


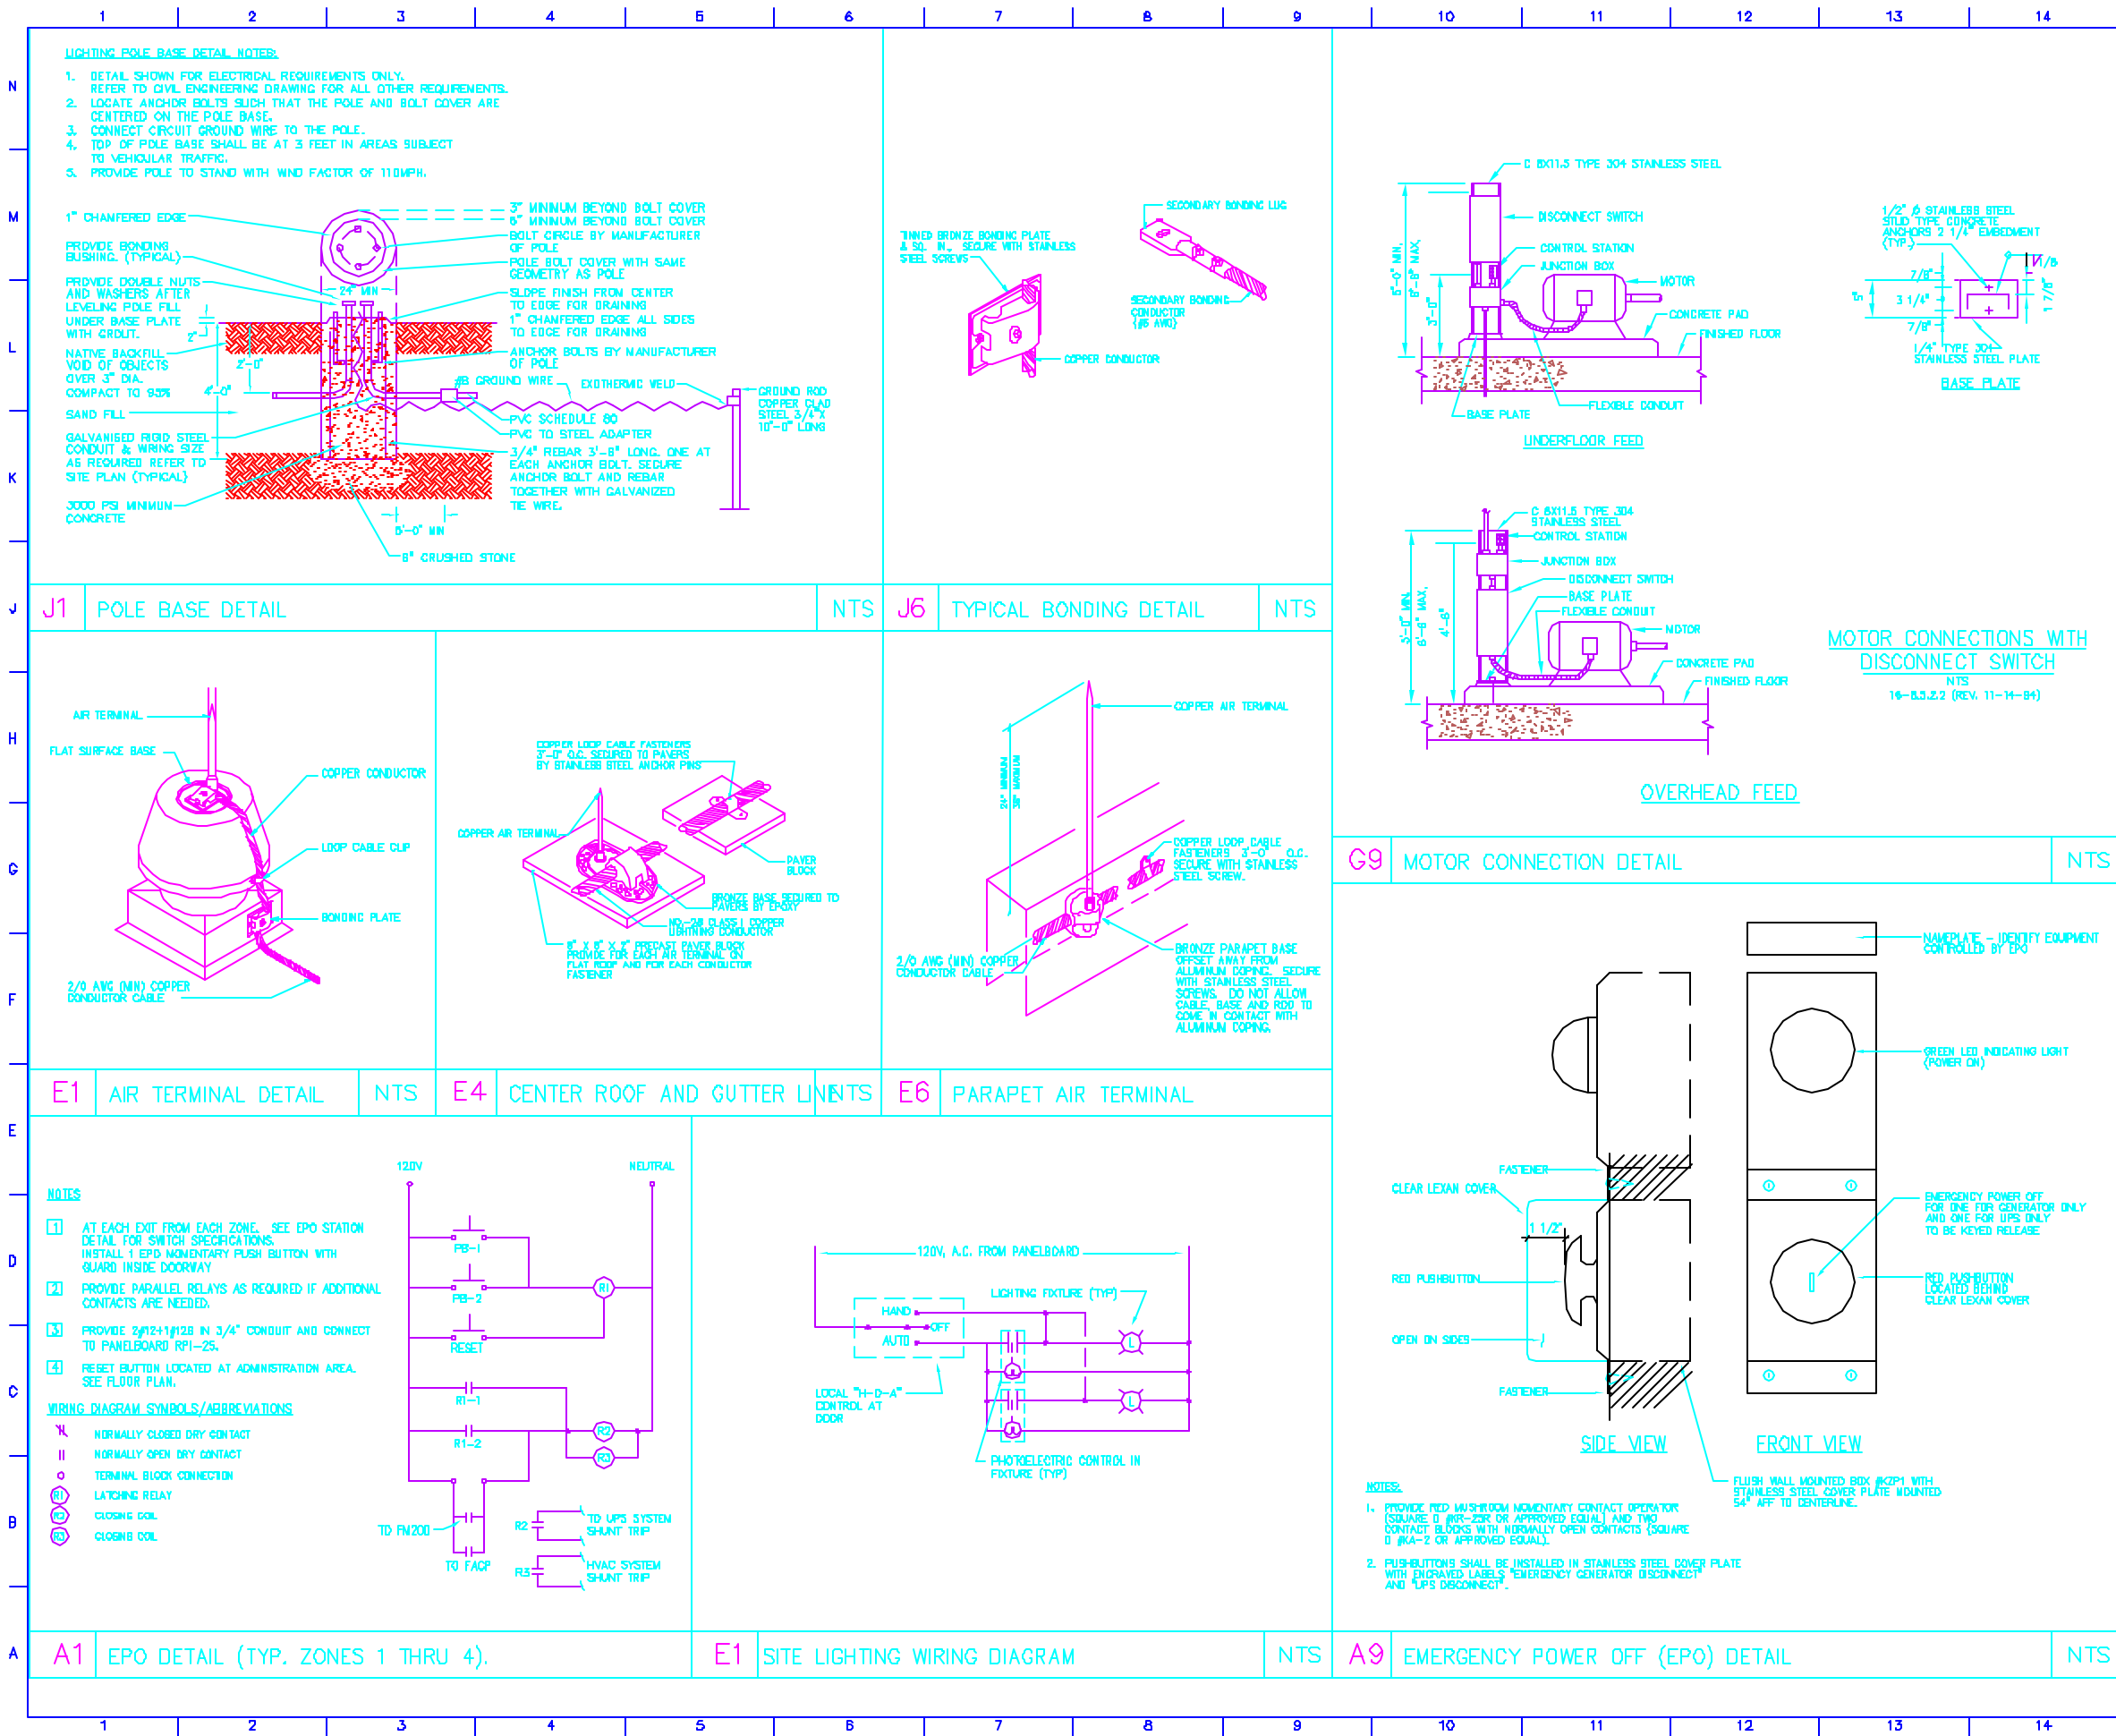

KEYED NOTES

GENERAL NOTES

1. FOR SYMBOLS AND GENERAL NOTES, SEE DWG E001

P:\2001\5501001.dwg\TWT\VRPaga.dwg

0	FOR CONSTRUCTION	7/13/01
no.	revisions/submissions	date

Einhorn Yaffee Prescott ARCHITECTURE & ENGINEERING, P.C.
THIRTY-FOUR BEECH STREET
PORTLAND, ME 04108
87.586-3865
ALBANY, NY
800 769-8776
NEW HAVEN, CT
NEW BRITAIN, CT

Commтел Data Center
380 Cumberland Avenue
Portland, Maine

drawing title	
ELECTRICAL DETAILS	
designed by	project no.
D.F.	5501001.00
drawn by	CAD file no.
I.D.	2001/ELEC/PLOT/CTL-E802
checked by	drawing no.
SA	E602
date	7/13/01
scale	AS NOTED