


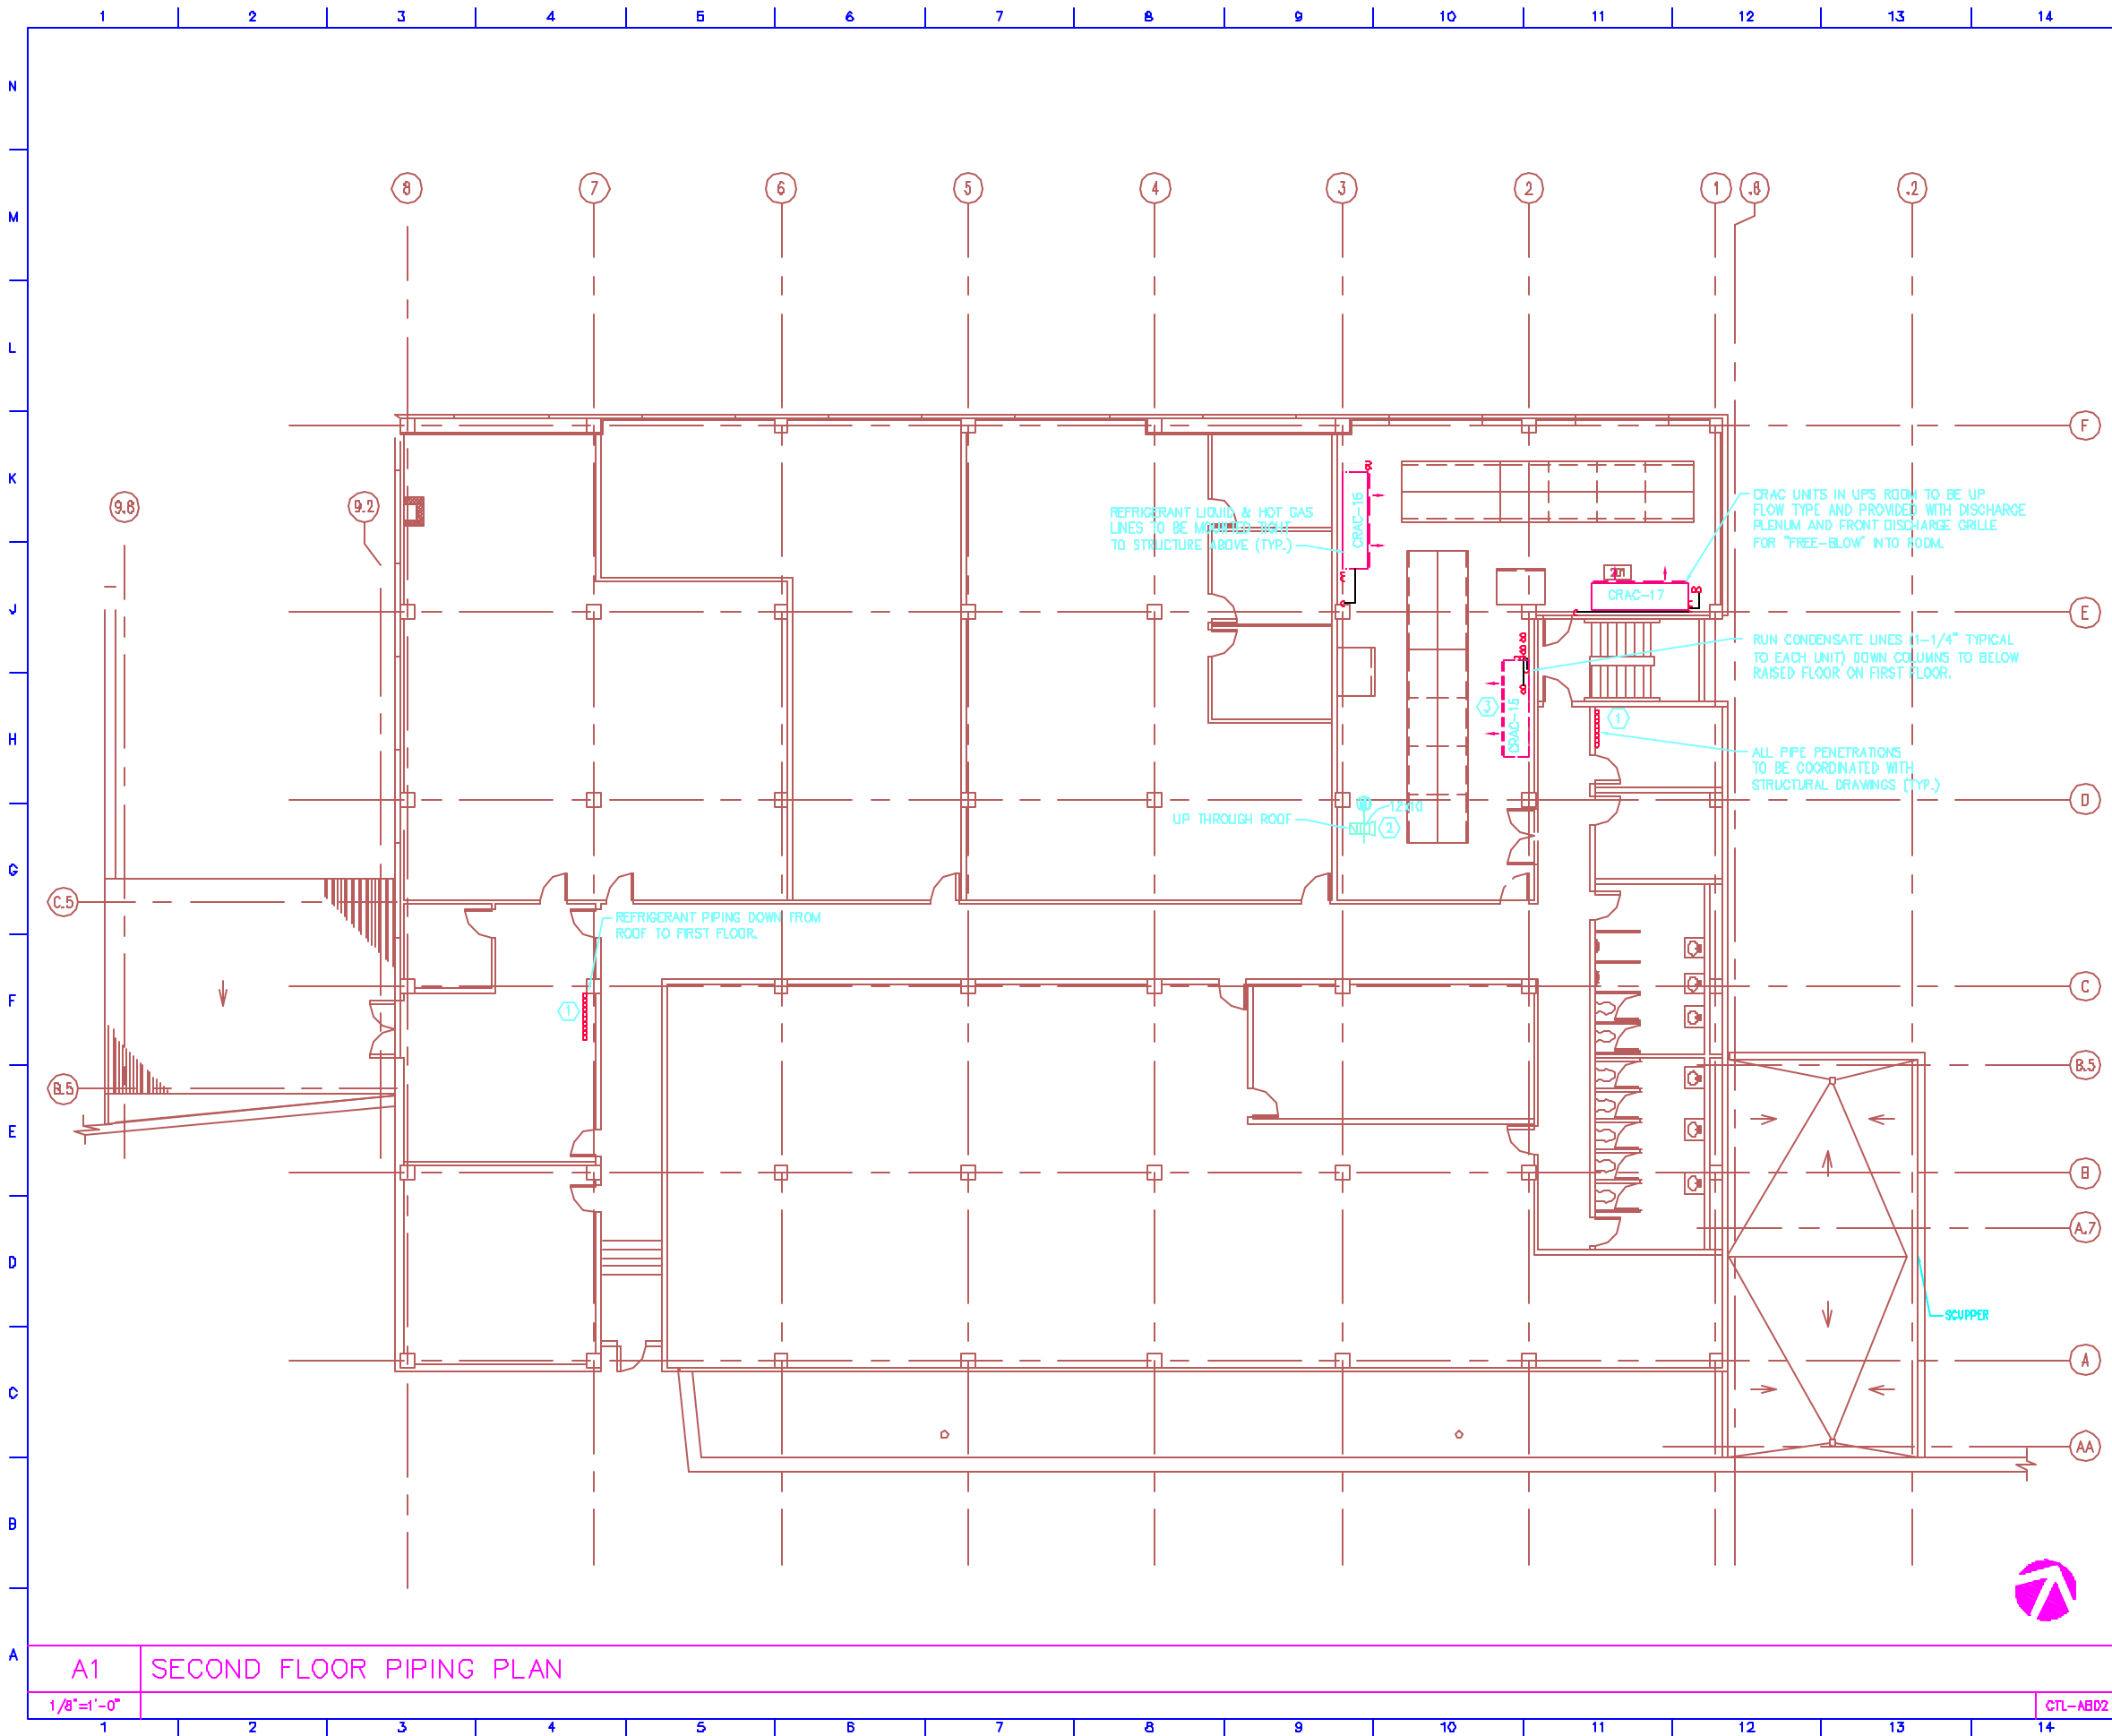

GENERAL NOTES

- 1 CORE-DRILL OPENING IN FLOOR SLAB FOR PIPE DROP TO FLOOR LEVEL BELDW. PROVIDE SLEEVE AND FIRE STOPPING. SLEEVE TO EXTEND 4 INCHES ABOVE FLOOR.
- 2 OPEN ENDED DUCT W/WINS.
- 3 FUTURE UNIT. REFRIGERANT PIPING SHALL BE INSTALLED AND CAPPED FOR FUTURE USE.

P:\2001\3501001\001\Task\HVAC.dwg

0	FOR CONSTRUCTION	7/13/01
no.	revisions/submissions	date



Einhorn
Yaffee
Prescott

ARCHITECTURE & ENGINEERING, P.C.

TWENTY-FOUR BECKLEY BLVD.
PORTLAND, ME 04106

87.586-3865

ALUMES: MR.
BOB TONG, P.E.
LOS ANGELES, CA

ENGINE PLANS BY
BIRMINGHAM, AL
BIRMINGHAM, AL

CommTel Data Center
380 Cumberland Avenue
Portland, Maine

drawing title
HVAC SECOND FLOOR
PIPING PLAN

designed by JML	project no. 5501001.00
drawn by JML	CAD file no. P:2000\5501001\HVAC
checked by WOK	drawing no. H202
date 07/13/01	scale 1/8"=1'-0"