


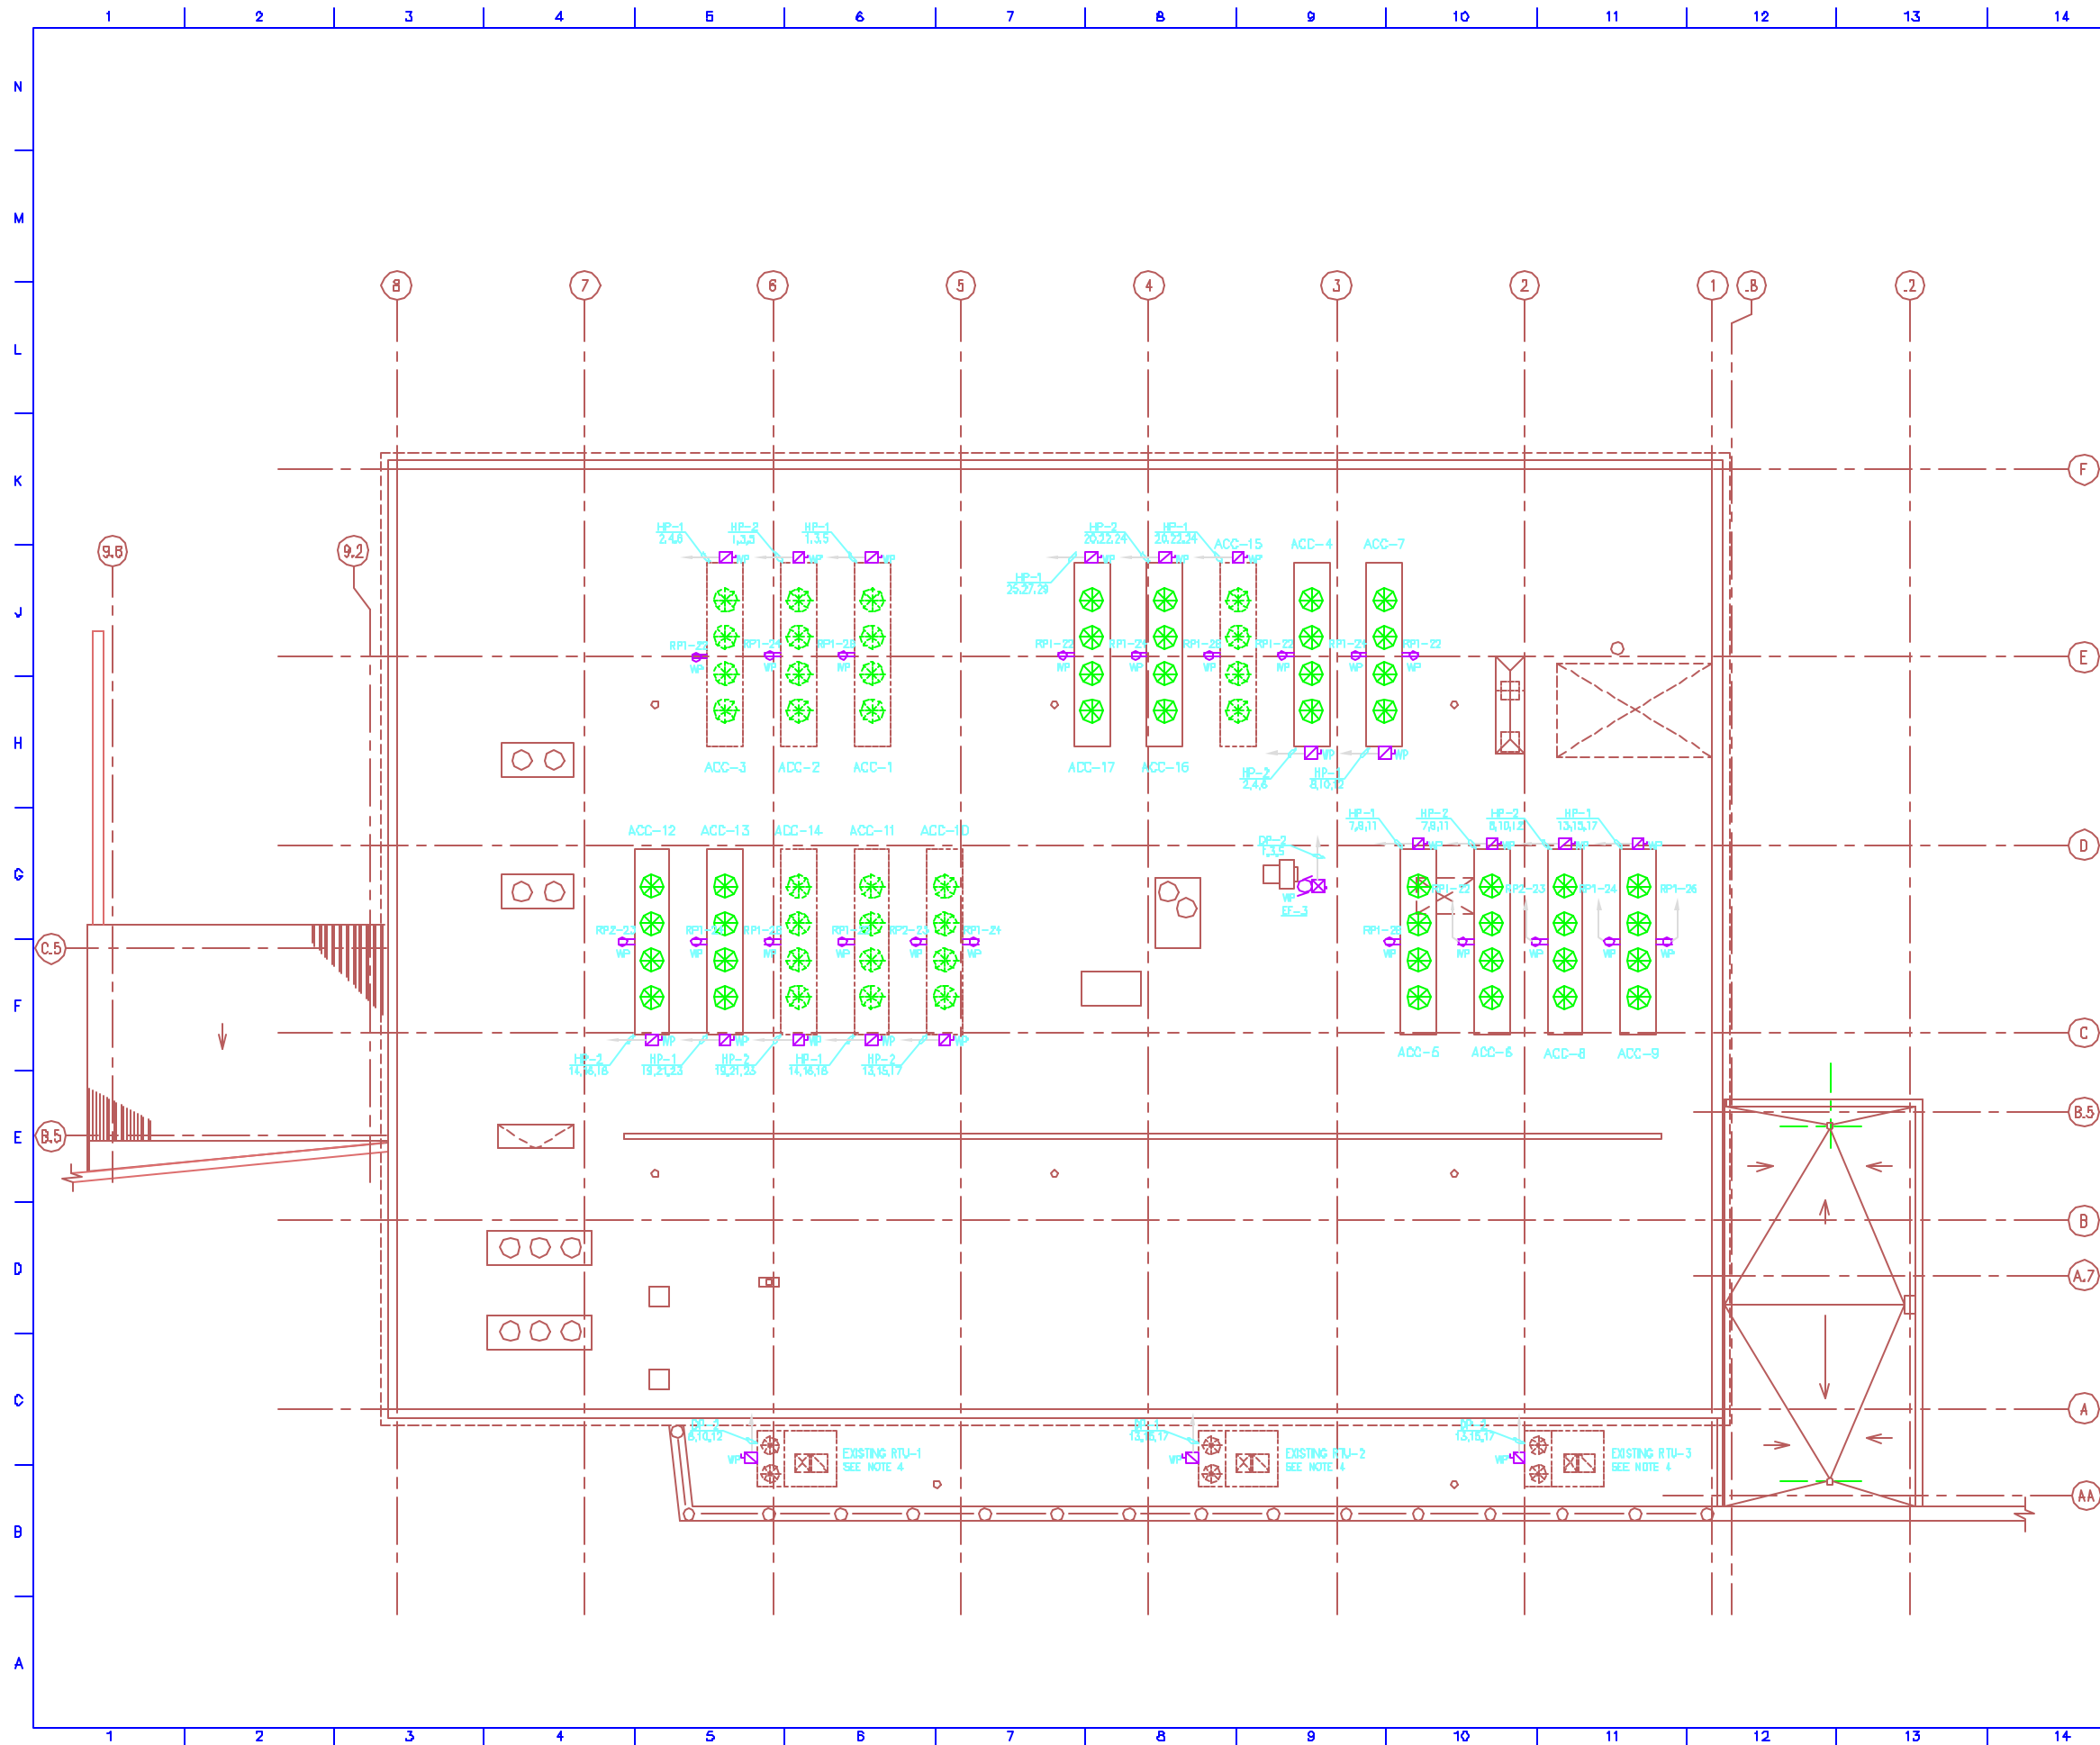

KEYED NOTES

GENERAL NOTES

1. FOR SYMBOLS AND GENERAL NOTES, SEE DWG E001
2. FOR PANELBOARD SCHEDULE, SEE DWG E501, E502, E503, E504
3. FOR CONDUIT AND WIRE SCHEDULE, SEE DRAWING E401 AND PANELBOARD SCHEDULE DWG E502, E503, E504
4. DISCONNECT POWER FEED TO EXISTING RTU'S AND PROVIDE POWER FROM NEW PANEL RP1 & DP2 AS SHOWN
5. ALL OUTSIDE RECEPTACLES TO BE FED THROUGH A 60 AMP RATED BREAKER
6. ALL PENETRATIONS SHOULD BE COORDINATED WITH STRUCTURAL DRAWINGS AND STRUCTURAL ENGINEER

P:\2001\5501001.00\T11\HRego.dwg

0	FOR CONSTRUCTION	7/13/01
no.	revisions/submissions	date



Einhorn
Yaffee
Prescott



ARCHITECTURE & ENGINEERING, P.C.
THIRTY-FOUR ROCKS BLVD
PORTLAND, ME 04106
87.586-3865
ALBANY, NY
NEW YORK, NY
LOS ANGELES, CA
BIRMINGHAM, AL
BOSTON, MA
CHICAGO, IL
DENVER, CO
HOUSTON, TX
SAN FRANCISCO, CA
WASHINGTON, DC

CommTel Data Center
380 Cumberland Avenue
Portland, Maine

drawing title
ROOF POWER PLAN

seal	designed by D.F.	project no. 5501001.00
	drawn by I.D.	CAD file no. 2001/5501001.00/ELEC/CTL-E203
	checked by SA	drawing no. E203
	date 7/13/01	
	scale 1/8"=1'-0"	of