


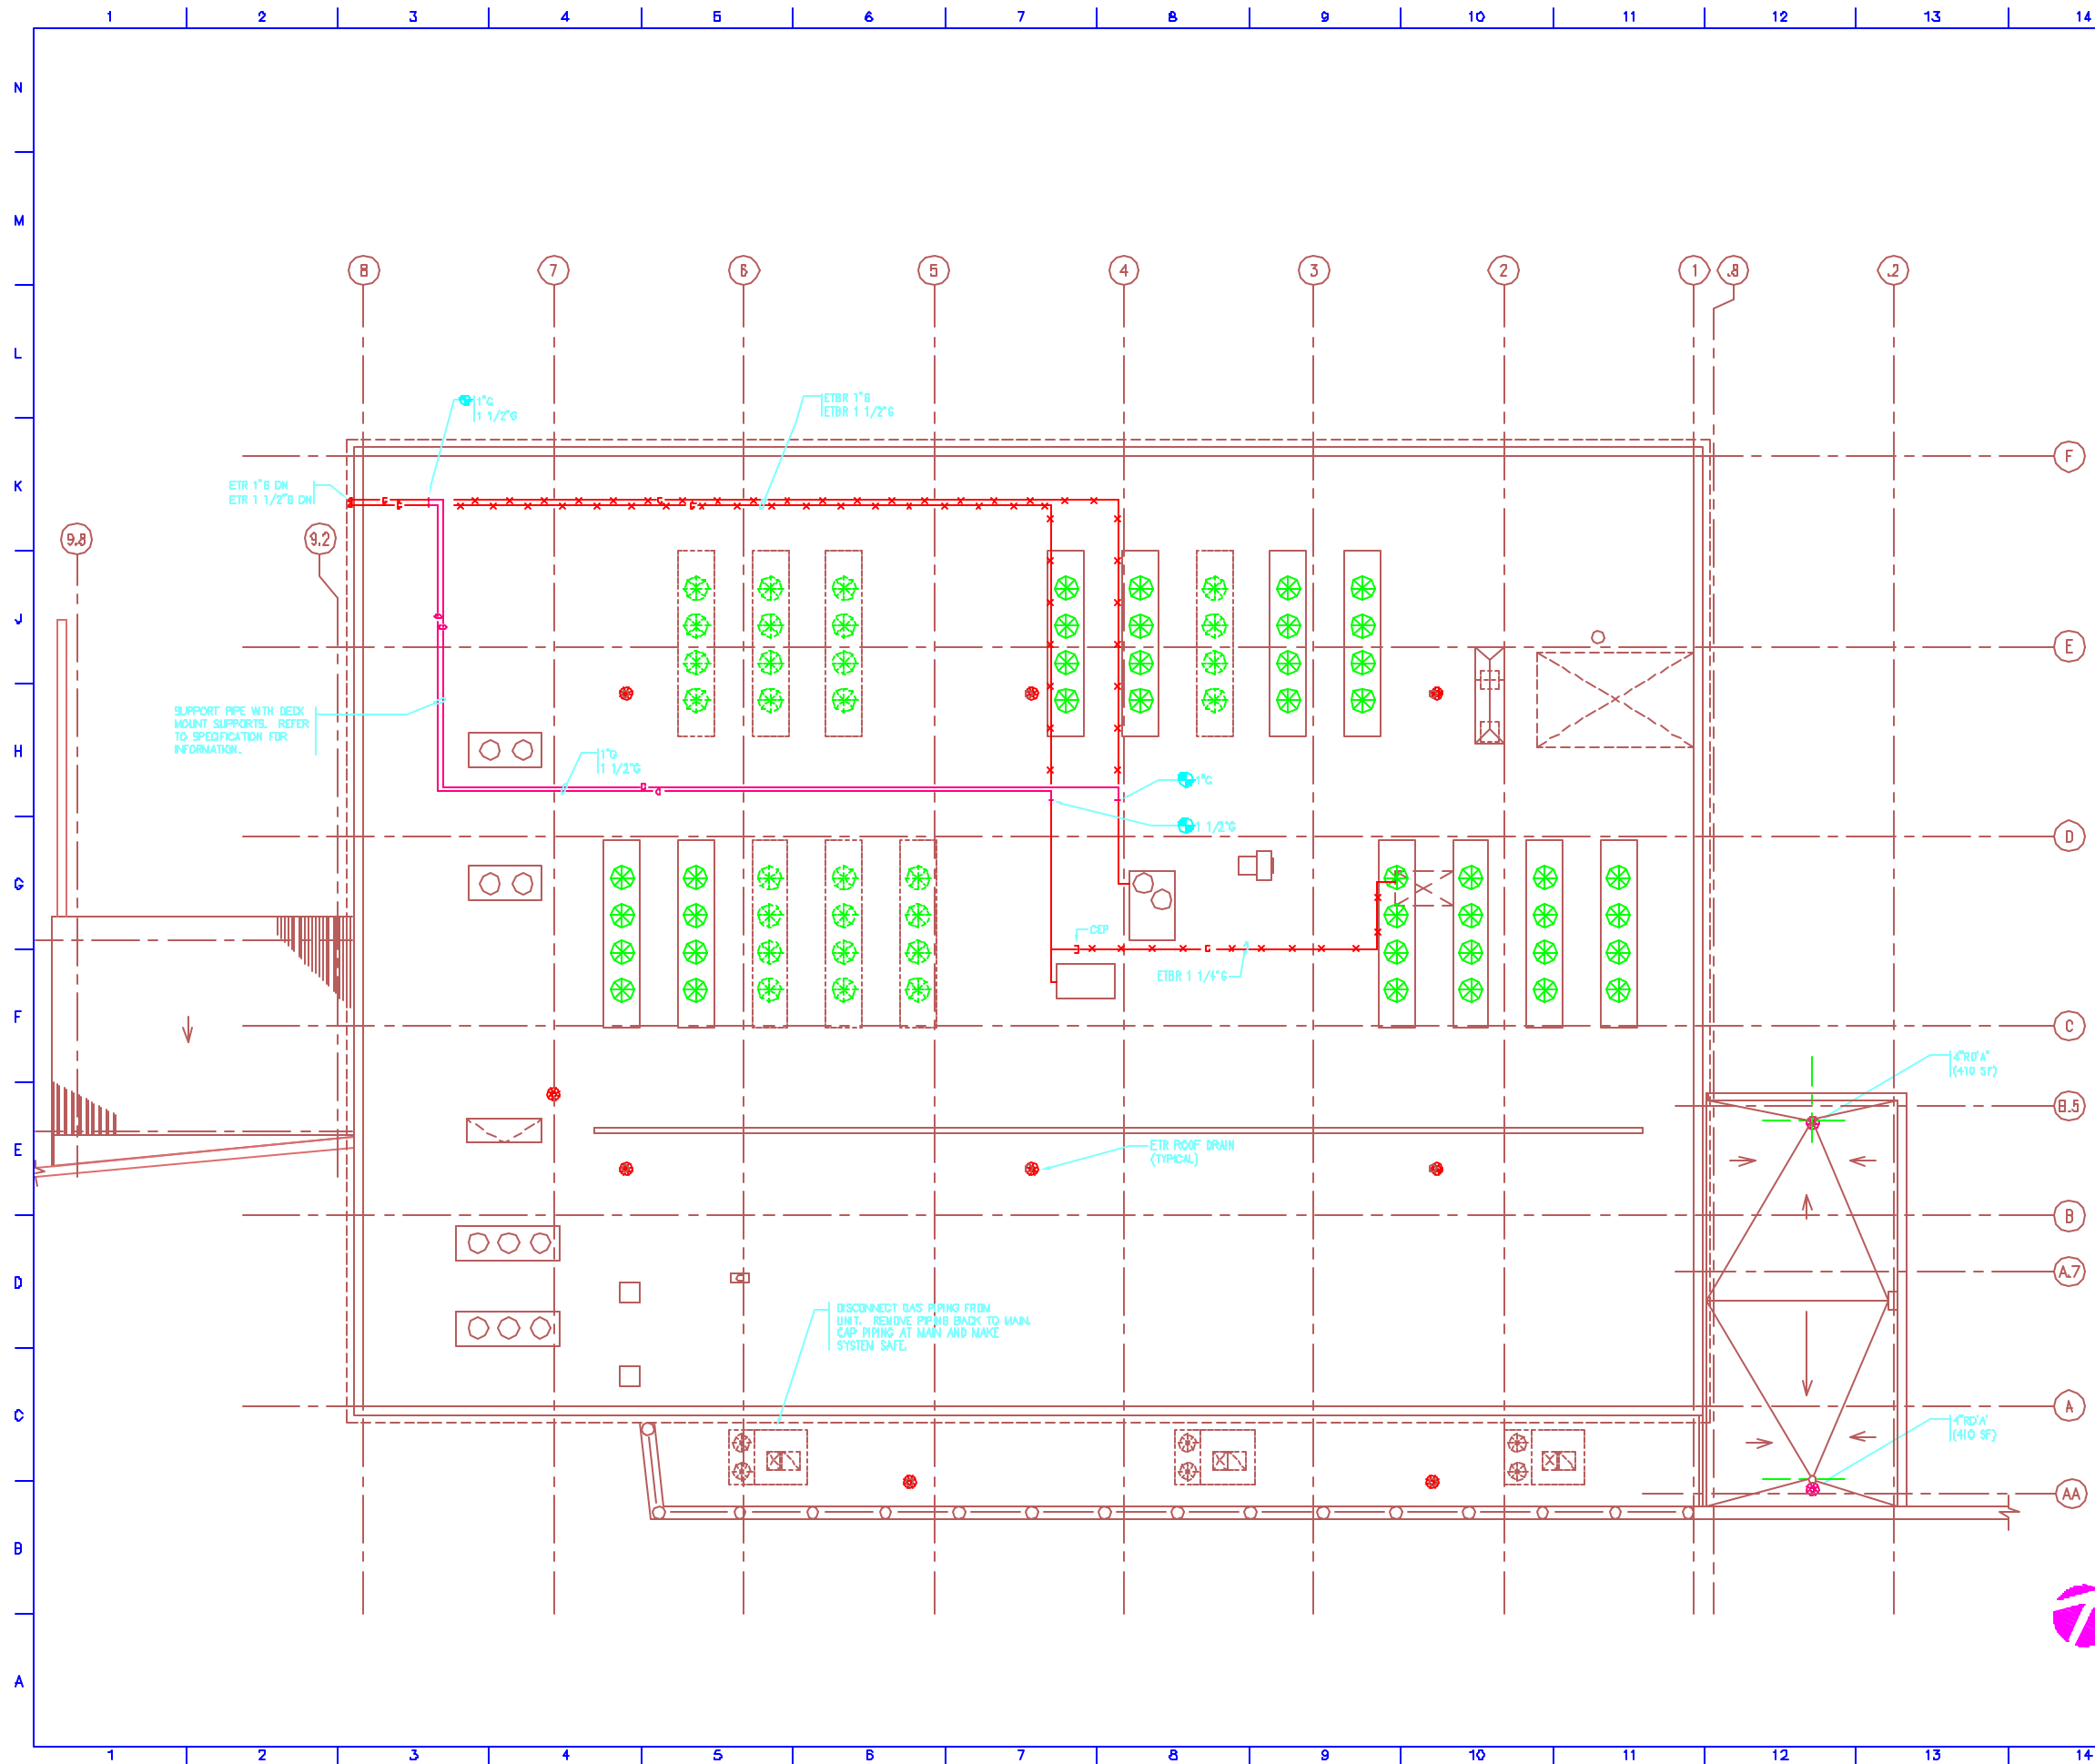

P:\2001\5501001.dwg\TitlePage.dwg

0	FOR CONSTRUCTION	7/13/01
no.	revisions/submissions	date

1" 2" 3"

Einhorn
Yaffee
Prescott

ARCHITECTURE & ENGINEERING, P.C.
THIRTY-FOUR BEECH STREET
PORTLAND, ME 04103
TEL: 603-866-1111
FAX: 603-866-1112
WWW.EINHOINRYAFFEEPRESOTT.COM

CommTel Data Center
380 Cumberland Avenue
Portland, Maine

drawing title
PLUMBING ROOF PLAN

seal	designed by JPP	project no. 5501001.00
	drawn by JPP	CAD file no. P:\2001\5501001\PLBG\PL01
	checked by DFR	drawing no. P103
	date 7/13/01	
	scale 1/8"=1'-0"	of