
 


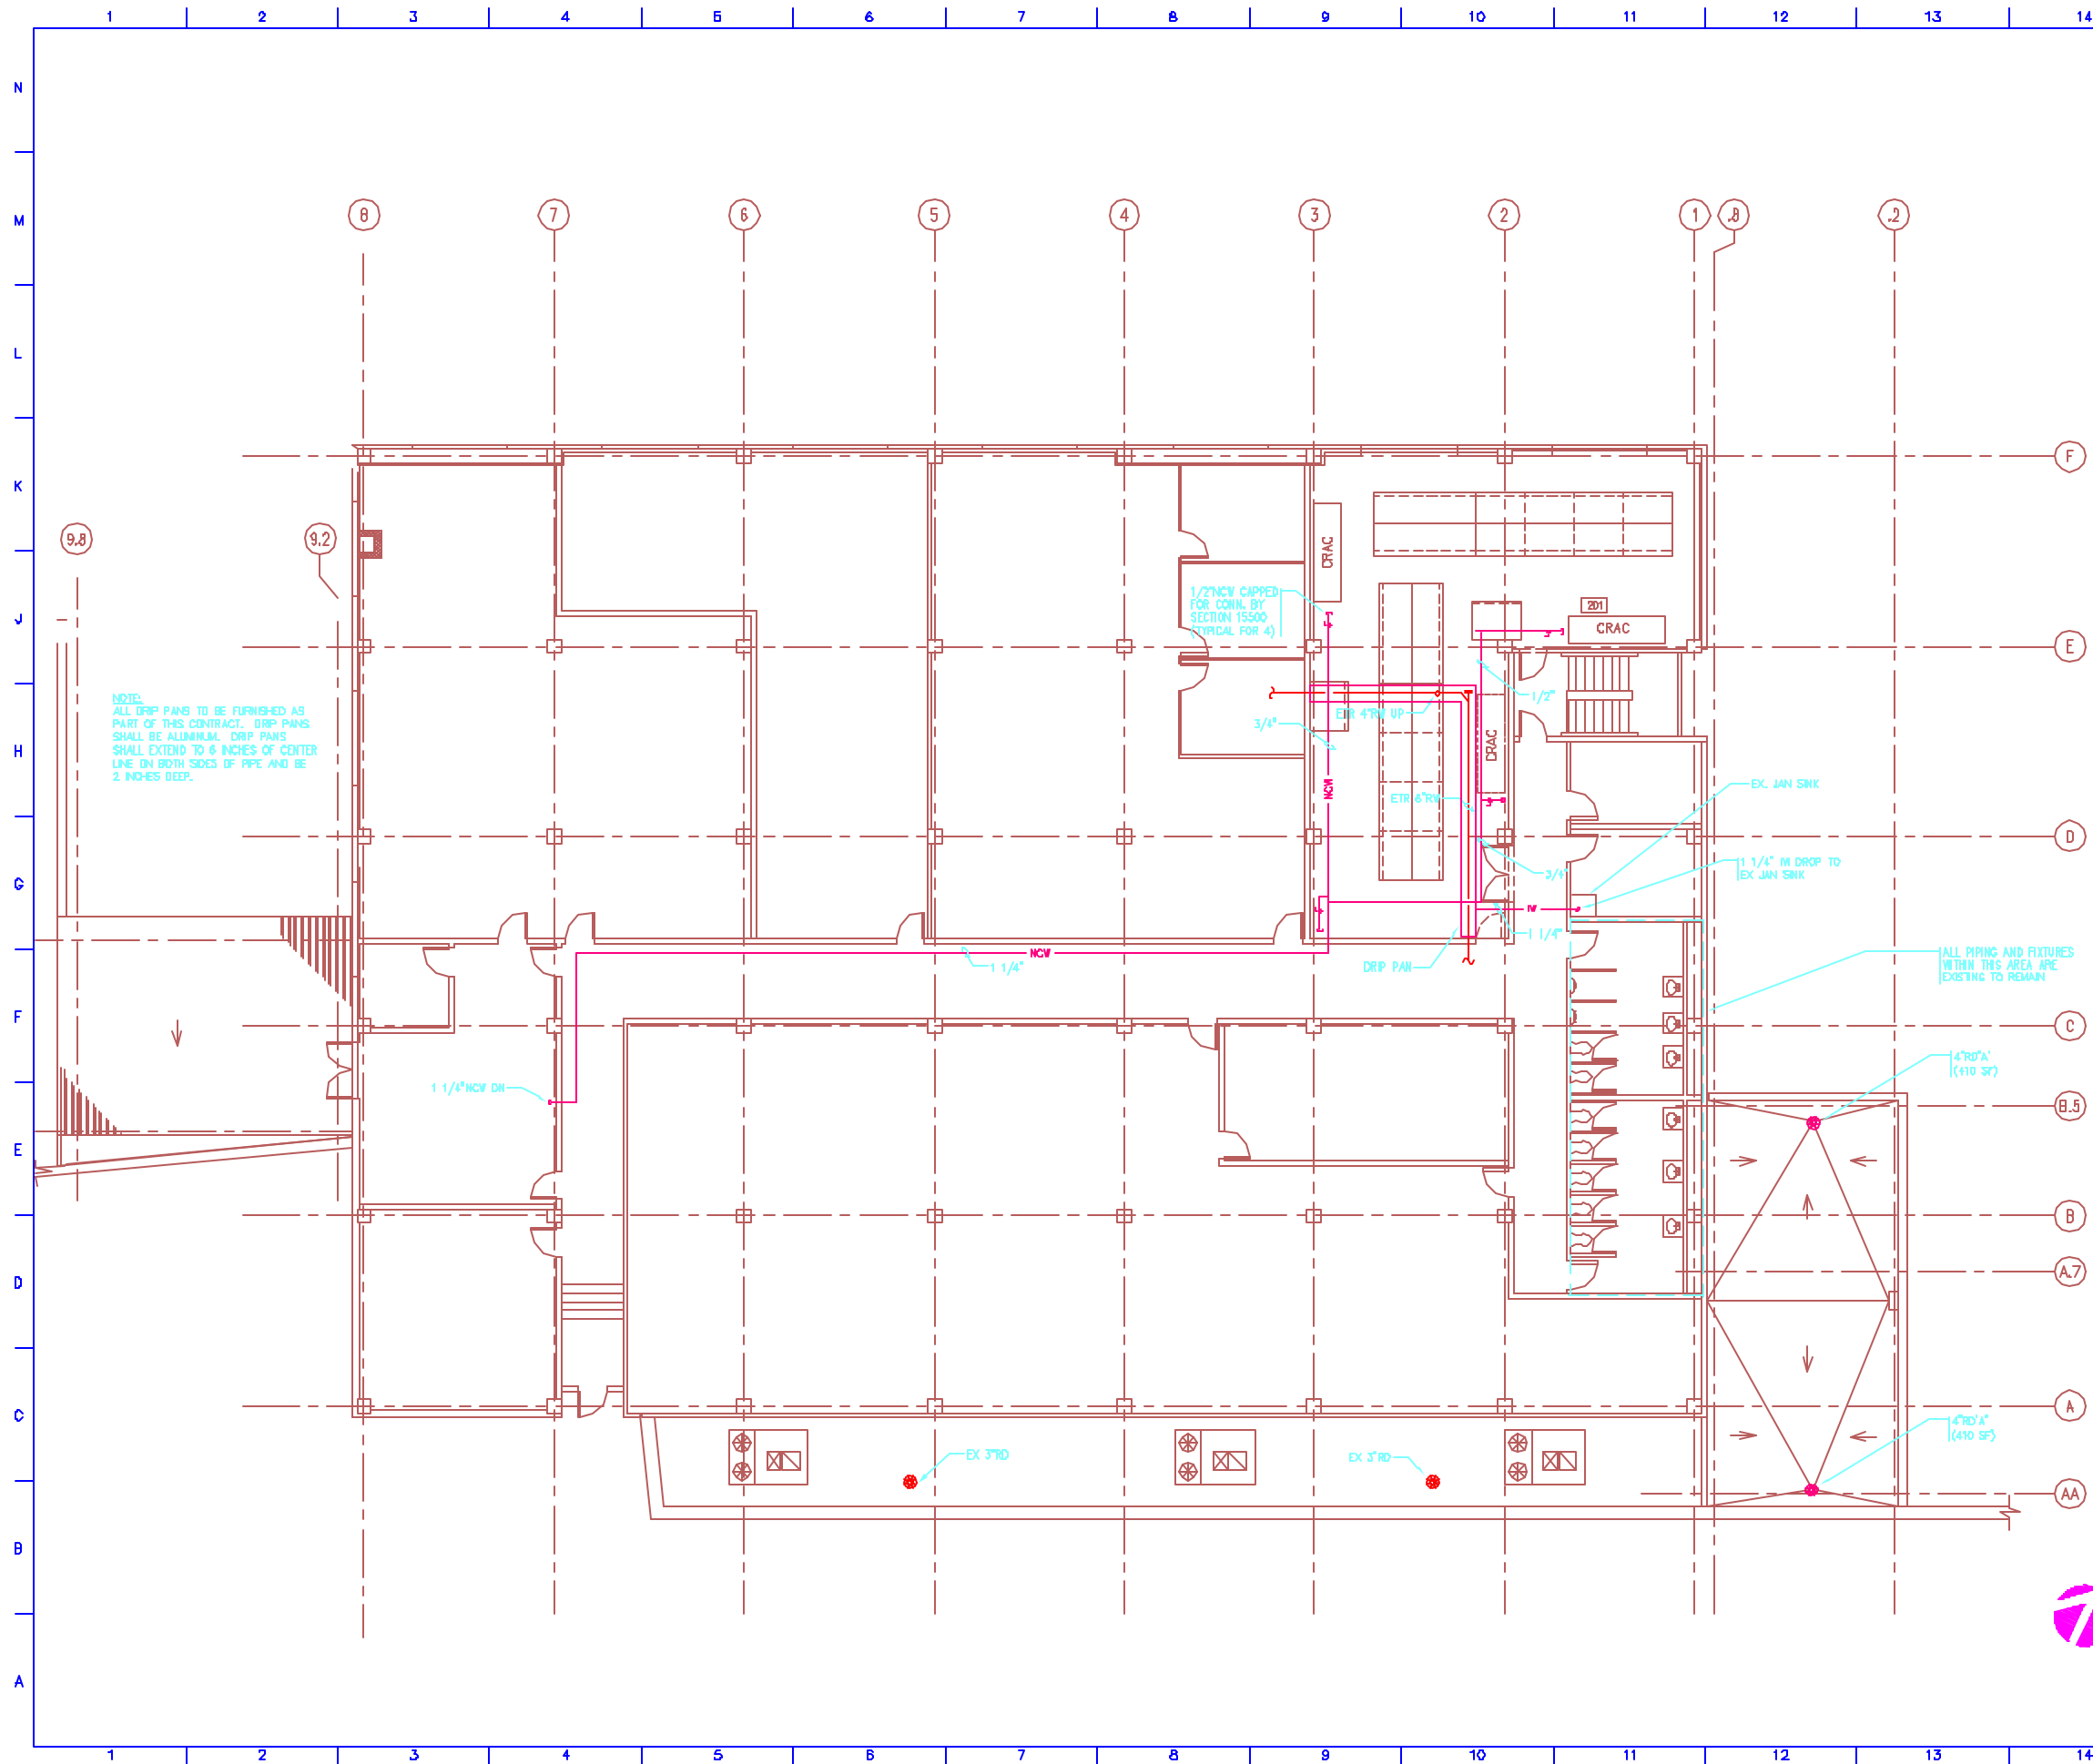

P:\2001\5501001.00\TW1\4848a.dwg

0	FOR CONSTRUCTION	7/13/01
no.	revisions/submissions	date



Einhorn Yaffee Prescott		ARCHITECTURE & ENGINEERING, P.C.	
		TWENTY-FOUR BUCKLE STREET PORTLAND, ME 04106	87.586-3865
		ALBANY, NY NEW YORK, NY LOS ANGELES, CA	BRIDGE PLAINS, FL BIRMINGHAM, AL DENVER, CO

Commтел Data Center
380 Cumberland Avenue
Portland, Maine

drawing title
PLUMBING SECOND FLOOR
PIPING PLAN

seal	designed by JPP	project no. 5501001.00
	drawn by JPP	CAD file no. P:\2001\5501001\PLBG\PILOT
	checked by DFR	drawing no. P102
	date 7/13/01	
	scale 1/8"=1'-0"	