
 


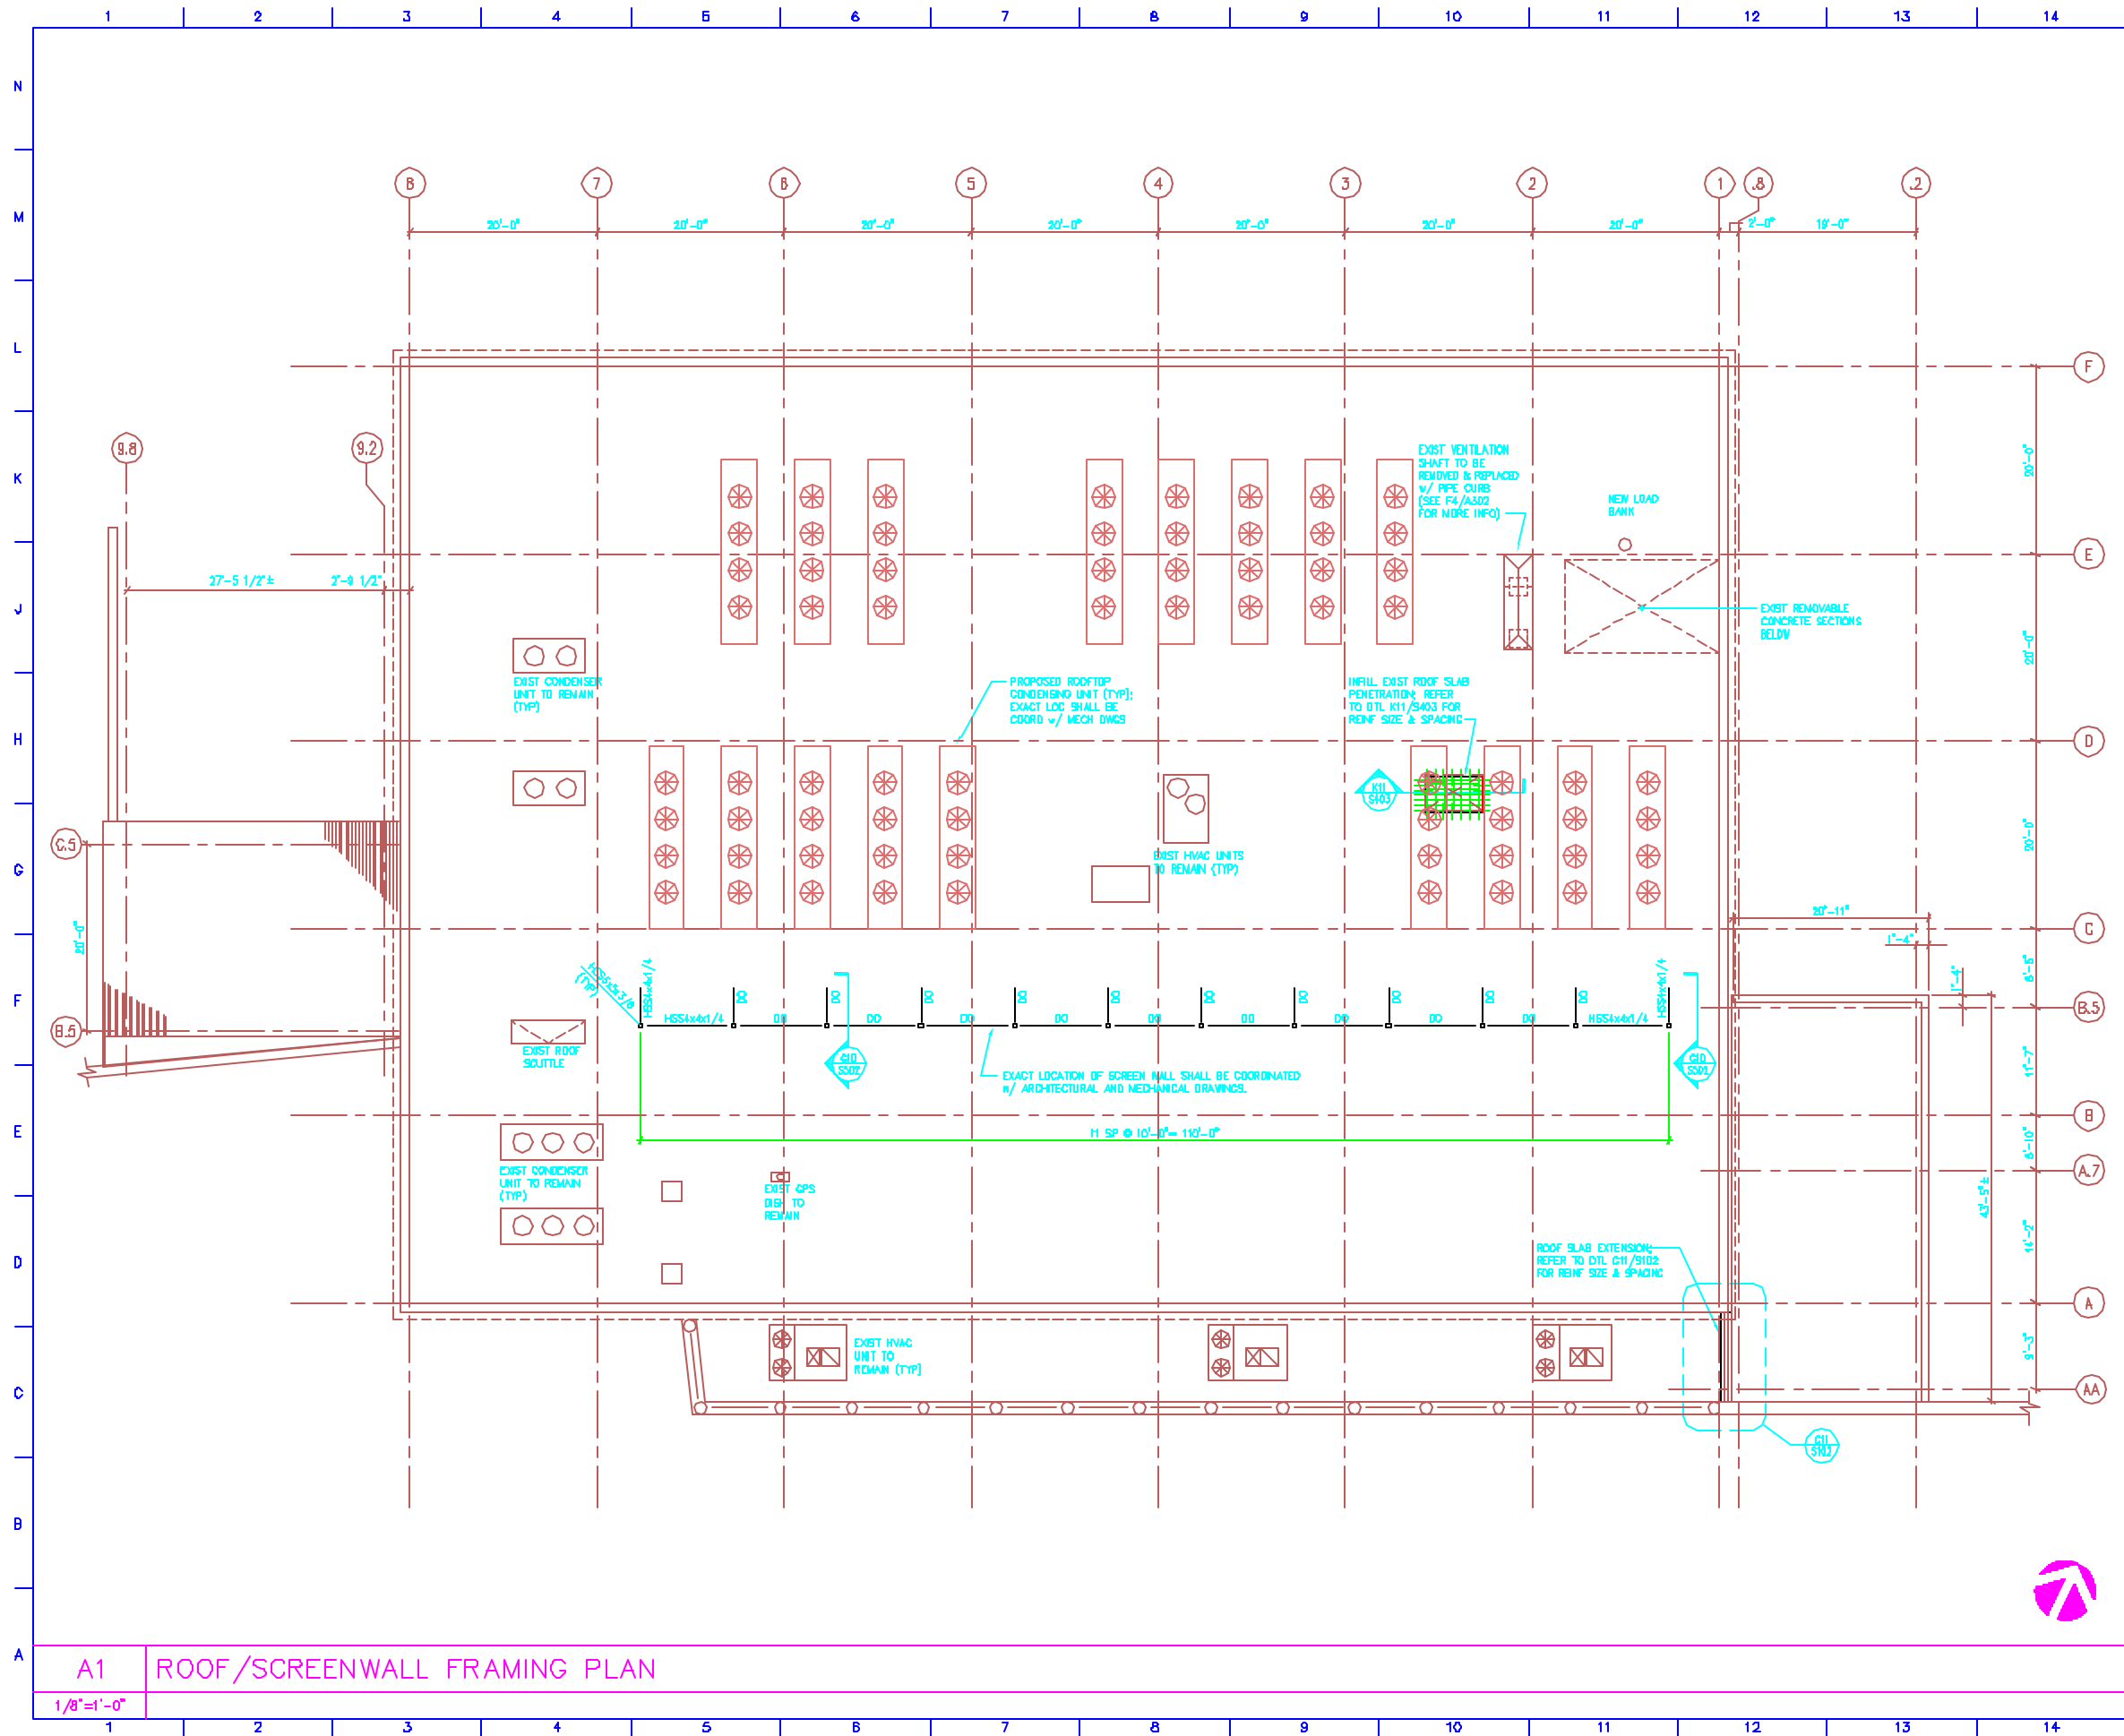

P:\2001\3501001.00\Title\Framing.dwg

no.	revisions/submissions	date
0	FOR CONSTRUCTION	7/13/01



Einhorn
Yaffee
Prescott

ARCHITECTURE & ENGINEERING, P.C.

TWENTY-FOUR BECKA STREET
PORTLAND, ME 04106 87.586-3865

ALBANY, NY
BOX 1090, R.F.
LEWISVILLE, OH

BRIDGE PLANS, BY
BIRMINGHAM, AL
BRIDGE, VA

CommTel Data Center
380 Cumberland Avenue
Portland, Maine

drawing title

ROOF/SCREEN WALL FRAMING PLAN

seal	designed by IF	project no. 5601001.00
	drawn by RT	CAD file no. CTL-S203.DWG
	checked by SB	drawing no. S203
	date 07/13/01	
	scale 1/8" = 1'-0"	of