



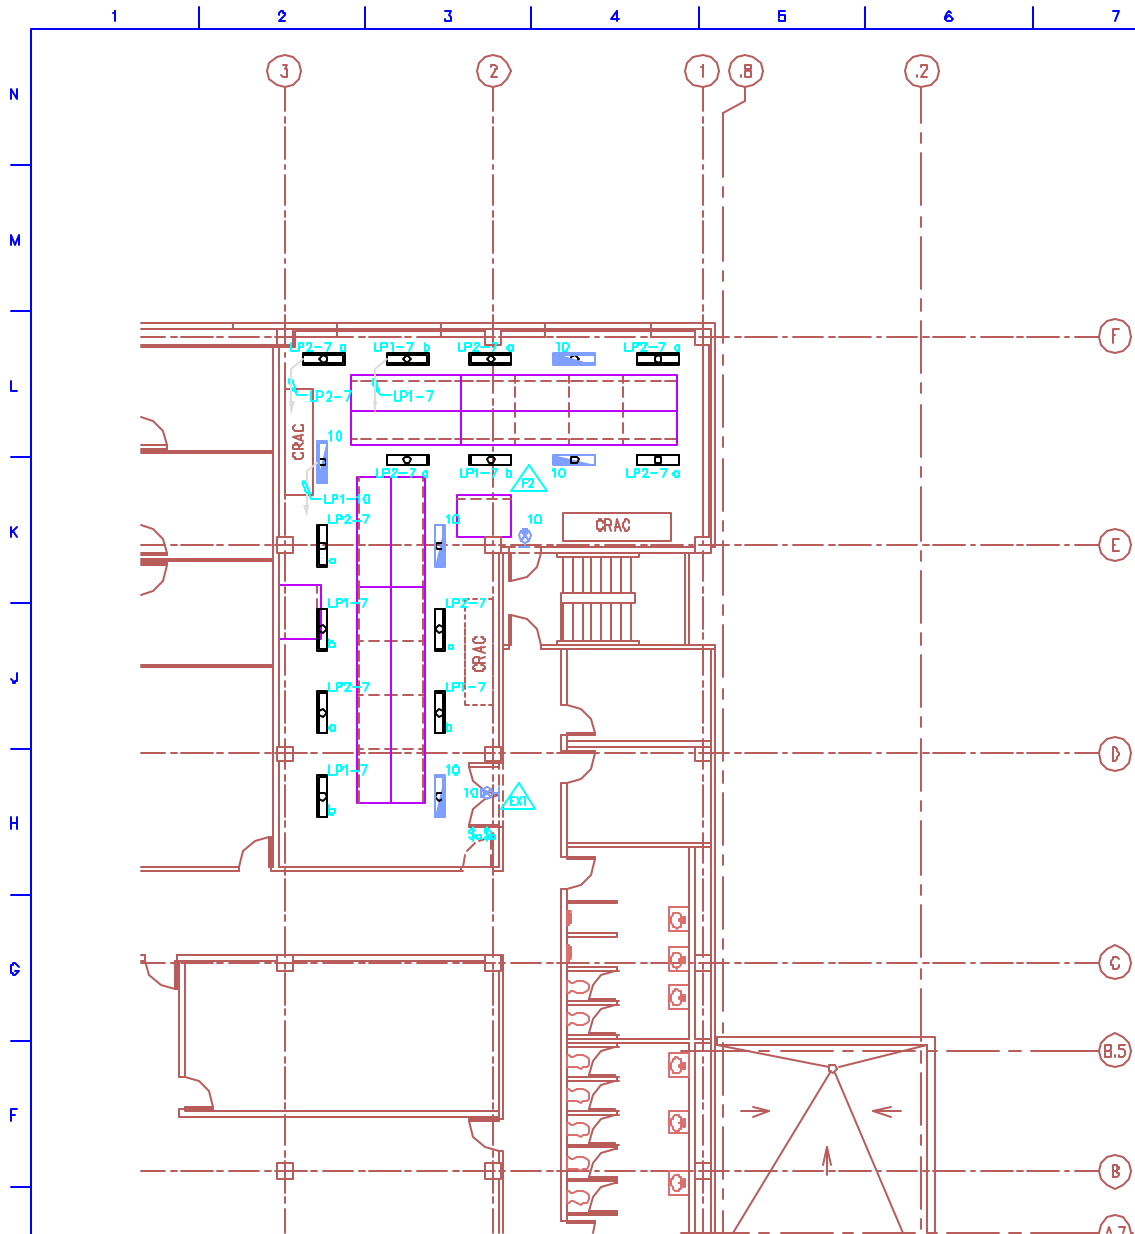

E1	SECOND FLOOR LIGHTING PART PLAN	FILENAME:
1/8"=1'-0"		

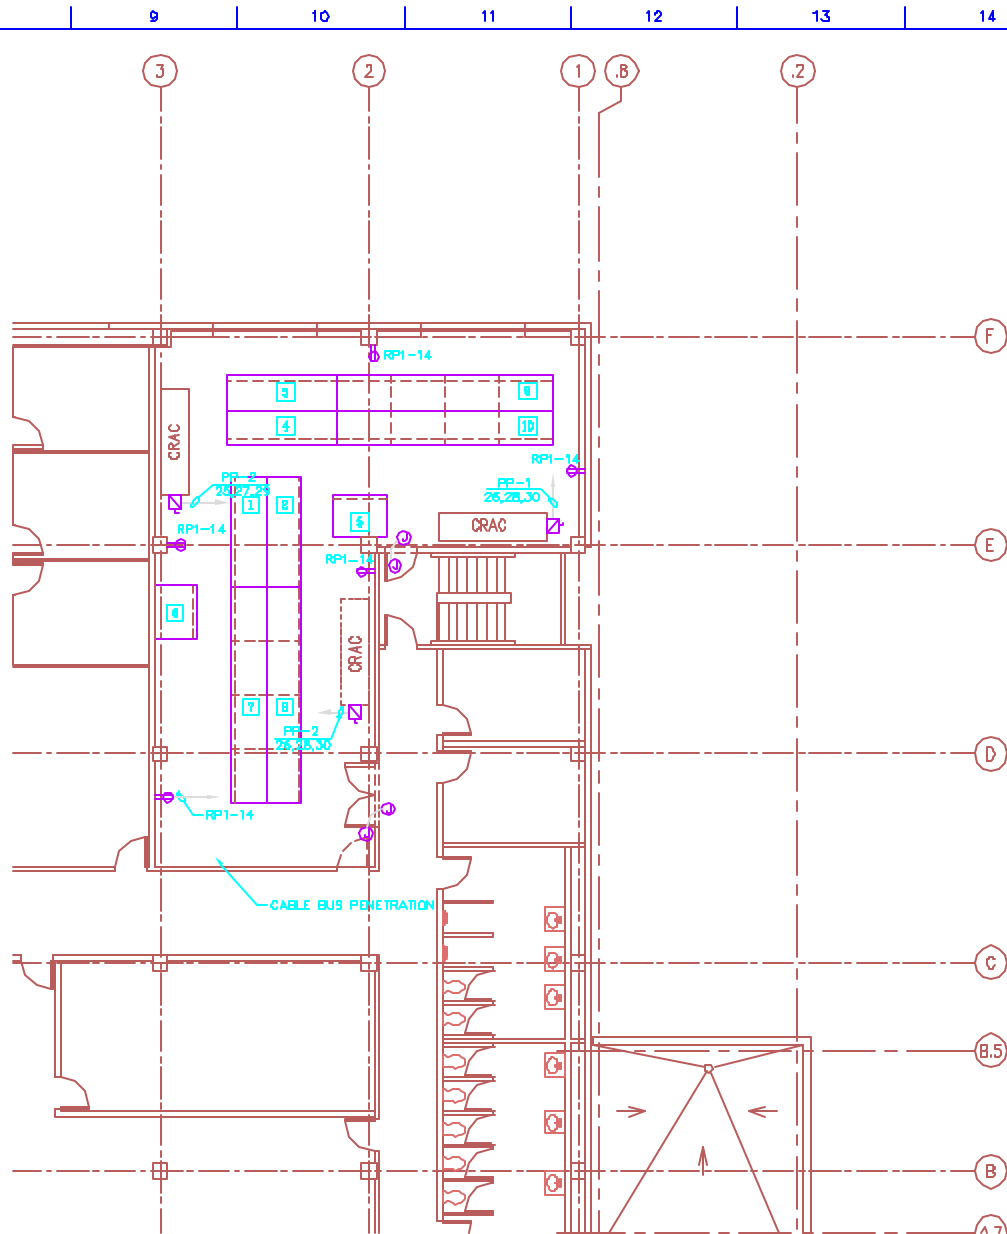

E9	SECOND FLOOR POWER PART PLAN	FILENAME:
1/8"=1'-0"		

KEYED NOTES

- 1 025KVA UPS MODULE
- 2 025KVA UPS MODULE
- 3 025KVA UPS MODULE
- 4 025KVA UPS MODULE
- 5 UPS PARALLELING SWGR #1
- 6 UPS PARALLELING SWGR #2
- 7 BATT. CABINET 1
- 8 BATT. CABINET 2
- 9 BATT. CABINET 3
- 10 BATT. CABINET 4

GENERAL NOTES

1. FOR SYMBOLS AND GENERAL NOTES, SEE DWG E001
2. FOR PANELBOARD SCHEDULE, SEE DWG E501, E502, AND E503
3. ALL PENETRATIONS SHOULD BE COORDINATED WITH STRUCTURAL DRAWINGS AND STRUCTURAL ENGINEER.
4. ALL WIRING BETWEEN BATTERY UPS-PDU'S SHALL BE PROVIDED BY THE ELECTRICAL CONTRACTOR.
5. ALL WIRING BETWEEN PDU AND RACKS BY ELECTRICAL CONTRACTOR.
6. EQUIPMENT SHOWN LIGHT AND DASHED IS FUTURE.

P:\2001\5501001.00\T11\149400.gif

FOR CONSTRUCTION		7/13/01
no. revisions/submissions		date
ARCHITECTURE & ENGINEERING, P.C.		
THIRTY-FOUR BECKA STREET PORTLAND, ME 04106 87.586-3865		
ALBANY, NY 800.760.8775 1000 AMHERST, CT		
BRIAN PLANN, BY BIRMINGHAM, AL 800.760.8775		
Commтел Data Center 380 Cumberland Avenue Portland, Maine		
drawing title		
SECOND FLOOR PART PLAN		
seal	designed by D.F.	project no. 5501001.00
	drawn by I.D.	CAD file no. 2001/5501001.00/ELEC/CTL-E202
	checked by SA	drawing no. E202
	date 7/13/01	
	scale 1/8"=1'-0"	