


FOURTH FLOOR REFLECTED CEILING PLAN  
SCALE: 1/8" = 1'-0"

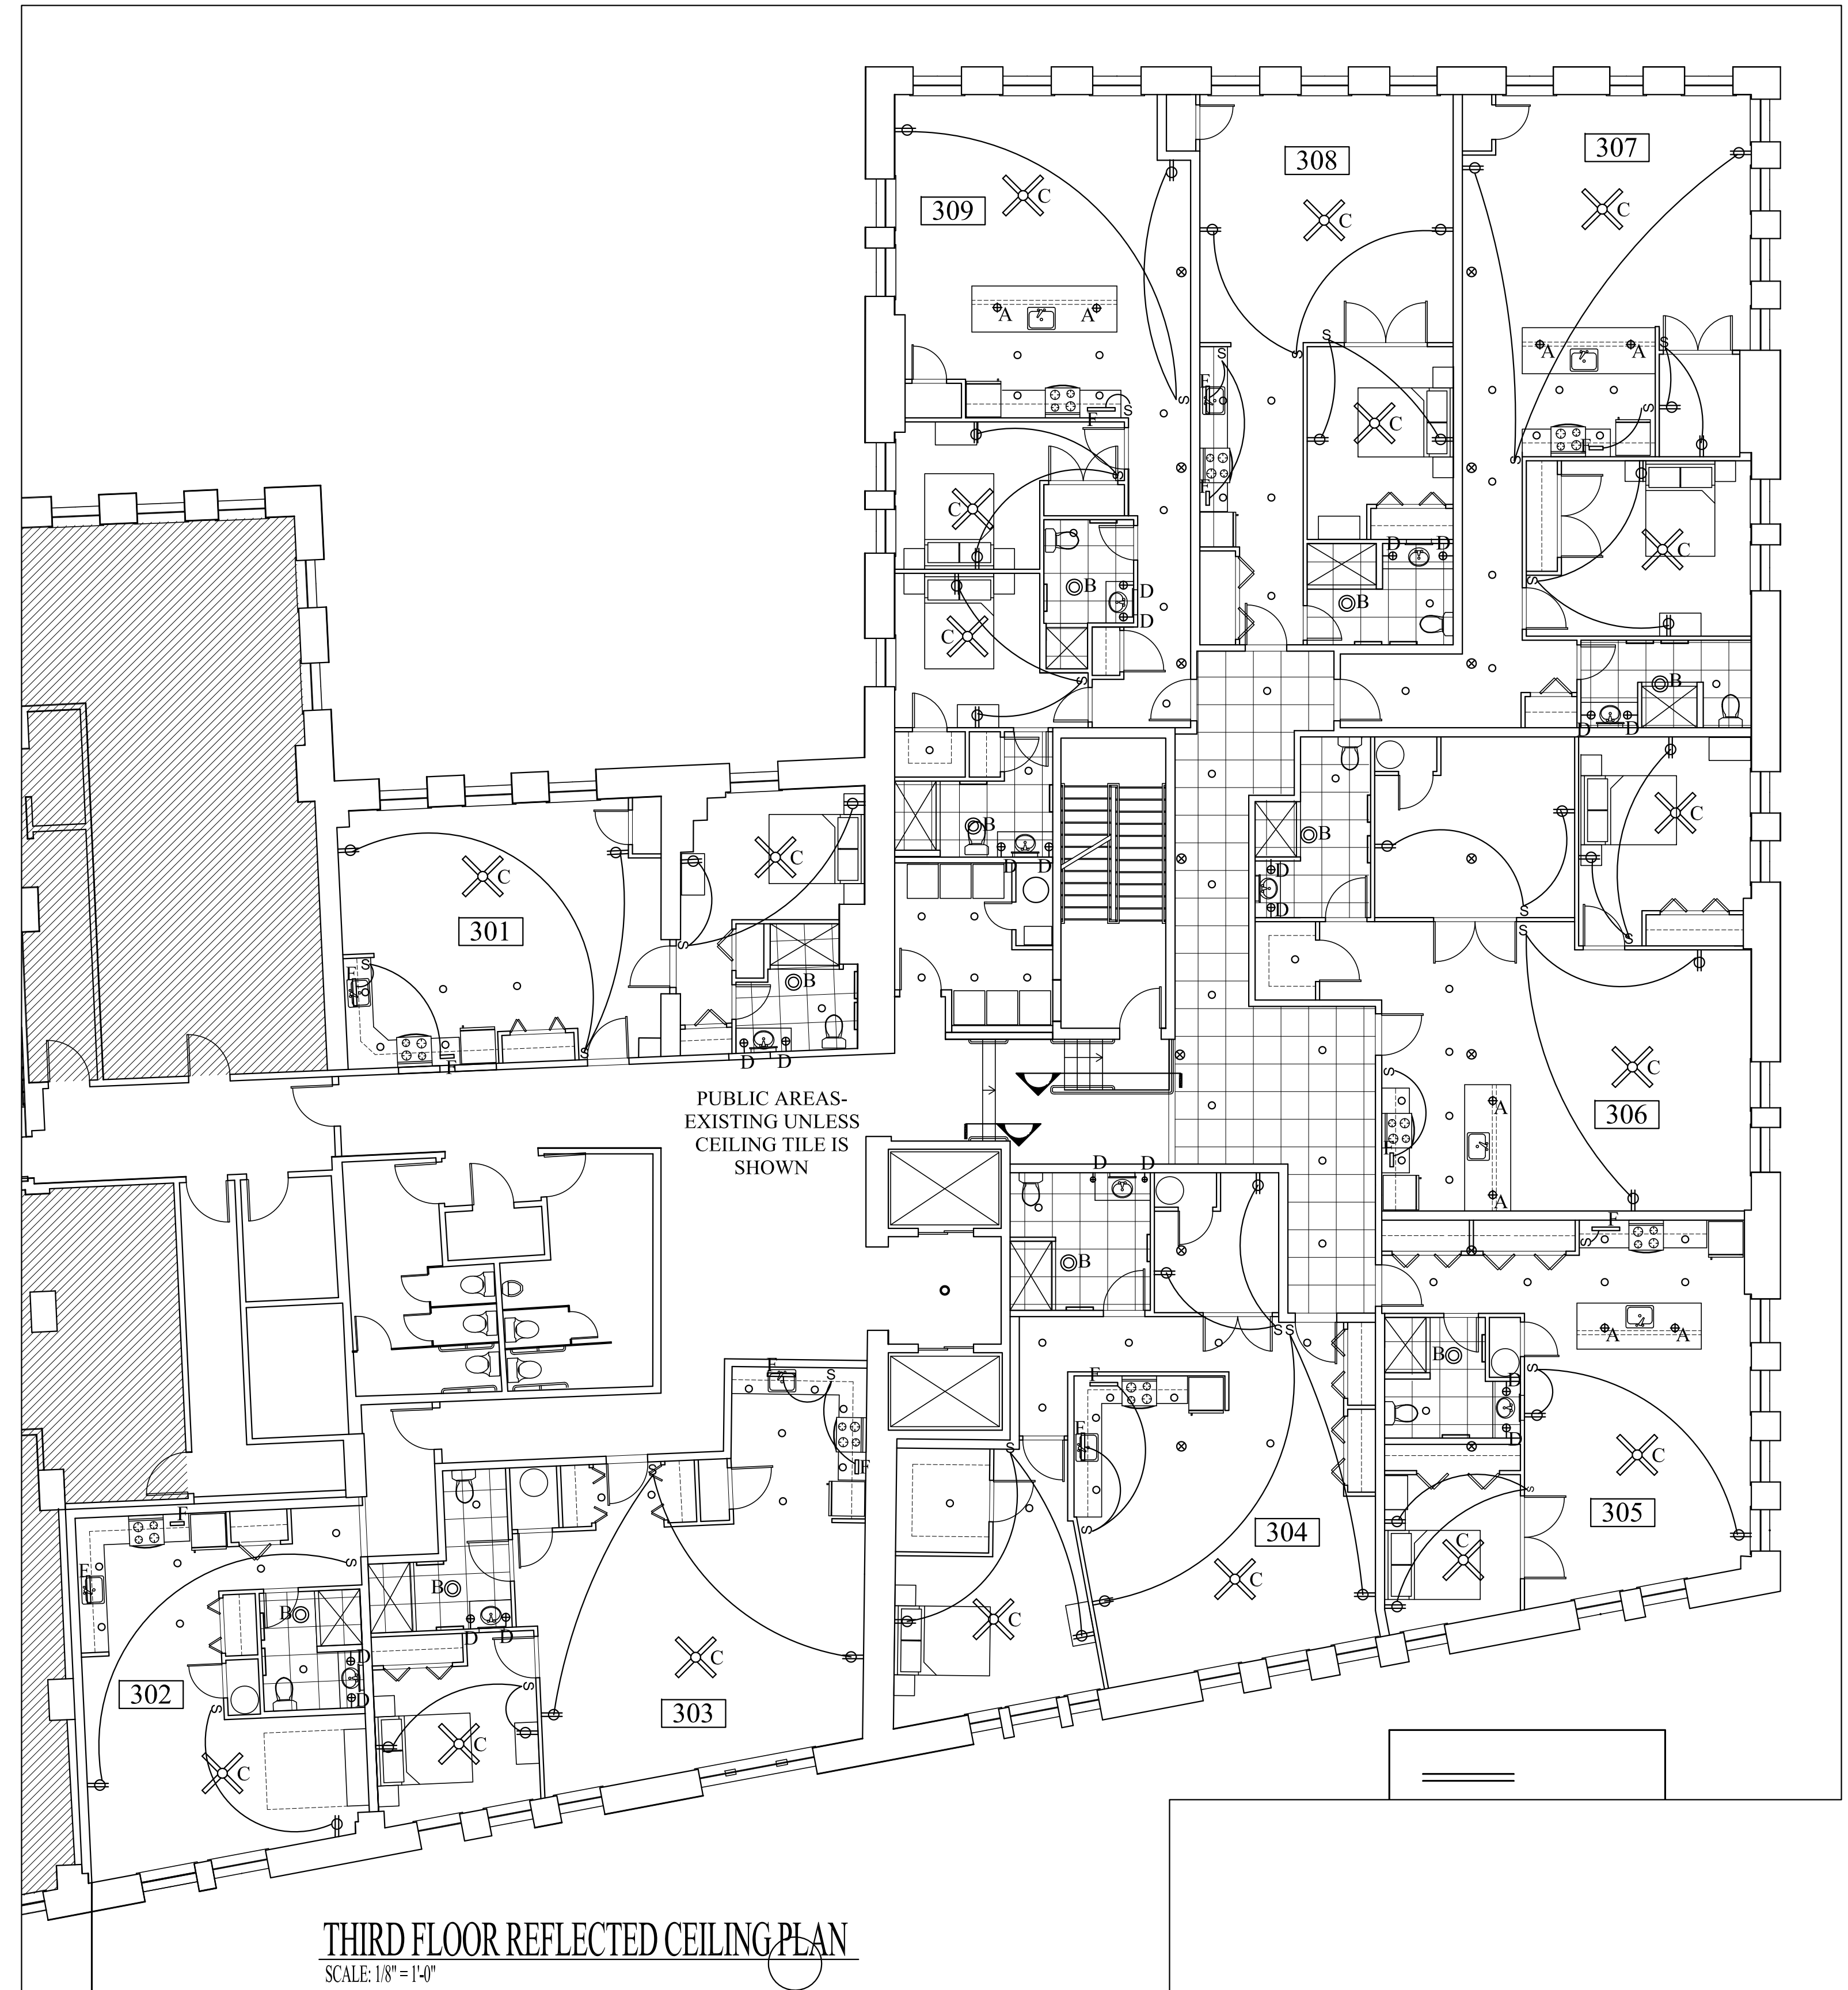

THIRD FLOOR REFLECTED CEILING PLAN  
SCALE: 1/8" = 1'-0"

**\* LIGHTING SCHEDULE \***

TAG	ITEM	MANUFACTURER	MODEL	FINISH
A	Pendant	Forecast Lighting	F5104-70	Merlot Bronze
	Pendant Shade	Forecast Lighting	F5184 Cork Over Clear Glass	Cork
B	Bathroom Fan	Air King	AK864L Exhaust Fan with Light	White
C	Ceiling Fan	Modern Fan	Gusto #GUS-BN-46-NK-NL-001	Bright Nickel
D	Sconce	Forecast Lighting	F4505-36 NV	Satin Nickel/White
E	Recessed Can	NA	Dimming 5" Recessed Aluminum Fixture with white trim kit	White
F	Under Cabinet			

NOTE: Provide switches and outlets per code- switches shown in addition to code requirements

Owner:

Consulting Engineer:

**ARCHETYPE**  
architects  
48 Union Wharf Portland, Maine 04101  
(207) 772-6022 Fax (207) 772-4056

Architect:

**J.B. BROWN BUILDING**  
537 CONGRESS STREET  
PORTLAND, ME

Project:

Revisions:

Scale: 1/8" = 1'-0"

Date: 16 April 2013

**THIRD & FOURTH FLOOR  
REFLECTED CEILING PLANS**

**A3.0**