



FOURTH FLOOR REFLECTED CEILING PLAN
SCALE: 1/8" = 1'-0"

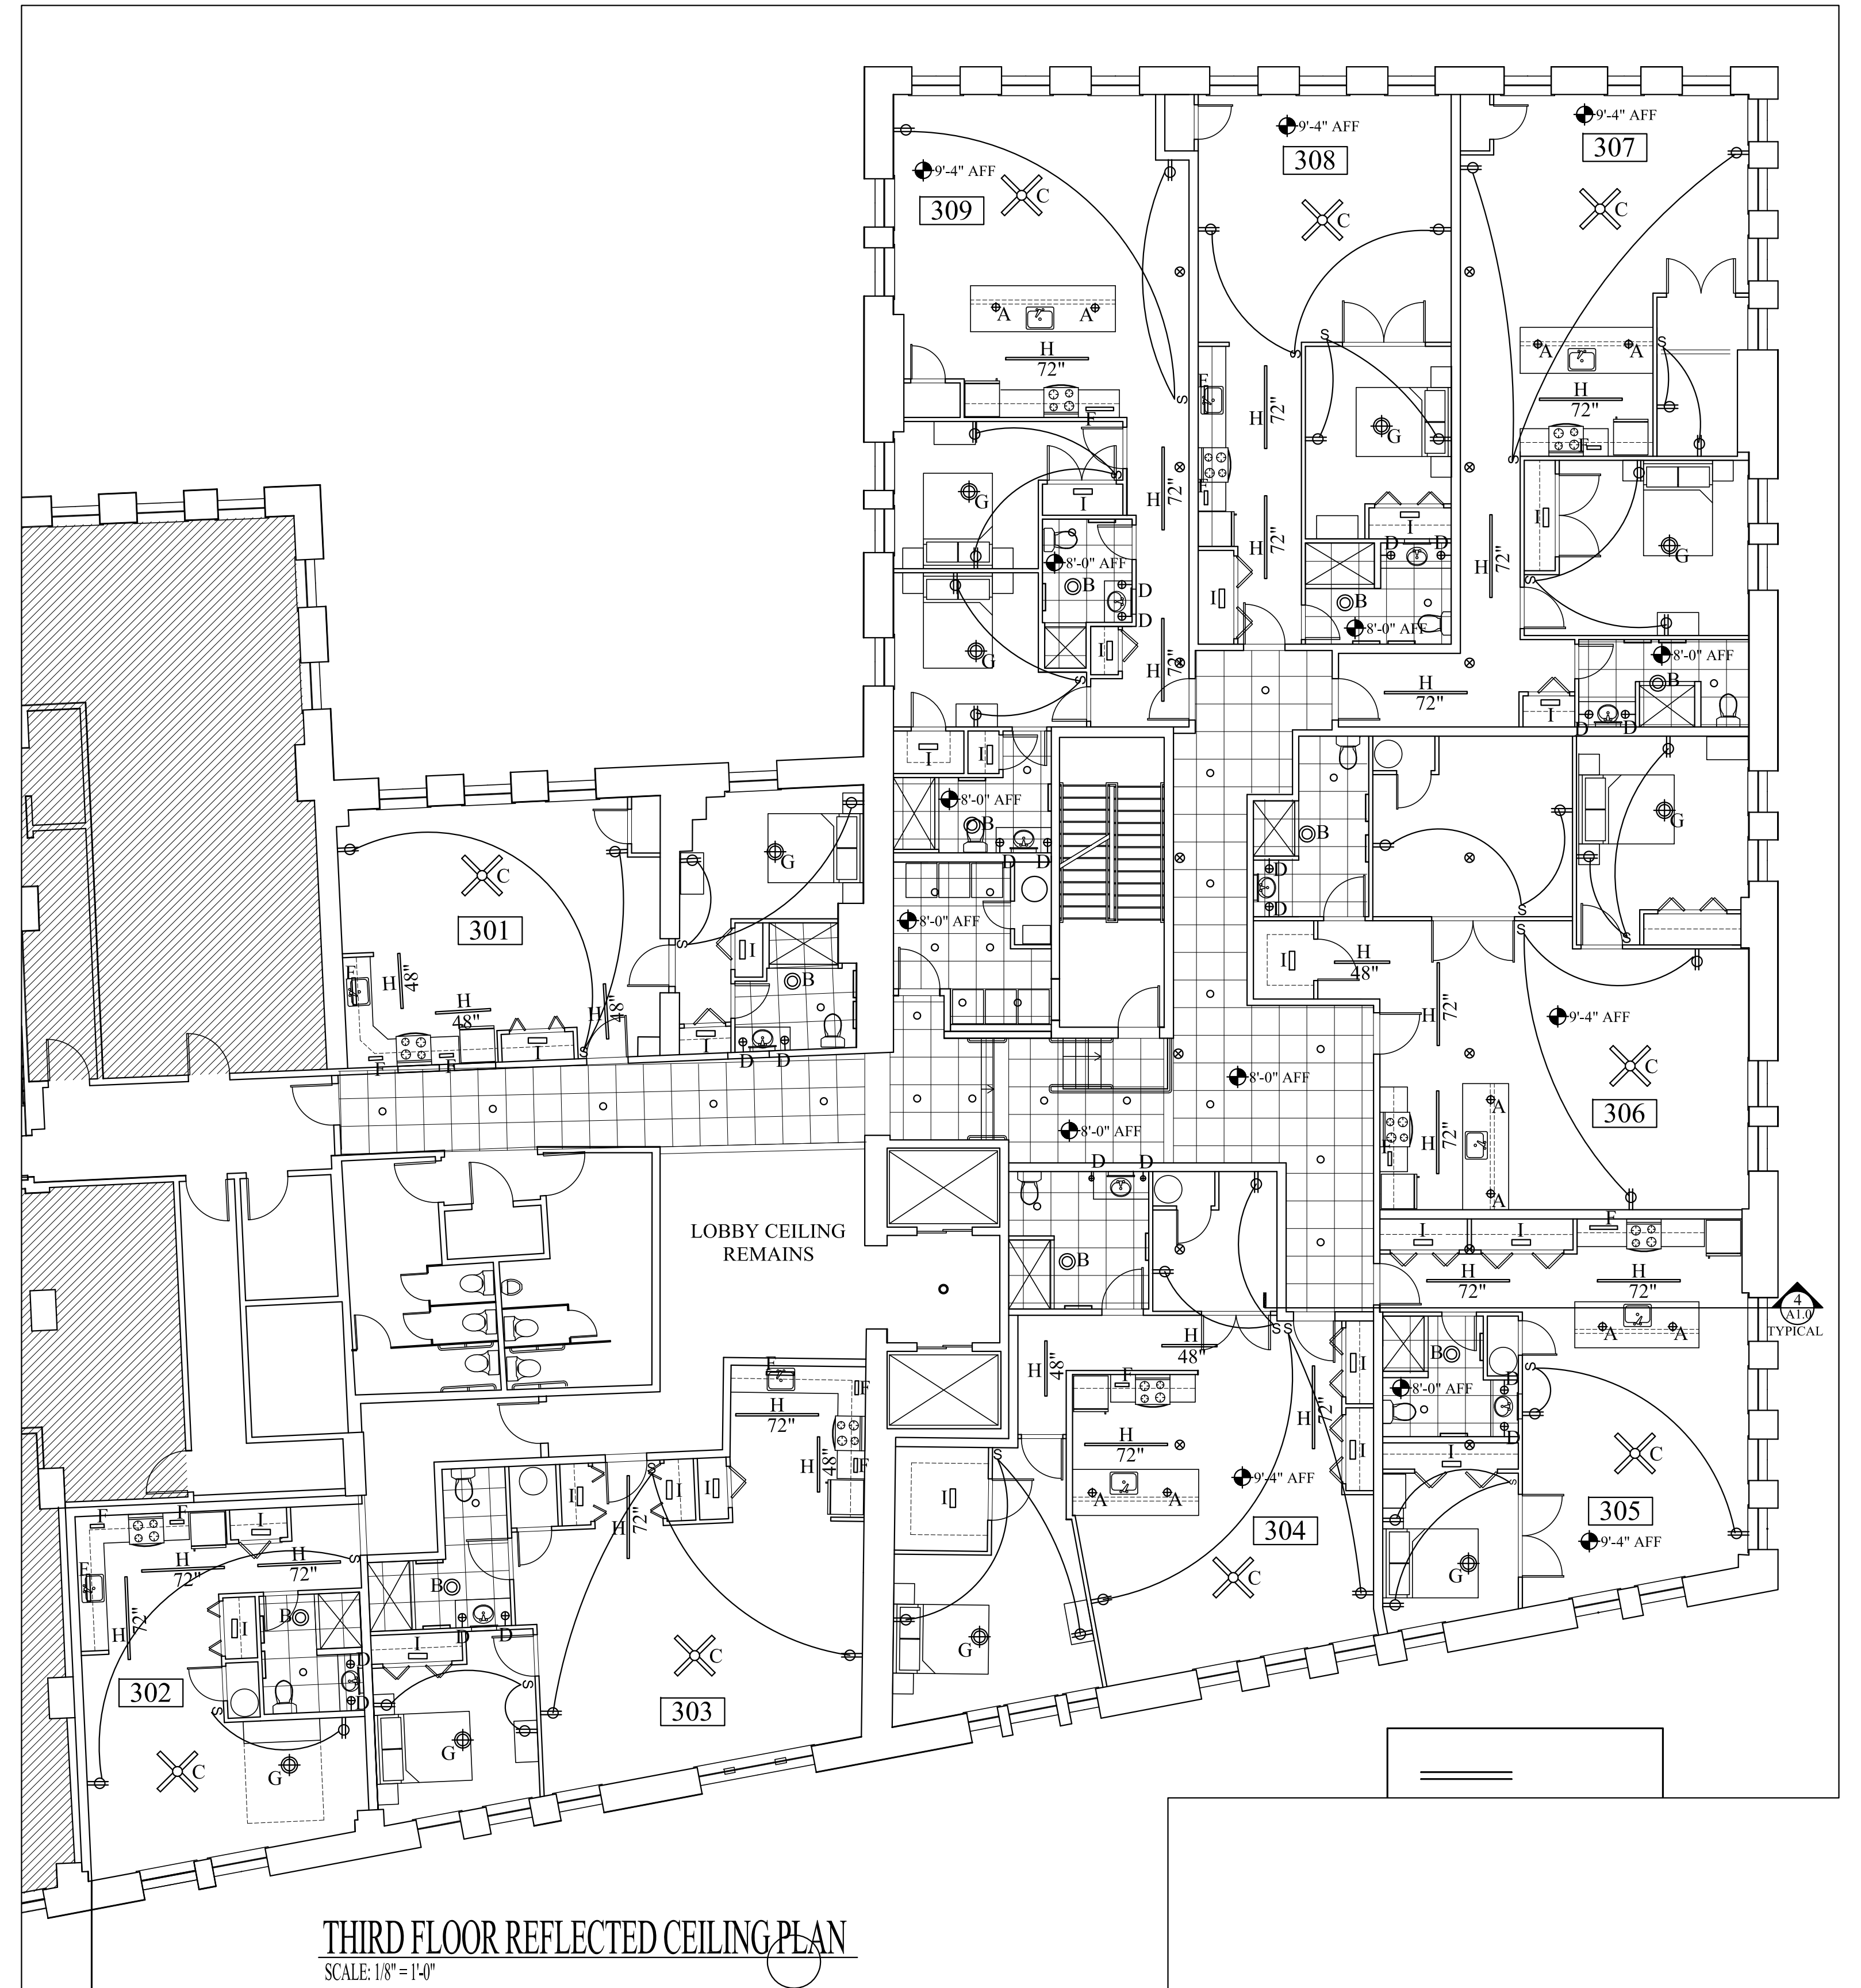

THIRD FLOOR REFLECTED CEILING PLAN
SCALE: 1/8" = 1'-0"

*** LIGHTING SCHEDULE ***

TAG	ITEM	MANUFACTURER	MODEL	FINISH
A	Pendant	Forecast Lighting	F5104-70	Merlot Bronze
	Pendant Shade	Forecast Lighting	F5184 Cork Over Clear Glass	Cork
B	Bathroom Fan	Air King	AK864L Exhaust Fan with Light	White
C	Ceiling Fan	Modern Fan	Gusto #GUS-BN-46-NK-NL-001	Bright Nickel
D	Sconce	Forecast Lighting	F4505-36 NV	Satin Nickel/White
○ = E	Recessed Can	NA	Dimming 5" Recessed Aluminum Fixture with white trim kit	White
F	Under Cabinet	NA	See millwork elevations dwg A5.0 & A5.1 for light lengths	
G	Surface mtd. Light	Forecast Lighting	Cassandra F615136NV	Satin Nickel
H	Lighting Track	NA	Plan indicates length of track	Stainless Steel
I	Surface mounted Closet Light	NA		

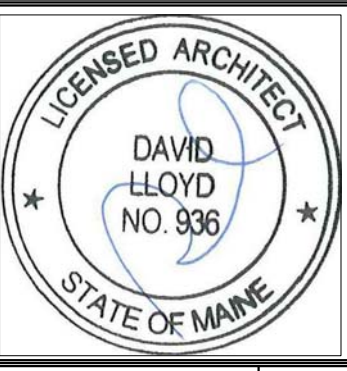

Owner:

Consulting Engineer:



Project: **J.B. BROWN BUILDING**
537 CONGRESS STREET
PORTLAND, ME

Revisions:

Date: 16 April 2013
Scale: 1/8" = 1'-0"
THIRD & FOURTH FLOOR REFLECTED CEILING PLANS

A3.0