




1 REFLECTED CEILING PLAN
SCALE: 1/8" = 1'-0"

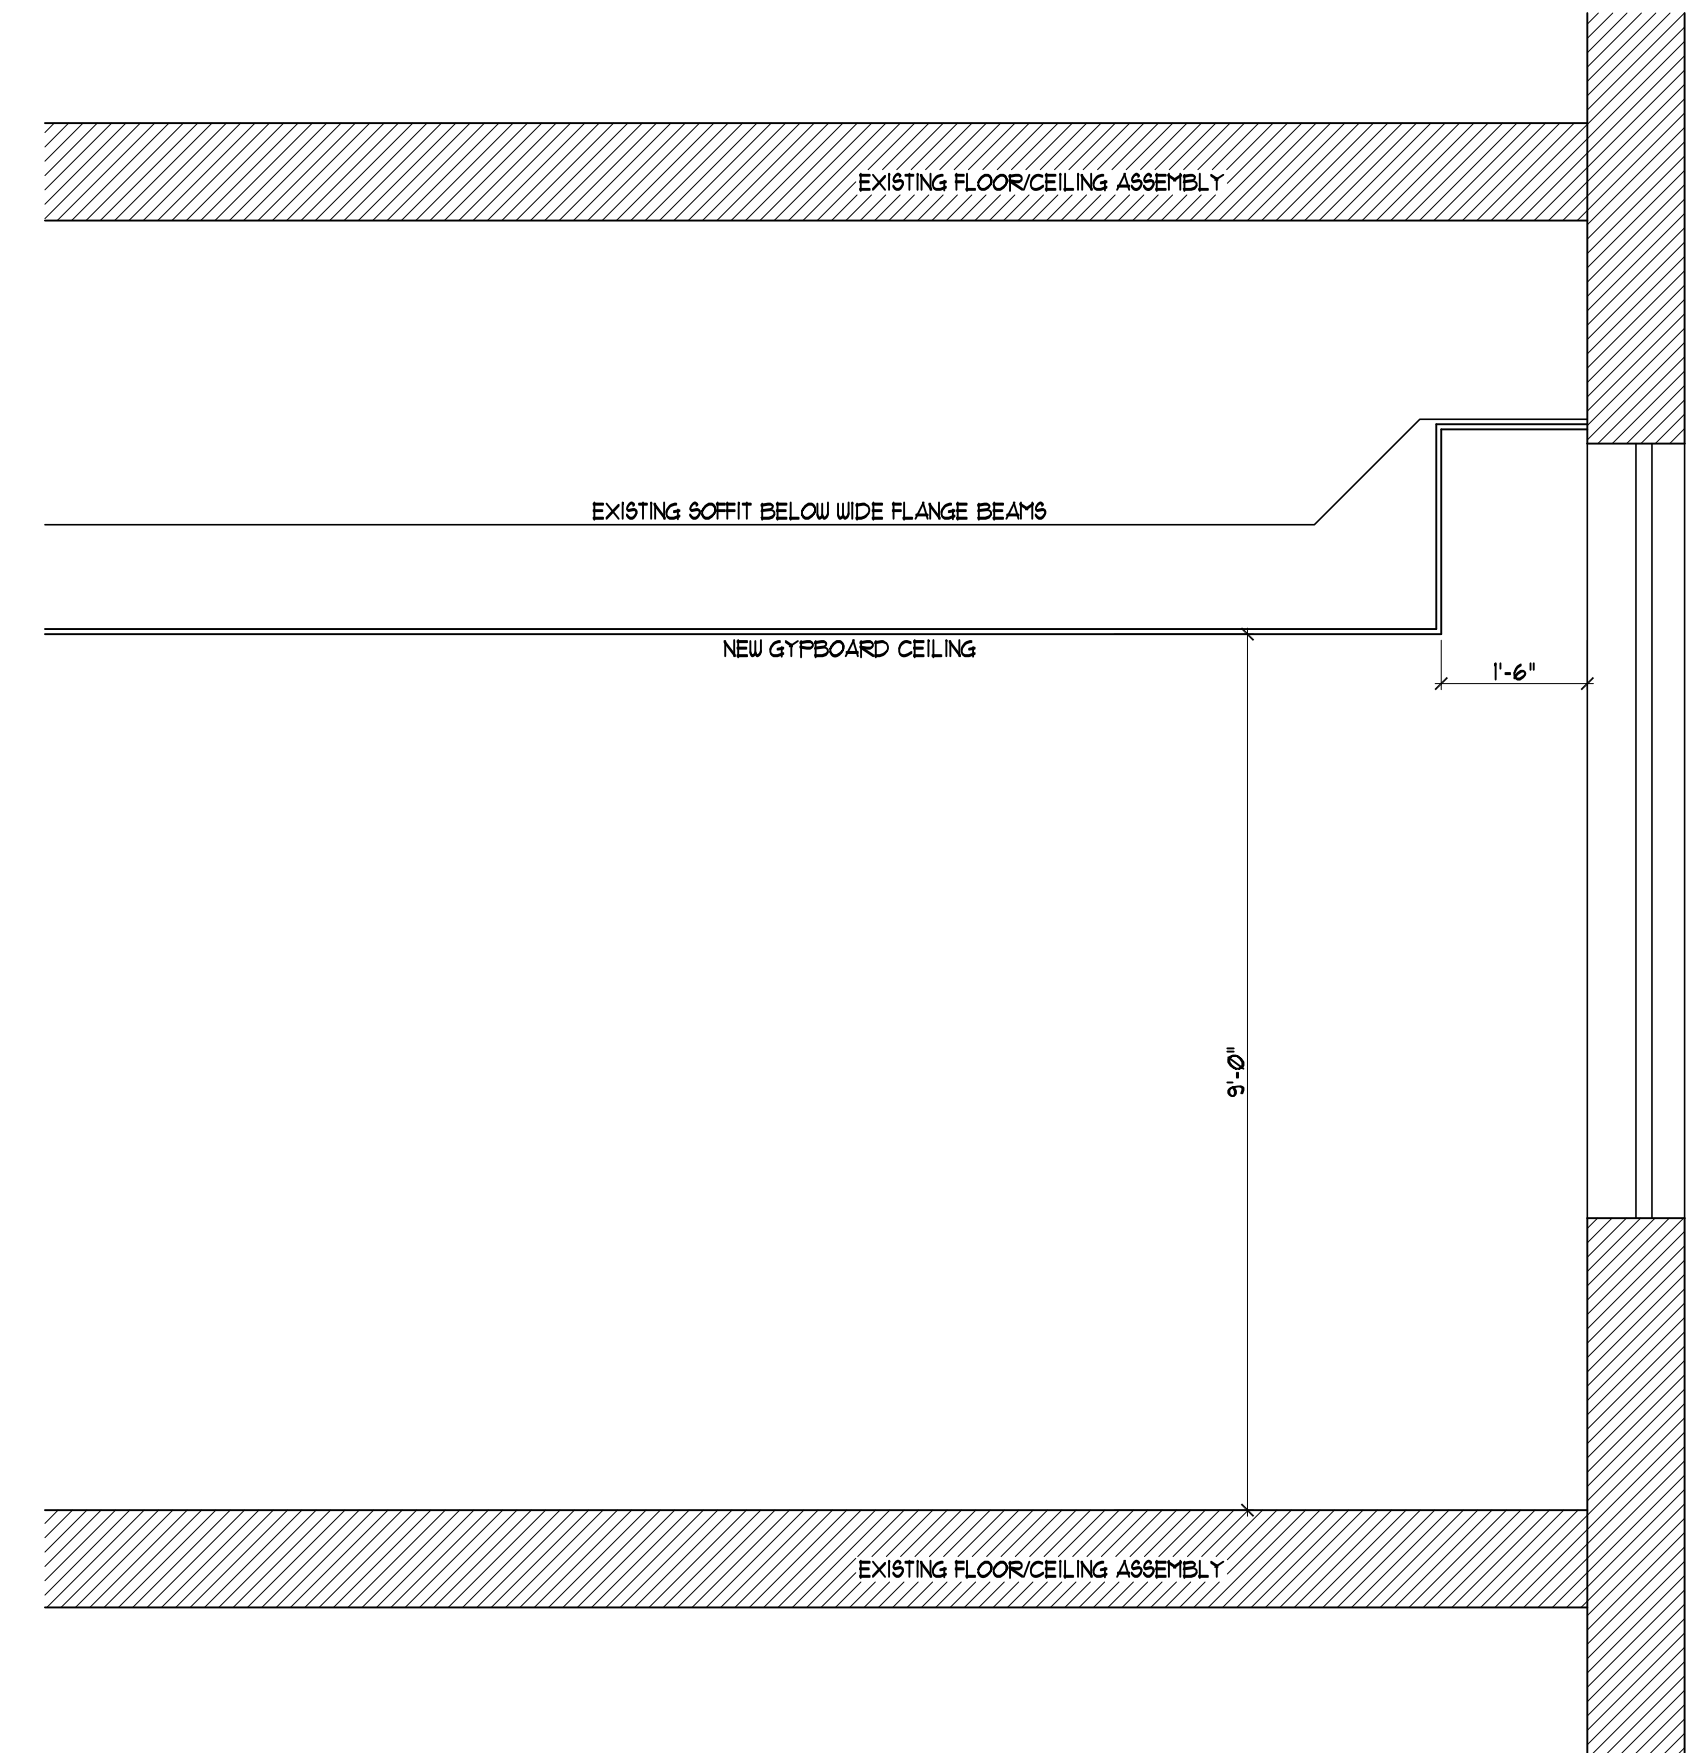

2 TYPICAL SECTION AT WINDOW
SCALE: 1/2" = 1'-0"

*** LIGHTING SCHEDULE ***

TAG	ITEM	MANUFACTURER	MODEL	FINISH
A	Pendant	Forecast Lighting	F5104-70	Merlot Bronze
	Pendant Shade	Forecast Lighting	F5184 Cork Over Clear Glass	Cork
B	Bathroom Fan	Air King	AK864L Exhaust Fan with Light	White
C	Ceiling Fan	Modern Fan	Gusto #GUS-BN-46-NK-NL-001	Bright Nickel
D	Sconce	Forecast Lighting	F4505-36 NV	Satin Nickel/White
E	Recessed Can	NA	Dimming 5" Recessed Aluminum Fixture with white trim kit	White

NOTE: Provide switches and outlets per code- switches shown in addition to code requirements

Owner:

Consulting Engineer:

Architect: **ARCHETYPE architects**
48 Union Wharf Portland, Maine 04101
(207) 772-6022 Fax (207) 772-4056

Project: **J.B. BROWN BUILDING**
537 CONGRESS STREET
PORTLAND, ME

Revisions:

Date: 22 November 2011
Scale: 1/8" = 1'-0"
1/2" = 1'-0"

**FOURTH FLOOR
CEILING PLAN**

A2