





2 | PROPOSED ROOF DRAINAGE PLAN  
SCALE: 1/8"=1'-0"

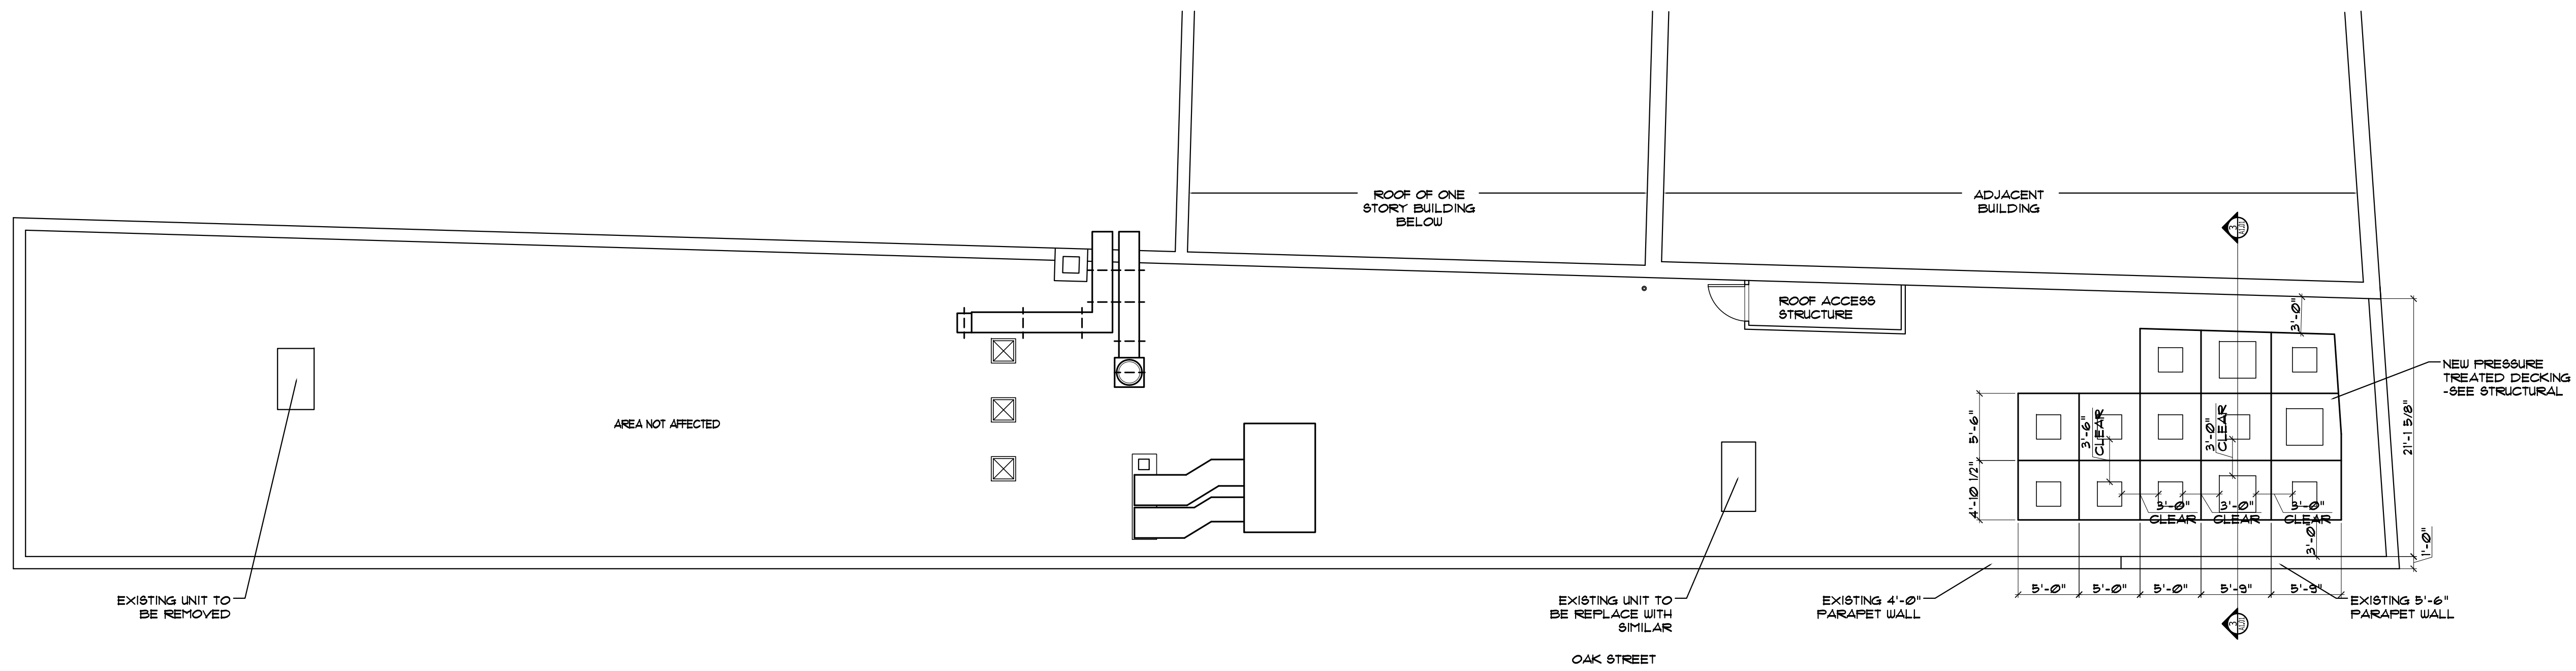

1 | PROPOSED ROOF DECK PLAN  
SCALE: 1/8"=1'-0"

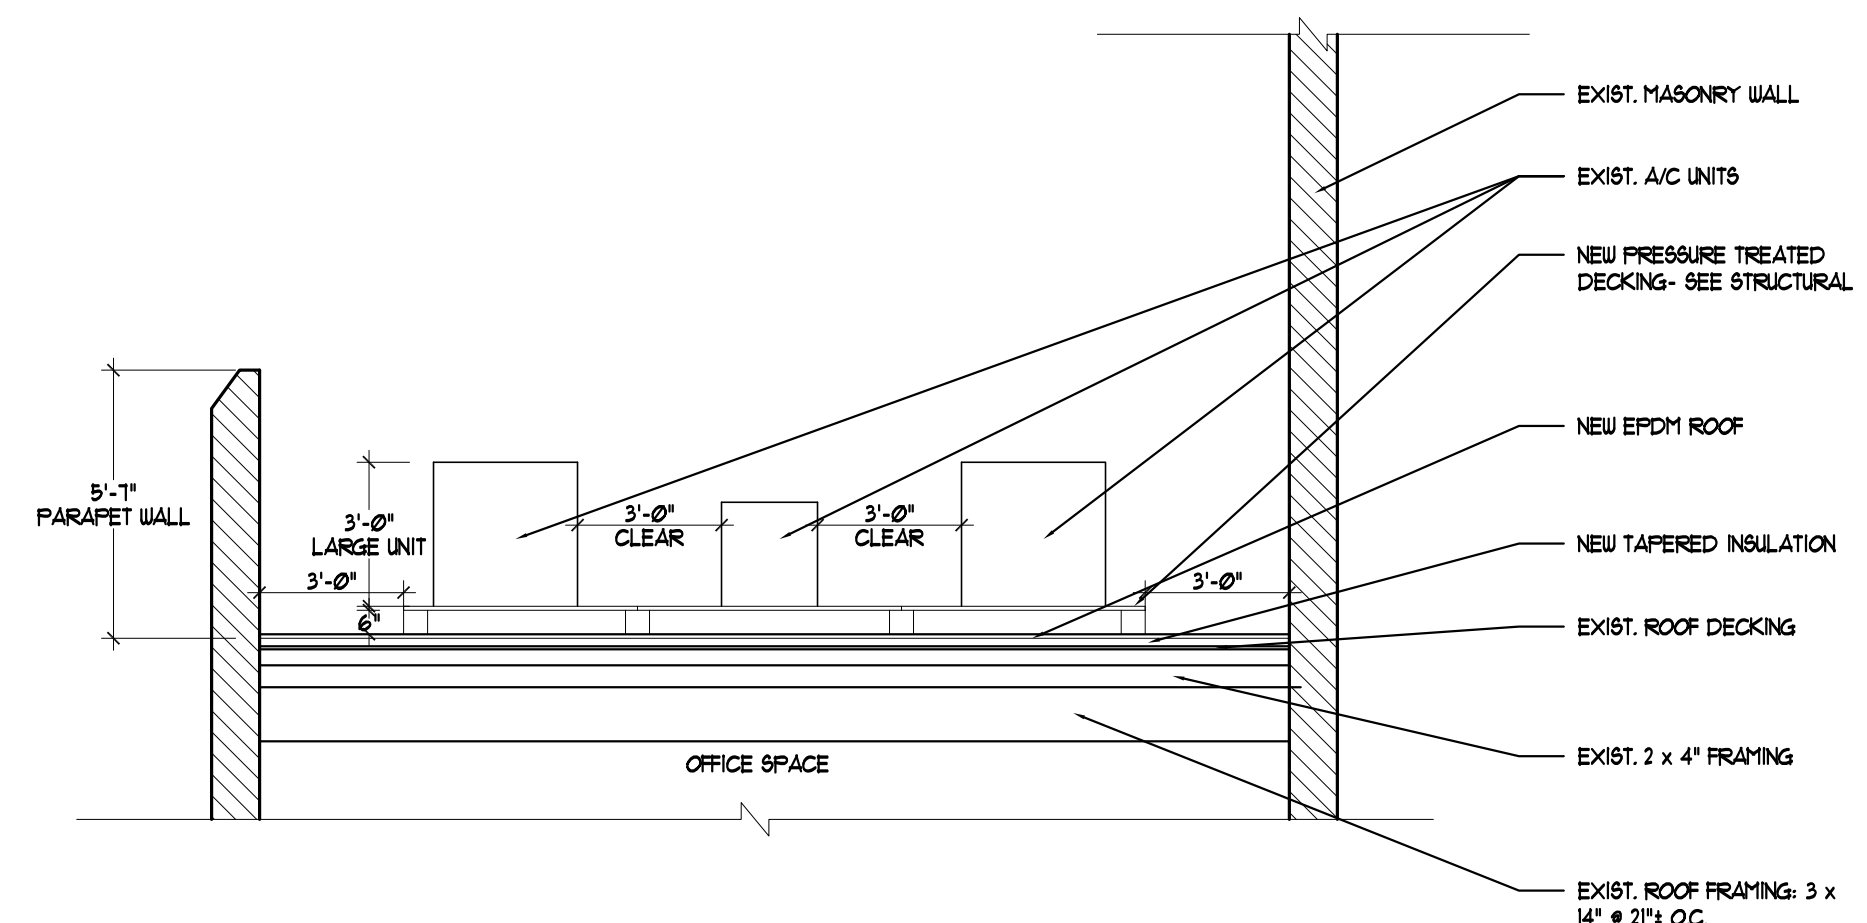

3 | ROOF SECTION  
SCALE: 1/4"=1'-0"

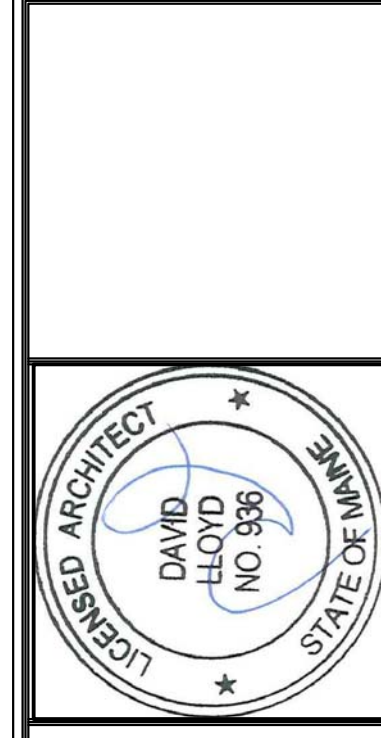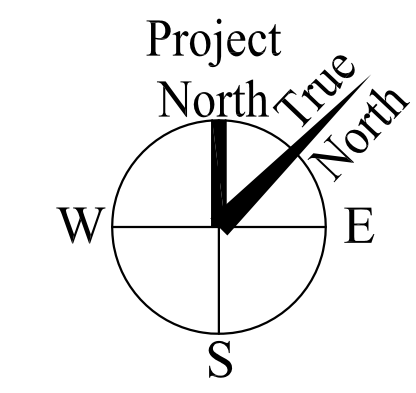

Consulting Engineer:

Architect:  
**ARCHETYPE** architects  
48 Union Wharf Portland, Maine 04101  
(207) 772-6022 Fax (207) 772-4056

Project:  
**551 CONGRESS ST**  
551 CONGRESS STREET  
PORTLAND, MAINE

Revisions:

Date: 02 May 2013  
Scale: AS NOTED  
**PROPOSED ROOF PLAN**

**A1.01**