




2 | PROPOSED ROOF DRAINAGE PLAN  
SCALE: 1/8"=1'-0"

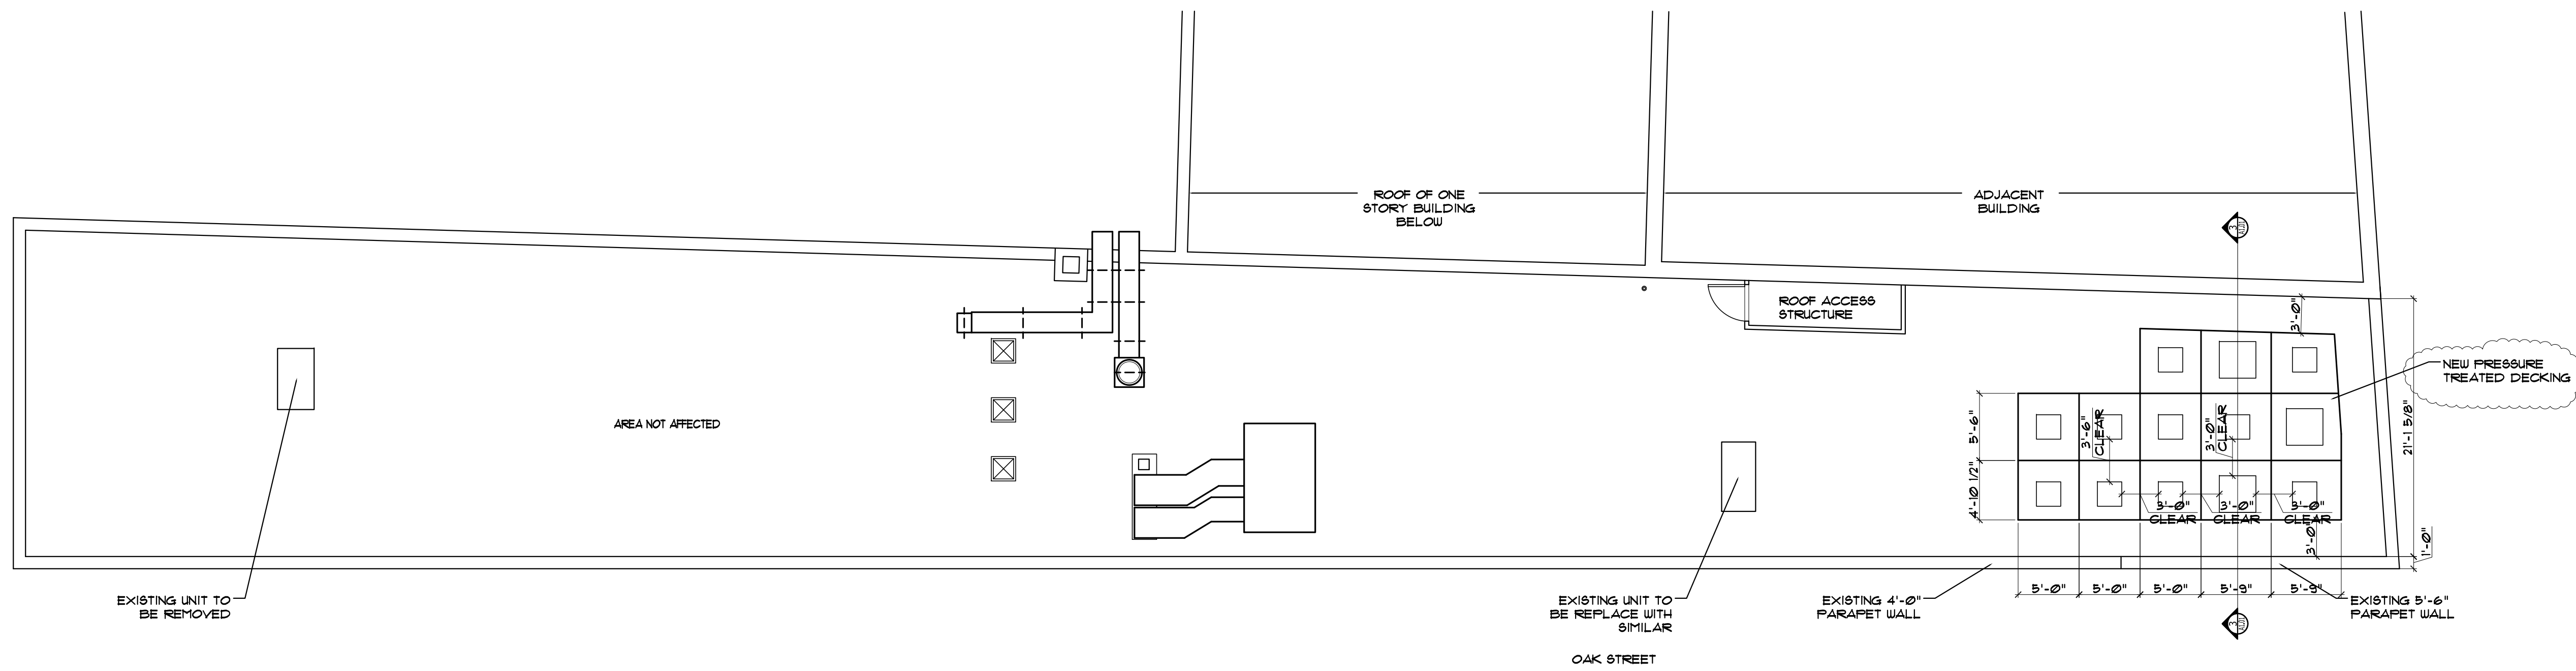

1 | PROPOSED ROOF DECK PLAN  
SCALE: 1/8"=1'-0"

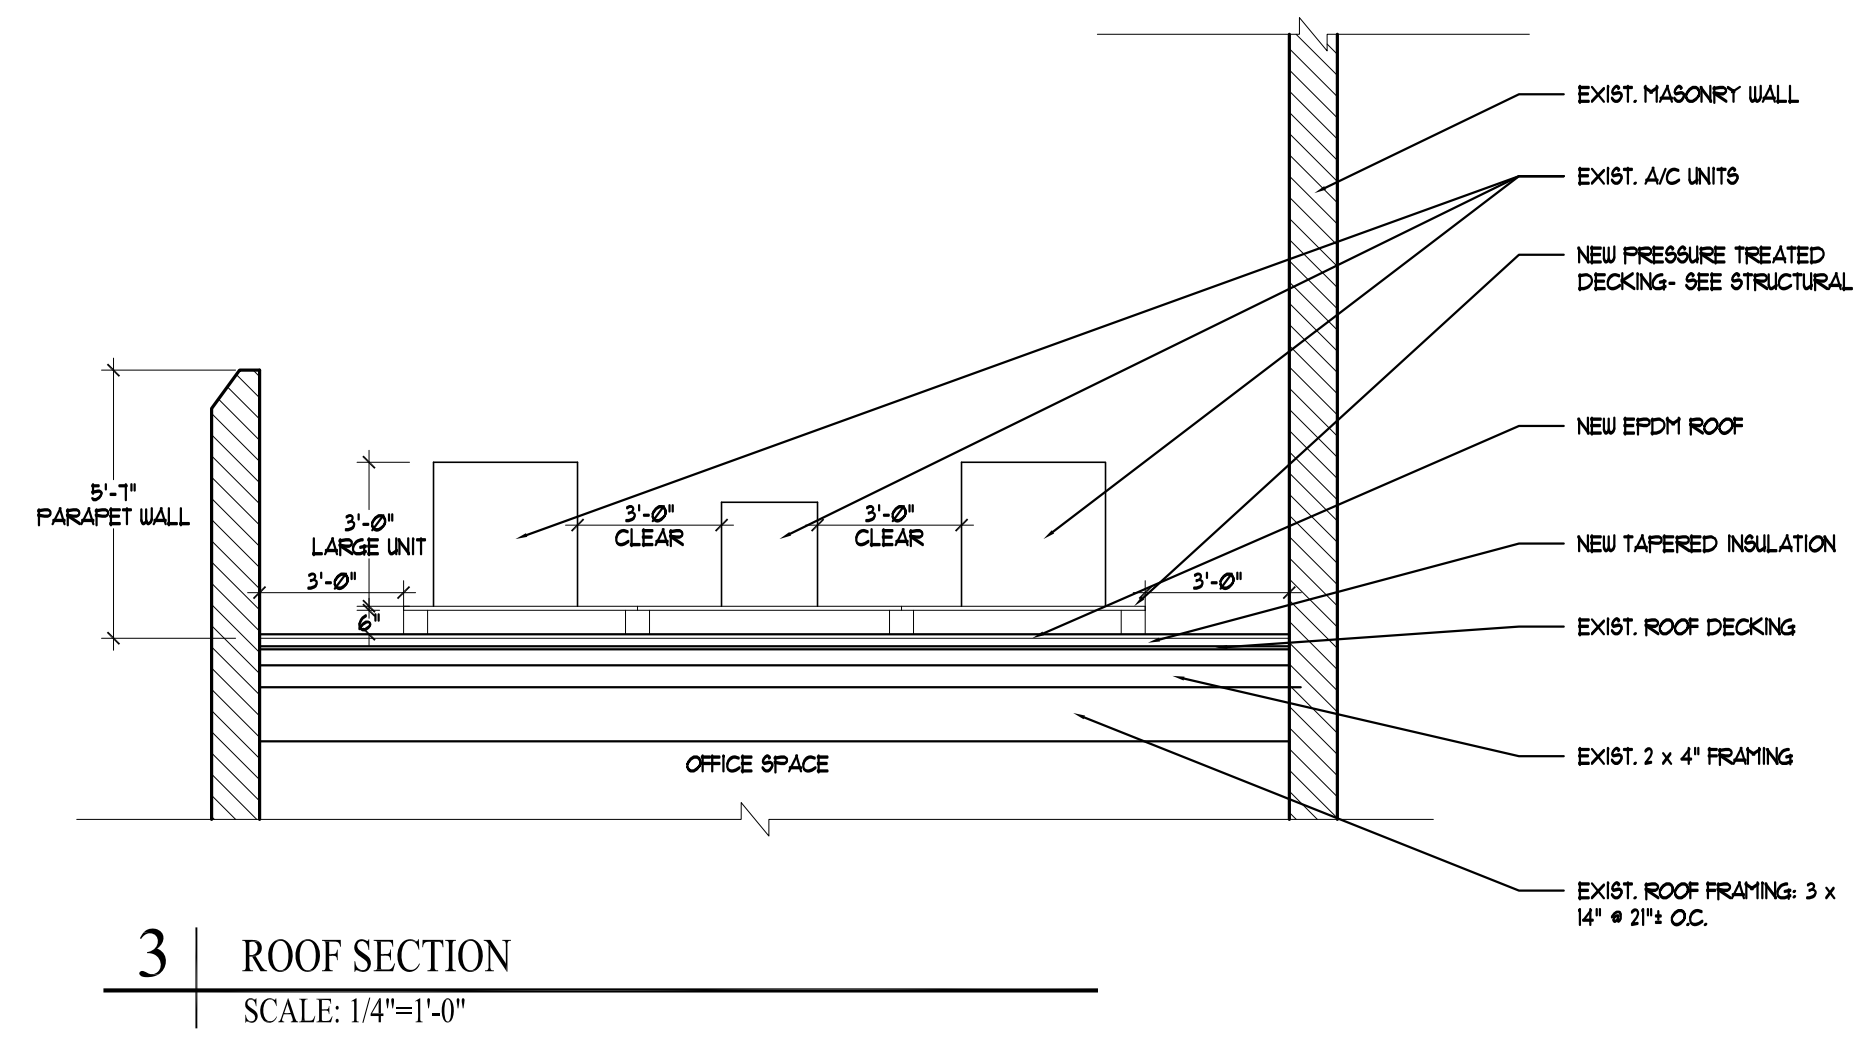

3 | ROOF SECTION  
SCALE: 1/4"=1'-0"

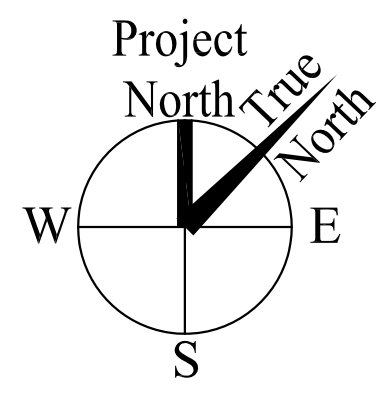

Consulting Engineer:	
<b>ARCHETYPE</b> architects 48 Union Wharf Portland, Maine 04101 (207) 772-6022 Fax (207) 772-4056	
Project:	<b>551 CONGRESS ST</b> 551 CONGRESS STREET PORTLAND, MAINE
Revisions:	06/26/2013
Date:	02 May 2013
Scale:	AS NOTED
<b>PROPOSED ROOF PLAN</b>	
<h1>A1.01</h1>	