

FOR PERMITTING  
8-5-05



POWER & LIGHTING PLAN  
FIRST FLOOR  
ELECTRICAL

Date	8-5-05
Drawn By: CLC	
Checked By: AMM	
Scale	AS NOTED
Revisions:	

ARCHETYPE, P.A.  
ARCHITECTS  
48 Union Wharf Portland, Maine 04101  
(207) 772-6022 Fax (207) 772-4056

BAR  
551 CONGRESS SREET  
PORTLAND, MAINE

OWNER:  
CONGRESS STREET  
PORTLAND, MAINE

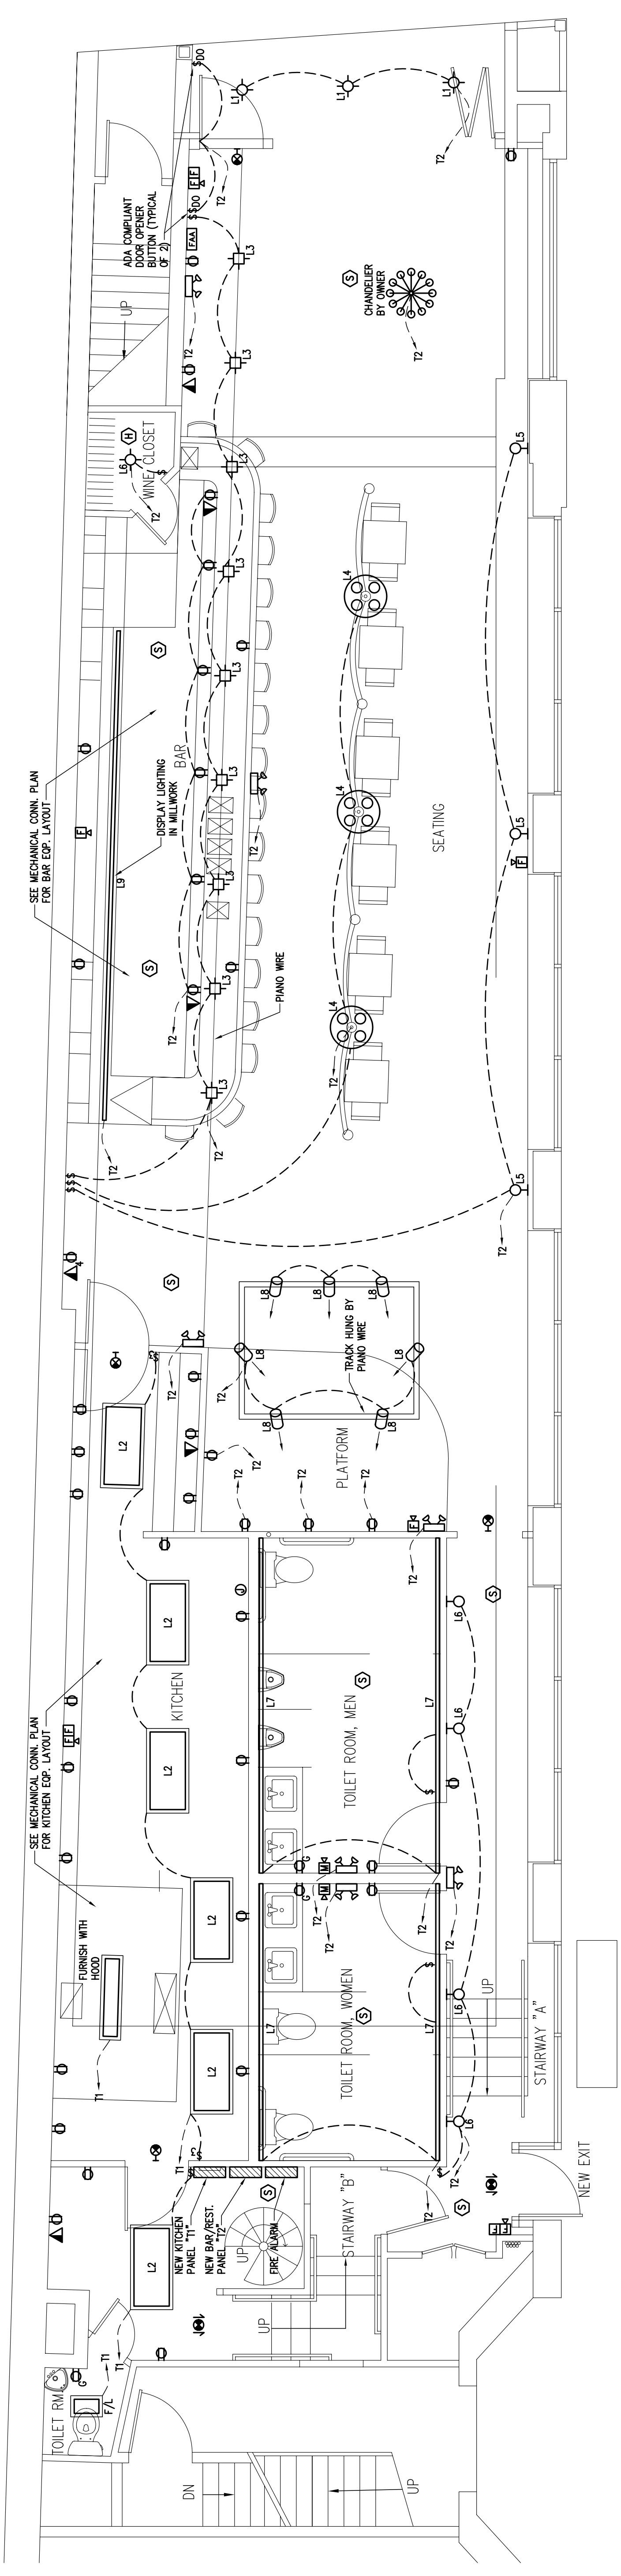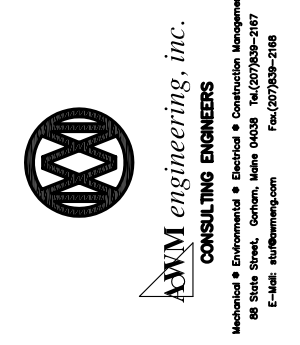

1 FIRST FLOOR PLAN  
1/4" = 1'-0"