

FOR PERMITTING 8-5-05




Plumbing First Floor Plan- Water & Gas

Date	8-5-05
Drawn By:	AL
Checked By:	
Scale	AS NOTED

ARCHETYPE, P.A. ARCHITECTS  
 48 Union Wharf Portland, Maine 04101  
 (207) 772-6022 Fax (207) 772-4056

BAR  
 551 CONGRESS SREET  
 PORTLAND, MAINE

Owner:  
 CONGRESS STREET  
 PORTLAND, MAINE

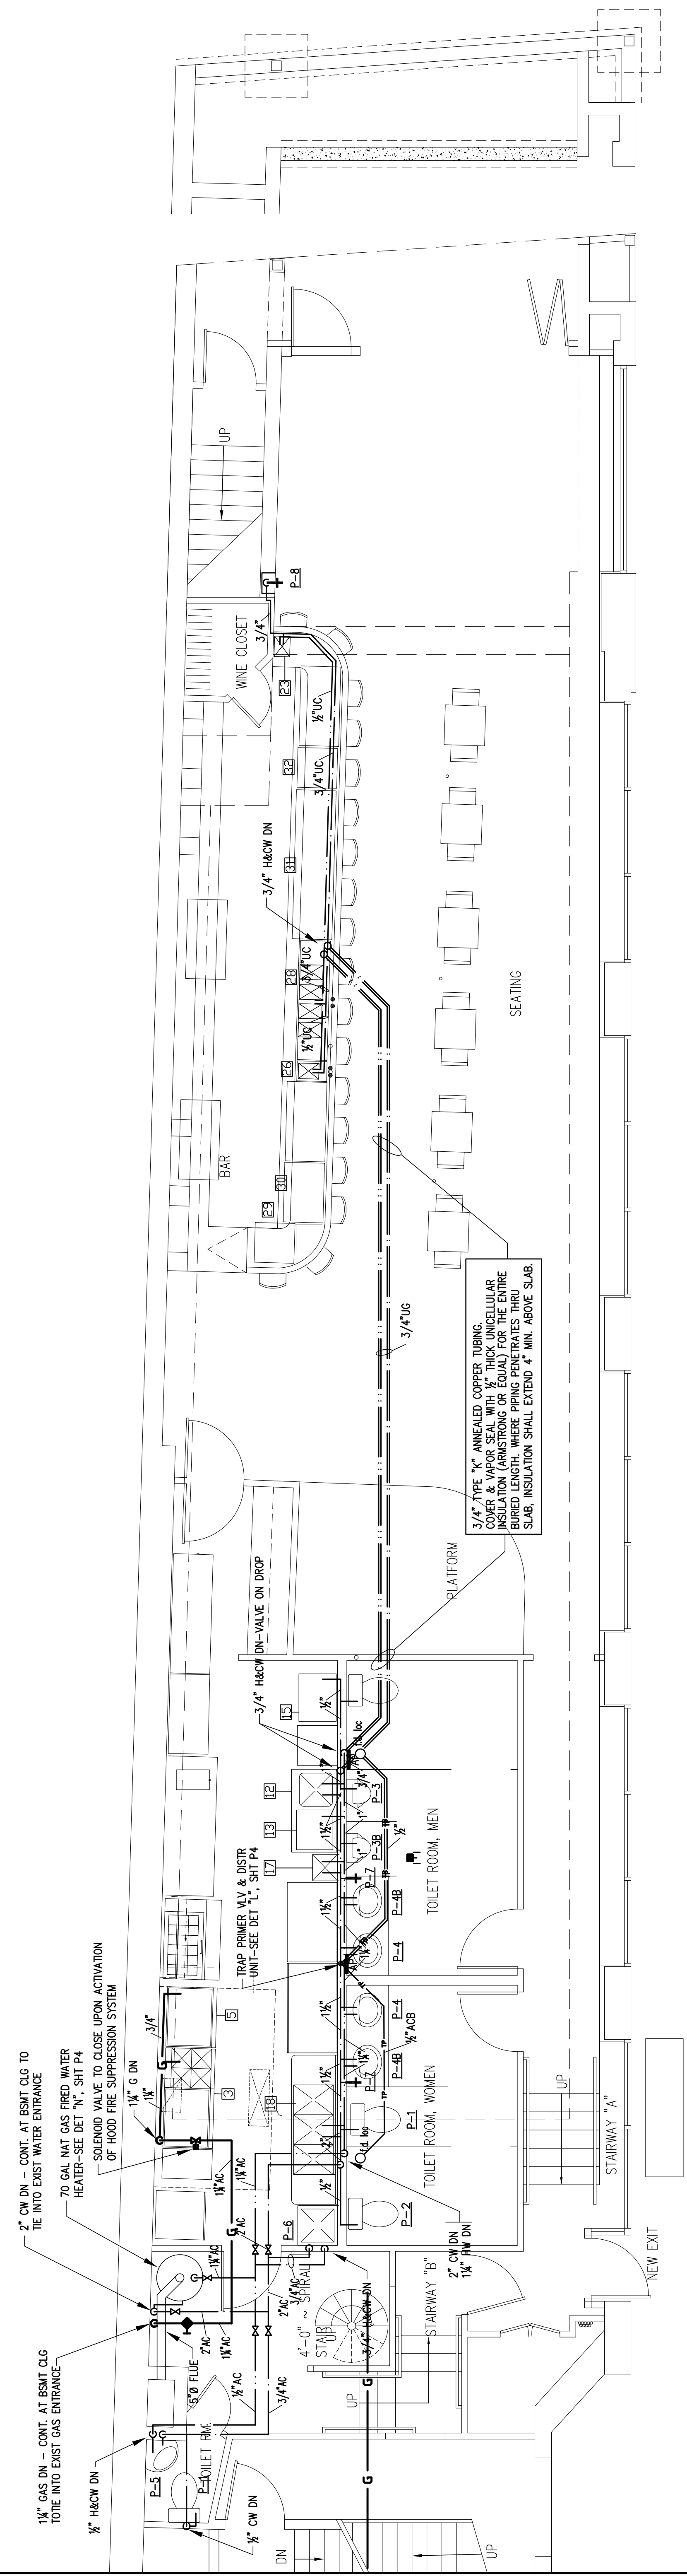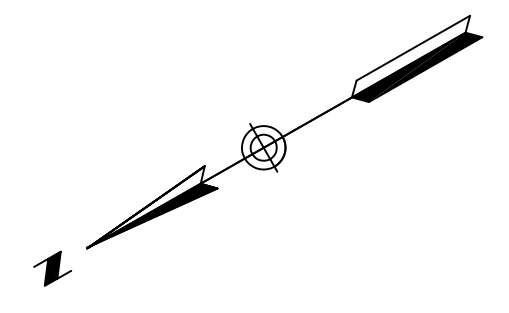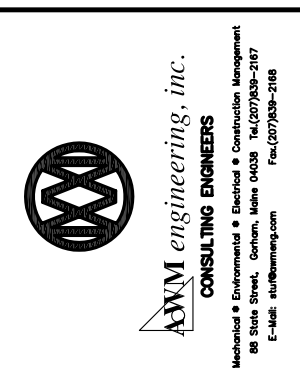

10 FOUNDATION  
 1/4" = 1'-0"

1 FIRST FLOOR PLAN  
 1/4" = 1'-0"