


— LEGEND —

ABBR	DESCRIPTION	SYMB	ABBR	DESCRIPTION	SYMB
CW	COLD WATER	●	208-1	VOLTAGE PHASE	V.A.
HW	HOT WATER	●	KW	KILOWATT	—
WV	WASTE	○	HP	HORSE POWER	—
IW	INDIRECT WASTE	○	DR	DRINK RECEPTACLE	■
G	GAS	●	JB	JUNCTION BOX	■
BTU	BRITISH THERMAL UNIT	■	SR	SINGLE RECEPTACLE	■
FD	FLOOR DRAIN	■	V	VOLT	—
FS	FLOOR SINK	■	AMP	AMPERE	—
S	STEAM	■	BTC	BRANCH TO CONNECTION	—
CR	CONDENSATE RETURN	■	SW	SWITCH	—
CFM	CUBIC-FOOT-MINUTE	—	DEF	DROP ROOM ABOVE	—
SP	STATIC PRESSURE	—	AFB	ABOVE FINISHED FLOOR	—
PC	PUMPER CONTRACTOR	—	CBP	CORO AND PLUG	—
KEC	KITCH. EQUIP. CONTR.	—	EC	ELECT. CONTRACTOR	—
			NIC	NOT IN CONTRACT	—

- ELECTRICAL NOTES (E.C.)
- ALL BOXES, CONNECTIONS, RECEPTACLES, SWITCHES AND WIRING ARE TO BE SUPPLIED AND INSTALLED BY THE ELECTRICAL CONTRACTOR UNLESS OTHERWISE NOTED.
  - ALL RECEPTACLES, UNLESS OTHERWISE NOTED, ARE TO BE CONFORMABLE WITH CSA CONNECTIONS BY EQUIPMENT SYMBOLS WITH CSAS AND CSAP.
  - ALL WORK AND MATERIAL MUST BE ACCEPTABLE TO CODE ENFORCEMENT WITH OBSERVATION BY THE OWNER.
  - DIMENSIONS OF THIS PLAN ARE TO THE UTILITY CENTER LINE UNLESS OTHERWISE NOTED TO POINT. ARE TO THE UTILITY CENTER LINE UNLESS OTHERWISE NOTED TO POINT. ARE TO THE UTILITY CENTER LINE UNLESS OTHERWISE NOTED TO POINT. ARE TO THE UTILITY CENTER LINE UNLESS OTHERWISE NOTED TO POINT. ARE TO THE UTILITY CENTER LINE UNLESS OTHERWISE NOTED TO POINT.
  - CHECK ALL MOTOR BARRIERS, APPLIANCES TO ASSURE WIRING ALLOWNS FOR CORRECT MOTION.

FOODSERVICE EQUIPMENT

#	QTY	DESCRIPTION
1	1	EXHAUST HOOD
2	1	SPARE #
3	1	RANGE
4	1	SPARE #
5	1	CHARBROLLER
5.1	1	CHARBROLLER STAND
6	1	WORKTABLE
7	1	PREPZER
8	1	SANDWICH PREP UNIT (BY OTHERS)
9	1	SANDWICH PREP UNIT
9.1	1	WALL SHELF
10	1	WALL SHELF
11	1	SHELVING UNIT
12	1	SOILED DISHTABLE
13	1	UNDERCOUNTER DISHWASHER
14	1	STAND
15	1	ICE MAKER
16	1	REFRIGERATOR
17	1	HAND SINK
18	1	3 COMPARTMENT SINK
19	1	WALL SHELF
20	1	WORKTABLE
21	1	FOOD WARMER
22	1	WOOD TOP TABLE
23	1	HAND SINK
24	1	WAITRESS COUNTER (OTHERS)
25	1	BAR AREA
26	1	HAND SINK
27	2	BOTTLE COOLER
28	1	4 COMP. BAR SINK
29	1	GLASS RACK
30	1	COCKTAIL STATION
31	1	DRAFT BEER UNIT
32	1	COCKTAIL STATION
33	2	BACK BAR REFRIGERATOR

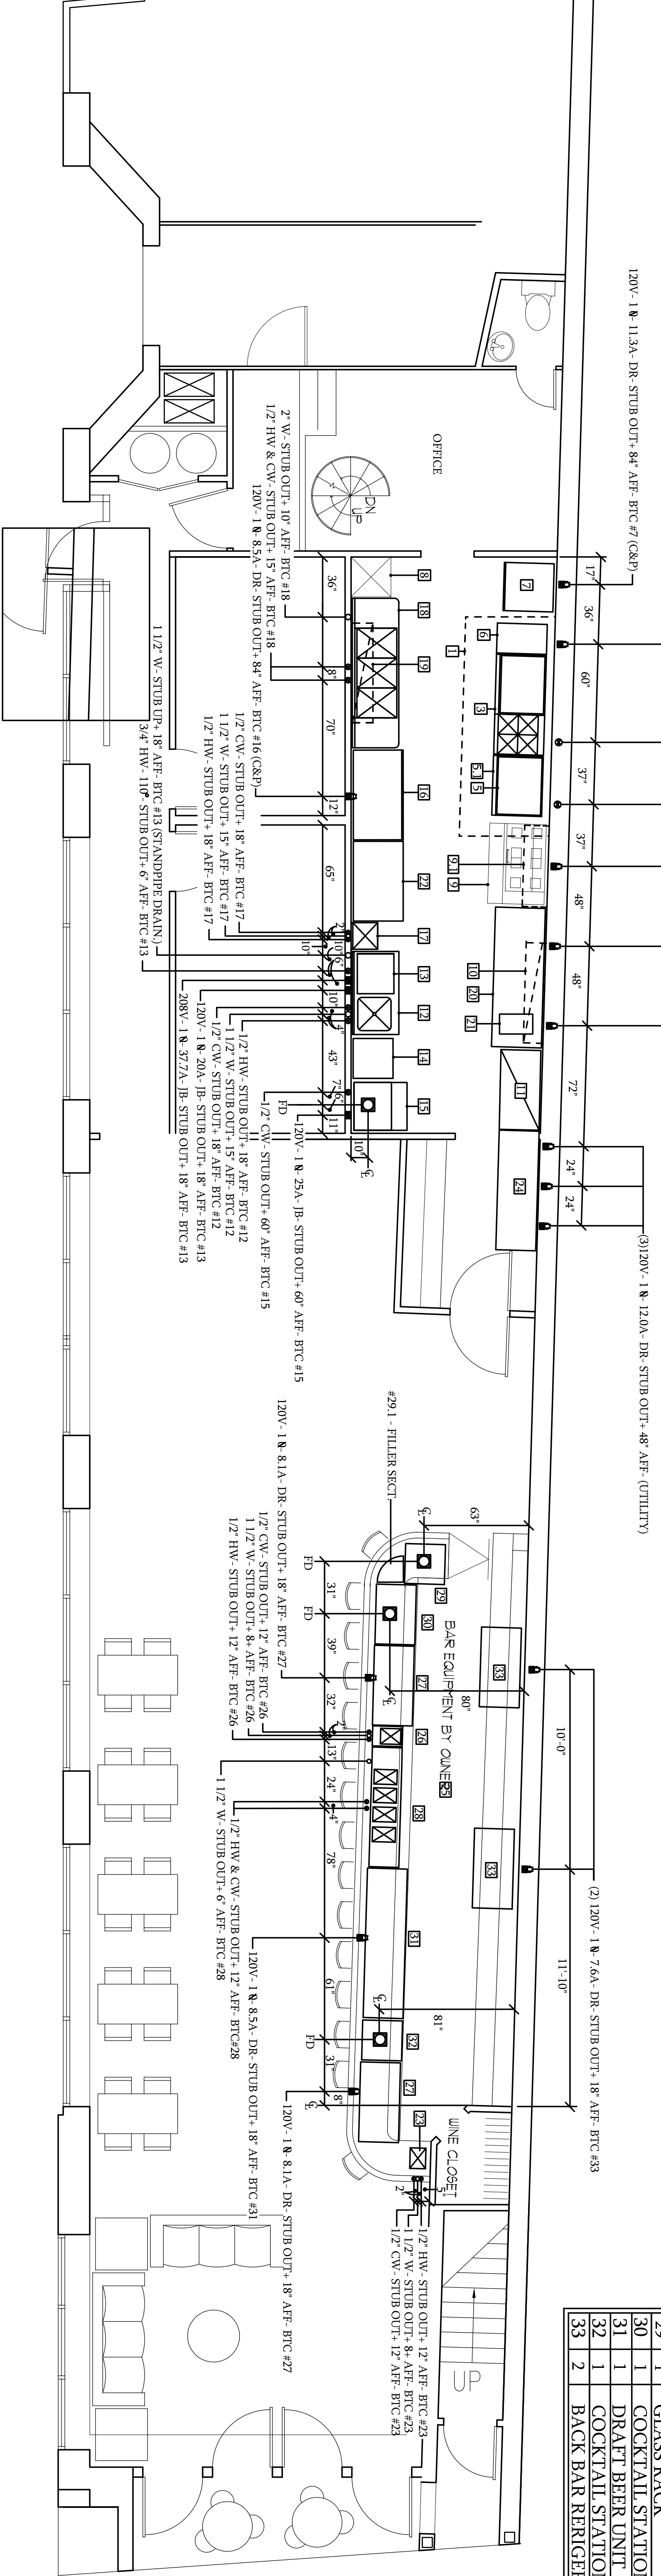

FIRST FLOOR PLAN

OAK STREET

PROJECT:  
WHITE HEART LOUNGE  
PORTLAND, ME

PERKINS  
QUALITY WITHOUT COMPROMISE

37 AMOSKEAG ST. MANCHESTER, N.H. 03102  
603.669.3400 FAX:603.661.6140  
HERDQ/AVARS/ESD/JOHN HANCOCK ROAD, TAYLORVILLE, MA 02786  
MECHANICAL CONNECTION PLAN

SCALE: 1/4" = 1'-0"  
DRAWN BY: E.D.  
DATE: 6.10.05  
REVISED: 6.22.05  
REVISED: 7.15.05  
JOB #:

DWG # :  
**K-1**

Project: 551 CONGRESS STREET  
551 CONGRESS STREET  
PORTLAND, MAINE

Owner: 551 CONGRESS STREET LLC  
551 CONGRESS STREET  
PORTLAND, MAINE

SUBMITTED FOR PERMIT 8/05/05