


CASCO STREET.

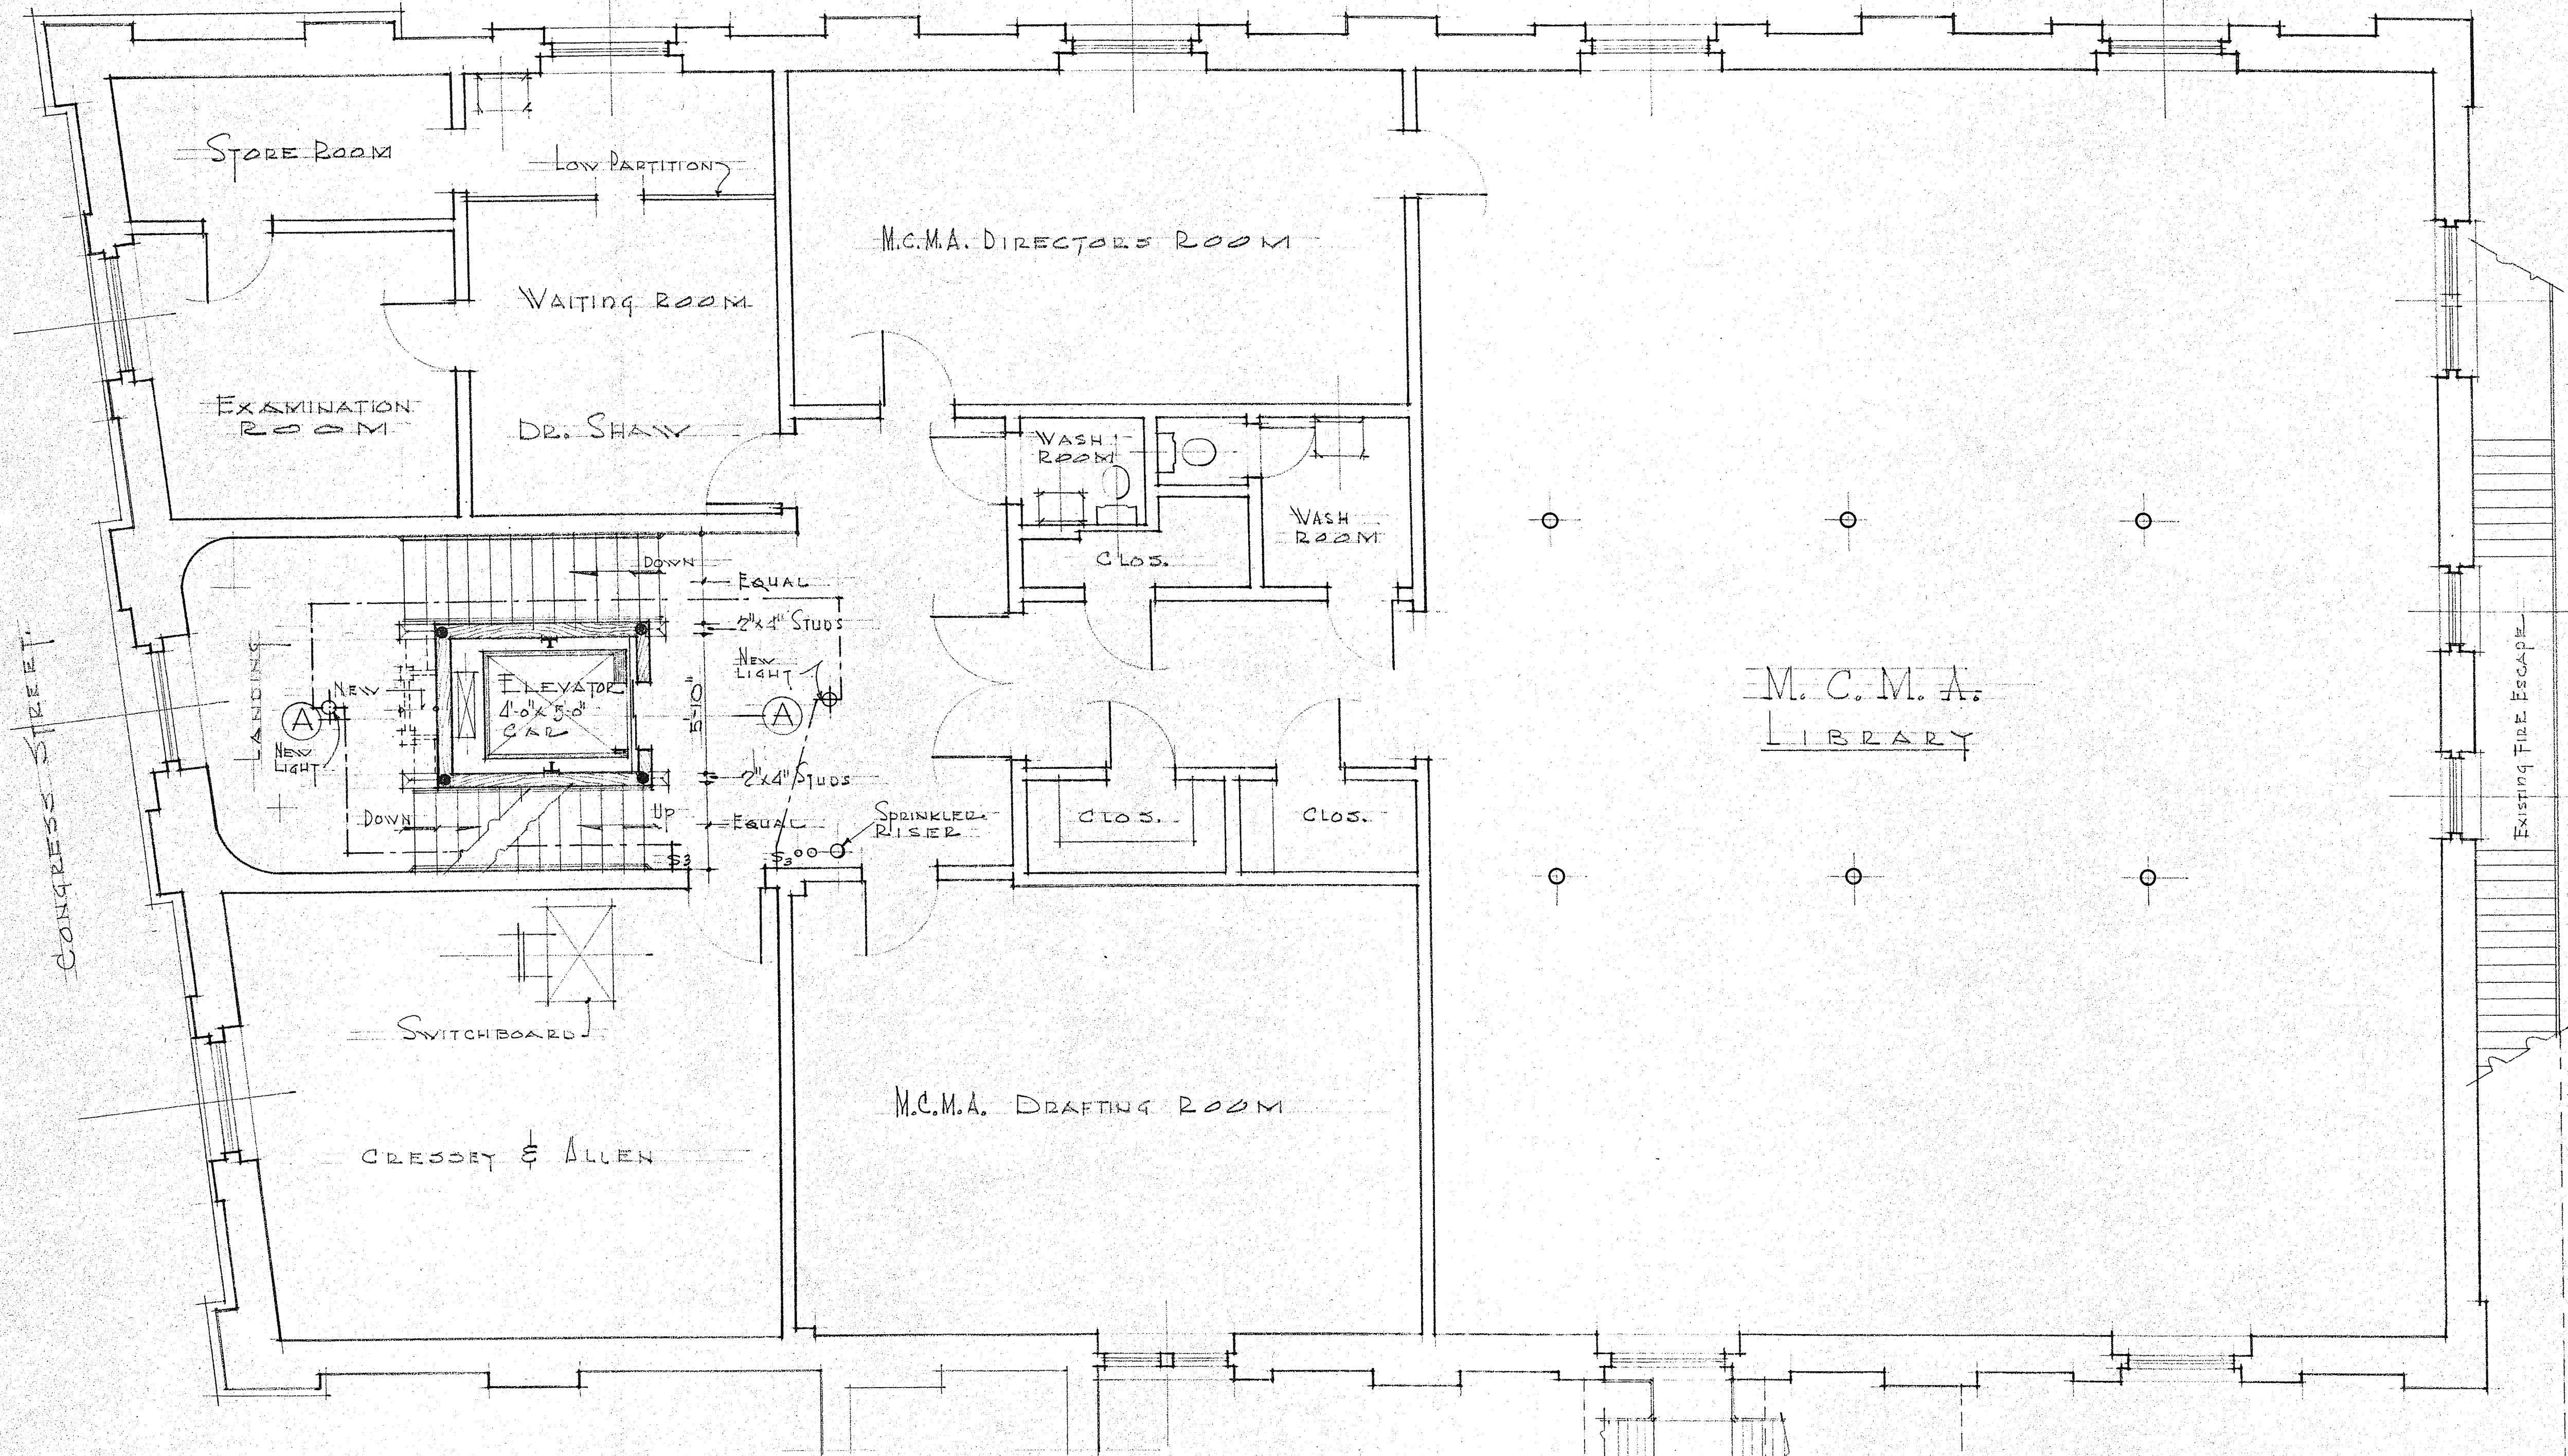

CONGRESS STREET.

M.C.M.A.
LIBRARY

SWITCHBOARD

CRESSBY & ALLEN

M.C.M.A. DRAFTING ROOM

M.C.M.A. DIRECTORS ROOM

STORE ROOM

WAITING ROOM

EXAMINATION ROOM

DR. SHAW

WASH ROOM

WASH ROOM

CLOS.

CLOS.

CLOS.

SPRINKLER RISER

DOWN

EQUAL

2x4 STUDS

ELEVATOR

4'0" x 5'0" CAR

NEW LIGHT

NEW LIGHT

DOWN

UP

EQUAL

2x4 STUDS

ELEVATOR

Existing Fire Escape

Existing Fire Escape

LEGEND

- Existing Work
- ▨ New Work
- - - Existing Work Removed



NO.	REVISIONS	DATE	BY
SECOND FLOOR PLAN			
SCALE: 1/4" = 1'-0"			
PLANS SHOWING CHANGES IN STAIRS AND ADDITION OF ELEVATOR ENCLOSURE AT THE			
MAINE CHARITABLE MECHANICS ASS'N.			
519 CONGRESS ST. PORTLAND, M.E.			
175	SEP 86	MILLER & BEAL INC.	SHEET
		ARCHITECTS	2
		PORTLAND, MAINE	