


REVISION	DESCRIPTION	DATE
0	ISSUED FOR REVIEW & APPROVAL	7/26/2016

RESERVED FOR CITY STAMP

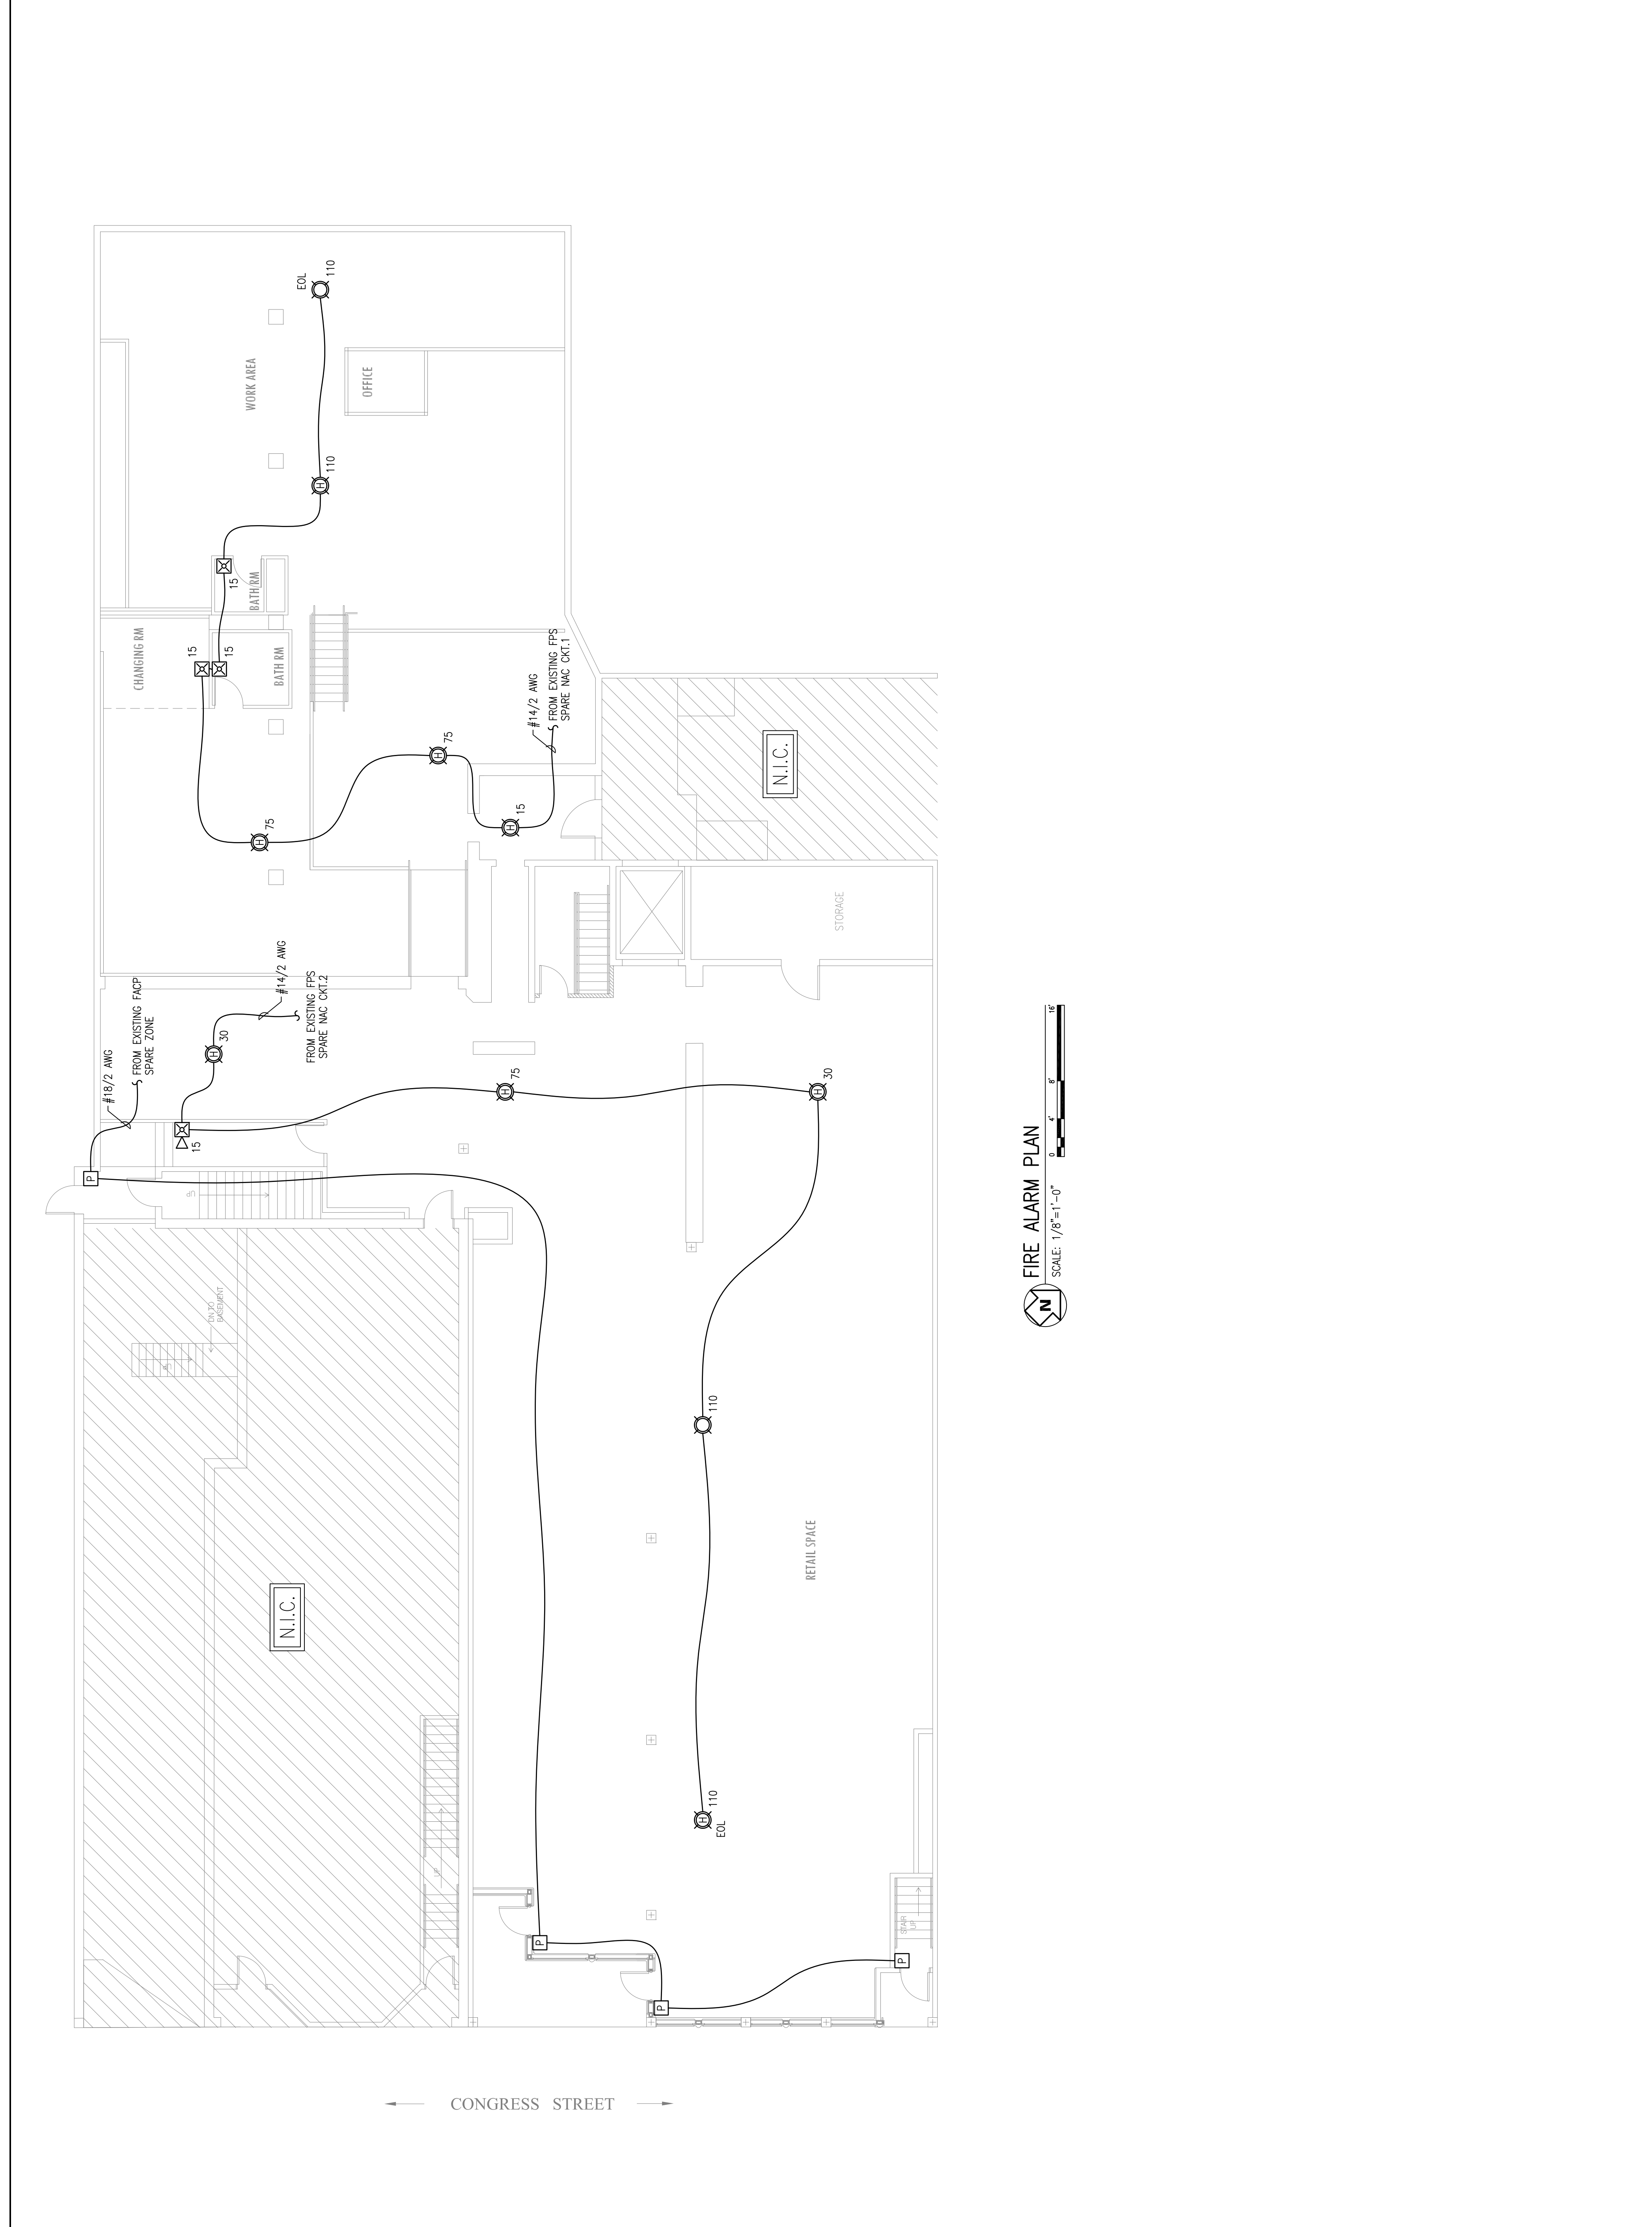

CUNNINGHAM
Security Systems

10 Princes Point Road, Yarmouth, Maine 04096
Office: 207.846.3350 • Fax: 207.846.6080

585 CONGRESS STREET CONDOMINIUM
585 CONGRESS STREET
PORTLAND, MAINE 04101
FIRE ALARM PLAN

DRAWN	JPB UNICAD JOB #16517
CHECKED	WAYNE B. HAWES NCET # 90496
DATE	7/26/2016
REVISION	0
SCALE	1/8" = 1'-0"

FA-2

UNICAD
Inc.
www.unicad.net
100 Main Street
Portland, ME 04101
Office: 603.865.6410