



SIXTH FLOOR
SCALE: 1/8" = 1'-0"

- ELECTRICAL KEYNOTES**
- 1) NEW 15 AMP SINGLE POLE BREAKER IN EXISTING PANEL
 - 2) NEW 20 AMP SINGLE POLE BREAKER IN EXISTING PANEL
 - 3) NEW 30 AMP SINGLE POLE BREAKER IN EXISTING PANEL
 - 4) EXISTING PANEL TO BE REPLACED WITH NEW 14 GA. COPPER

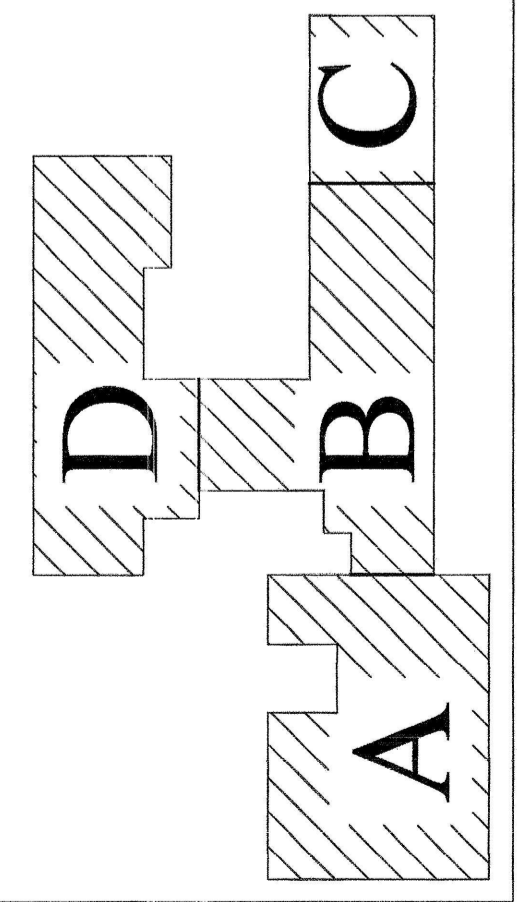


FOREST AVENUE

 KEY PLAN
SCALE: NONE



BID SET
FEBRUARY 4, 2005

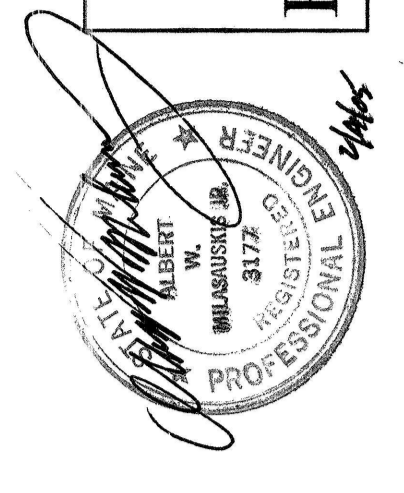

E6

SIXTH FLOOR APARTMENTS
ELECTRICAL MODIFICATIONS AND
NEW FIRE ALARM SYSTEM

Drawing:

Scale: 1/8" = 1'-0"

Date: 2-4-05


Checked: AWM

Drawn: CLC

Project:
RENOVATION OF
CONGRESS SQUARE PLAZA
10 CONGRESS STREET
PORTLAND, MAINE 04101

Architect:
ARCHETYPE, P.A.
ARCHITECTS
48 Union Wharf Portland, Maine 04101
(207) 772-6022 Fax (207) 772-4056

Owner:
HARBOR MANAGEMENT CO.
23 CENTRAL AVENUE
SUITE 710
LYNN, MA 01901

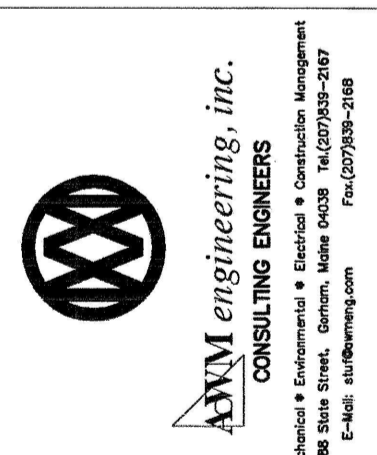

AWM engineering, inc.
CONSULTING ENGINEERS
Maine Professional & Consulting Engineers License No. 3177
State of Maine License No. 3177
48 Union Wharf Portland, Maine 04101
Phone: (207) 772-6022 Fax: (207) 772-4056