



BID SET  
FEBRUARY 4, 2005

E5

FIFTH FLOOR APARTMENTS  
ELECTRICAL MODIFICATIONS AND  
NEW FIRE ALARM SYSTEM


Drawing:

Date: 2-4-05  
Drawn: CLC  
Checked: AWM


Project:  
RENOVATION OF  
CONGRESS SQUARE PLAZA  
10 CONGRESS STREET  
PORTLAND, MAINE 04101

Architect:  
ARCHETYPE, P.A.  
ARCHITECTS  
48 Union Wharf Portland, Maine 04101  
(207) 772-6022 Fax (207) 772-4056

Owner:  
HARBOR MANAGEMENT CO.  
23 CENTRAL AVENUE  
SUITE 710  
LYNN, MA 01901

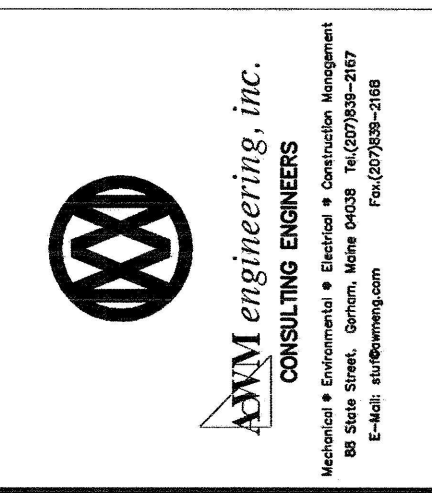


AXM engineering, inc.  
CONSULTING ENGINEERS  
Main Office: 1000 Congress Street, Portland, ME 04101  
Fax: (207) 772-6022

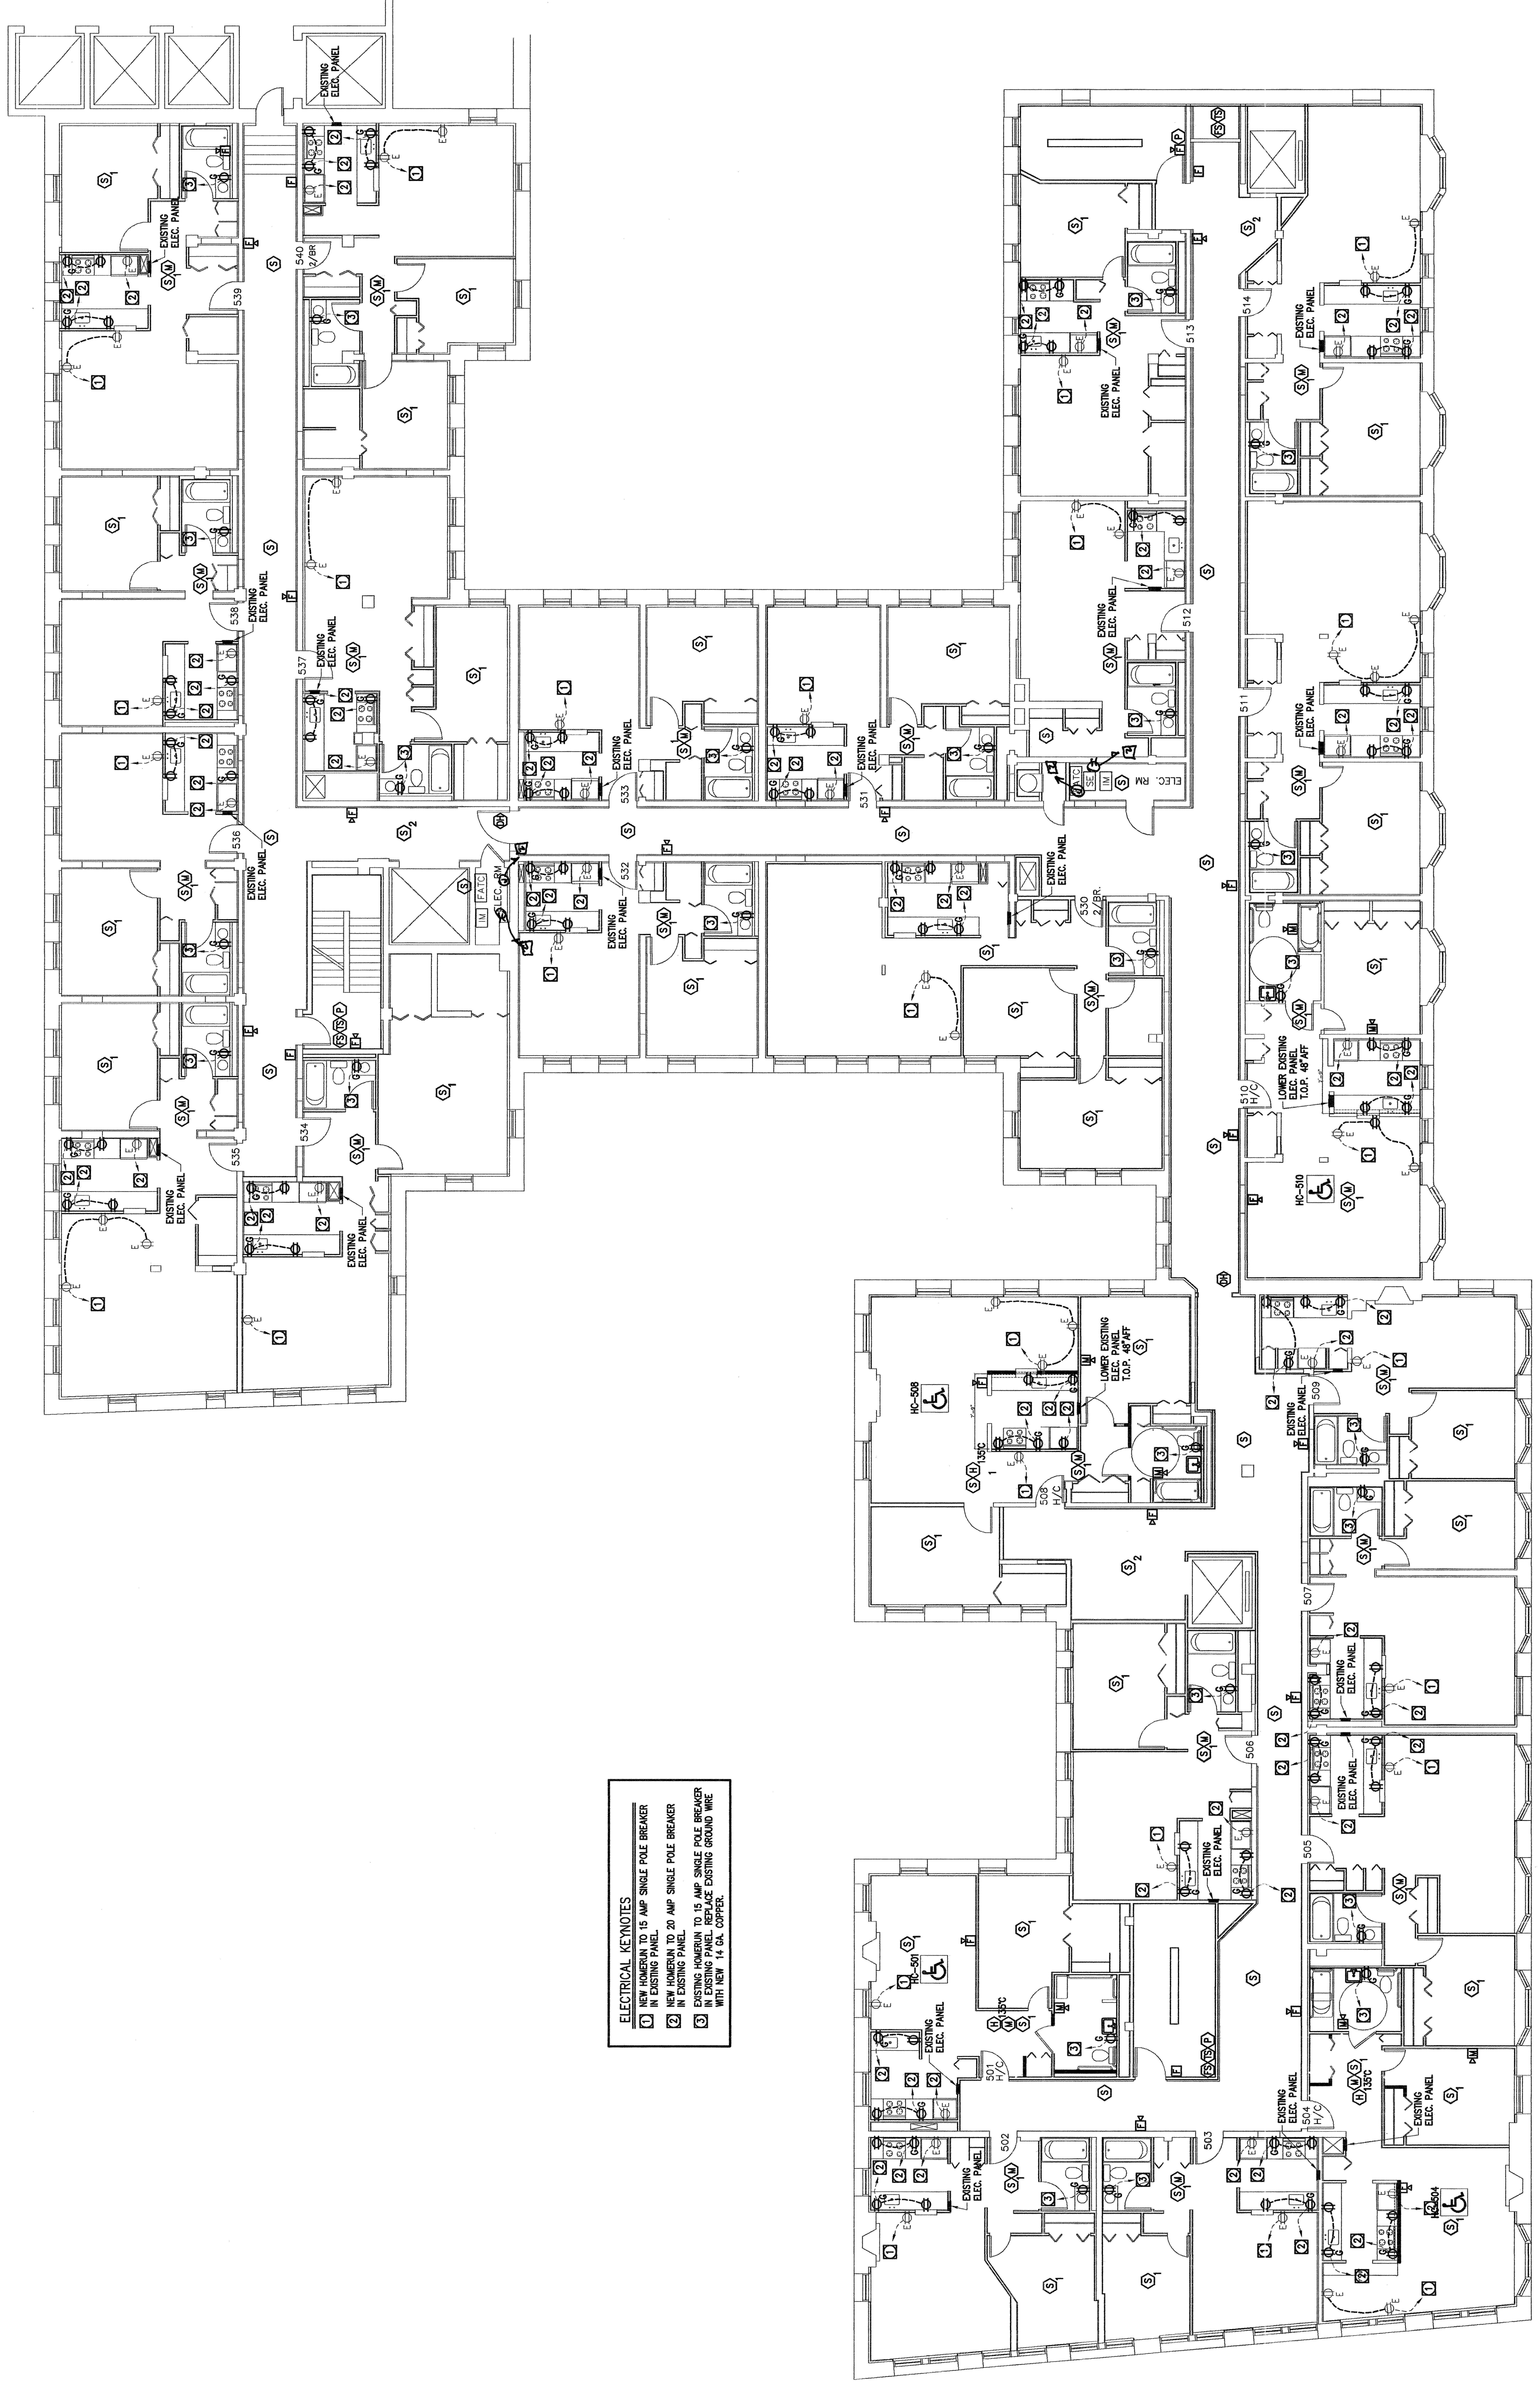

FIFTH FLOOR  
SCALE: 1/8" = 1'-0"

- ELECTRICAL KEYNOTES**
- 1 NEW 15 AMP TO 15 AMP SINGLE POLE BREAKER IN EXISTING PANEL
  - 2 NEW 20 AMP TO 20 AMP SINGLE POLE BREAKER IN EXISTING PANEL
  - 3 EXISTING PANEL TO 15 AMP SINGLE POLE BREAKER IN EXISTING PANEL. REPLACE EXISTING GROUND WIRE WITH NEW 14 GA COPPER.

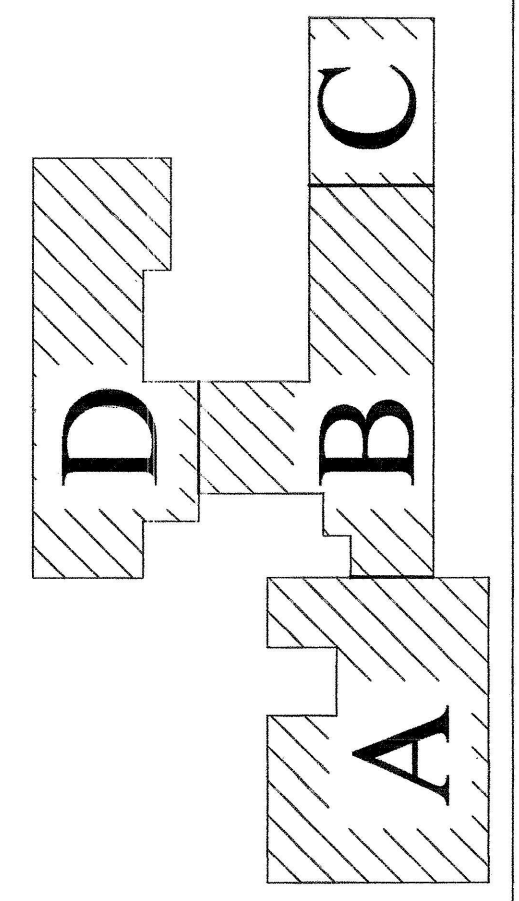

CONGRESS STREET

FOREST AVENUE

KEY PLAN  
SCALE: NONE

