


ELECTRICAL KEYNOTES

- 1 NEW 15 AMP SINGLE POLE BREAKER IN EXISTING PANEL
- 2 NEW 20 AMP SINGLE POLE BREAKER IN EXISTING PANEL
- 3 EXISTING 15 AMP TO 20 AMP SINGLE POLE BREAKER IN EXISTING PANEL
- 4 EXISTING 15 AMP TO 20 AMP SINGLE POLE BREAKER WITH NEW 14 GA. COPPER.

FOURTH FLOOR
SCALE: 1/8" = 1'-0"

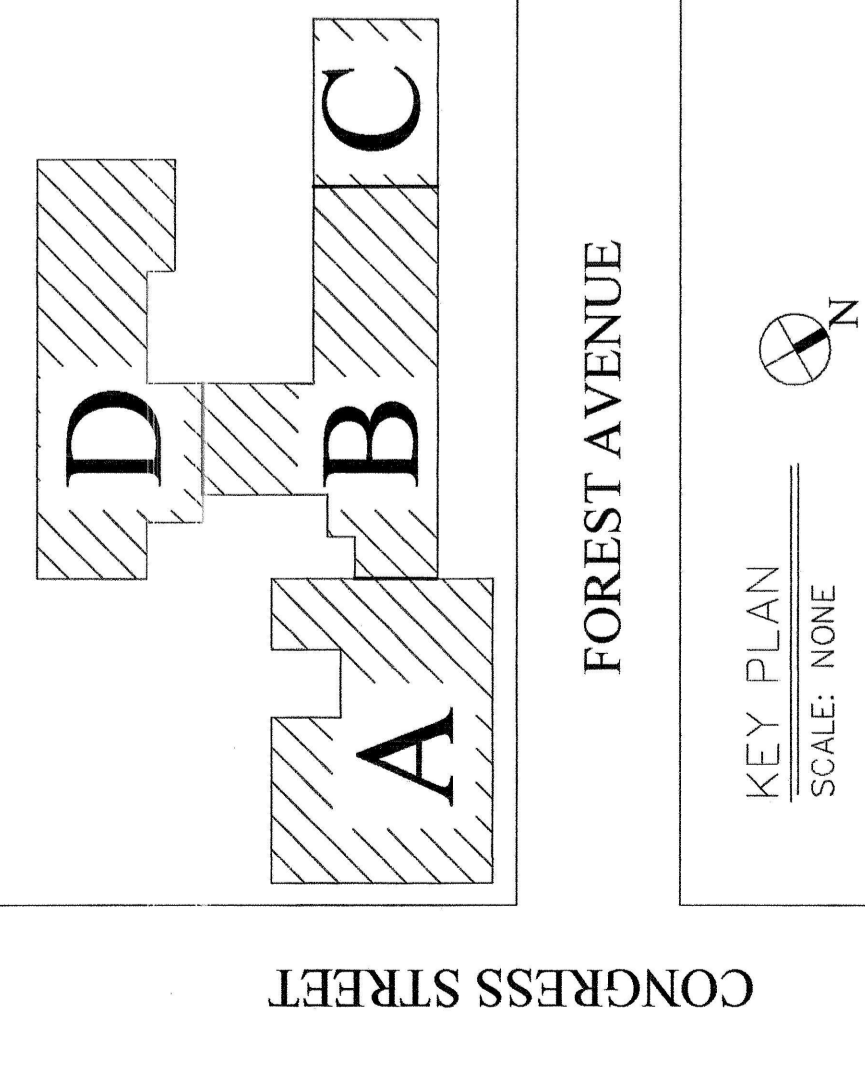

FOREST AVENUE

KEY PLAN
SCALE: NONE

Owner:
HARBOR MANAGEMENT CO.
23 CENTRAL AVENUE
SUITE 710
LYNN, MA 01901

Architect:
ARCHETYPE, P.A.
ARCHITECTS
48 Union Wharf
Portland, Maine 04101
(207) 772-6022 Fax (207) 772-4056

Project:
**RENOVATION OF
CONGRESS SQUARE PLAZA
10 CONGRESS STREET
PORTLAND, MAINE 04101**

Date: 2-4-05
Drawn: CLC

Scale: 1/8" = 1'-0"
Checked: AWM

Drawing:
**FOURTH FLOOR APARTMENTS
ELECTRICAL MODIFICATIONS AND
NEW FIRE ALARM SYSTEM**



BID
SET
FEBRUARY 4, 2005

E4