


ELECTRICAL KEYNOTES

- ① NEW 15 AMP SINGLE POLE BREAKER IN EXISTING PANEL
- ② NEW 20 AMP SINGLE POLE BREAKER IN EXISTING PANEL
- ③ EXISTING 15 AMP SINGLE POLE BREAKER IN EXISTING PANEL
- ④ EXISTING 20 AMP SINGLE POLE BREAKER IN EXISTING PANEL
- ⑤ NEW 14 GA. COPPER

THIRD FLOOR
SCALE: 1/8" = 1'-0"

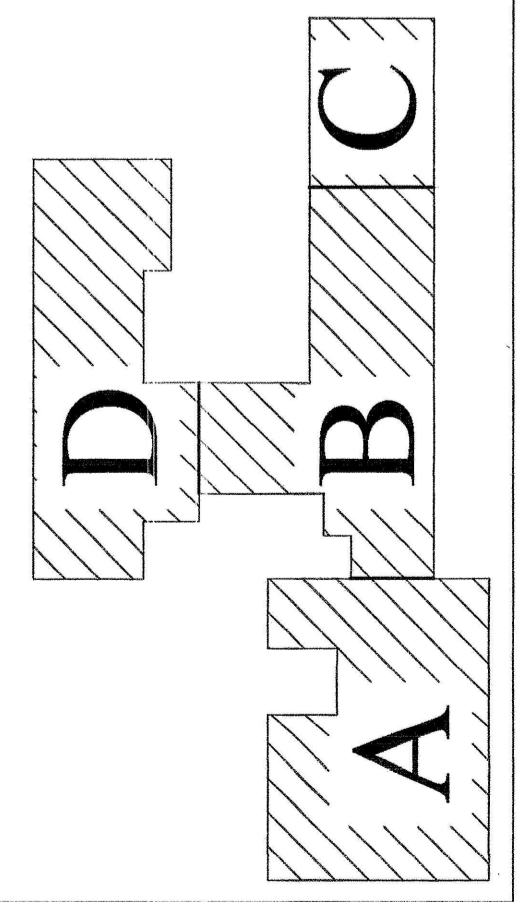

FOREST AVENUE

KEY PLAN
SCALE: NONE

BID SET
FEBRUARY 4, 2005



THIRD FLOOR APARTMENTS
ELECTRICAL MODIFICATIONS AND
NEW FIRE ALARM SYSTEM

E3

Drawing:

Scale: 1/8" = 1'-0"

Date: 2-4-05

Drawn: CLC

Checked: AMM

Project:

RENOVATION OF
CONGRESS SQUARE PLAZA
10 CONGRESS STREET
PORTLAND, MAINE 04101

Architect:

ARCHETYPE, P.A.
ARCHITECTS
48 Union Wharf Portland, Maine 04101
(207) 772-6022 Fax (207) 772-4056

Owner:

HARBOR MANAGEMENT CO.
23 CENTRAL AVENUE
SUITE 710
LYNN, MA 01901

