


ELECTRICAL KEYNOTES

- 1 NEW HANGER TO 15 AMP SINGLE POLE BREAKER IN EXISTING PANEL.
- 2 NEW HANGER TO 20 AMP SINGLE POLE BREAKER IN EXISTING PANEL.
- 3 NEW HANGER TO 15 AMP SINGLE POLE BREAKER IN EXISTING PANEL. REPLACE EXISTING GROUND WIRE WITH NEW 14 GA. COPPER.

SECOND FLOOR
SCALE: 1/8" = 1'-0"

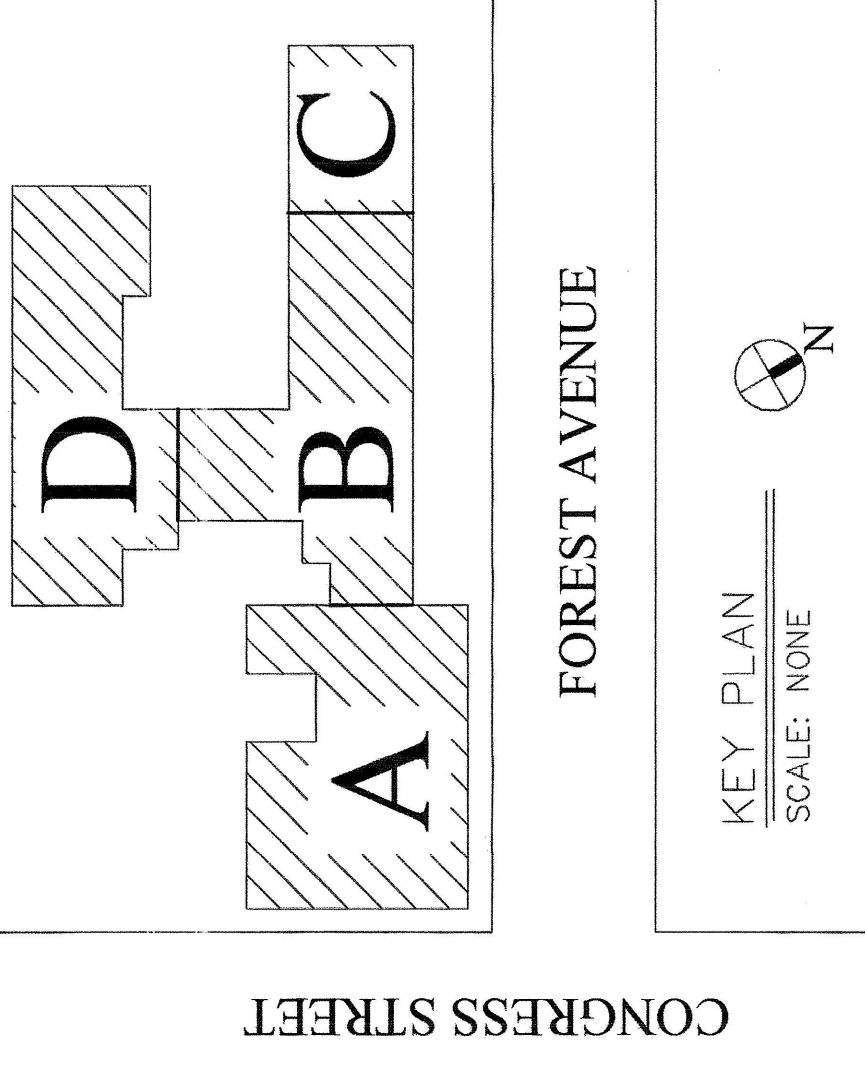

BID SET
FEBRUARY 4, 2005



E2

Project: SECOND FLOOR APARTMENTS
ELECTRICAL MODIFICATIONS AND
NEW FIRE ALARM SYSTEM

Date: 2-4-05
Scale: 1/8" = 1'-0"
Drawn: CLC
Checked: AWM

Project: RENOVATION OF
CONGRESS SQUARE PLAZA
10 CONGRESS STREET
PORTLAND, MAINE 04101

Architect: ARCHETYPE, P.A.
ARCHITECTS
48 Union Wharf Portland, Maine 04101
(207) 772-6022 Fax (207) 772-4056

Owner: HARBOR MANAGEMENT CO.
23 CENTRAL AVENUE
SUITE 710
LYNN, MA 01901



FOREST AVENUE
KEY PLAN
SCALE: NONE