


ELECTRICAL KEYNOTES

- 1 15 AMP SINGLE POLE BREAKER
- 2 20 AMP SINGLE POLE BREAKER
- 3 30 AMP SINGLE POLE BREAKER
- 4 40 AMP SINGLE POLE BREAKER
- 5 50 AMP SINGLE POLE BREAKER
- 6 60 AMP SINGLE POLE BREAKER
- 7 75 AMP SINGLE POLE BREAKER
- 8 100 AMP SINGLE POLE BREAKER
- 9 125 AMP SINGLE POLE BREAKER
- 10 150 AMP SINGLE POLE BREAKER
- 11 200 AMP SINGLE POLE BREAKER
- 12 250 AMP SINGLE POLE BREAKER
- 13 300 AMP SINGLE POLE BREAKER
- 14 400 AMP SINGLE POLE BREAKER
- 15 500 AMP SINGLE POLE BREAKER
- 16 600 AMP SINGLE POLE BREAKER
- 17 800 AMP SINGLE POLE BREAKER
- 18 1000 AMP SINGLE POLE BREAKER
- 19 1200 AMP SINGLE POLE BREAKER
- 20 1500 AMP SINGLE POLE BREAKER
- 21 2000 AMP SINGLE POLE BREAKER
- 22 2500 AMP SINGLE POLE BREAKER
- 23 3000 AMP SINGLE POLE BREAKER
- 24 4000 AMP SINGLE POLE BREAKER
- 25 5000 AMP SINGLE POLE BREAKER
- 26 6000 AMP SINGLE POLE BREAKER
- 27 8000 AMP SINGLE POLE BREAKER
- 28 10000 AMP SINGLE POLE BREAKER
- 29 12000 AMP SINGLE POLE BREAKER
- 30 15000 AMP SINGLE POLE BREAKER
- 31 20000 AMP SINGLE POLE BREAKER
- 32 25000 AMP SINGLE POLE BREAKER
- 33 30000 AMP SINGLE POLE BREAKER
- 34 40000 AMP SINGLE POLE BREAKER
- 35 50000 AMP SINGLE POLE BREAKER
- 36 60000 AMP SINGLE POLE BREAKER
- 37 80000 AMP SINGLE POLE BREAKER
- 38 100000 AMP SINGLE POLE BREAKER
- 39 120000 AMP SINGLE POLE BREAKER
- 40 150000 AMP SINGLE POLE BREAKER
- 41 200000 AMP SINGLE POLE BREAKER
- 42 250000 AMP SINGLE POLE BREAKER
- 43 300000 AMP SINGLE POLE BREAKER
- 44 400000 AMP SINGLE POLE BREAKER
- 45 500000 AMP SINGLE POLE BREAKER
- 46 600000 AMP SINGLE POLE BREAKER
- 47 800000 AMP SINGLE POLE BREAKER
- 48 1000000 AMP SINGLE POLE BREAKER
- 49 1200000 AMP SINGLE POLE BREAKER
- 50 1500000 AMP SINGLE POLE BREAKER
- 51 2000000 AMP SINGLE POLE BREAKER
- 52 2500000 AMP SINGLE POLE BREAKER
- 53 3000000 AMP SINGLE POLE BREAKER
- 54 4000000 AMP SINGLE POLE BREAKER
- 55 5000000 AMP SINGLE POLE BREAKER
- 56 6000000 AMP SINGLE POLE BREAKER
- 57 8000000 AMP SINGLE POLE BREAKER
- 58 10000000 AMP SINGLE POLE BREAKER
- 59 12000000 AMP SINGLE POLE BREAKER
- 60 15000000 AMP SINGLE POLE BREAKER
- 61 20000000 AMP SINGLE POLE BREAKER
- 62 25000000 AMP SINGLE POLE BREAKER
- 63 30000000 AMP SINGLE POLE BREAKER
- 64 40000000 AMP SINGLE POLE BREAKER
- 65 50000000 AMP SINGLE POLE BREAKER
- 66 60000000 AMP SINGLE POLE BREAKER
- 67 80000000 AMP SINGLE POLE BREAKER
- 68 100000000 AMP SINGLE POLE BREAKER
- 69 120000000 AMP SINGLE POLE BREAKER
- 70 150000000 AMP SINGLE POLE BREAKER
- 71 200000000 AMP SINGLE POLE BREAKER
- 72 250000000 AMP SINGLE POLE BREAKER
- 73 300000000 AMP SINGLE POLE BREAKER
- 74 400000000 AMP SINGLE POLE BREAKER
- 75 500000000 AMP SINGLE POLE BREAKER
- 76 600000000 AMP SINGLE POLE BREAKER
- 77 800000000 AMP SINGLE POLE BREAKER
- 78 1000000000 AMP SINGLE POLE BREAKER
- 79 1200000000 AMP SINGLE POLE BREAKER
- 80 1500000000 AMP SINGLE POLE BREAKER
- 81 2000000000 AMP SINGLE POLE BREAKER
- 82 2500000000 AMP SINGLE POLE BREAKER
- 83 3000000000 AMP SINGLE POLE BREAKER
- 84 4000000000 AMP SINGLE POLE BREAKER
- 85 5000000000 AMP SINGLE POLE BREAKER
- 86 6000000000 AMP SINGLE POLE BREAKER
- 87 8000000000 AMP SINGLE POLE BREAKER
- 88 10000000000 AMP SINGLE POLE BREAKER
- 89 12000000000 AMP SINGLE POLE BREAKER
- 90 15000000000 AMP SINGLE POLE BREAKER
- 91 20000000000 AMP SINGLE POLE BREAKER
- 92 25000000000 AMP SINGLE POLE BREAKER
- 93 30000000000 AMP SINGLE POLE BREAKER
- 94 40000000000 AMP SINGLE POLE BREAKER
- 95 50000000000 AMP SINGLE POLE BREAKER
- 96 60000000000 AMP SINGLE POLE BREAKER
- 97 80000000000 AMP SINGLE POLE BREAKER
- 98 100000000000 AMP SINGLE POLE BREAKER
- 99 120000000000 AMP SINGLE POLE BREAKER
- 100 150000000000 AMP SINGLE POLE BREAKER

FIRST FLOOR
SCALE: 1/8" = 1'-0"

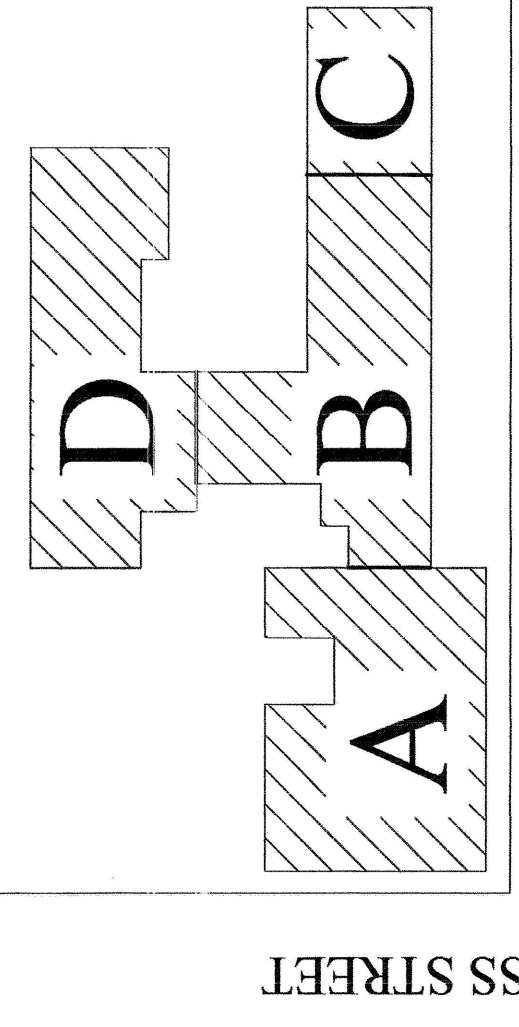

KEY PLAN
SCALE: NONE

BID SET
FEBRUARY 4, 2005



Project:
RENOVATION OF
CONGRESS SQUARE PLAZA
10 CONGRESS STREET
PORTLAND, MAINE 04101

Architect:
ARCHETYPE, P.A.
ARCHITECTS
48 Union Wharf Portland, Maine 04101
(207) 772-6022 Fax (207) 772-4056

Owner:
HARBOR MANAGEMENT CO.
23 CENTRAL AVENUE
SUITE 710
LYNN, MA 01901

Contractor:
AWM engineering, inc.
CONSULTING ENGINEERS
1000 State Street, Suite 200
Portland, ME 04101
Tel: (207) 772-2247
Fax: (207) 772-2248

Date: 2-4-05
Scale: 1/8" = 1'-0"
Drawn: CLC
Checked: AWM

Drawing:
FIRST FLOOR APARTMENTS
ELECTRICAL MODIFICATIONS AND
NEW FIRE ALARM SYSTEM

E1