

REVISION	DESCRIPTION	DATE
0	ISSUED FOR REVIEW & APPROVAL	1/30/2017

**CUNNINGHAM**

**Security Systems**

10 Princes Point Road, Yarmouth, Maine 04096  
Office: 207.846.3350 • Fax: 207.846.6080


**PORTLAND, MAINE 04101**  
**SECOND FLOOR FIRE ALARM PLAN**

**24 PEBBLE STREET**

JOB	UNICAD JOB #17018
DRAWN	WAYNE B. HAWES
CHECKED	NGEET N. 90496
DATE	1/30/2017
REVISION	0
SCALE	AS NOTED

**FA-4**

**UNICAD** Inc.  
278 W. 400th St.  
Portland, ME 04106  
www.unicad.net

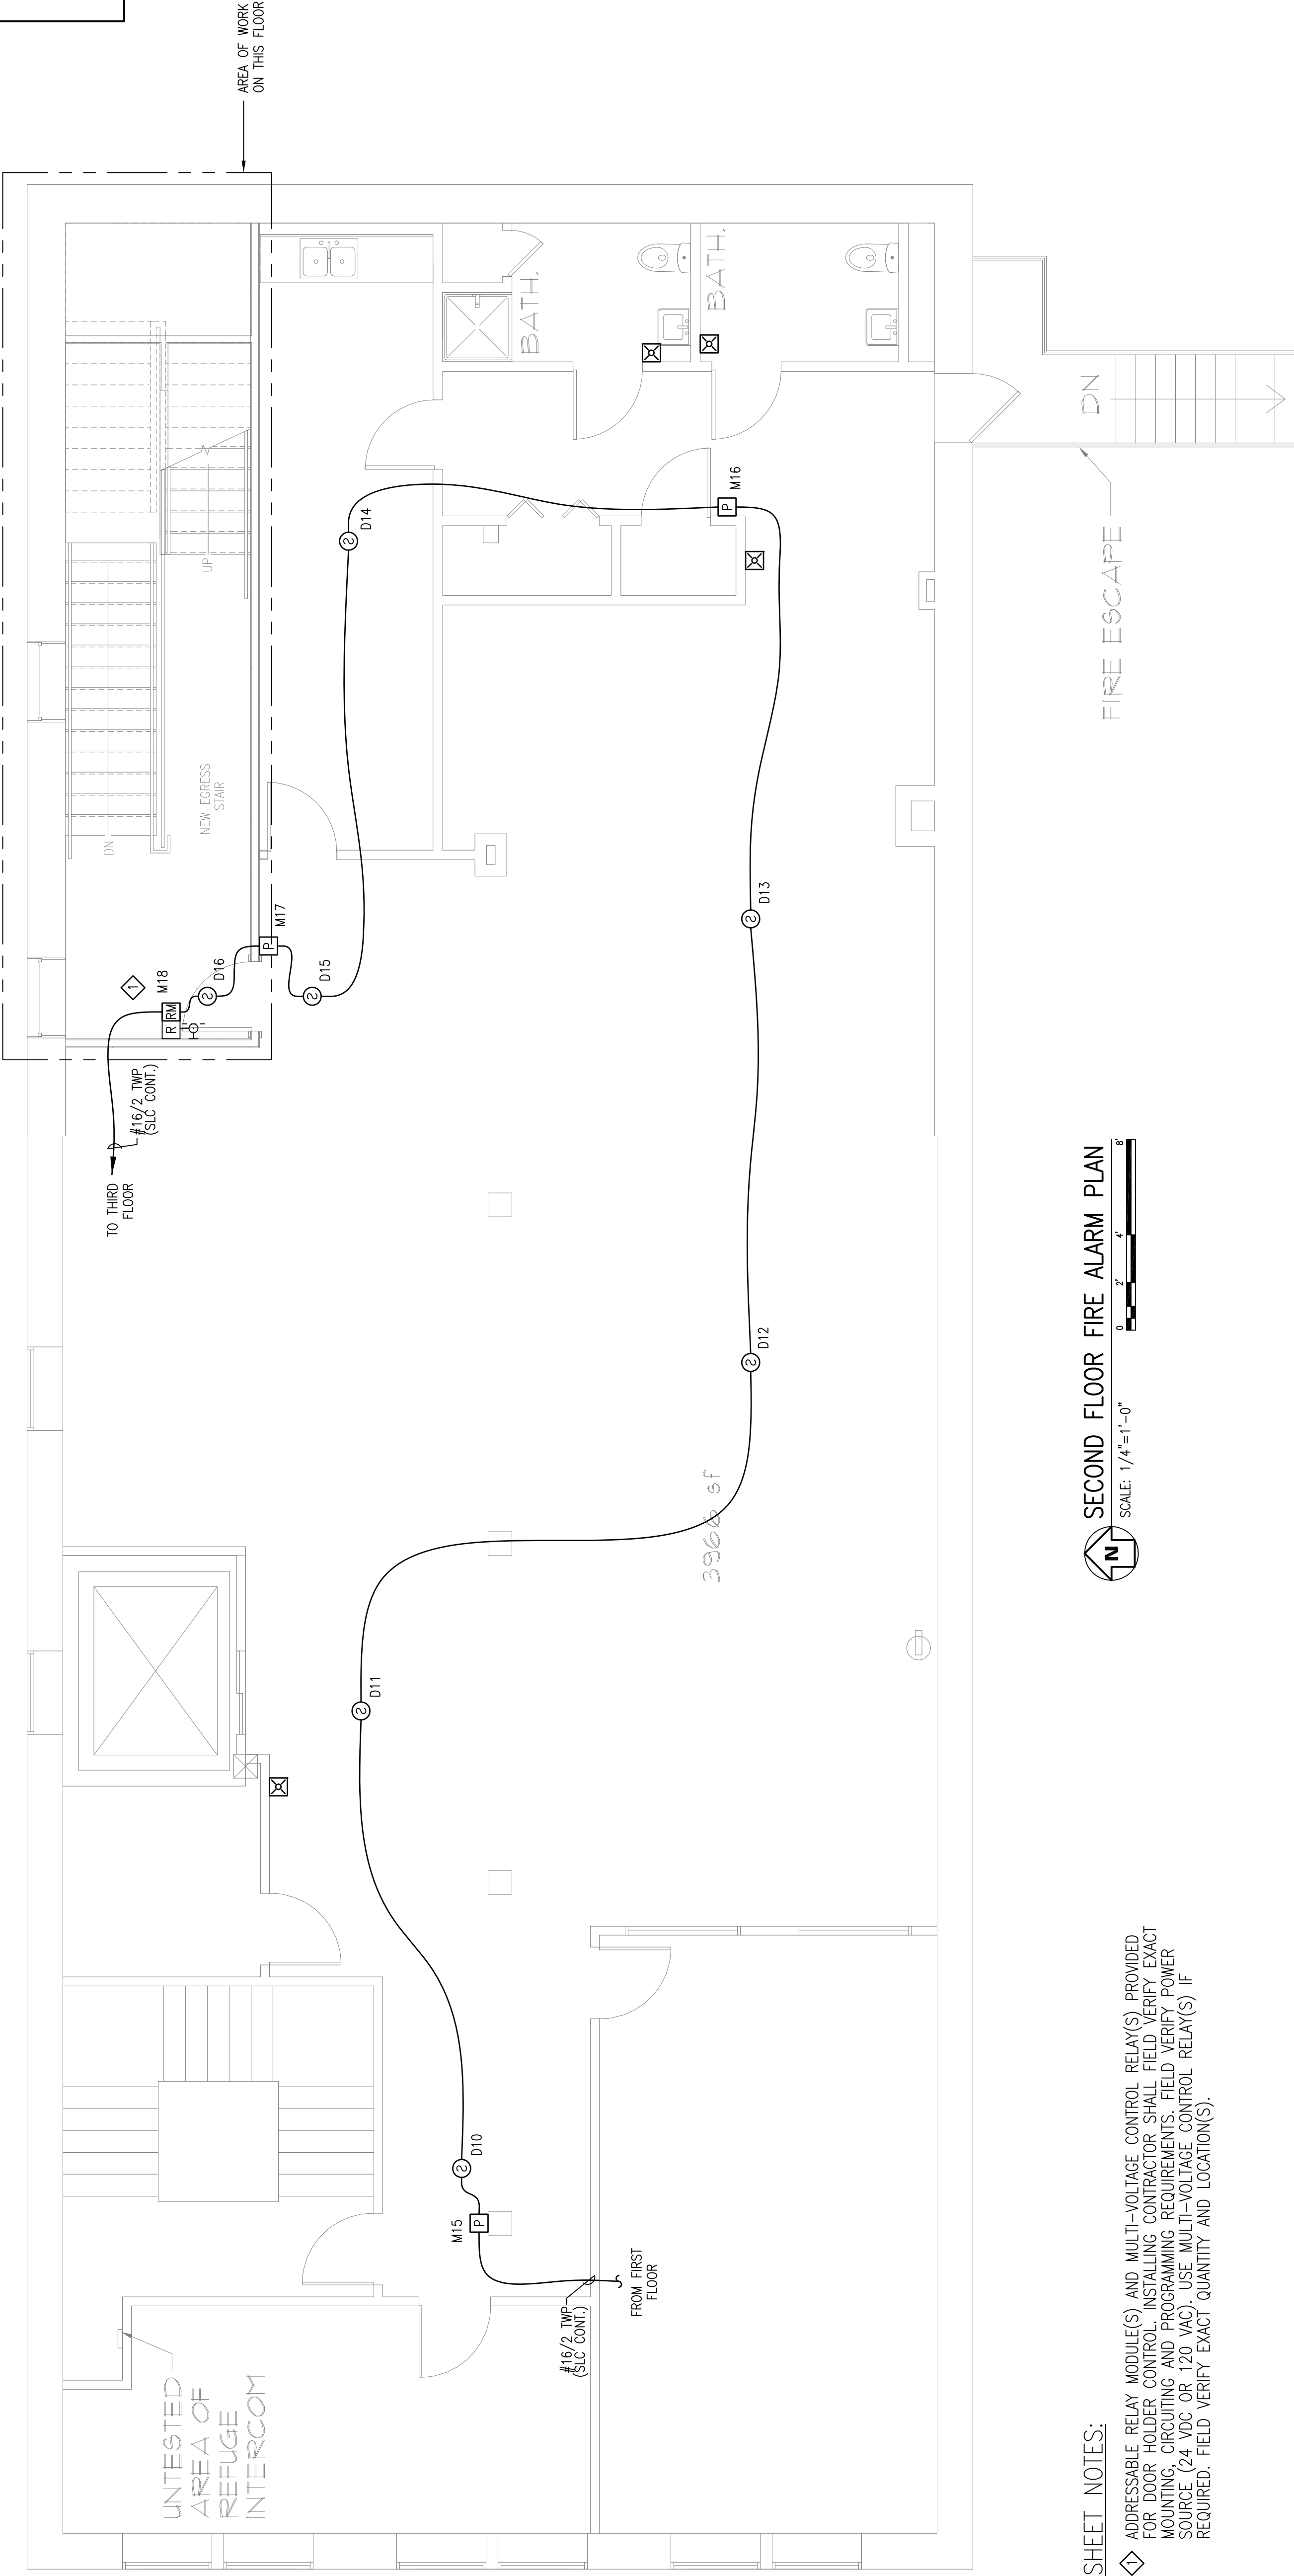

RESERVED FOR CITY STAMP

AREA OF WORK  
ON THIS FLOOR

**SECOND FLOOR FIRE ALARM PLAN**  
SCALE: 1/4"=1'-0"

**SHEET NOTES:**  
◇ ADDRESSABLE RELAY MODULE(S) AND MULTI-VOLTAGE CONTROL RELAY(S) PROVIDED FOR DOOR HOLDER CONTROL. INSTALLING CONTRACTOR SHALL FIELD VERIFY EXACT MOUNTING, CIRCUITING AND PROGRAMMING REQUIREMENTS. FIELD VERIFY POWER SOURCE (24 VDC OR 120 VAC). USE MULTI-VOLTAGE CONTROL RELAY(S) IF REQUIRED. FIELD VERIFY EXACT QUANTITY AND LOCATION(S).

**DEVICE NOTE:**  
- EXISTING SMOKE DETECTORS AND PULL STATIONS ARE TO BE REPLACED WITH NEW ADDRESSABLE DEVICES.  
- EXISTING NOTIFICATION TO REMAIN AS IS.  
- NEW REAR STAIRWELL FIRE DOOR, DOOR HOLDER AND SMOKE DETECTOR(S).