

REVISION	DESCRIPTION	DATE
0	ISSUED FOR REVIEW & APPROVAL	1/30/2017

DATE	DESCRIPTION	DATE

**CUNNINGHAM**

**Security Systems**

10 Princes Point Road, Yarmouth, Maine 04096  
Office: 207.846.3350 • Fax: 207.846.6080


**PORTLAND, MAINE 04101  
THIRD FLOOR FIRE ALARM PLAN**

**24 PEBBLE STREET**

DRAWN	JPB UNICAD JOB #17018
CHECKED	WAYNE B. HAWES NICET # 90496
DATE	1/30/2017
REVISION	0
SCALE	AS NOTED

**FA-5**

**UNICAD** Inc.  
Fire Alarm Design & Drafting Services  
www.unicad.net  
578 W. 40th St.  
Portland, ME 04102  
Office: 603.865.6410

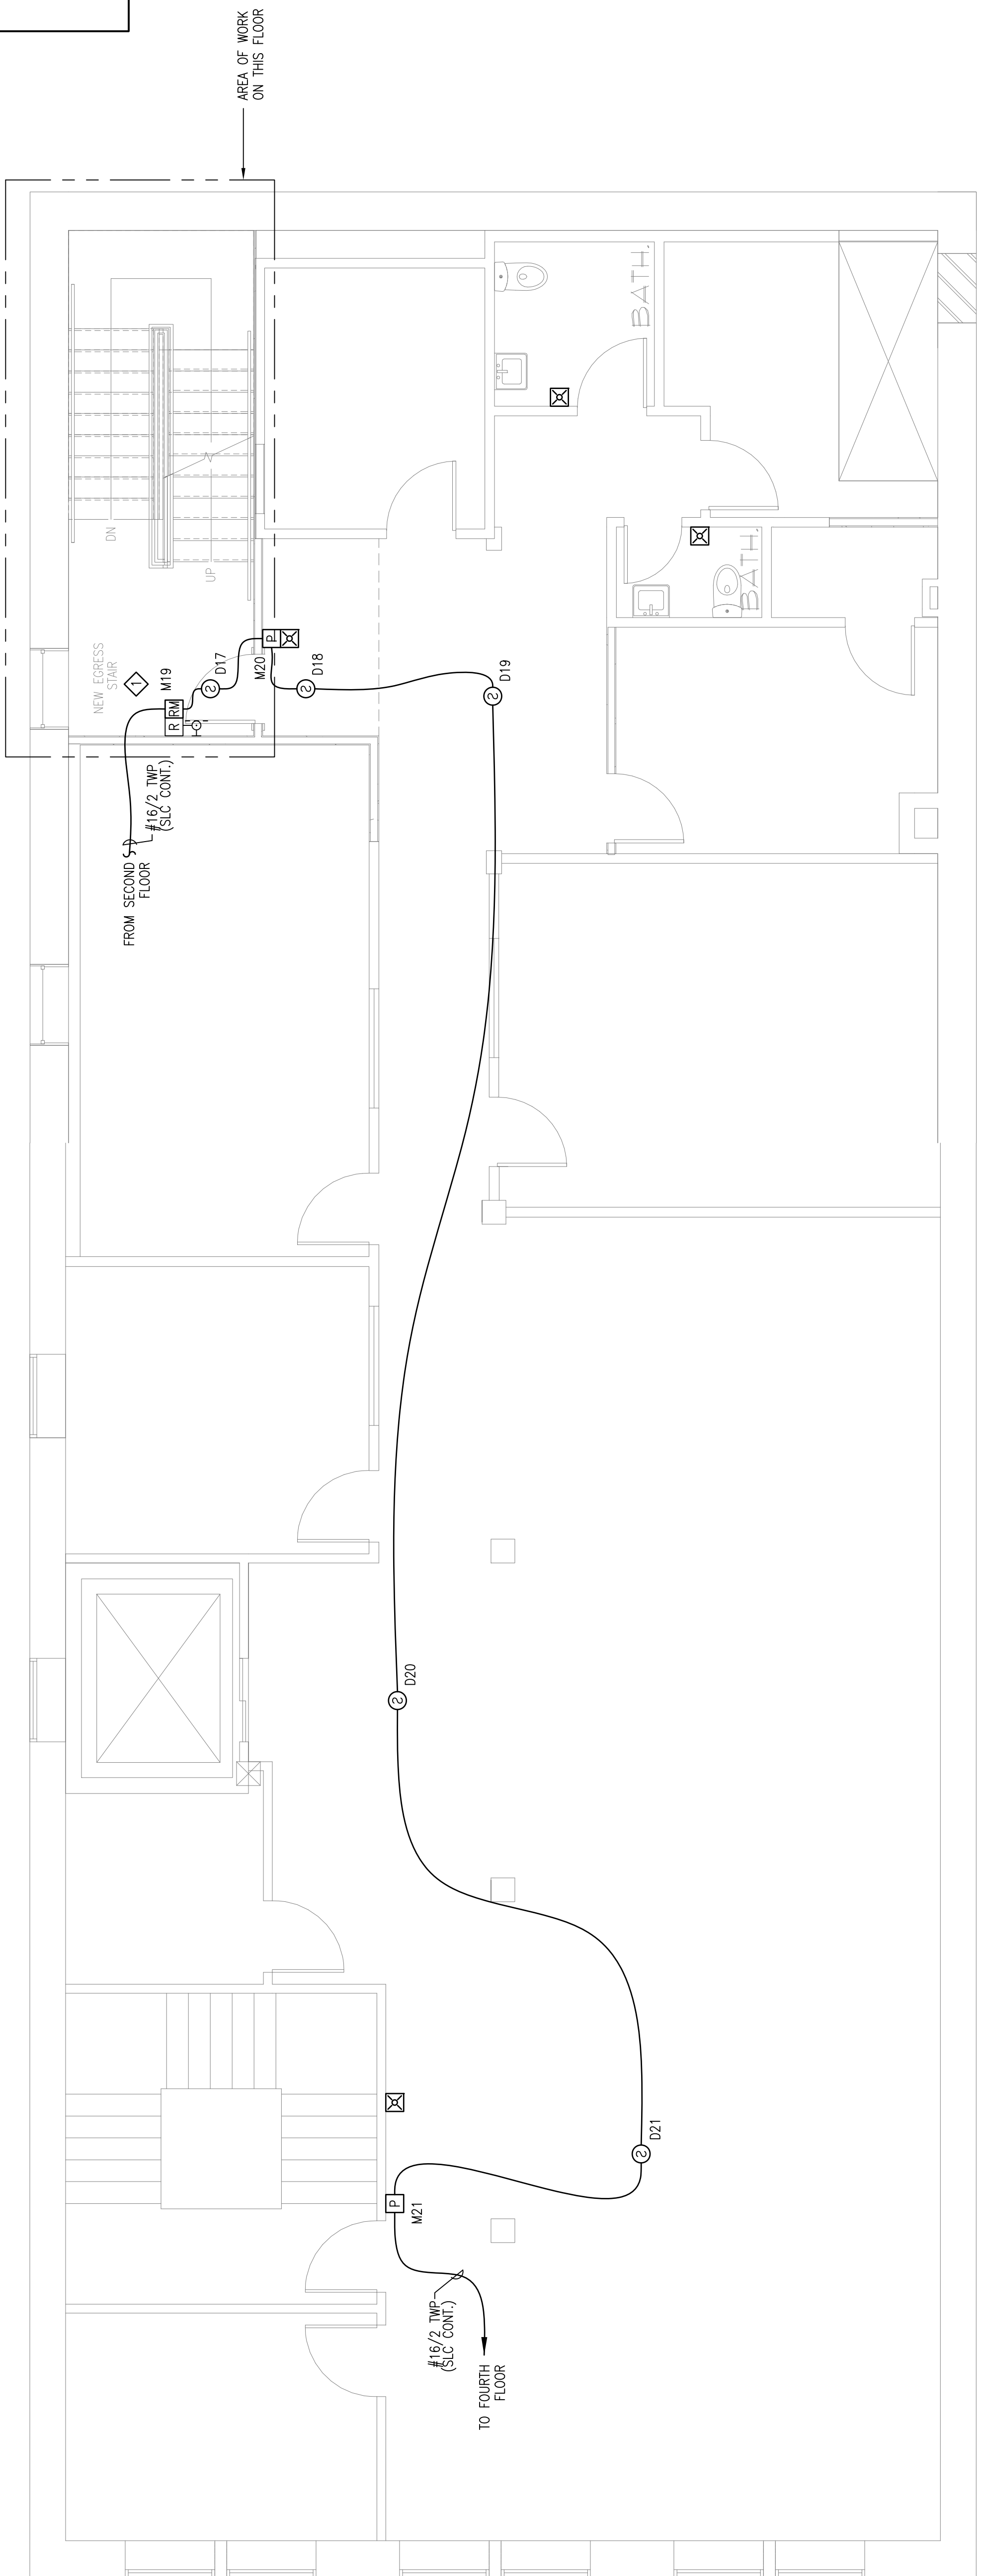

RESERVED FOR CITY STAMP

AREA OF WORK ON THIS FLOOR

FROM SECOND FLOOR  
#16/2 TWP (SLC CONT.)

NEW EGRESS STAIR

DN

UP

M19

FD

D17

M20

D18

D19

D20

D21

M21

FD

BATH

BATH

**DEVICE NOTE:**  
 - EXISTING SMOKE DETECTORS AND PULL STATIONS ARE TO BE REPLACED WITH NEW ADDRESSABLE DEVICES.  
 - EXISTING NOTIFICATION TO REMAIN AS IS.  
 - NEW REAR STAIRWELL FIRE DOOR, DOOR HOLDER AND SMOKE DETECTOR(S).

**THIRD FLOOR FIRE ALARM PLAN**  
SCALE: 1/4"=1'-0"

**SHEET NOTES:**  
 ◆ ADDRESSABLE RELAY MODULE(S) AND MULTI-VOLTAGE CONTROL RELAY(S) PROVIDED FOR DOOR HOLDER CONTROL. INSTALLING CONTRACTOR SHALL FIELD VERIFY EXACT MOUNTING, CIRCUITING AND PROGRAMMING REQUIREMENTS. FIELD VERIFY POWER SOURCE (24 VDC OR 120 VAC). USE MULTI-VOLTAGE CONTROL RELAY(S) IF REQUIRED. FIELD VERIFY EXACT QUANTITY AND LOCATION(S).