

REVISION	DESCRIPTION	DATE
0	ISSUED FOR REVIEW & APPROVAL	1/30/2017


RESERVED FOR CITY STAMP

CUNNINGHAM
 Security Systems
 10 Princes Point Road, Yarmouth, Maine 04096
 Office: 207.846.3350 • Fax: 207.846.6080

PORTLAND, MAINE 04101
FOURTH FLOOR FIRE ALARM PLAN
24 PEBBLE STREET

DRAWN	JPB UNICAD JOB #17018
CHECKED	WAYNE B. HAWES NCEET # 90496
DATE	1/30/2017
REVISION	0
SCALE	AS NOTED

FA-6

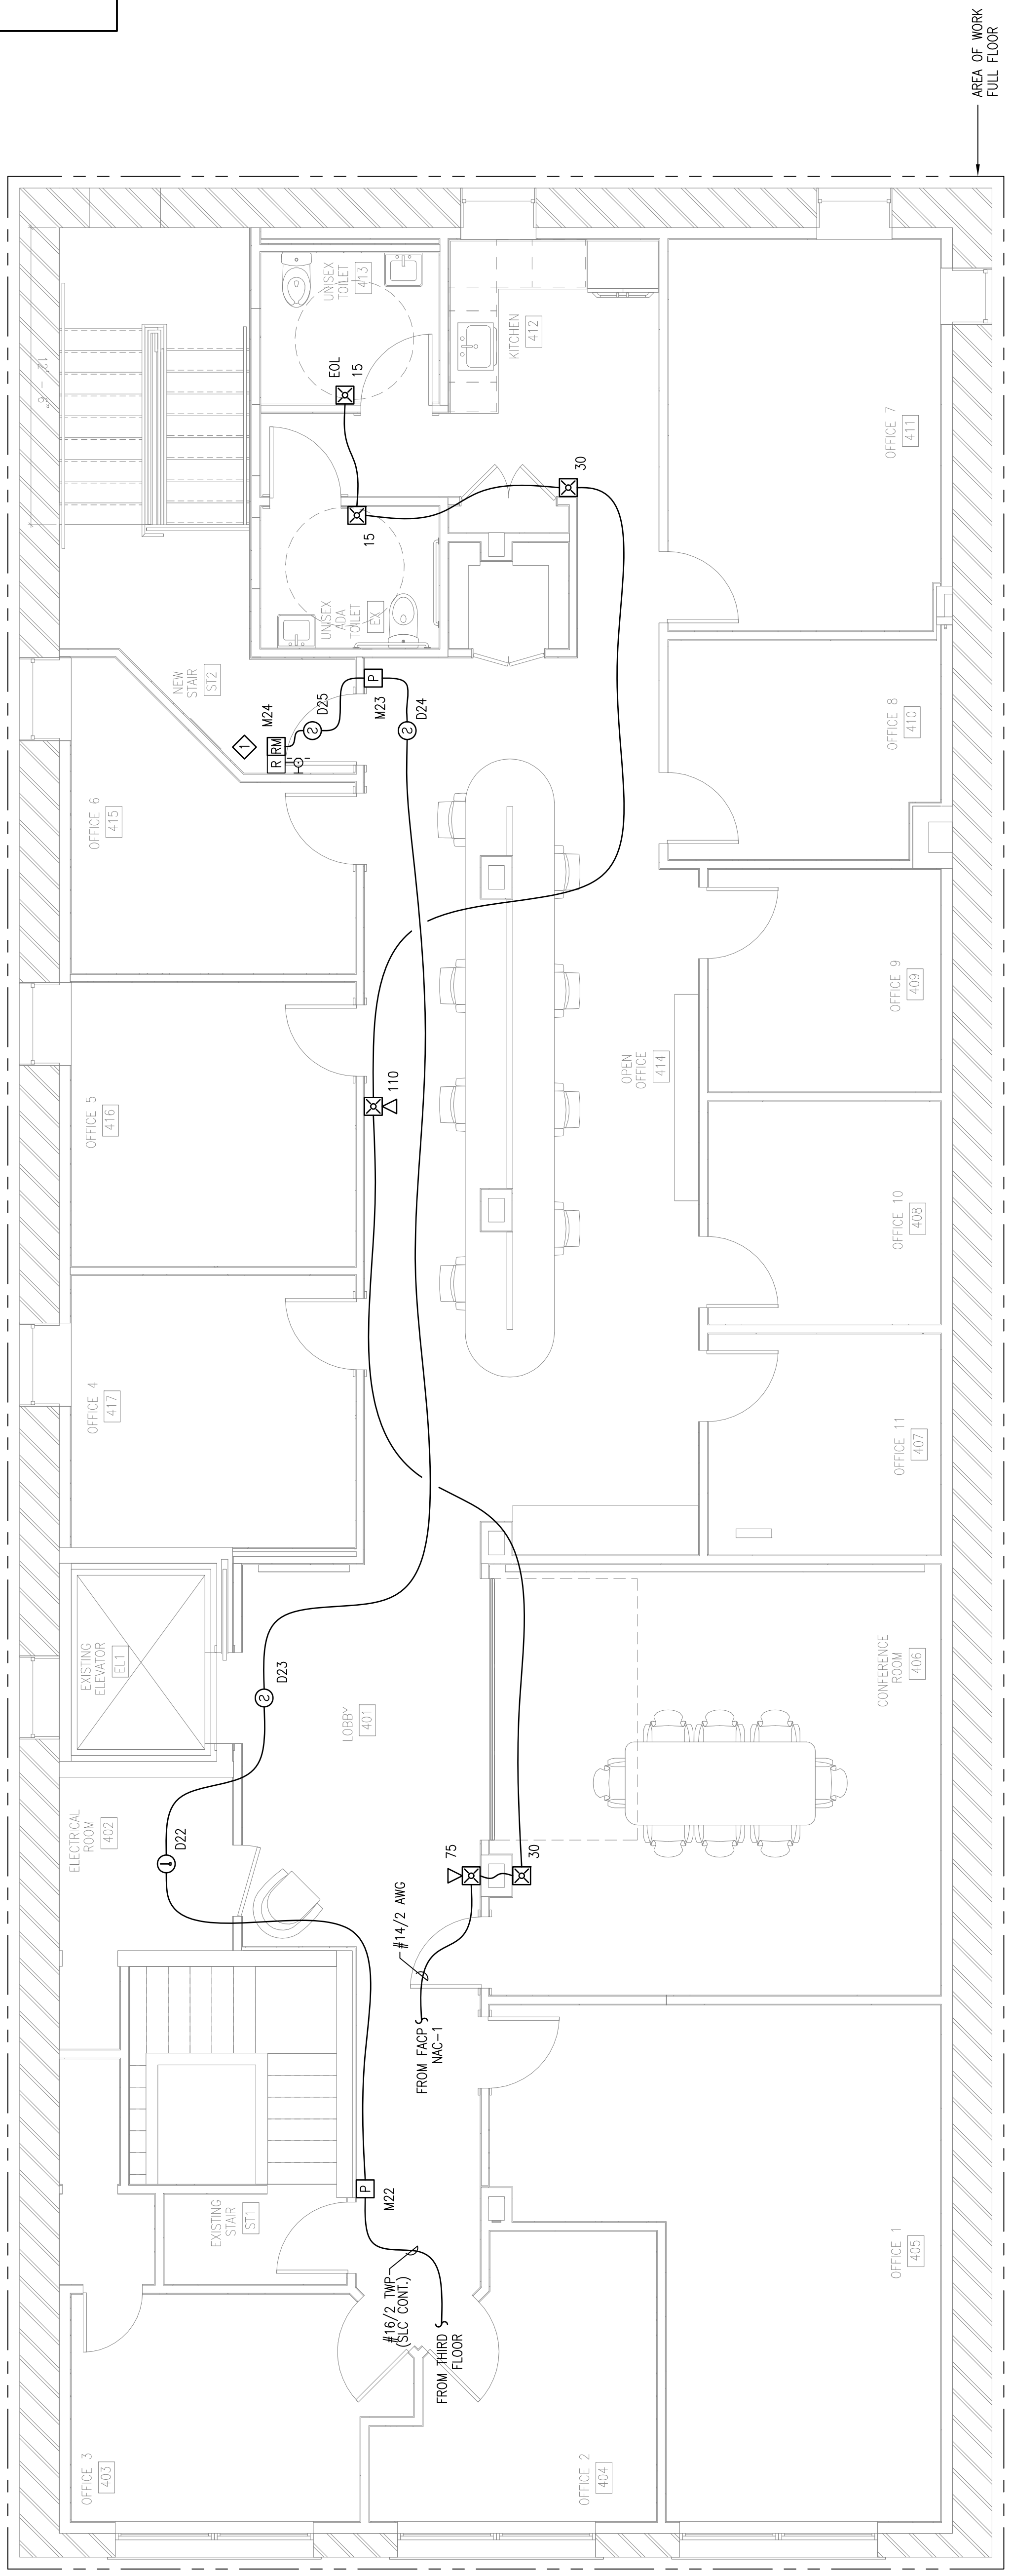

FOURTH FLOOR FIRE ALARM PLAN
 SCALE: 1/4"=1'-0"

DEVICE NOTE:
 - MAIN AREA OF WORK, FULL FLOOR RENOVATION, FULL FLOOR FIRE ALARM SYSTEM UPGRADE.

SHEET NOTES:

- ◇ ADDRESSABLE RELAY MODULE(S) AND MULTI-VOLTAGE CONTROL RELAY(S) PROVIDED FOR DOOR HOLDER CONTROL. INSTALLING CONTRACTOR SHALL FIELD VERIFY EXACT MOUNTING, CIRCUITING AND PROGRAMMING REQUIREMENTS. FIELD VERIFY POWER SOURCE (24 VDC OR 120 VAC). USE MULTI-VOLTAGE CONTROL RELAY(S) IF REQUIRED. FIELD VERIFY EXACT QUANTITY AND LOCATION(S).