


Common Colo Rack Space (Locked Racks)

CoLo Rack	CoLo Rack	CoLo Rack	CoLo Rack
CoLo Rack	CoLo Rack	CoLo Rack	CoLo Rack
CoLo Rack	CoLo Rack	CoLo Rack	CoLo Rack
CoLo Rack	CoLo Rack	CoLo Rack	CoLo Rack

CoLo Rack	CoLo Rack	Room	CoLo Rack	CoLo Rack	CoLo Rack	Room	CoLo Rack	CoLo Rack	Room	CoLo Rack	CoLo Rack
14'0" x 10'10.5"	14'0" x 10'10.5"	14'0" x 10'10.5"	14'0" x 10'10.5"	14'0" x 10'10.5"	14'0" x 10'10.5"	14'0" x 10'10.5"	14'0" x 10'10.5"	14'0" x 10'10.5"	14'0" x 10'10.5"	14'0" x 10'10.5"	14'0" x 10'10.5"


18" Raised Computer Floor

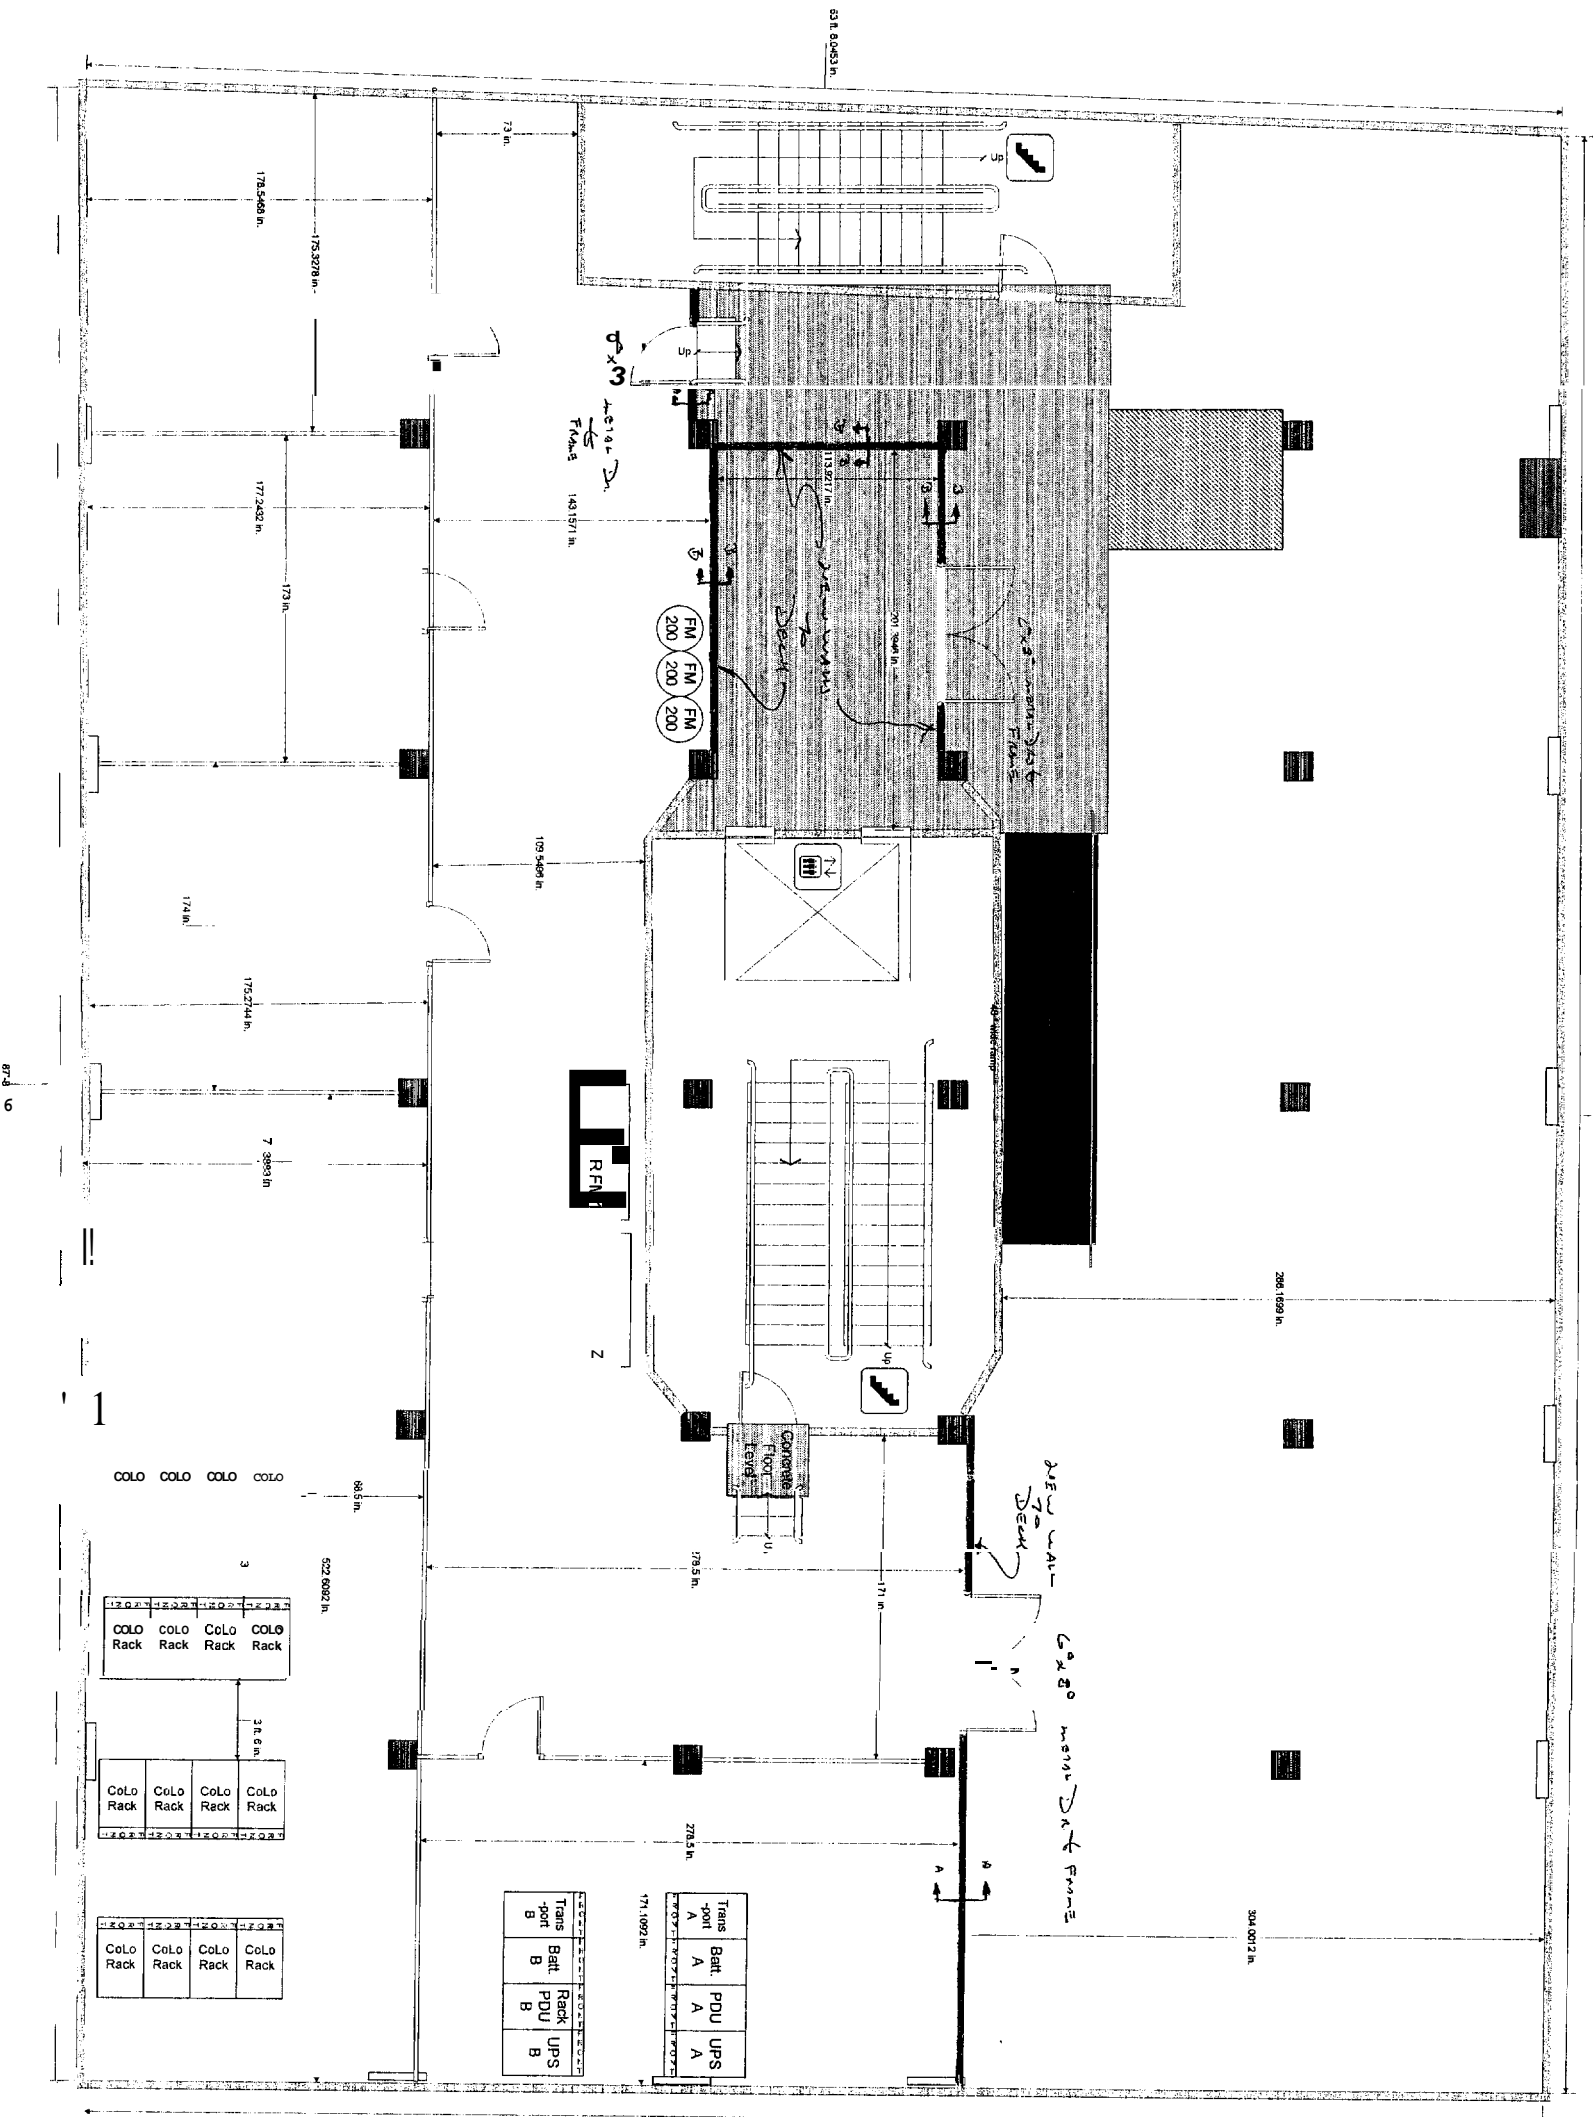

TRANSFORMER UPS	TRANSFORMER PDU	TRANSFORMER UPS	TRANSFORMER PDU
A	A	A	A
B	B	B	B
TRANSFORMER UPS	TRANSFORMER PDU	TRANSFORMER UPS	TRANSFORMER PDU
A	A	A	A
B	B	B	B

COLO Rack	COLO Rack	COLO Rack	COLO Rack
COLO Rack	COLO Rack	COLO Rack	COLO Rack
COLO Rack	COLO Rack	COLO Rack	COLO Rack
COLO Rack	COLO Rack	COLO Rack	COLO Rack

Data Center Floor Plan - Cumberland Ave.	
Time Warner Cable of Maine	
Network Engineering	
Checked by: [Signature]	Date: 31 Aug 2005
Scale: 1/8" = 1'	Sheet: 1 of 1

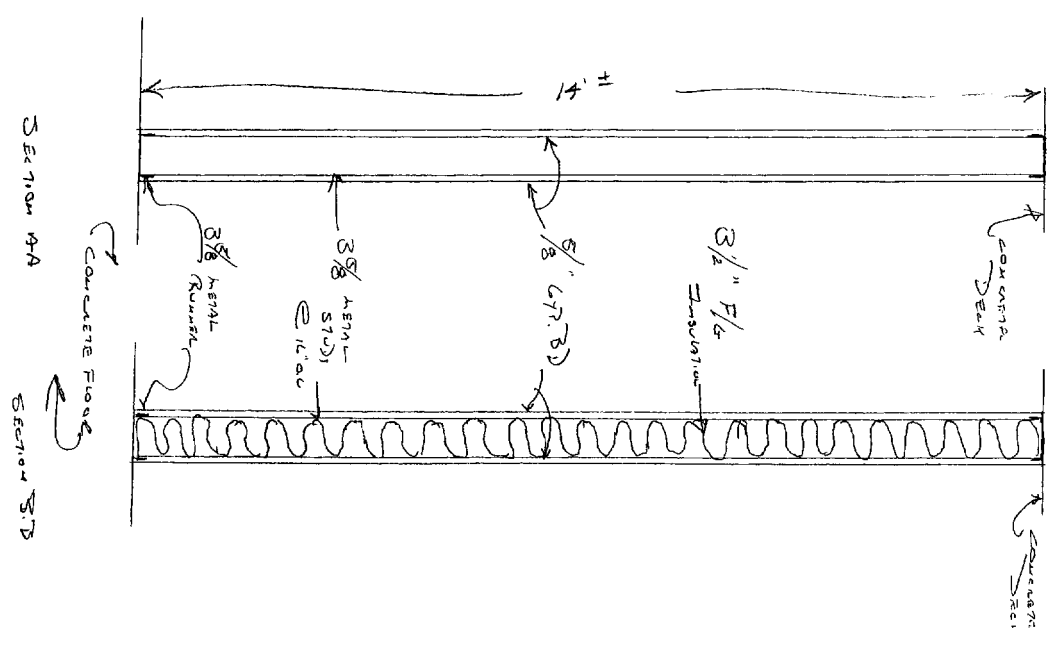

9/16/05  
J. Lewis