


Portland Hall Basement Floor

2003-027 Portland Hall Fire Alarm University of Southern Maine Portland Campus



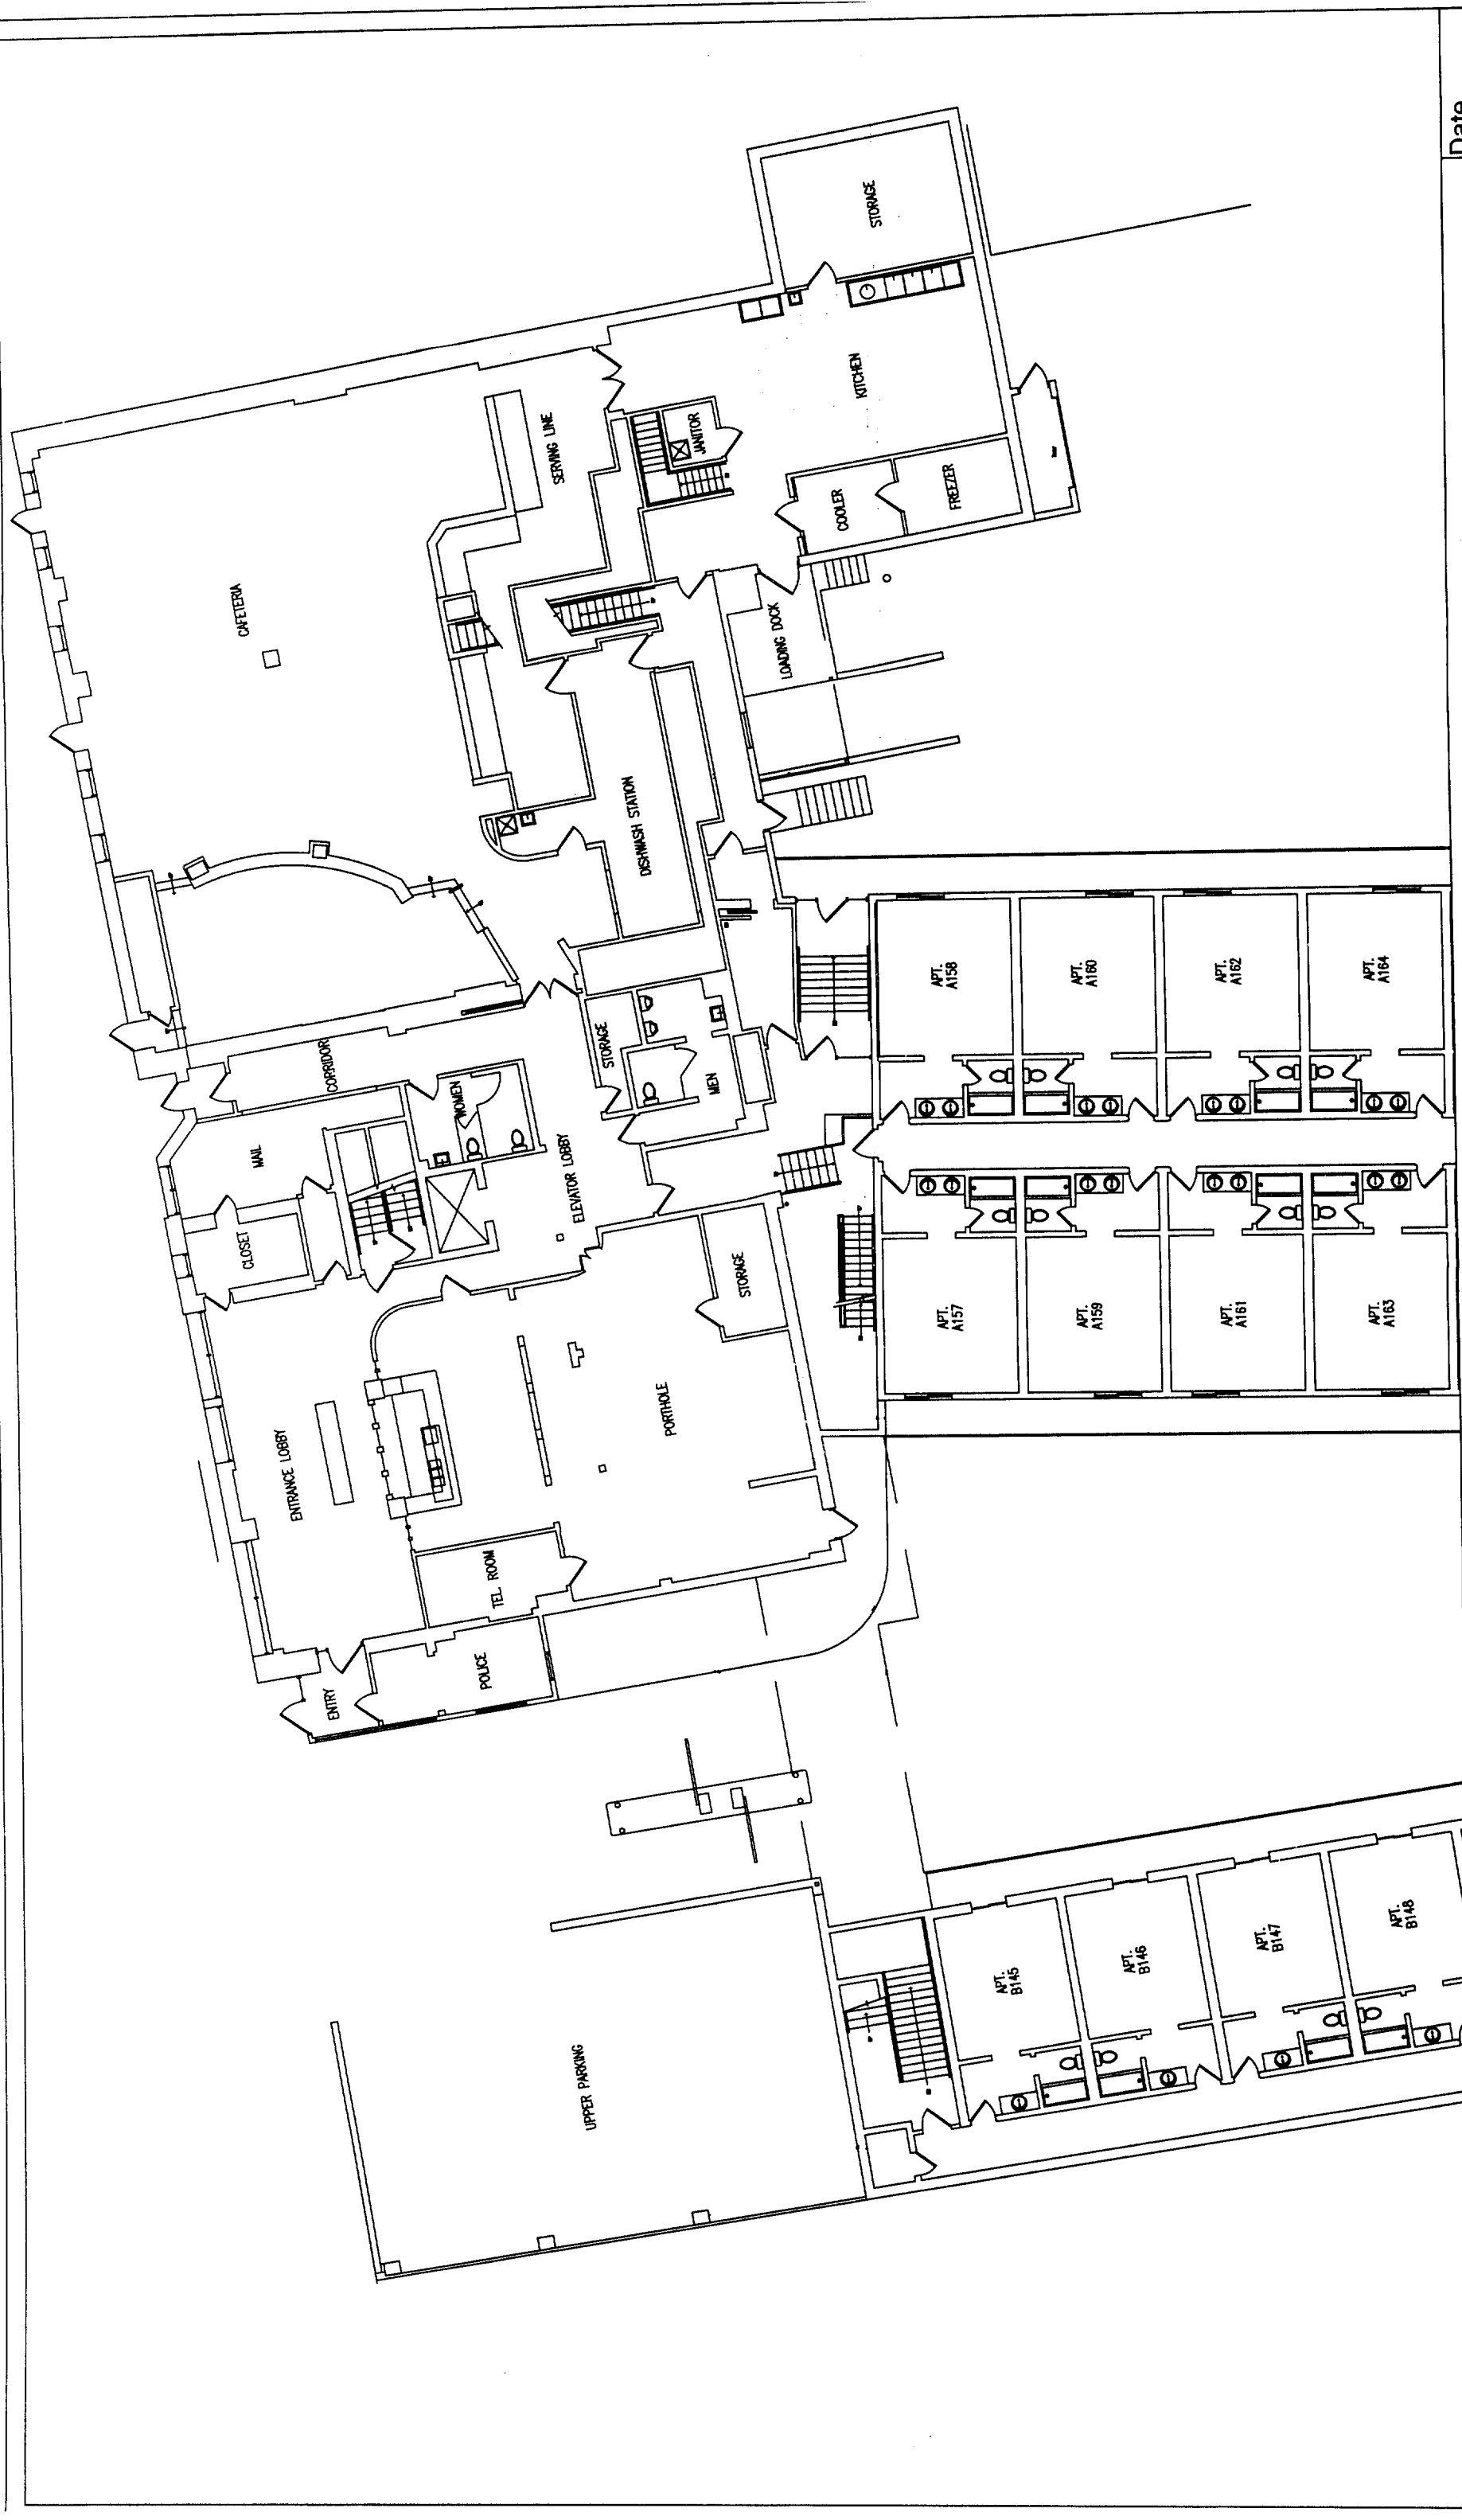

Scale 1/16"=1'

Portland Hall First Floor Main Building

2003-027 Portland Hall Fire Alarm University of Southern Maine Portland Campus






2003-027 Portland Hall Fire Alarm

Portland Hall First Floor Plan Wing A & B

Date 03-04-04

Scale 1/16"=1'

Page 3 of

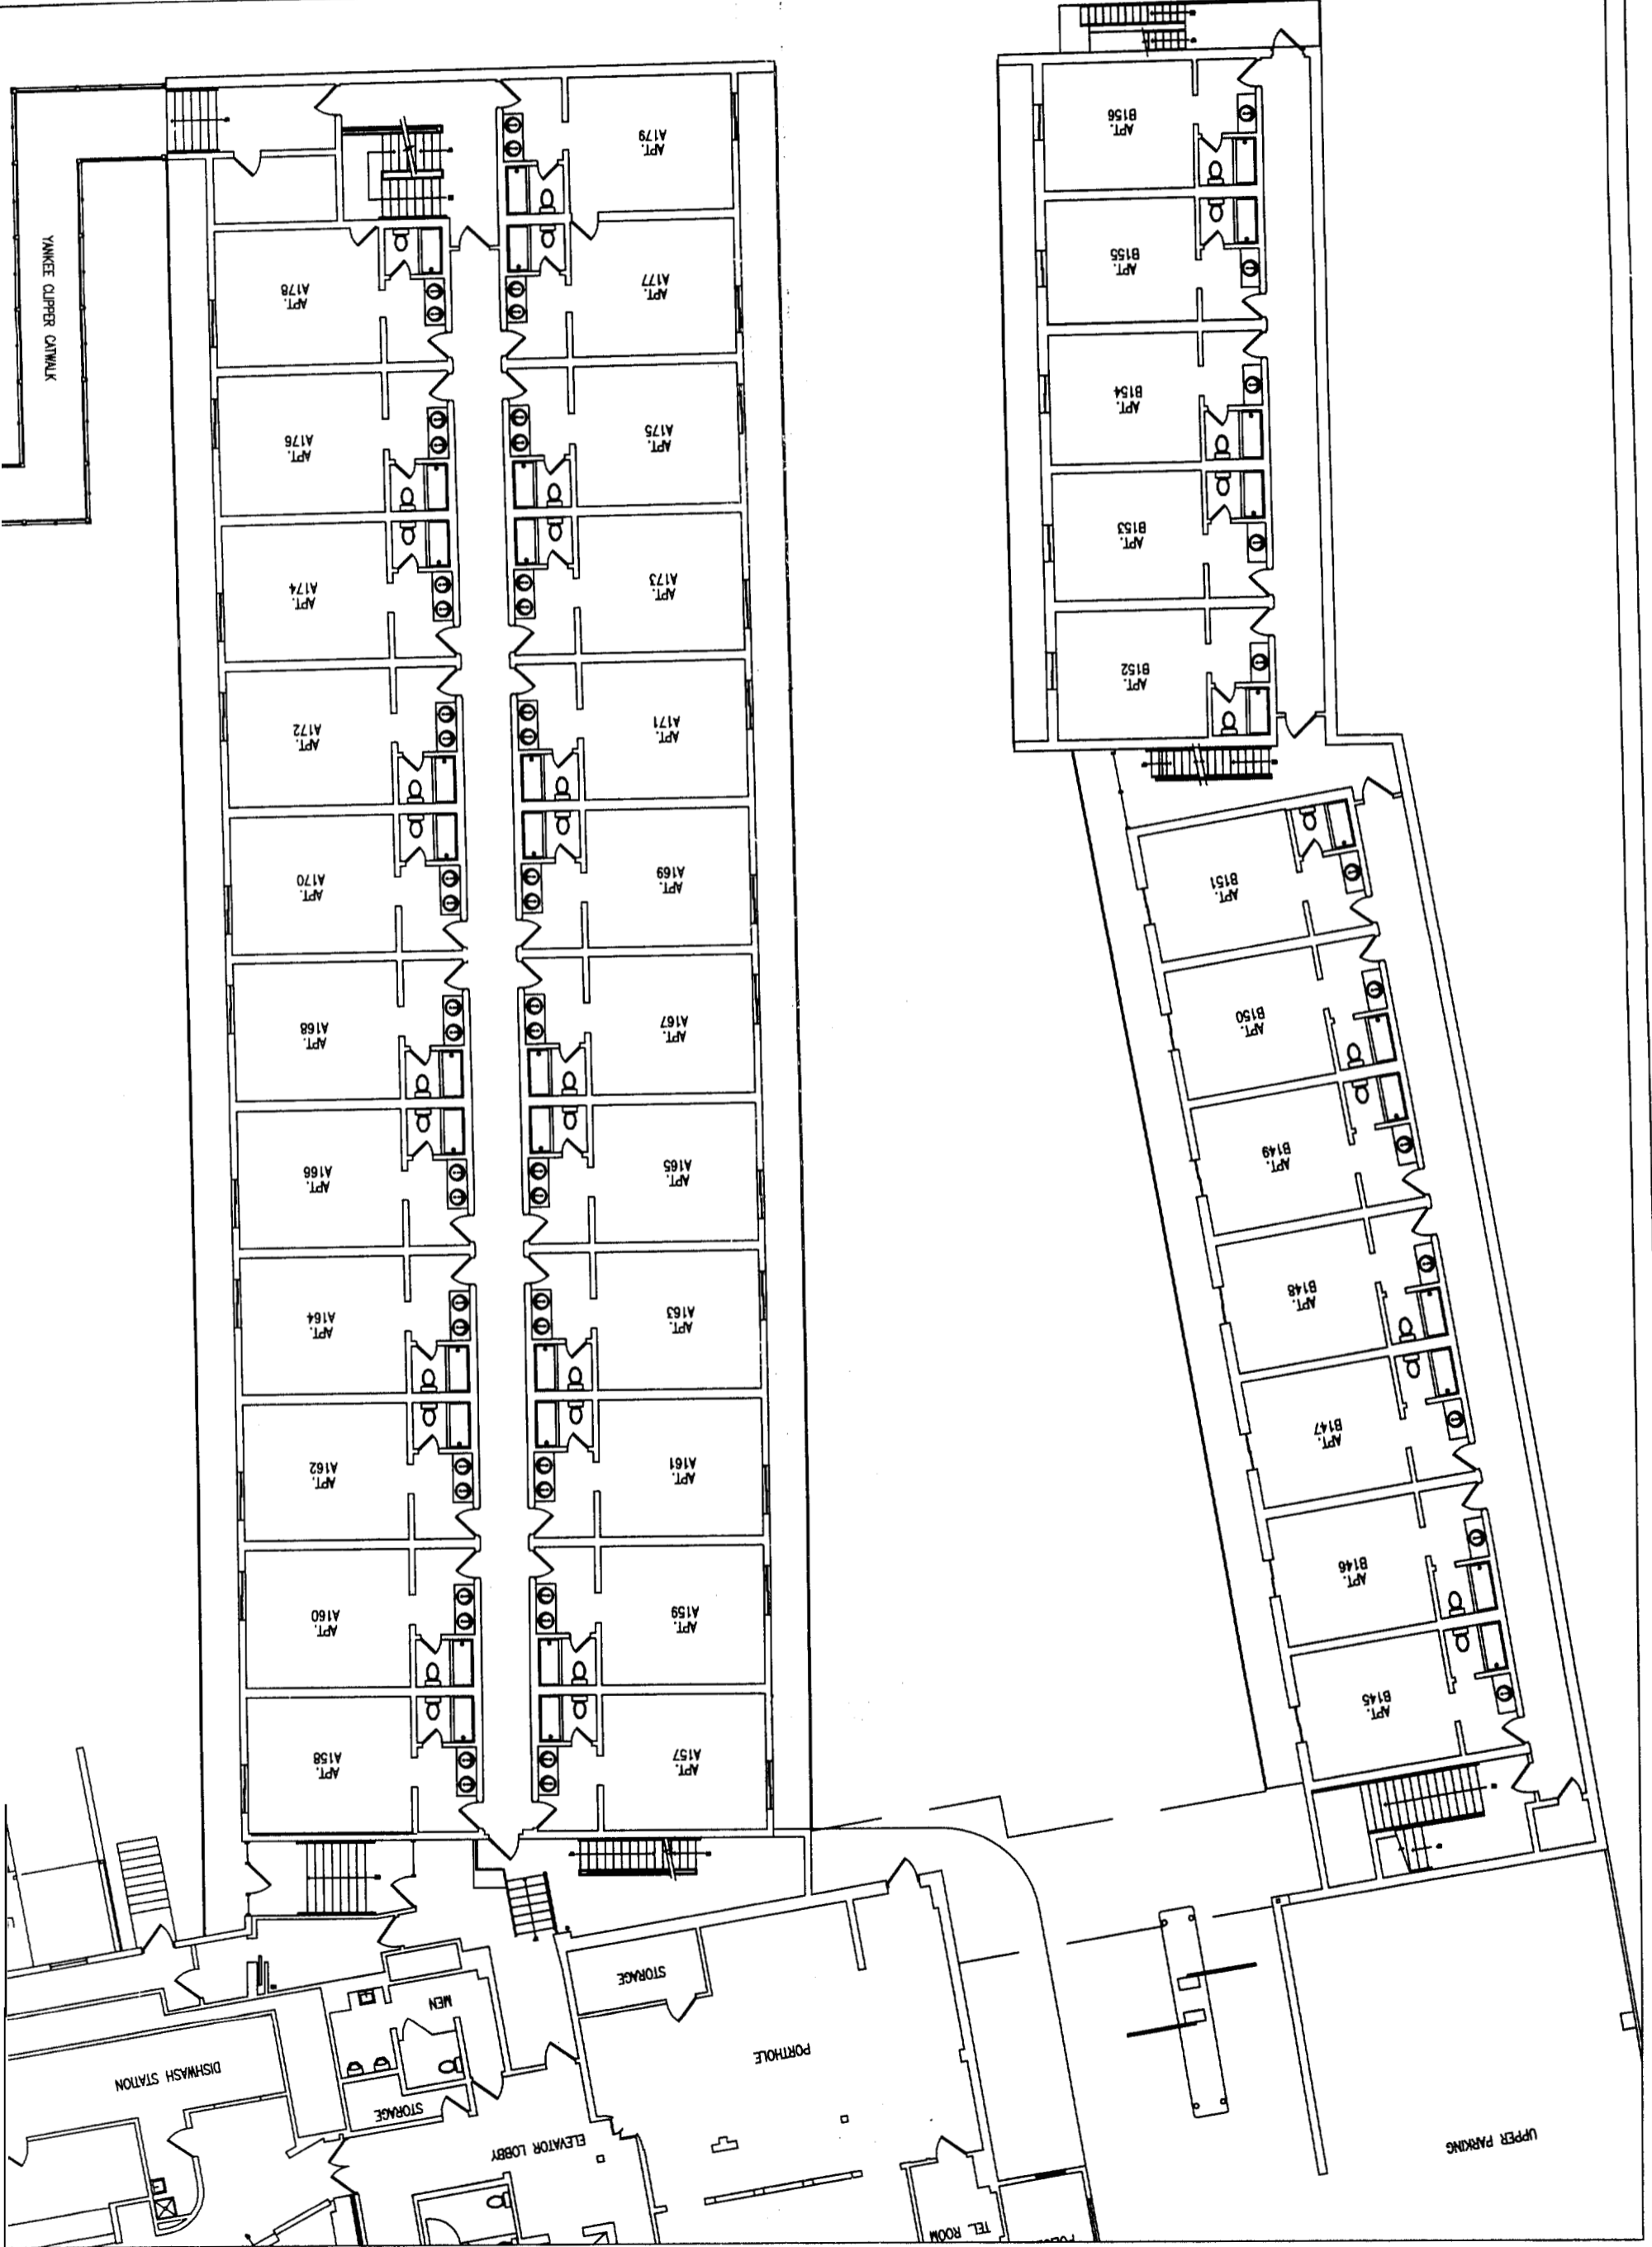




2003-027 Portland Hall Fire Alarm


Portland Hall First Floor Yankee Clipper

Date 03-04-04

Scale 1/16"=1'

Page 4 of 11

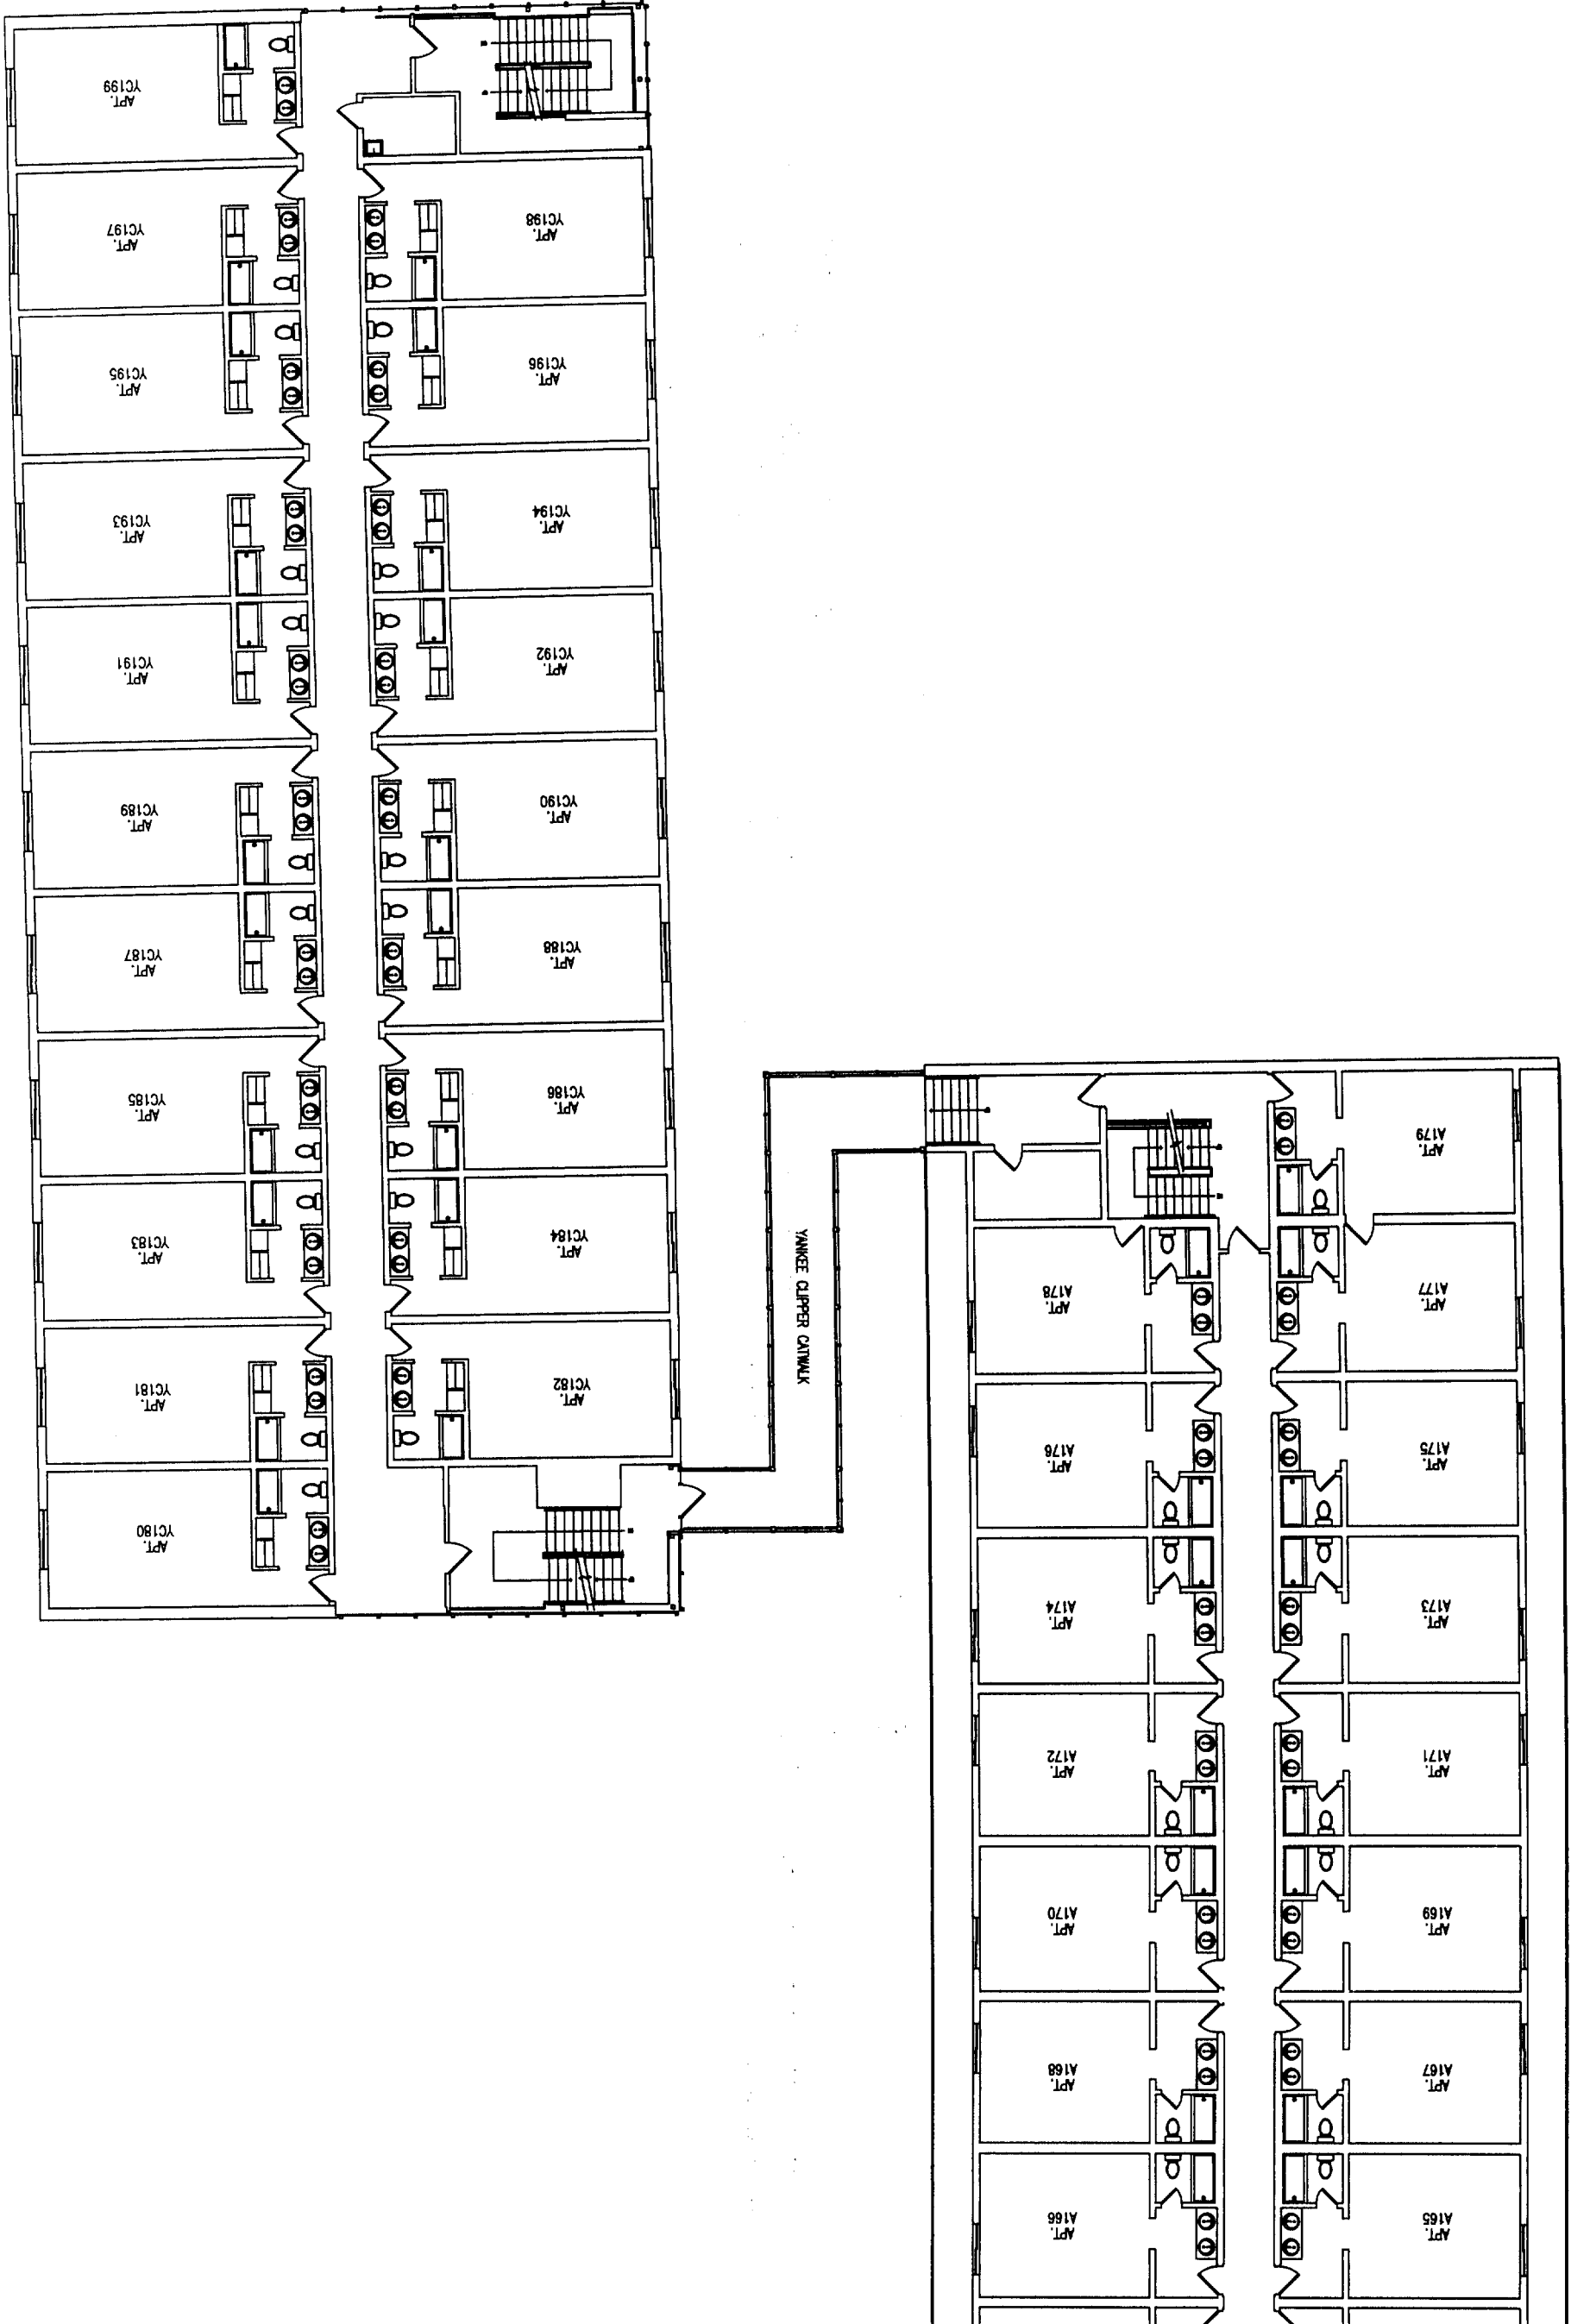

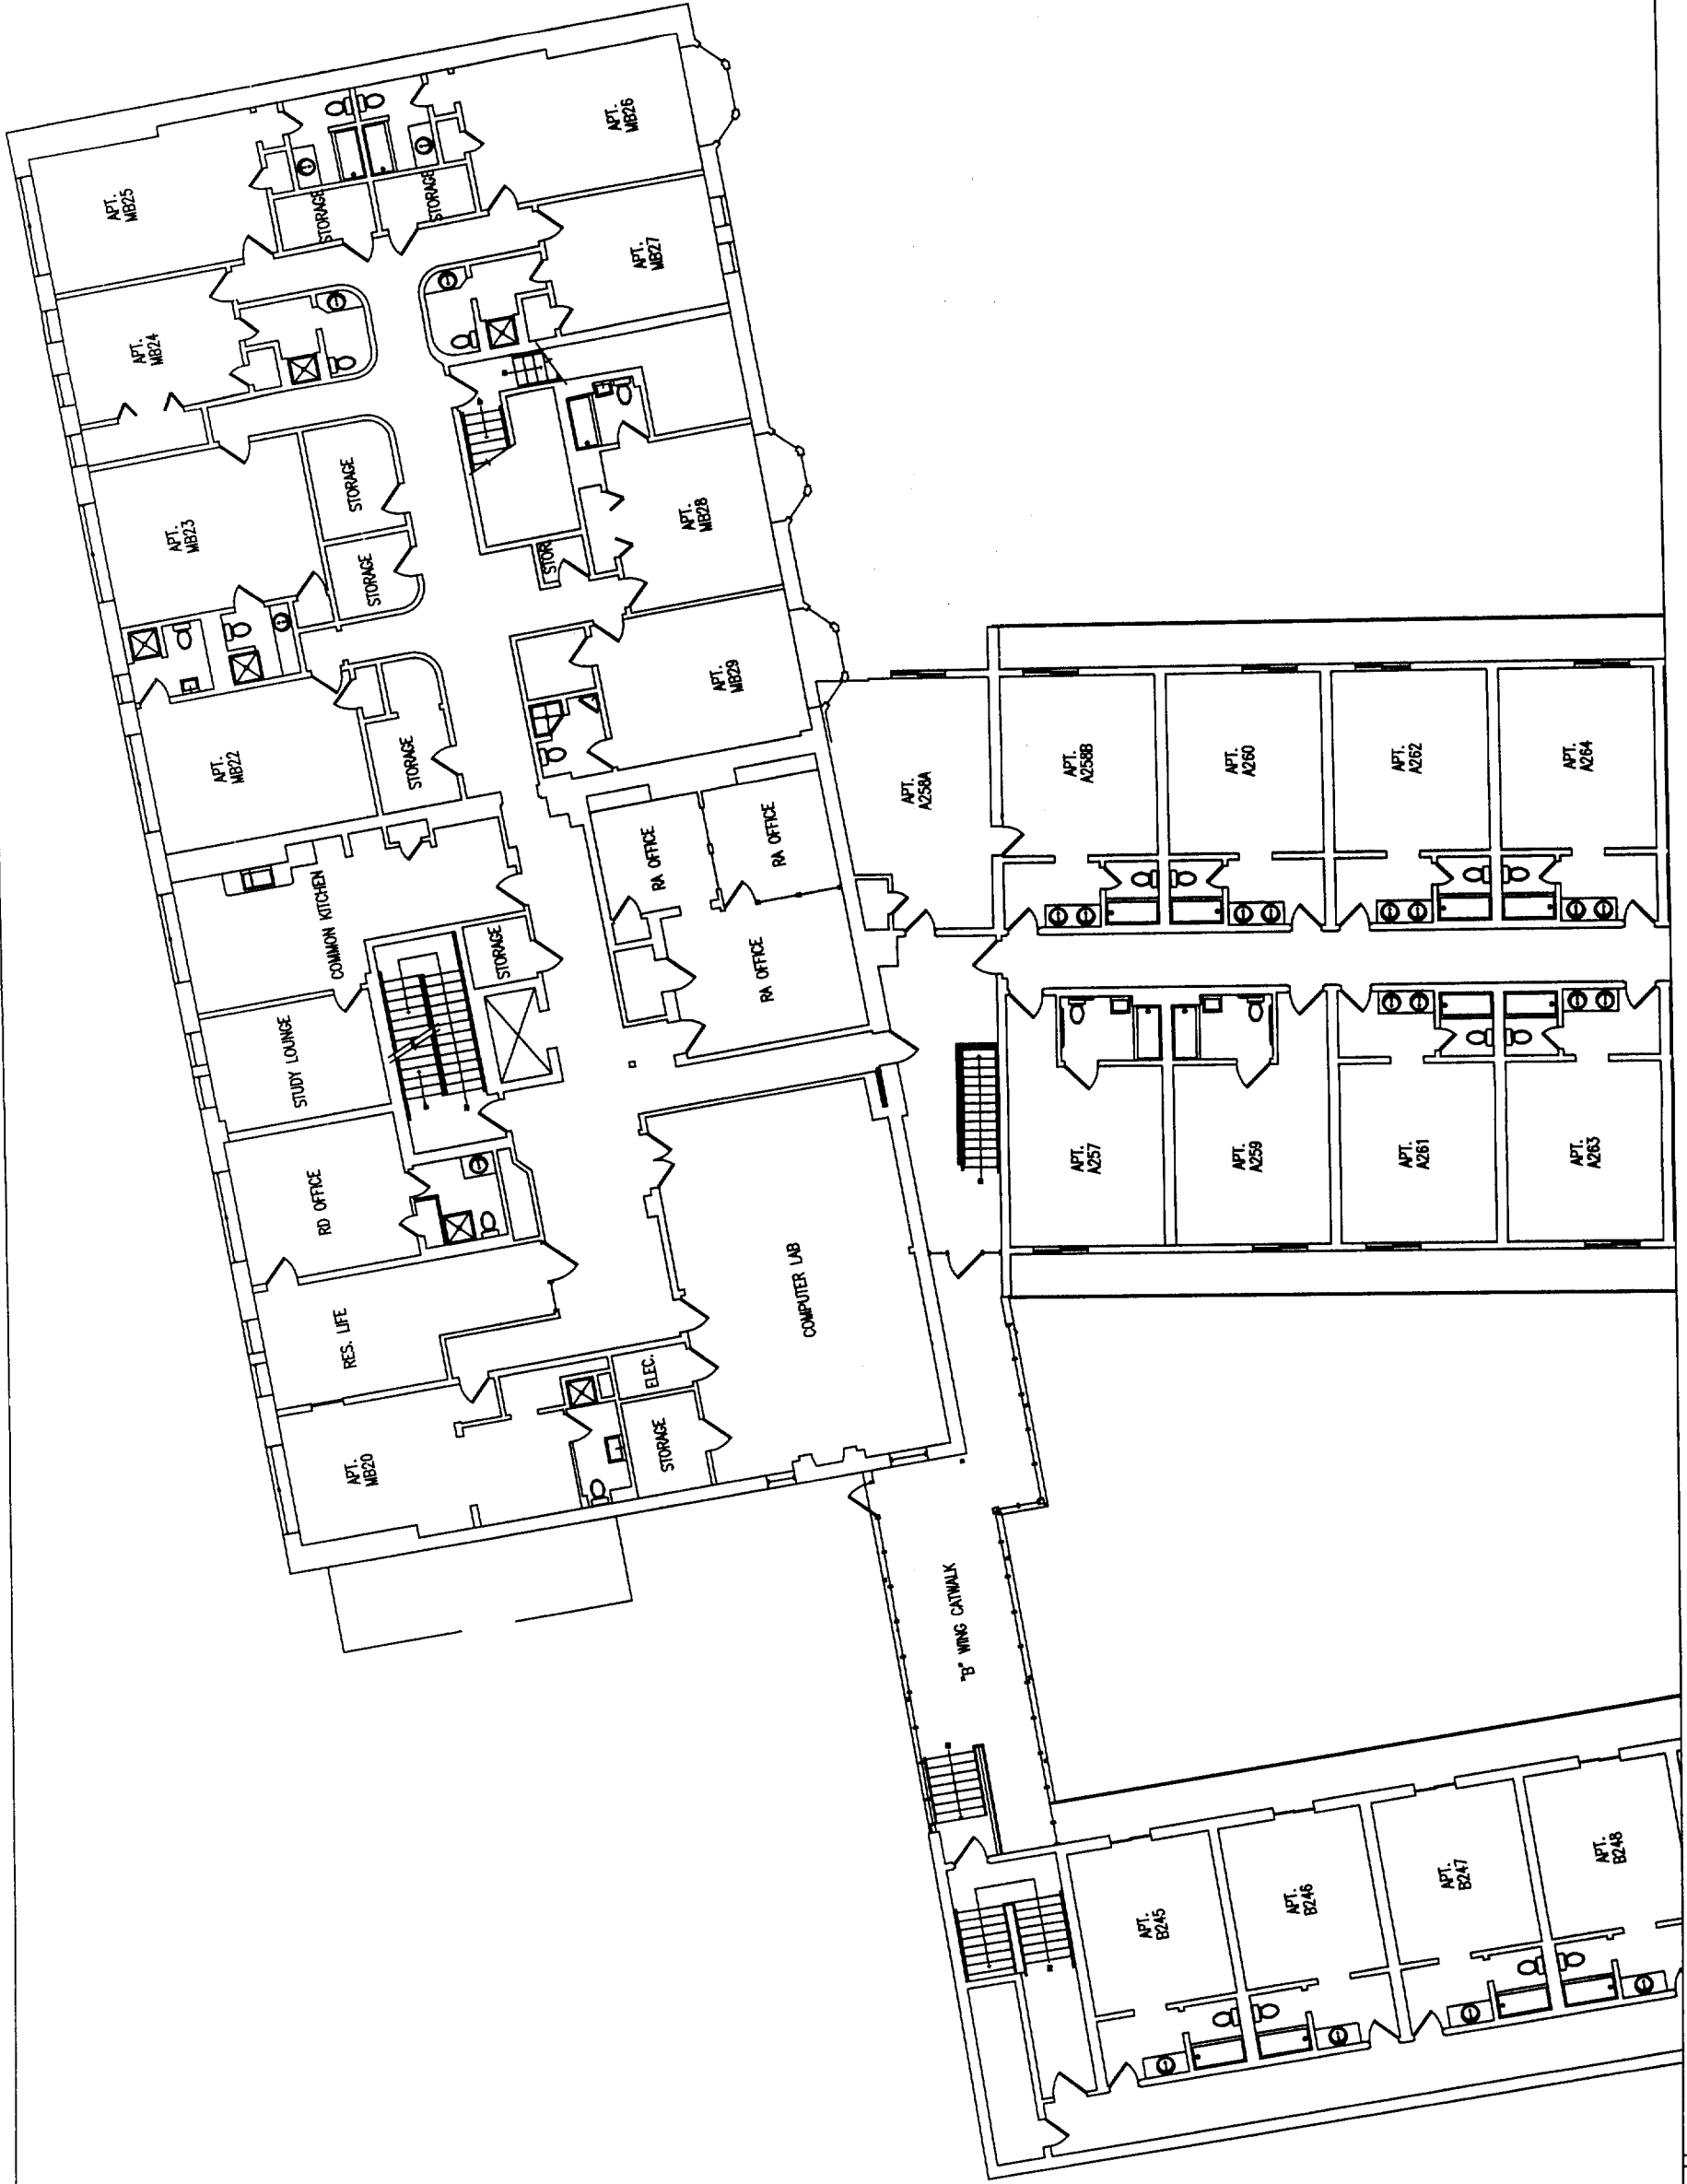

Portland Hall Second Floor Main Building

2003-027 Portland Hall Fire Alarm University of Southern Maine Portland Campus

Scale 1/16"=1'





2003-027 Portland Hall Fire Alarm


Portland Hall Second Floor Wing A & B

Wing A and Wing B

Date 03-04-04

Scale 1/16"=1'



Page 6 of 11

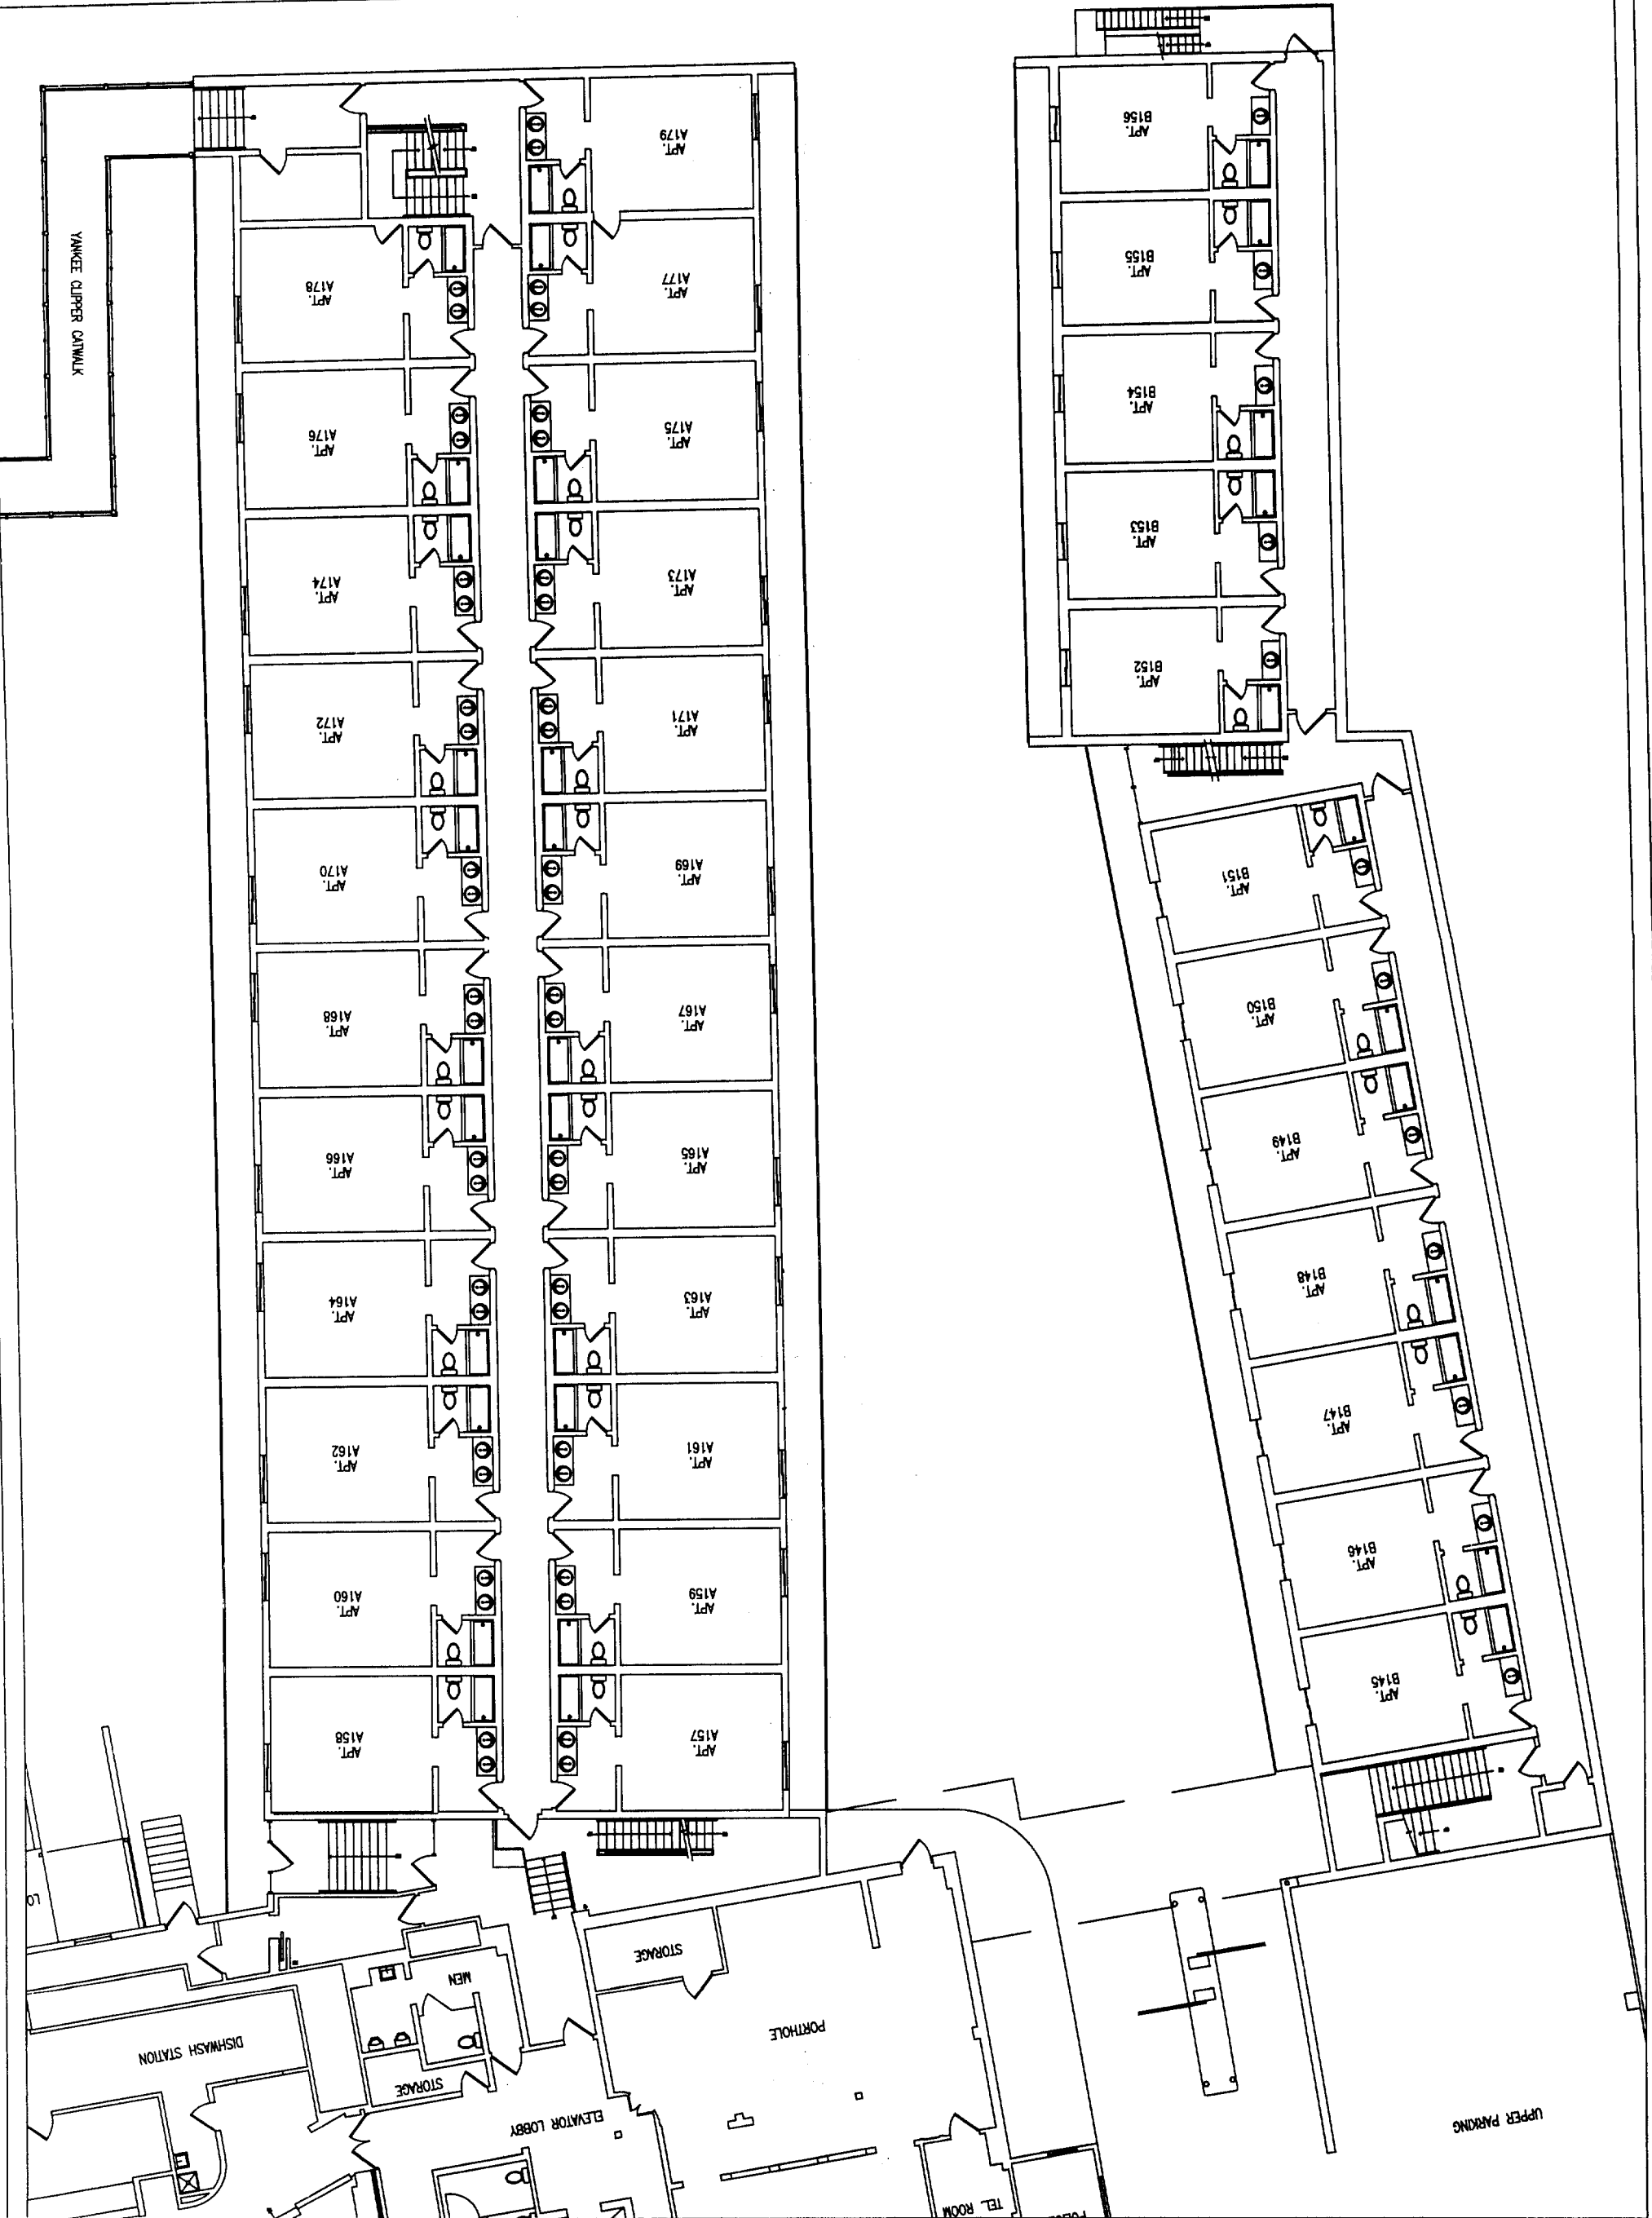



Portland Hall Second Floor Yankee Clipper


Date 03-04-04

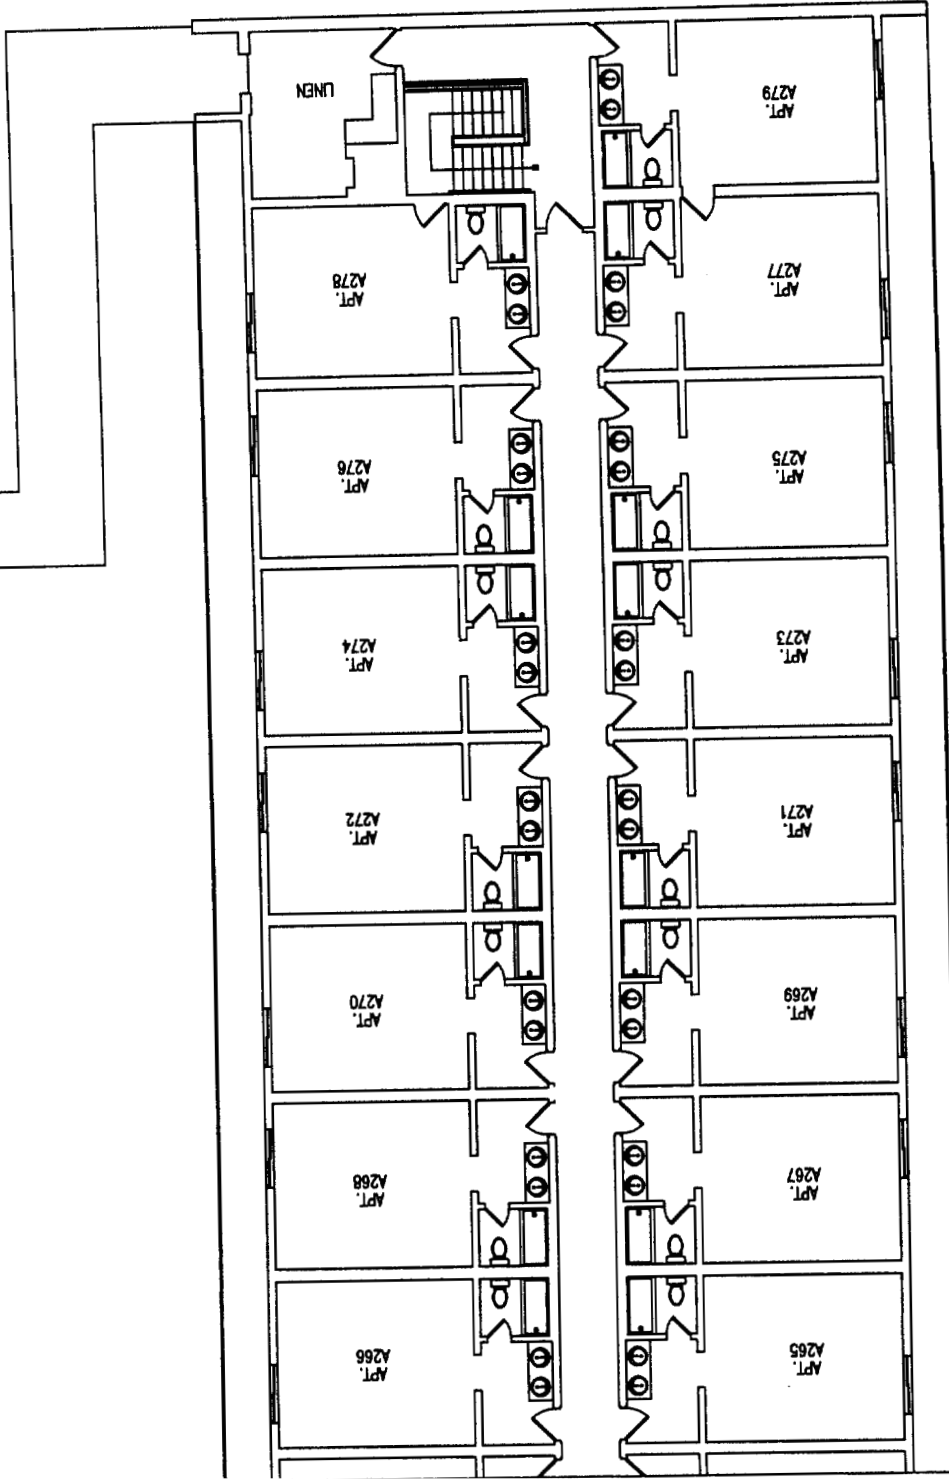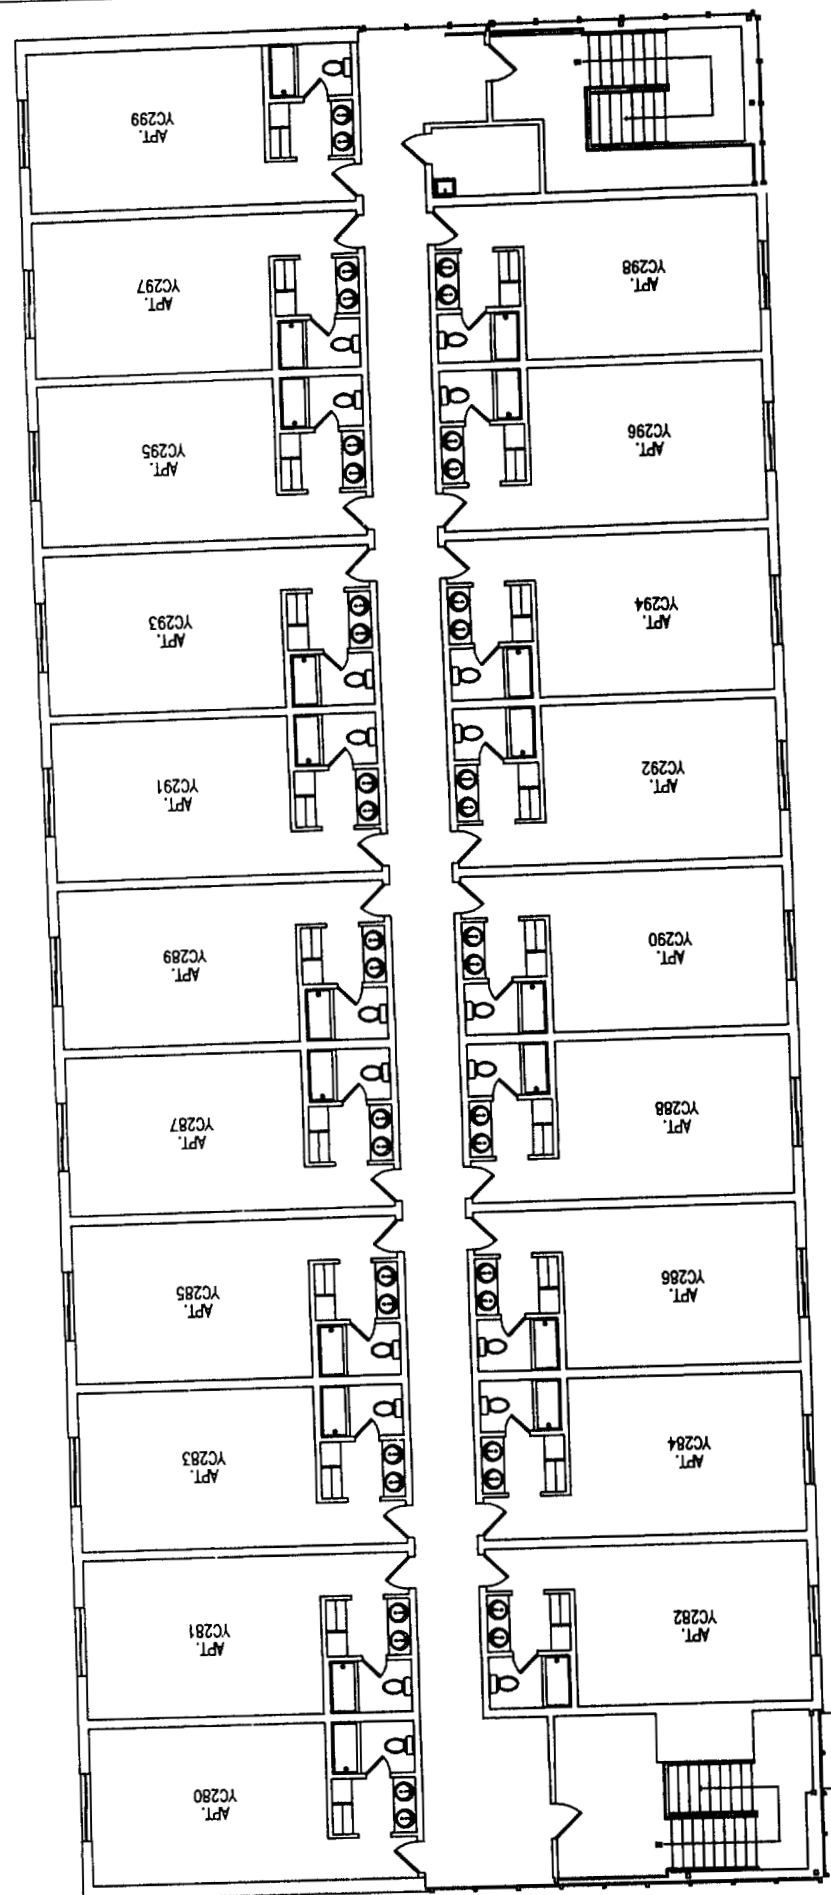




Portland Hall Third Floor Main Building

2003-027 Portland Hall Fire Alarm University of Southern Maine Portland Campus

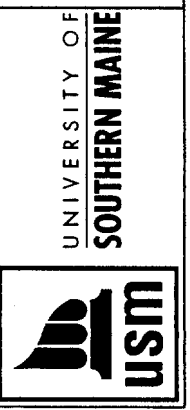

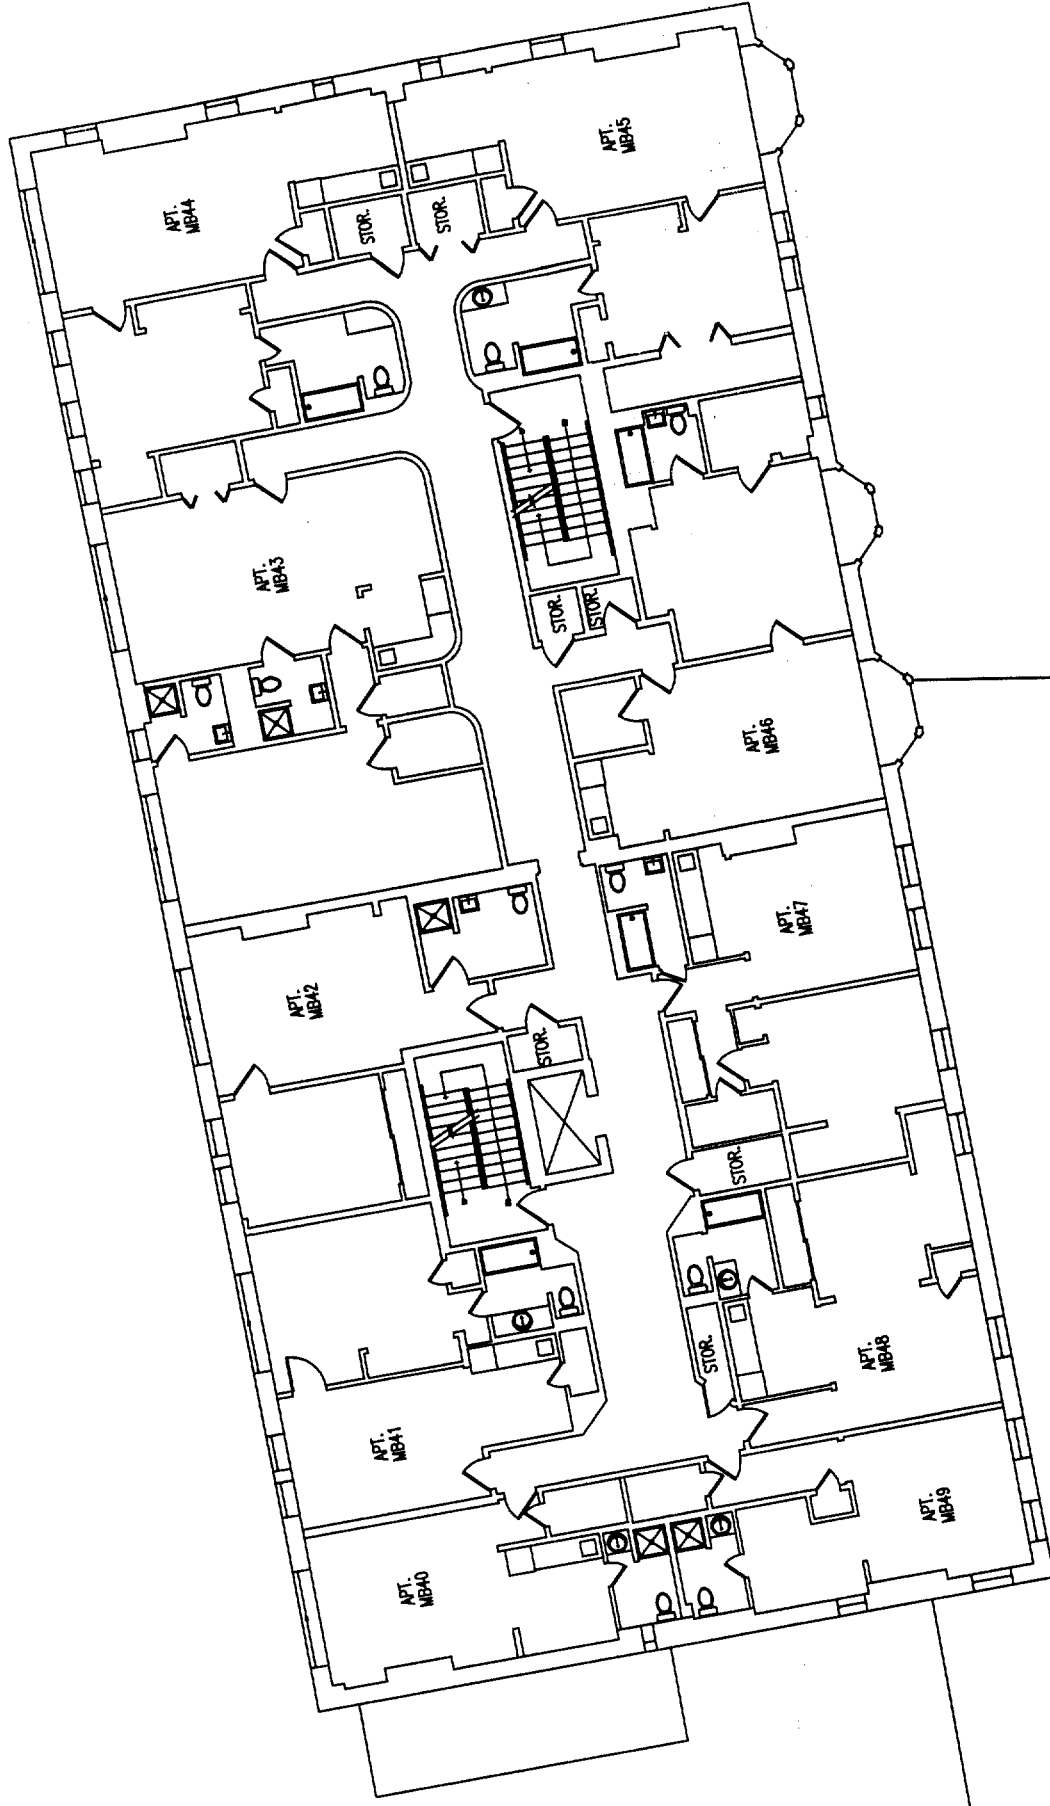


Portland Hall Fourth Floor Main Building

2003-027 Portland Hall Fire Alarm University of Southern Maine Portland Campus

Scale
1/16"=1'



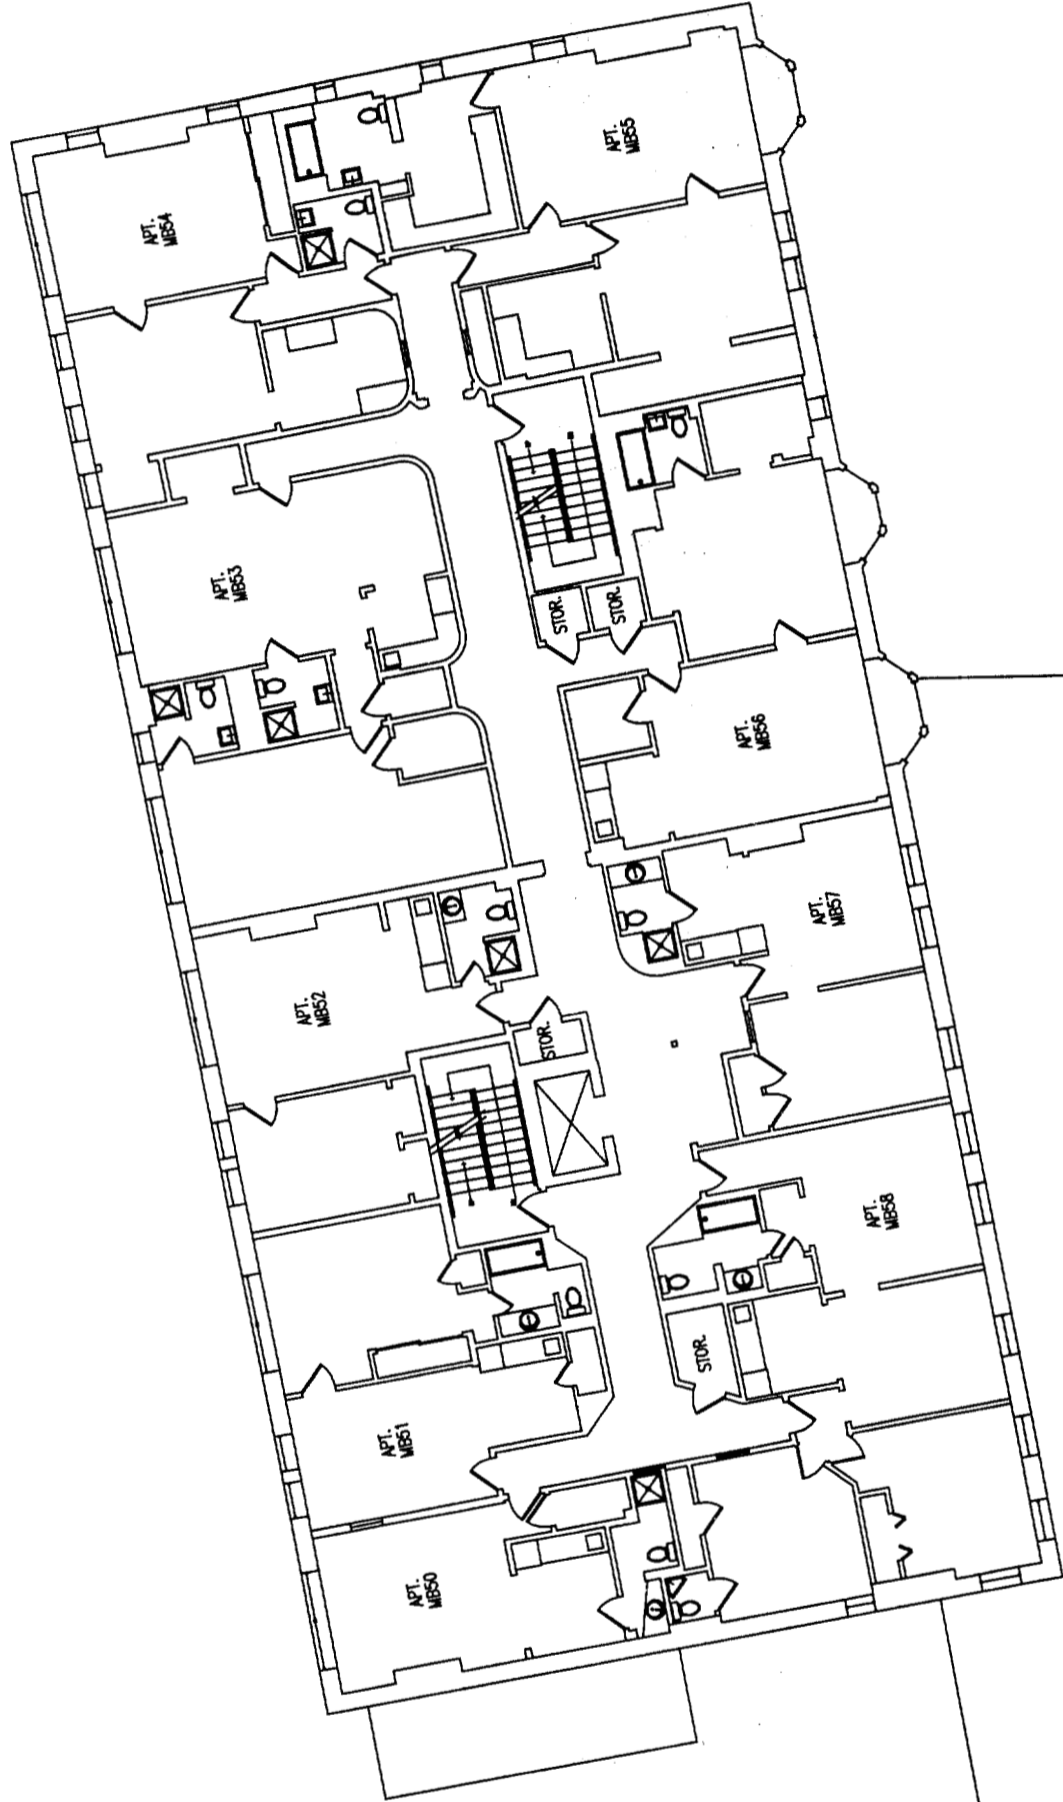



Portland Hall Fifth Floor Main Building

2003-027 Portland Hall Fire Alarm University of Southern Maine Portland Campus



UNIVERSITY OF
SOUTHERN MAINE

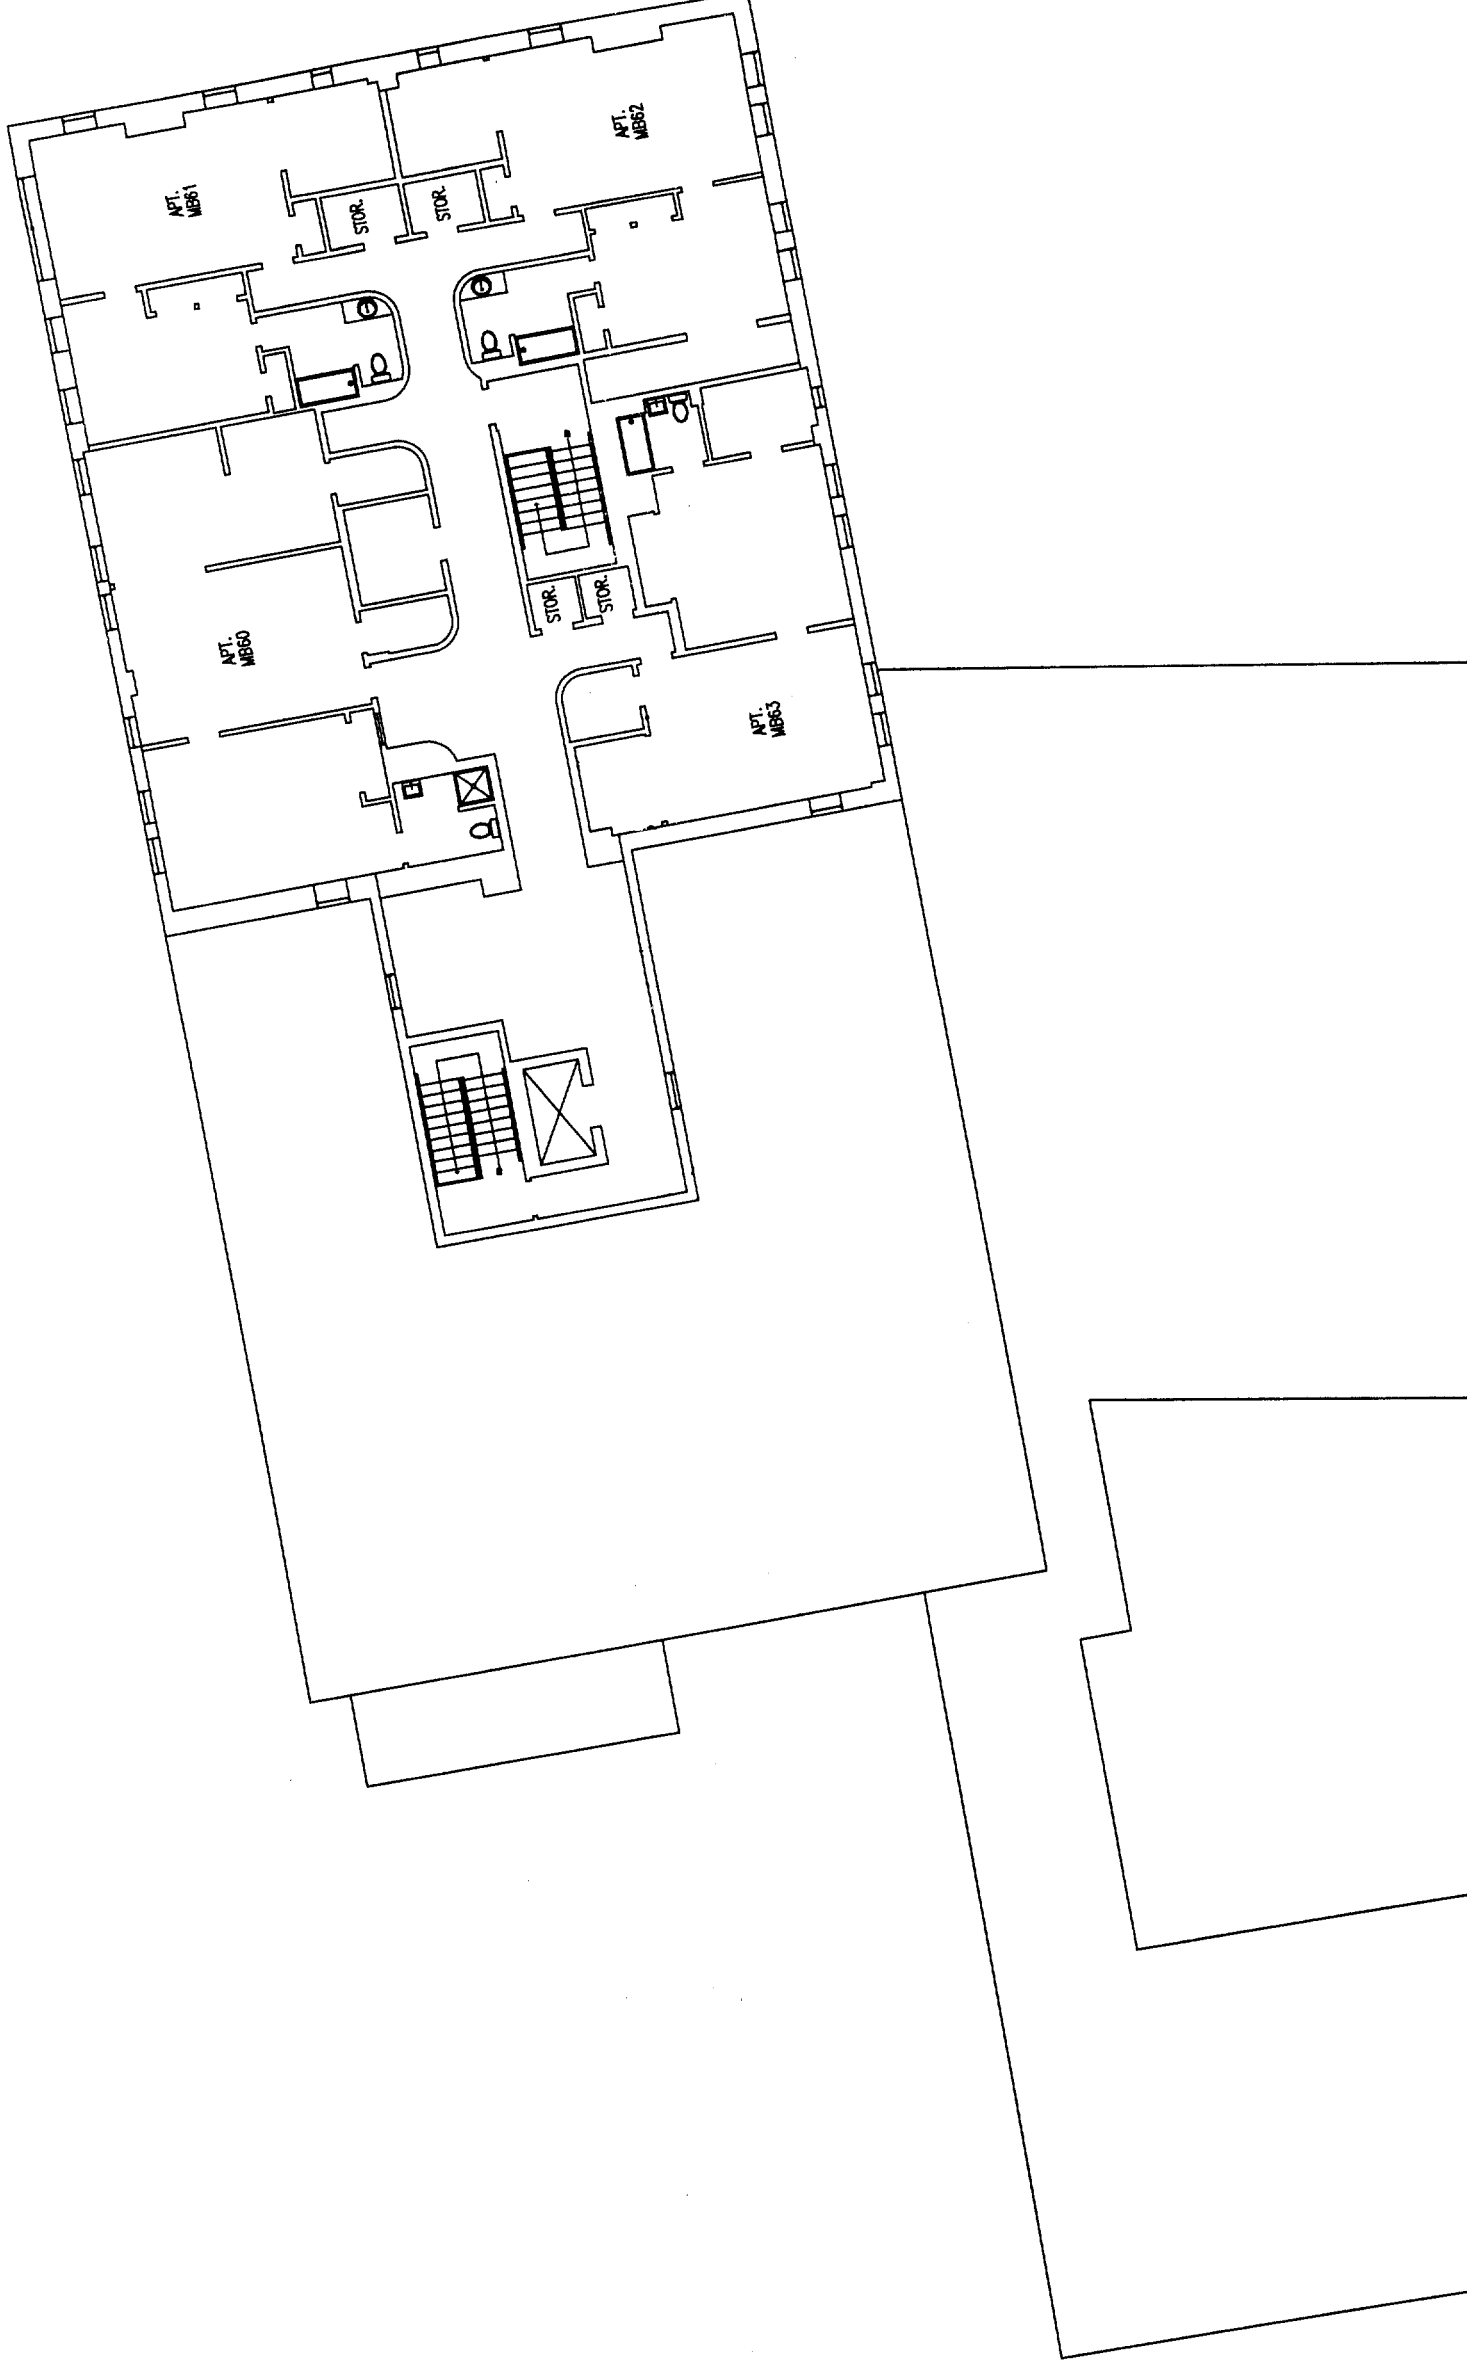

 UNIVERSITY OF SOUTHERN MAINE	Portland Hall Sixth Floor Main Building		Date 03-04-04
	2003-027 Portland Hall Fire Alarm University of Southern Maine Portland Campus		Scale 1/16"=1' Page 11 of 11