


1 Reflected Ceiling Plan & Lighting Plan
SCALE: 1/4" = 1'-0"

Legend




Existing Cfg. Fixtures
To Be Removed/Replaced

TYPE	MANUFACTURER/DESCRIPTION	CATALOGUE #	REMARKS
A1	LIGHTOLIER SURFACE MTD. 2x2 ALTER	0V529FF05ZFT 59	
A1	LIGHTOLIER SURFACE MTD. 2x2 ALTER	0V729FF05ZFT 59	
P2	LIGHTOLIER CALCULITE ELIPSOIDAL DOWNLIGHT	784 CDM 7084 1951 T4 FROSTED MINI CAN BASE 500W LAMP (DIMMER)	
P3	LIGHTOLIER PERIDALUX TRADITIONAL	4R42842ASBU 45144ZSB 45XT 5A1N BRASS	
P4	LIGHTOLIER CALCULITE TURBO LOUVER	7132BU 8037 TBW TIT	
P5	LIGHTOLIER ALCON	22058AL/60098A 6080 WH	

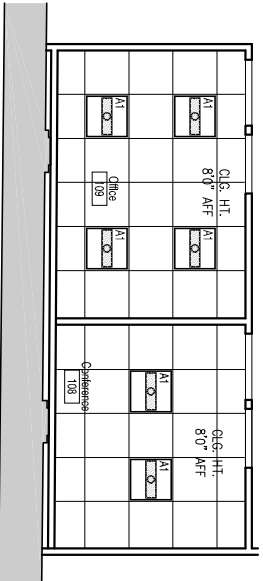

2 Offices 108&109 - Reflected Ceiling Plan & Lighting Plan
SCALE: 1/4" = 1'-0"

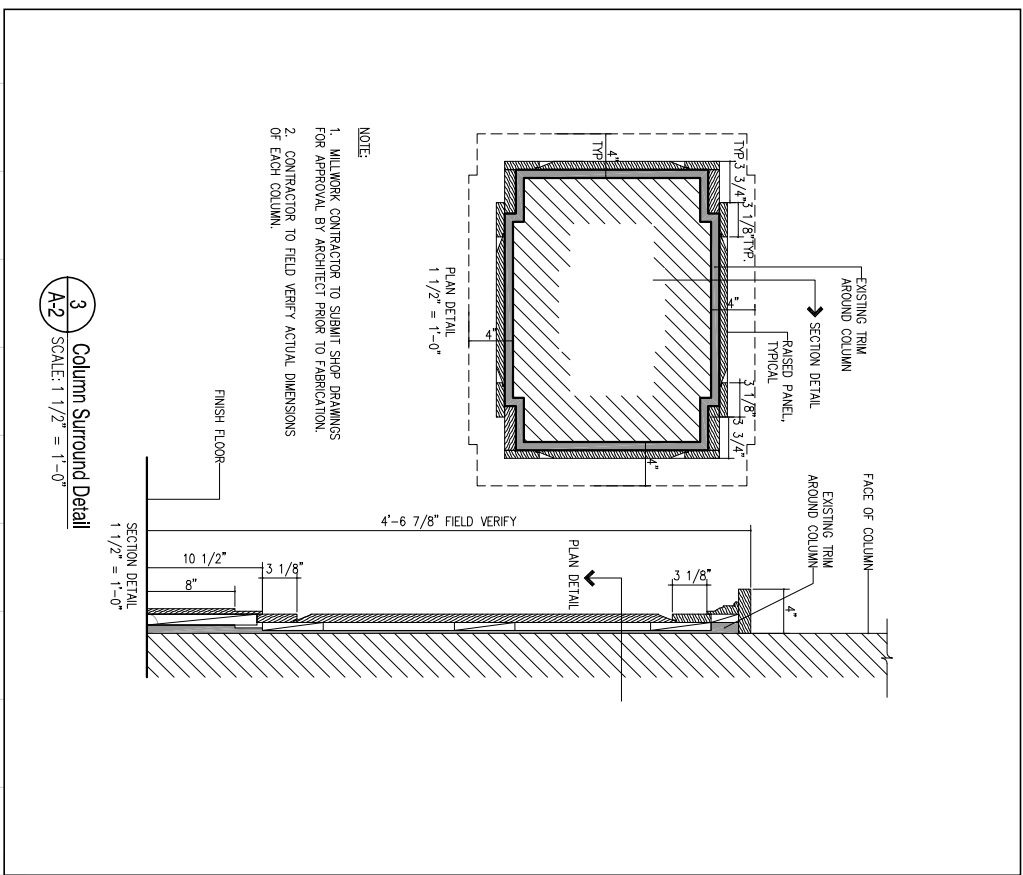

3 Column Surround Detail
SCALE: 1/2" = 1'-0"

- NOTE:
1. MILLWORK CONTRACTORS TO SIGN SHOP DRAWINGS FOR APPROVAL BY ARCHITECT PRIOR TO FABRICATION.
 2. CONTRACTOR TO FIELD VERIFY ACTUAL DIMENSIONS OF EACH COLUMN.

Construction Set

Peoples Heritage Bank
477 Congress Street, Portland, Maine
Reflected Ceiling Plan, Lighting Plan
and Details

revision #/ date Revision Reason

date 9-25-2005 drawn by JB 1/4" = 1'-0"

TLA
Tel: (207) 842-8360
Fax: (207) 842-6271
1 (800) 239-2253

**THERIAULT/
LANDMANN**
ASSOCIATES

118 Congress St., Portland, ME 04101

A-2
sheet number

issued:
project no.