



KEY PLAN

N.T.S.

RCP LEGEND	
	NEW 24x24 ACT TILES IN NEW GRID SYSTEM
	NEW 24x24 ACT TILES AND NEW CEILING LIGHT FIXTURES IN EXISTING GRID SYSTEM
	NEW 24x48 CEILING LIGHT FIXTURE
	NEW DIFFUSER
	NEW SINGLE SWITCH

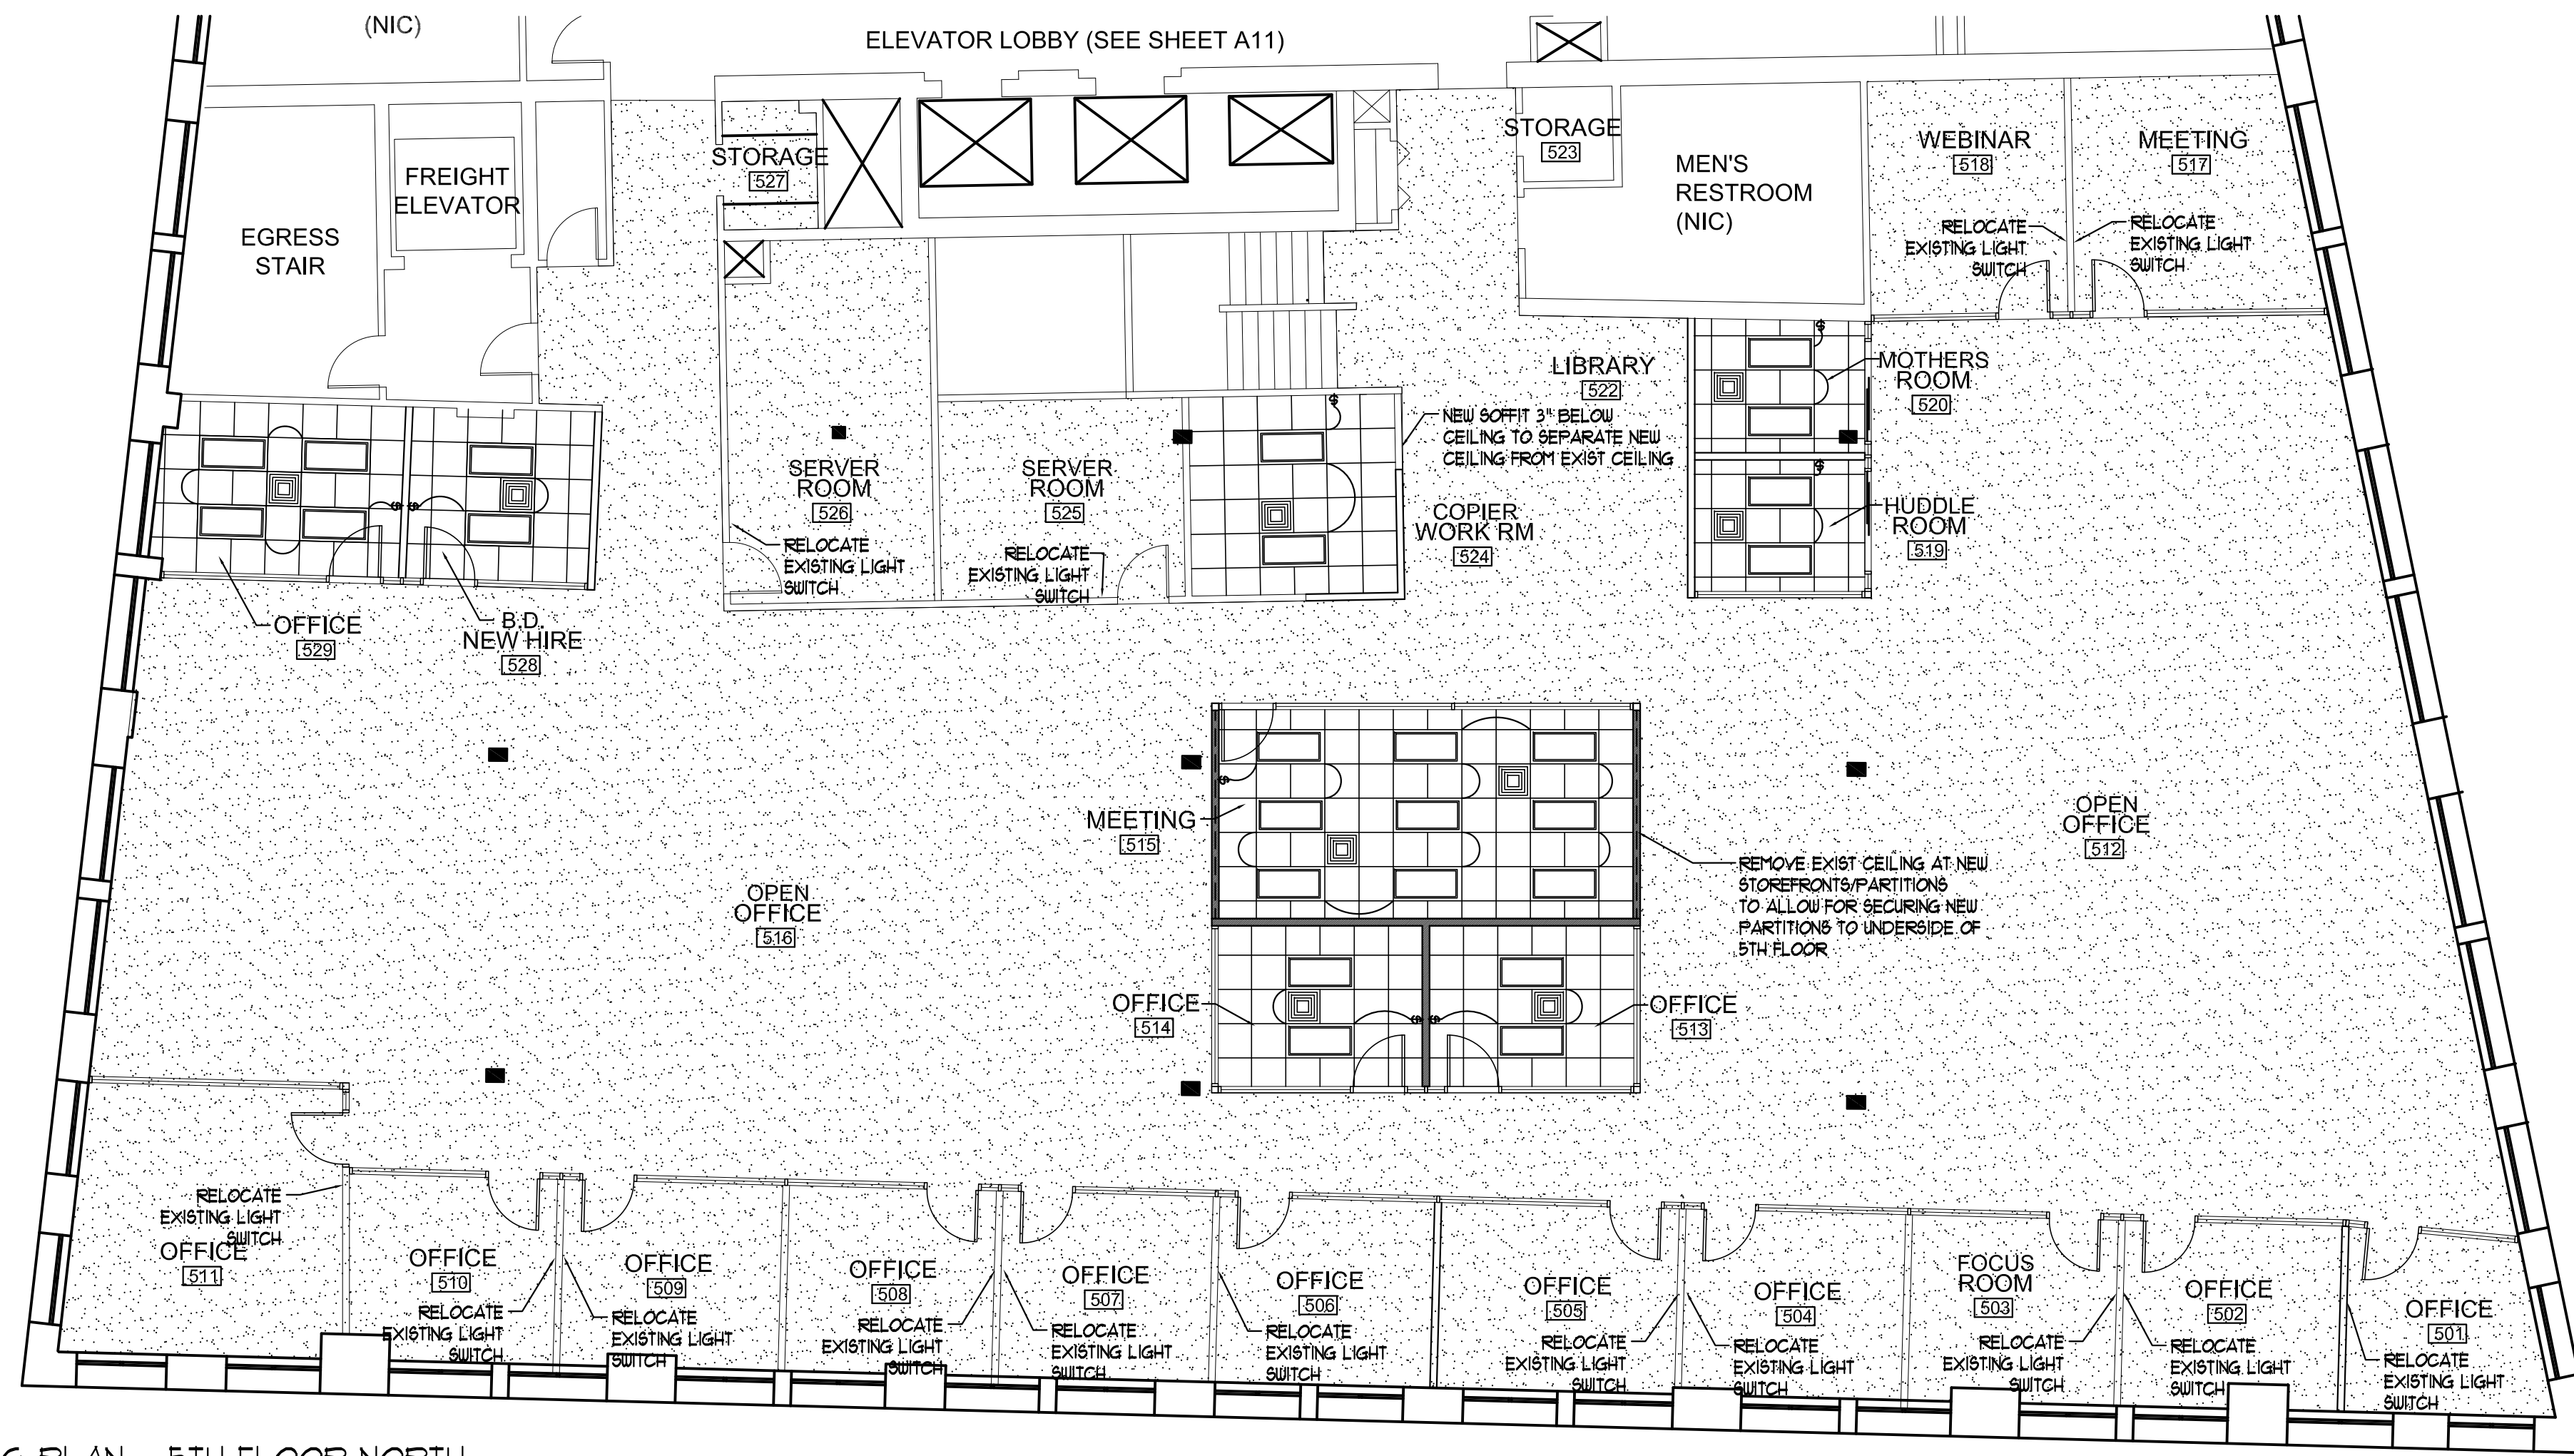

2 REFLECTED CEILING PLAN - 5TH FLOOR NORTH

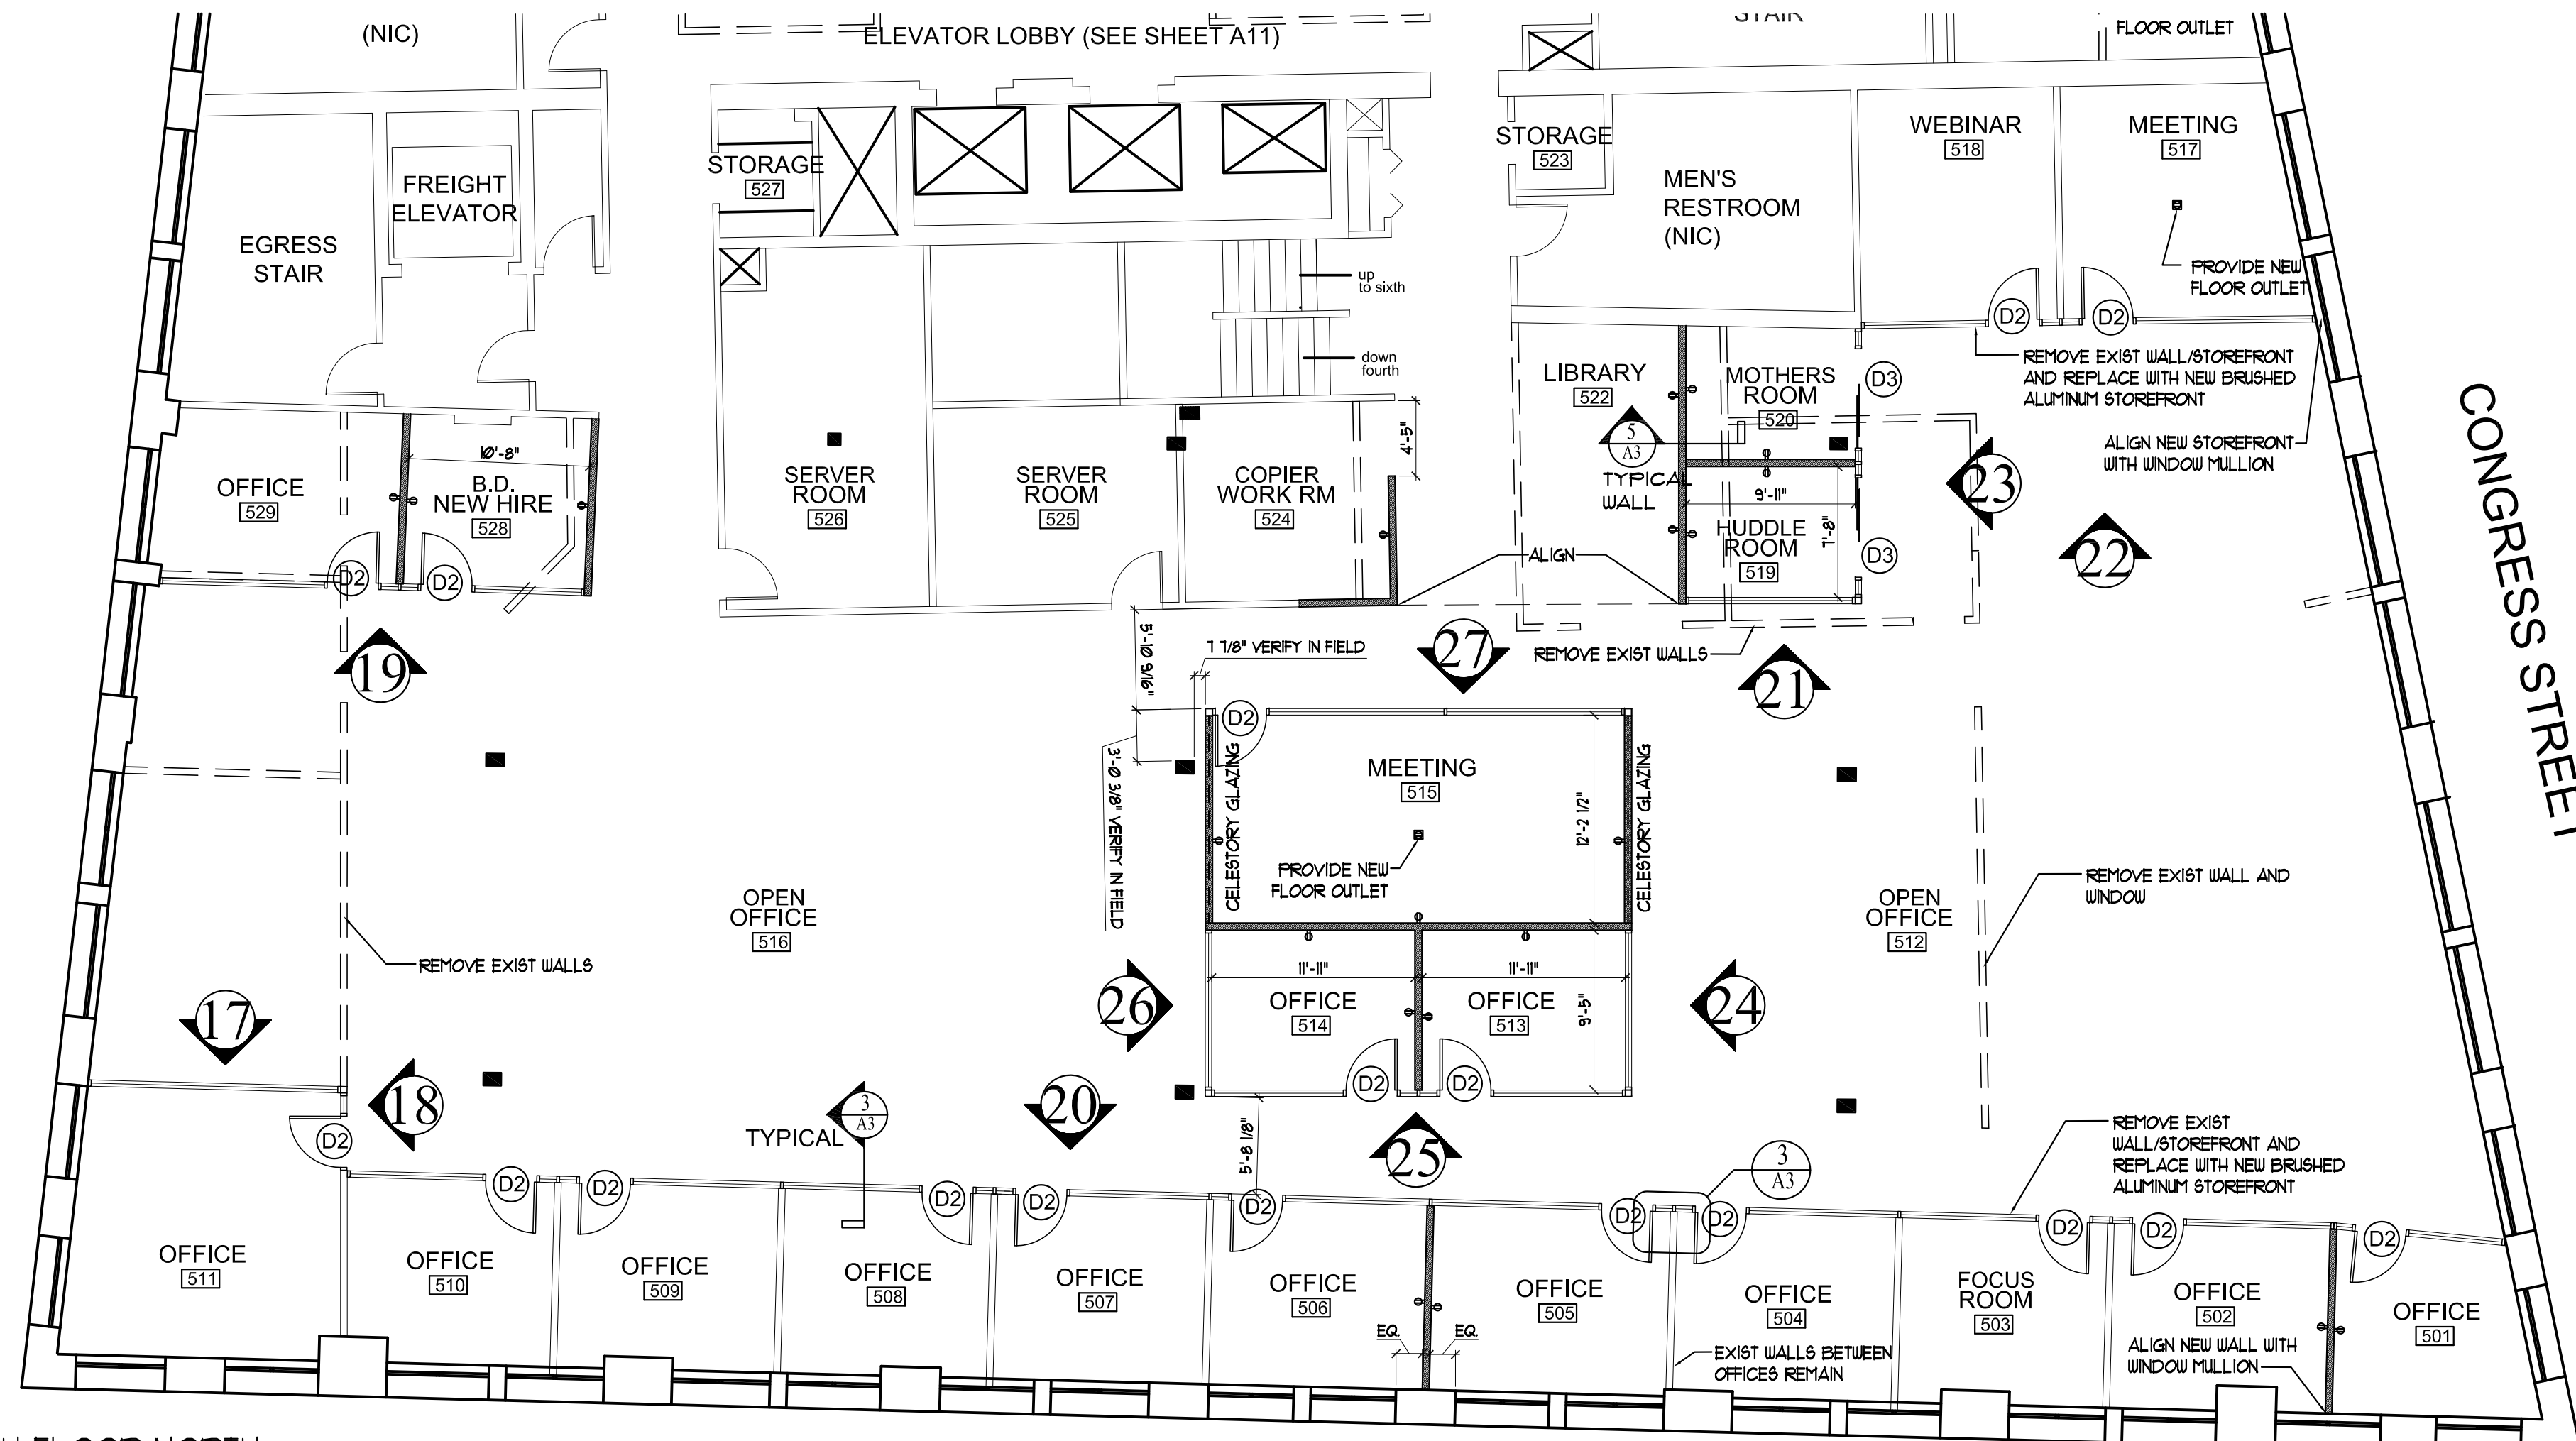

1 FLOOR PLAN - 5TH FLOOR NORTH  
SCALE: 1/8"=1'-0"

**WHITEED**  
PLANNING + DESIGN

**ARCHETYPE**  
architects

Architect:

48 Union Wharf Portland, Maine 04101  
(207) 772-6022 Fax (207) 772-4056

Project:

**DIVERSIFIED COMMUNICATIONS**

Revisions:


Date:

4 December 2012

Scale:

AS NOTED

Project:

**5TH FLOOR NORTH FLOOR PLAN AND REFLECTED CEILING PLAN**

Location:

PORTLAND, MAINE 04101

A5