
 
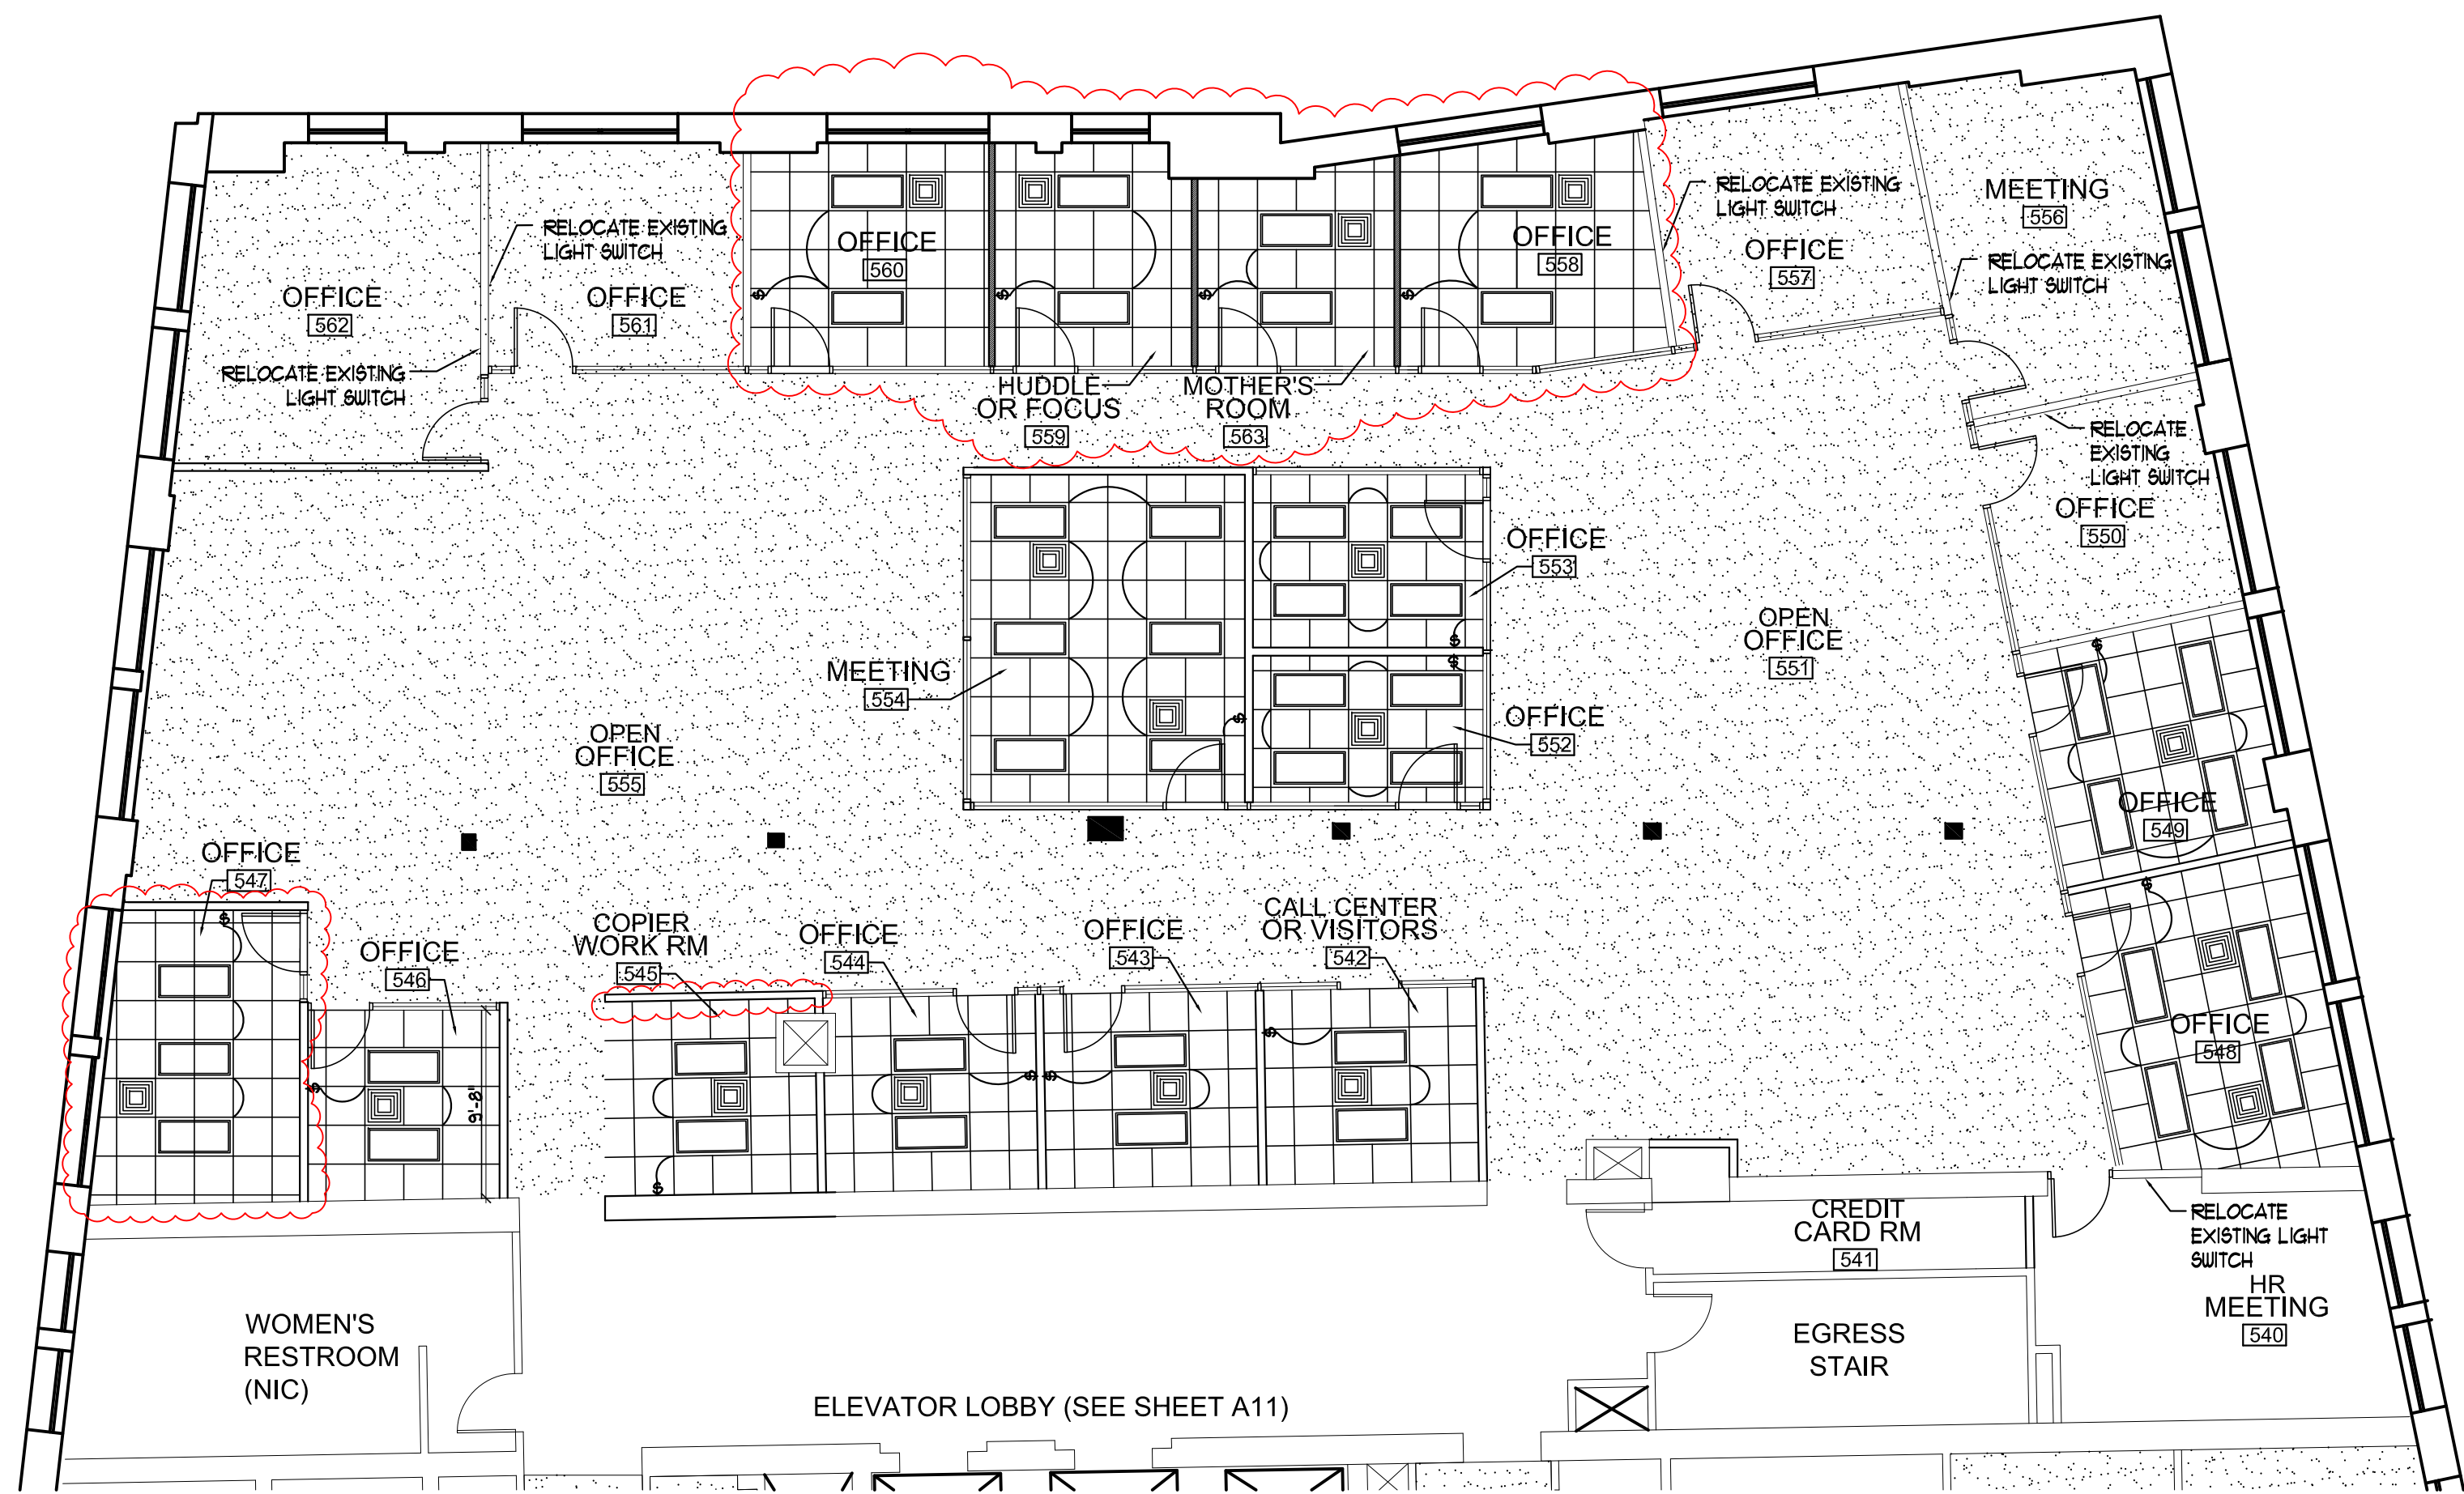


KEY PLAN
N.T.S.


RCP LEGEND	
	NEW 24x24 ACT TILES IN NEW GRID SYSTEM
	NEW 24x24 ACT TILES AND NEW CEILING LIGHT FIXTURES IN EXISTING GRID SYSTEM
	NEW 24x48 CEILING LIGHT FIXTURE
	NEW DIFFUSER
	NEW SINGLE SWITCH



2 REFLECTED CEILING PLAN - 5TH FLOOR SOUTH

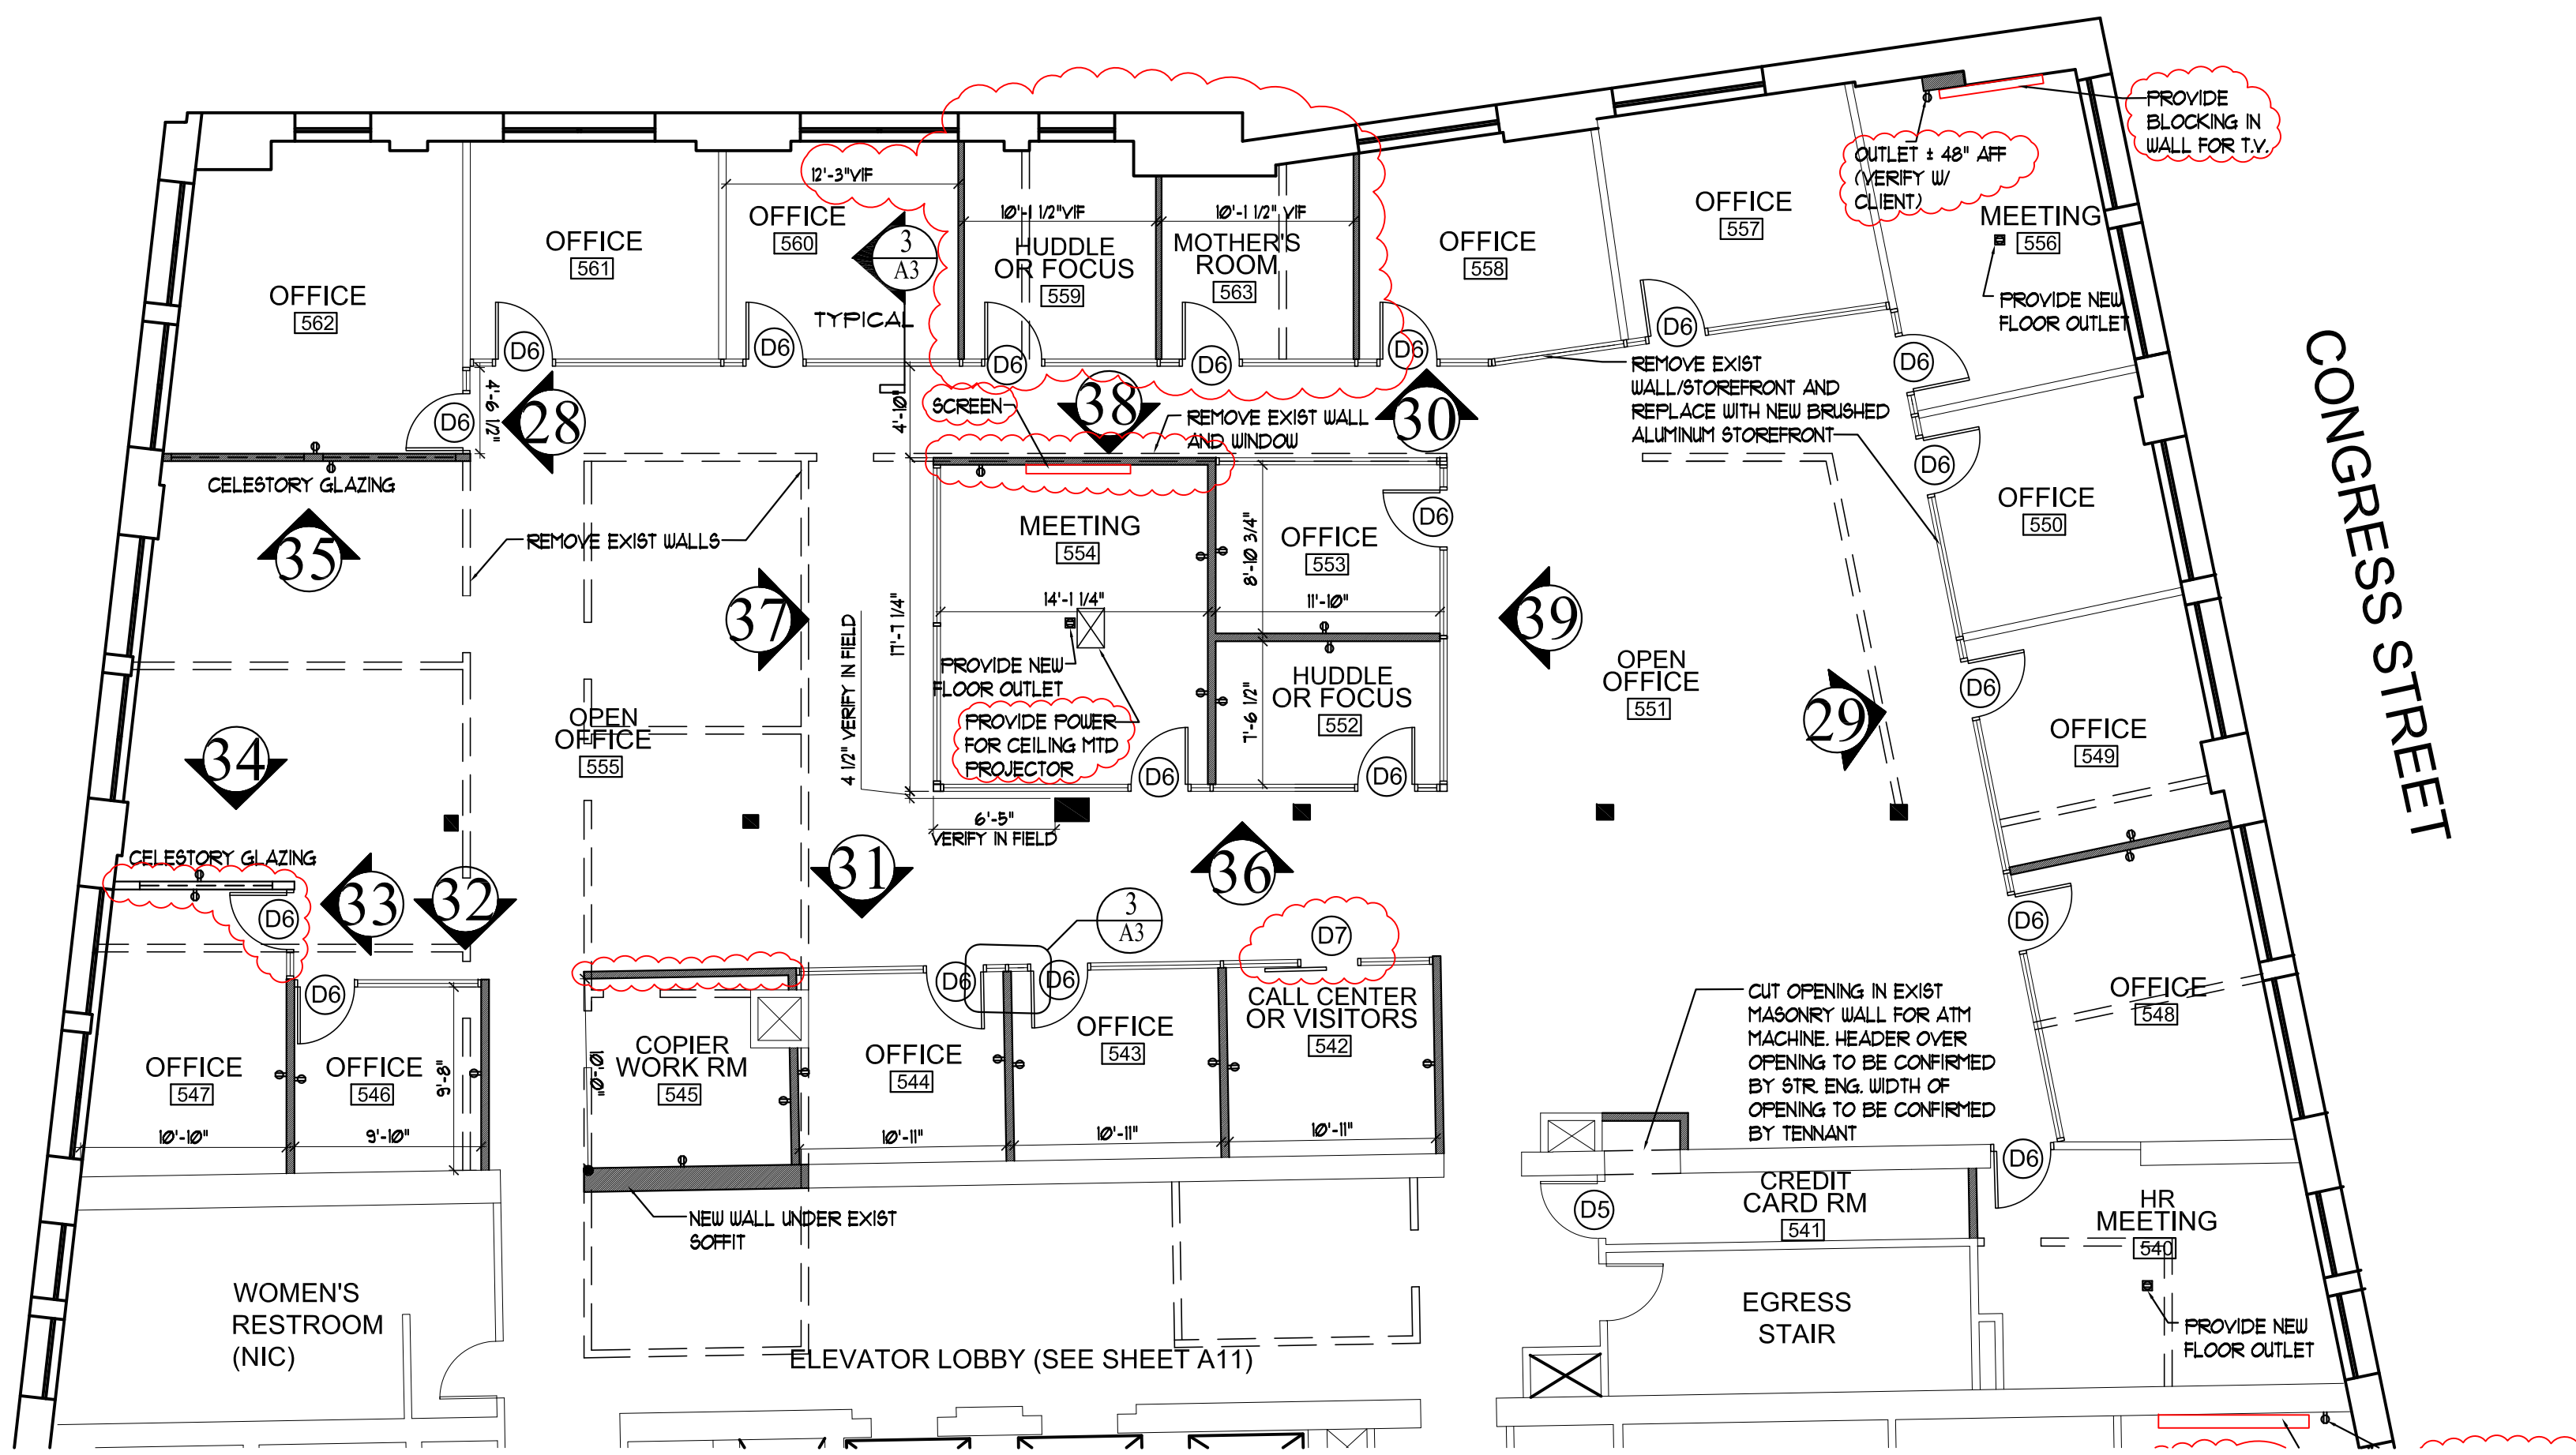

1 FLOOR PLAN - 5TH FLOOR SOUTH
SCALE: 1/8" = 1'-0"

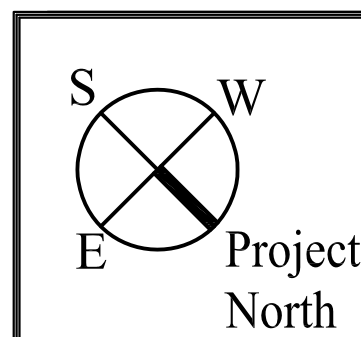

Architect:
ARCHETYPE
 architects
 48 Union Wharf Portland, Maine 04101
 (207) 772-6022 Fax (207) 772-4056

Project:
 DIVERSIFIED
 COMMUNICATIONS
 PORTLAND, MAINE 04101

Revisions:

Date: 4 December 2012
 Scale: AS NOTED
 5TH FLOOR SOUTH
 FLOOR PLAN AND
 REFLECTED CEILING PLAN

A6