


REPLACE TWO (2) TAMPER SWITCHES
FLOW & TAMPER SWITCHES
LSM-

FLOW & TAMPER SWITCHES
LSM-

GENERAL NOTES:
REPLACE EXISTING SPEAKER/STROBE & STROBE DEVICE.
BLUE COLOR = INDICATES NEW DEVICE.

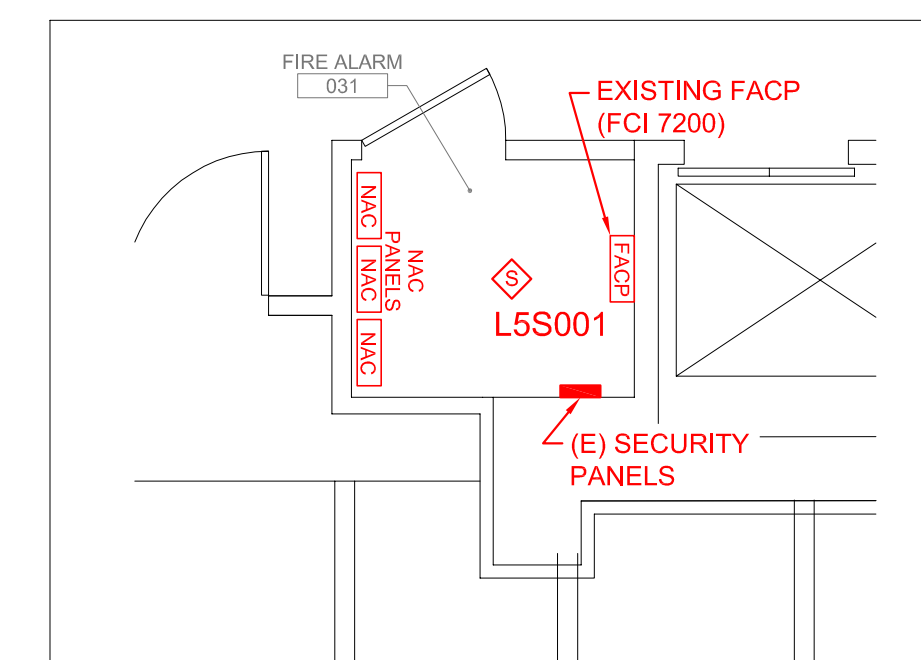

A8 FIRE ALARM ROOM

SCALE: 1/4"=1'-0"

A1 FIRE ALARM LAYOUT

SCALE: 1/8"=1'-0"

Anthony Mancini, Inc.
179 SHERIDAN ST.
PORTLAND, ME 04101
P: (207) 774-5829 F: (207) 772-1686
E: info@mancinielectric.com
"We appreciate Your Business."



NO.	DATE	DESCRIPTION

PROJECT NAME & ADDRESS:

Maine College of Art
Congress Street
Portland, Maine

SHEET NAME:

Basement - Fire Alarm

Date: 06.12.2015


Scale:

Checked By: G. MANCINI
A. AMES

SHEET:

EO

AS-BUILT FIRE ALARM

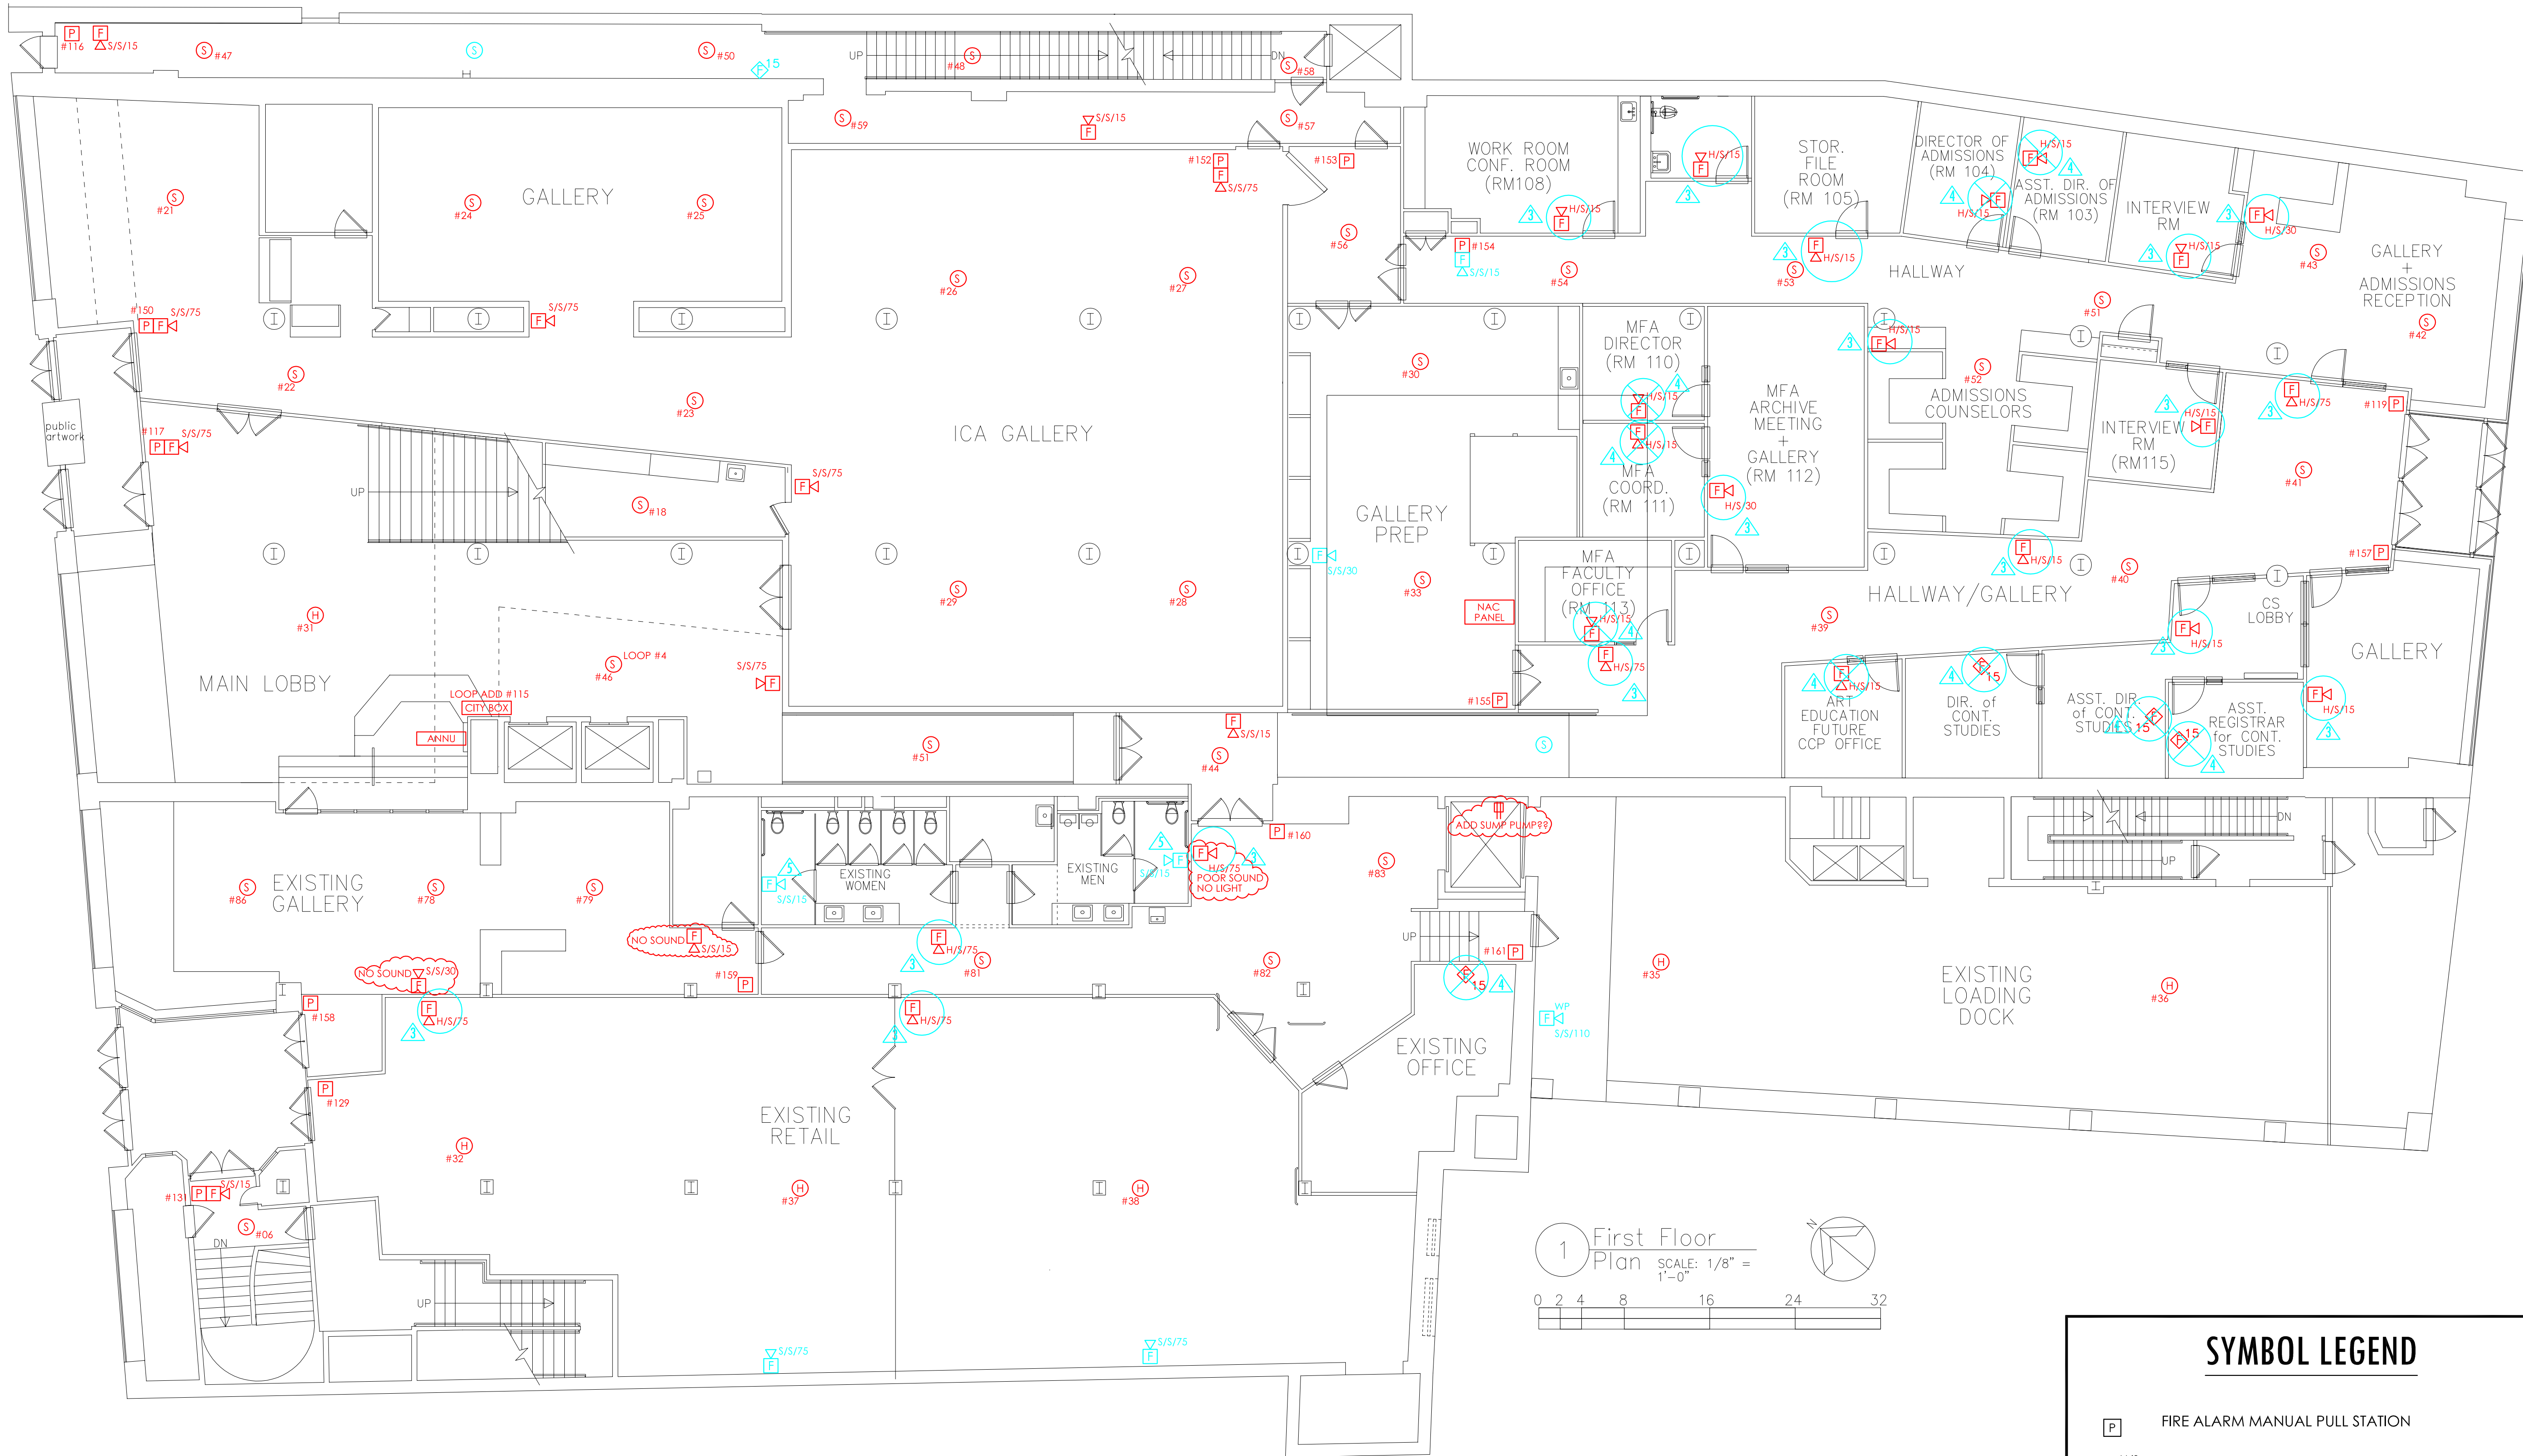

1 First Floor
Plan SCALE: 1/8" = 1'-0"
0 2 4 8 16 24 32

- GENERAL NOTES:**
- ▲ REPLACE ALL EXISTING SPEAKER/STROBE & STROBE DEVICES.
 - ▲ BLUE COLOR = INDICATES NEW DEVICE.
 - ▲ REPLACE EXISTING HORN/STROBE WITH SPEAKER/STROBE DEVICE.
 - ▲ REMOVE EXISTING DEVICE.
 - ▲ REPLACE EXISTING STROBE DEVICE WITH SPEAKER/STROBE DEVICE.

SYMBOL LEGEND	
	FIRE ALARM MANUAL PULL STATION
	FIRE ALARM HORN AND STROBE UNIT
	FIRE ALARM SPEAKER AND STROBE UNIT
	FIRE ALARM STROBE UNIT
	SMOKE DETECTOR - CEILING MOUNTED
	HEAT DETECTOR - CEILING MOUNTED
	DUCT SMOKE DETECTOR - HVAC DUCT MOUNTED

AS-BUILT FIRE ALARM

Anthony Mancini, Inc.
179 SHERIDAN ST.
PORTLAND, ME 04101
P: (207)774-5829 F: (207)772-1686
E: info@mancinielectric.com
"We appreciate Your Business."




NO.	DATE	DESCRIPTION


PROJECT NAME & ADDRESS:
Maine College of Art
Congress Street
Portland, Maine

SHEET NAME:
First Floor - Fire Alarm
Checked By: G. MANCINI
Drawn By: A. AMES
Date: 06.12.2015
Scale:

SHEET:
E1

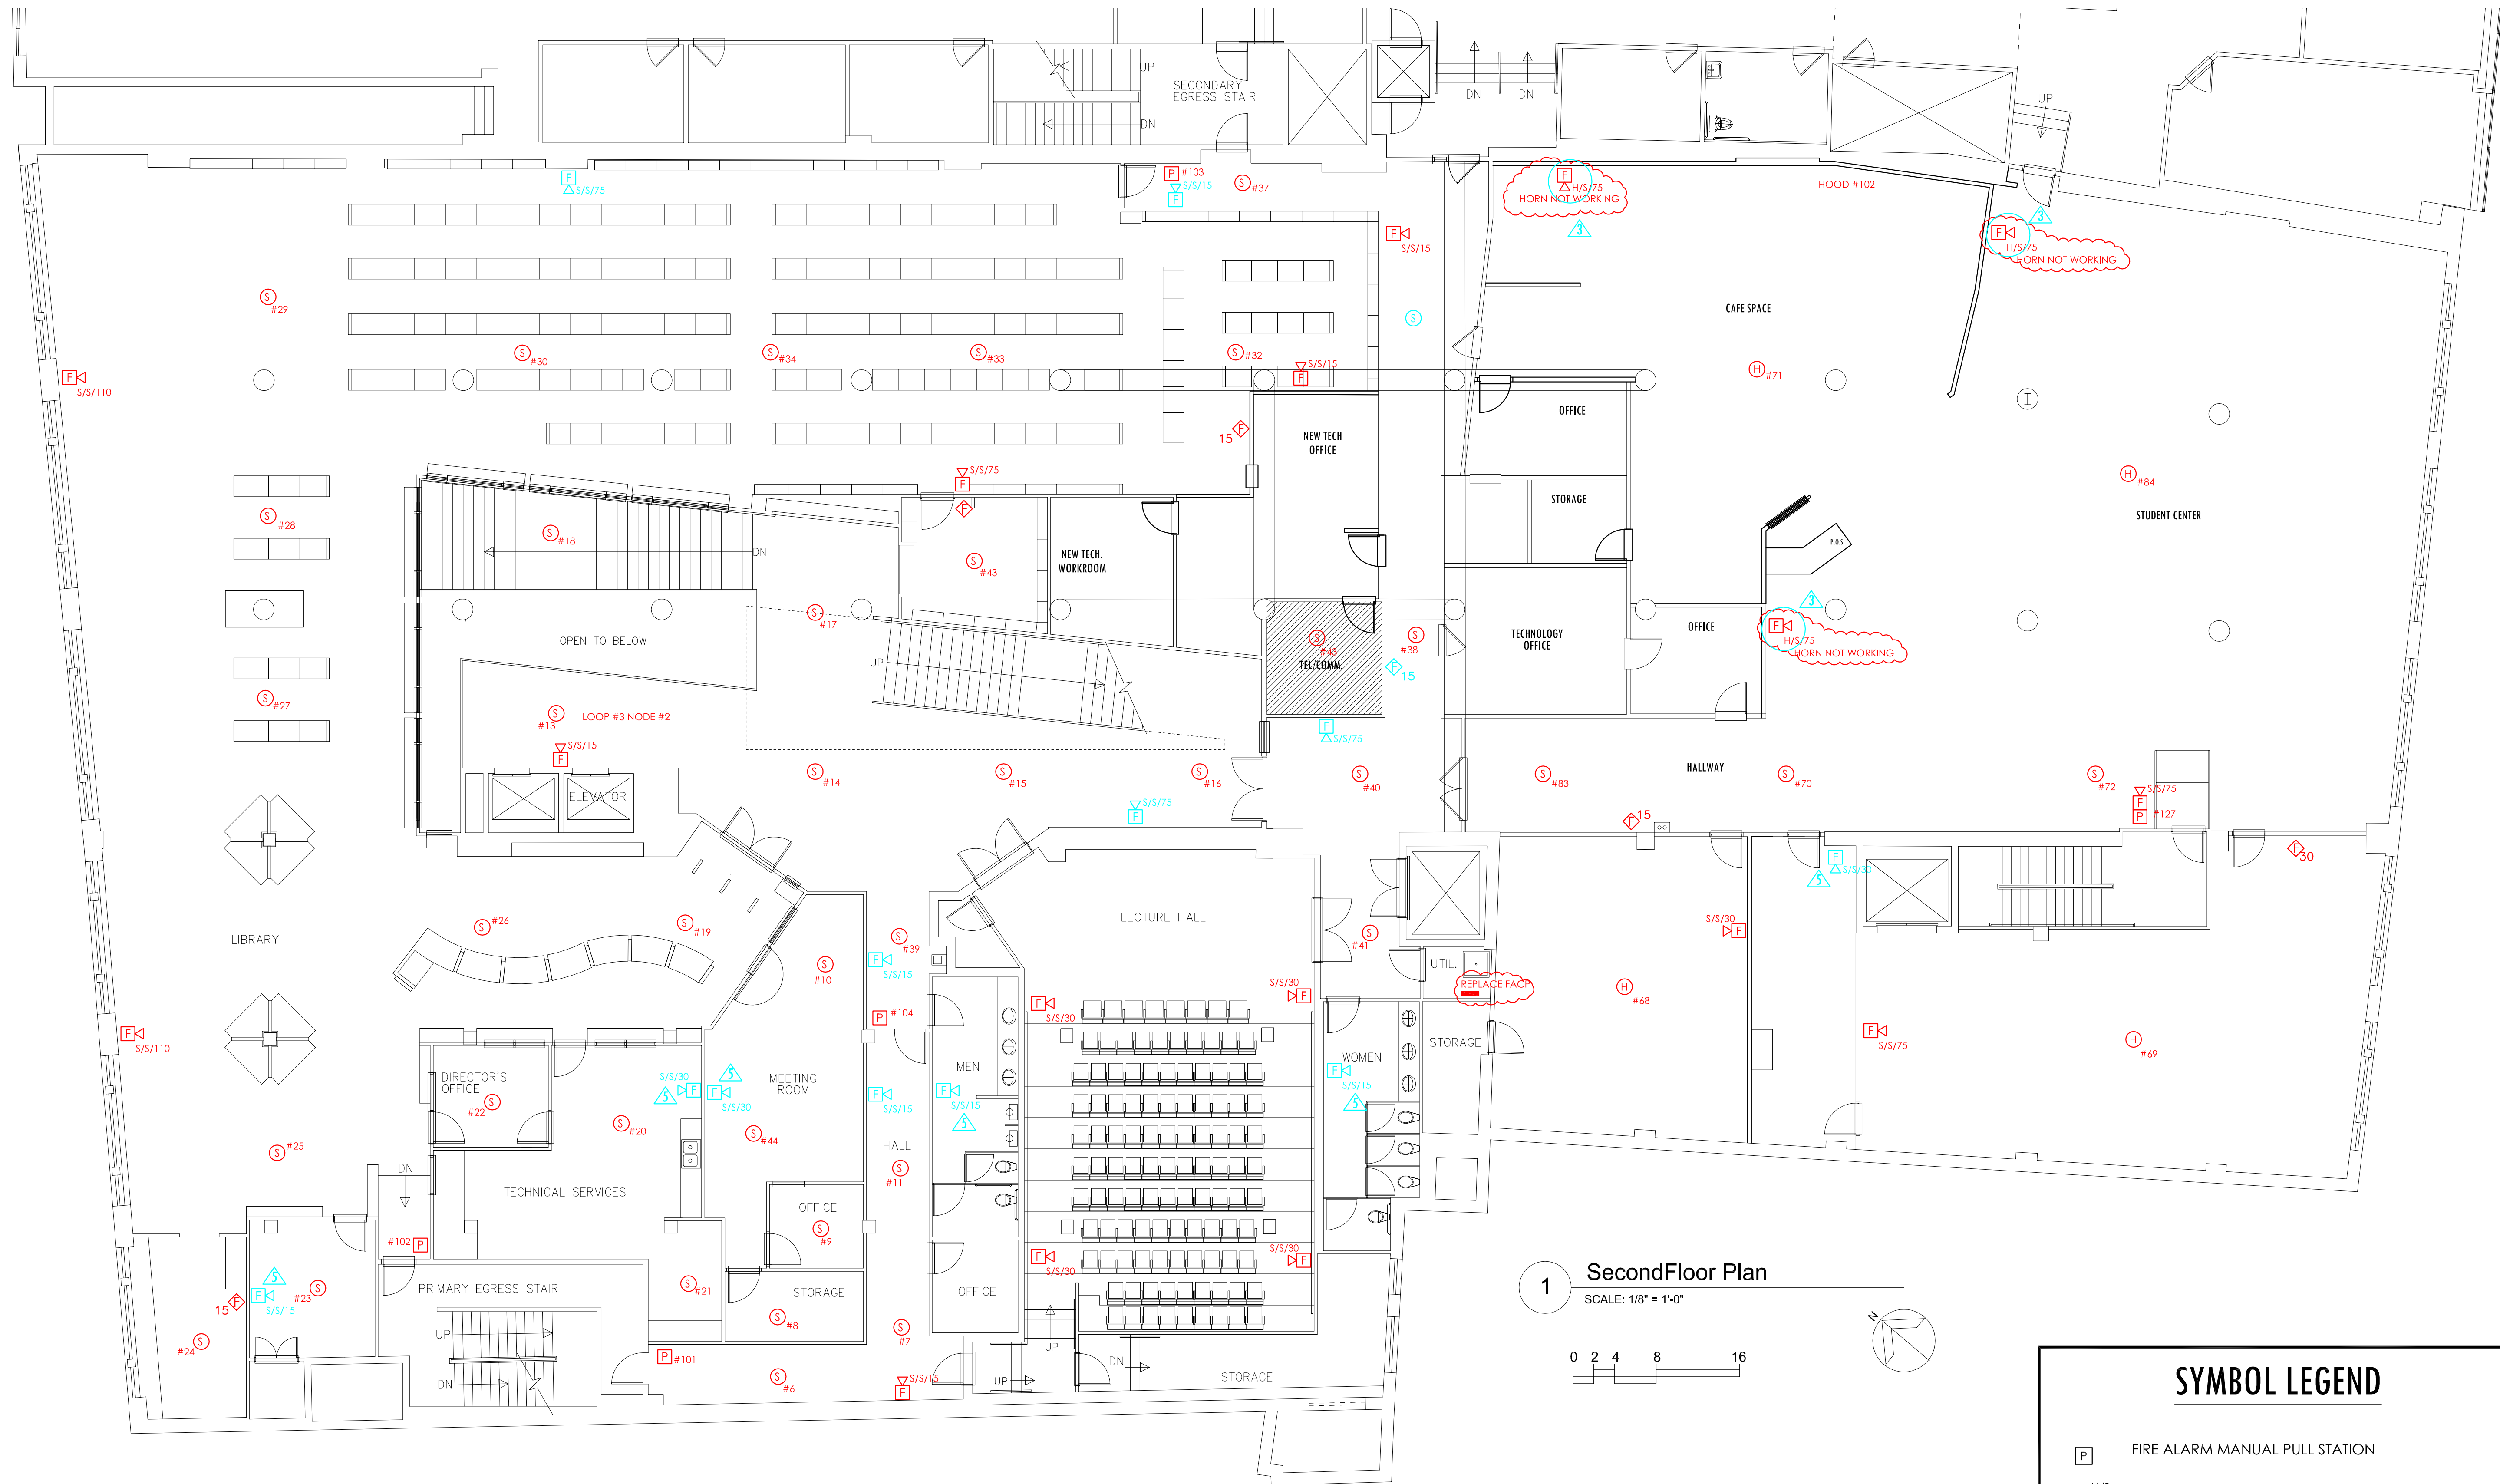

1 SecondFloor Plan
SCALE: 1/8" = 1'-0"

 

- GENERAL NOTES:
- ▲ REPLACE ALL EXISTING SPEAKER/STROBE & STROBE DEVICES.
 - ▲ BLUE COLOR = INDICATES NEW DEVICE.
 - ▲ REPLACE EXISTING HORN/STROBE WITH SPEAKER/STROBE DEVICE.
 - ▲ REMOVE EXISTING DEVICE.
 - ▲ REPLACE EXISTING STROBE DEVICE WITH SPEAKER/STROBE DEVICE.

SYMBOL LEGEND	
	FIRE ALARM MANUAL PULL STATION
	FIRE ALARM HORN AND STROBE UNIT
	FIRE ALARM SPEAKER AND STROBE UNIT
	FIRE ALARM STROBE UNIT
	SMOKE DETECTOR - CEILING MOUNTED
	HEAT DETECTOR - CEILING MOUNTED
	DUCT SMOKE DETECTOR - HVAC DUCT MOUNTED

AS-BUILT FIRE ALARM

Anthony Mancini, Inc.
179 SHERIDAN ST.
PORTLAND, ME 04101
P: (207)774-5829 F: (207)772-1686
E: info@mancinielectric.com
"We appreciate Your Business."



NO.	DATE	DESCRIPTION


PROJECT NAME & ADDRESS:
Maine College of Art
Congress Street
Portland, Maine

SHEET NAME:
Second Floor - Fire Alarm

Checked By: G. MANCINI
Drawn By: A. AMES

Date: 06.12.2015
Scale:

SHEET:
E2

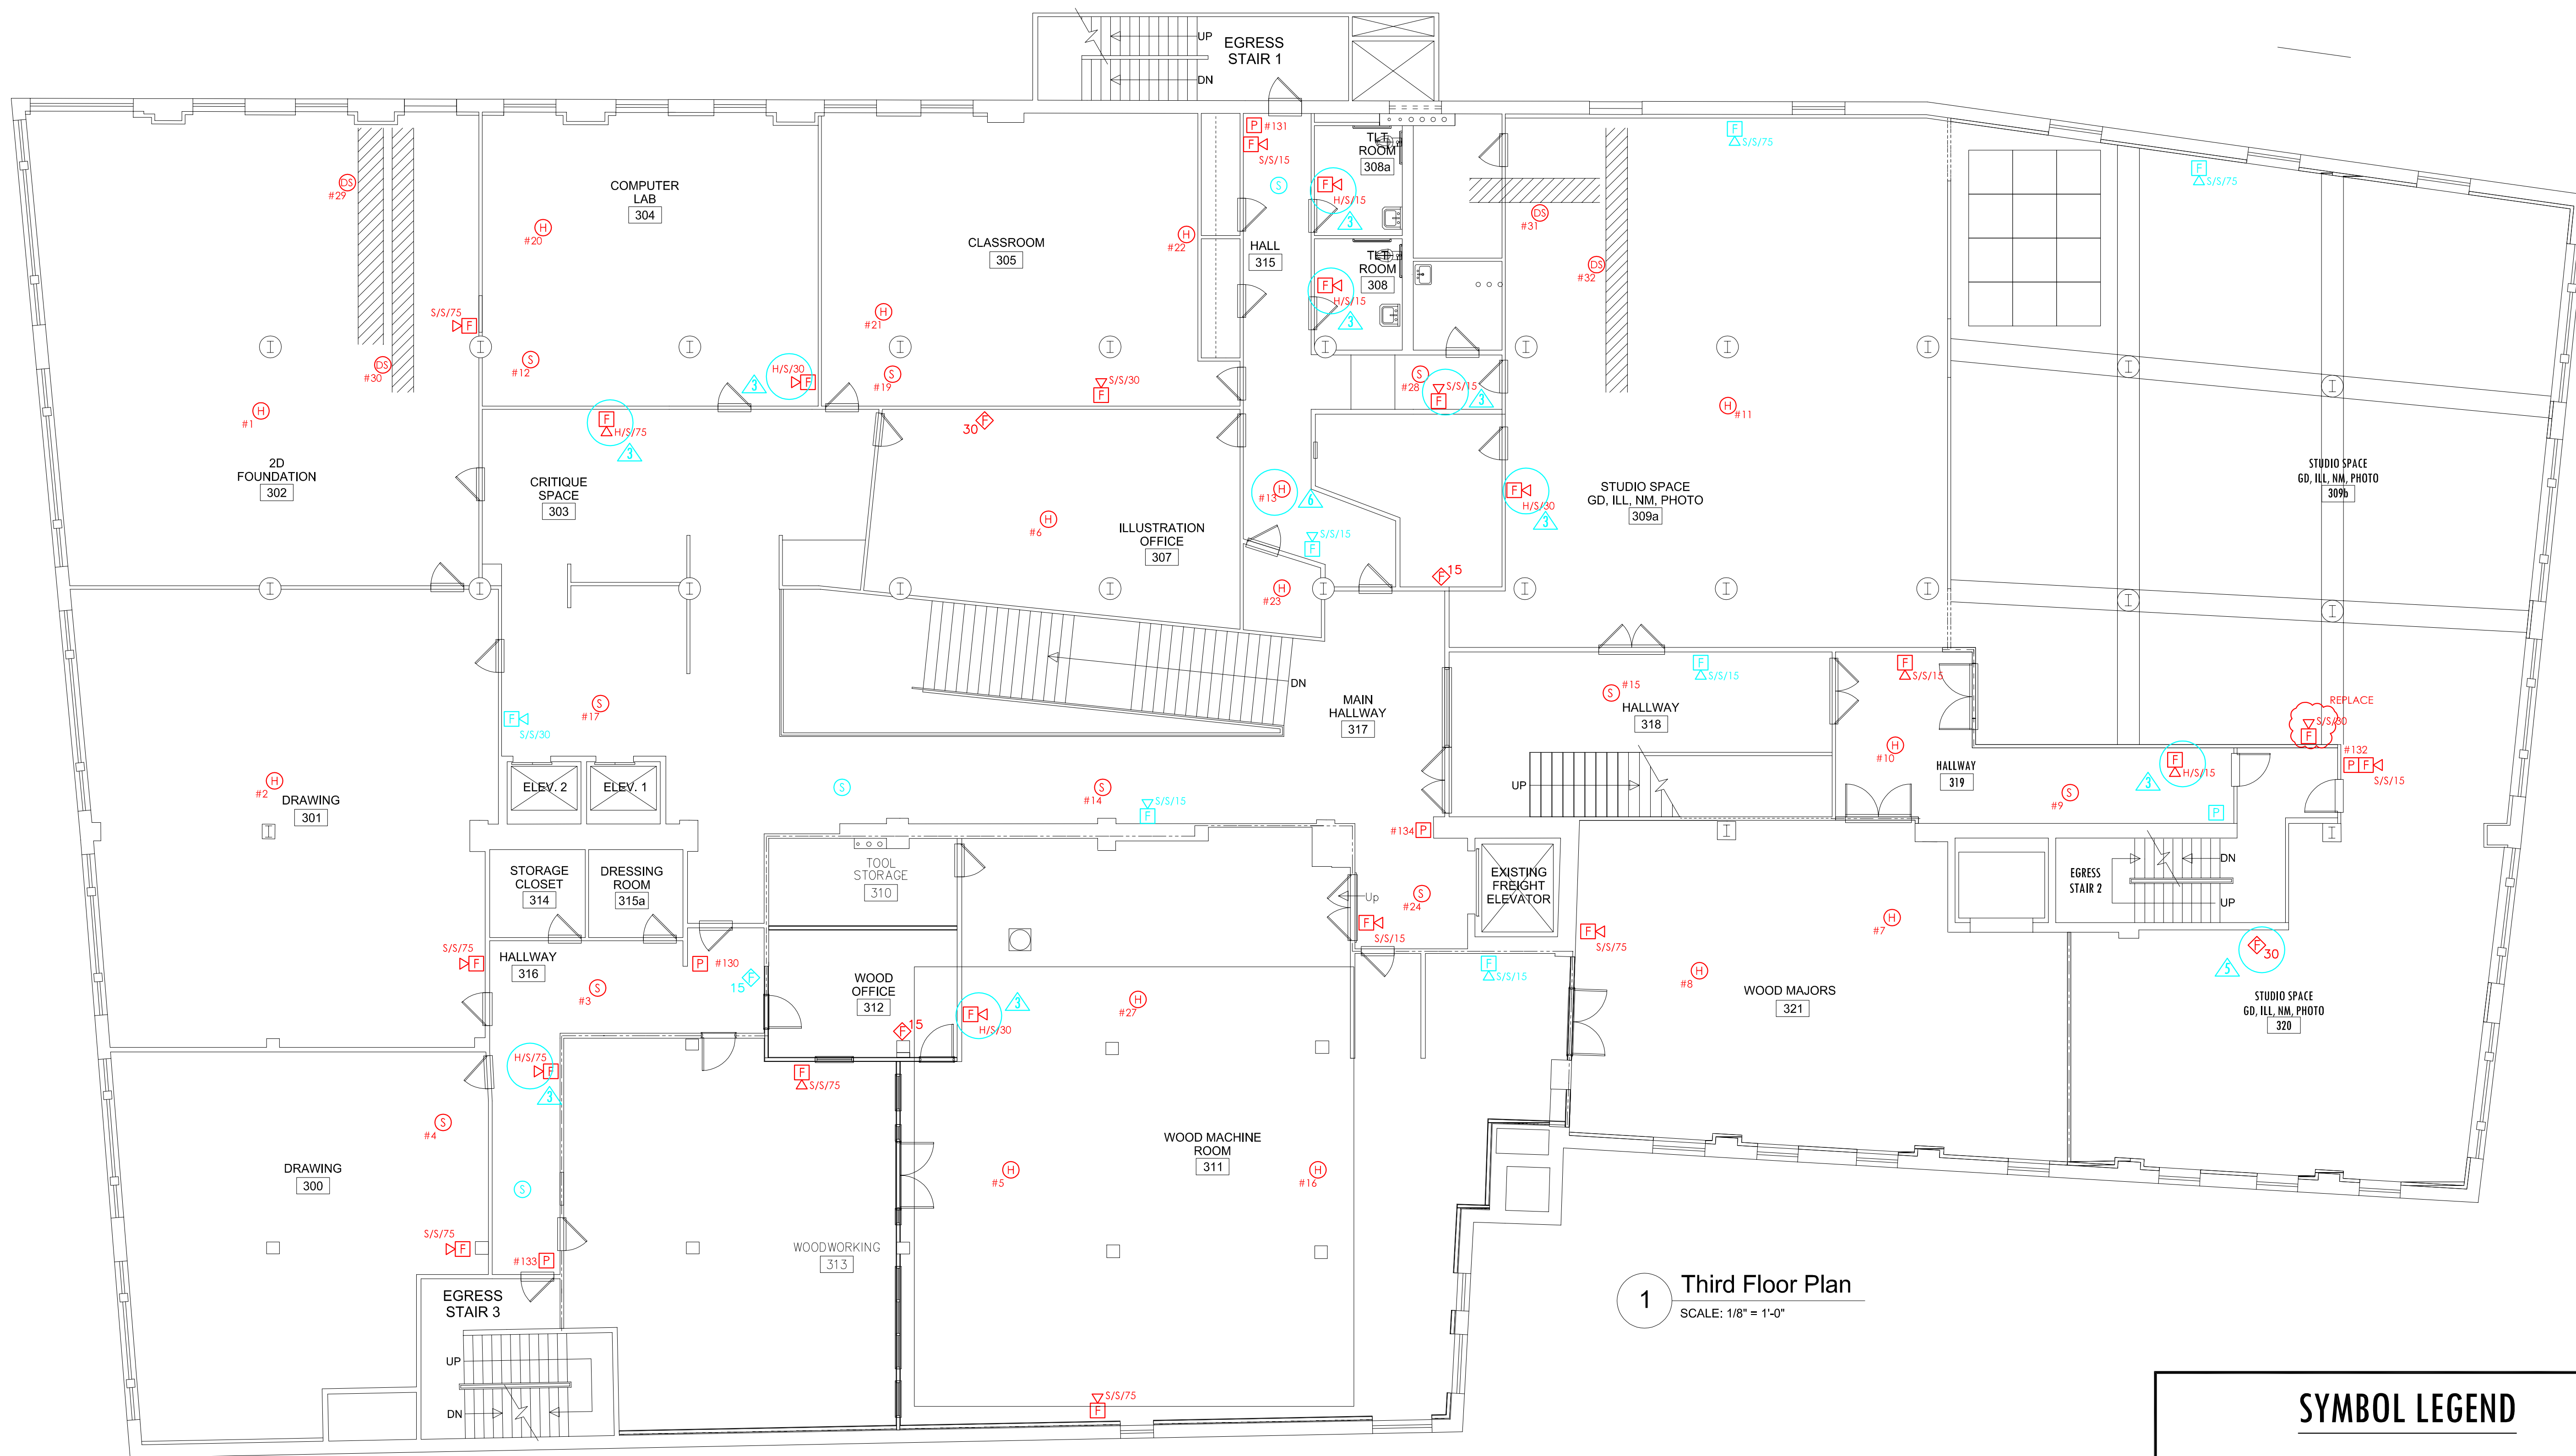

1 Third Floor Plan
SCALE: 1/8" = 1'-0"

- GENERAL NOTES:
- ▲ REPLACE ALL EXISTING SPEAKER/STROBE & STROBE DEVICES.
 - ▲ BLUE COLOR = INDICATES NEW DEVICE.
 - ▲ REPLACE EXISTING HORN/STROBE WITH SPEAKER/STROBE DEVICE.
 - ▲ REMOVE EXISTING DEVICE.
 - ▲ REPLACE EXISTING STROBE DEVICE WITH SPEAKER/STROBE DEVICE.
 - ▲ REPLACE EXISTING HEAT DETECTOR WITH SMOKE DETECTOR.

SYMBOL LEGEND	
	FIRE ALARM MANUAL PULL STATION
	FIRE ALARM HORN AND STROBE UNIT
	FIRE ALARM SPEAKER AND STROBE UNIT
	FIRE ALARM STROBE UNIT
	SMOKE DETECTOR - CEILING MOUNTED
	HEAT DETECTOR - CEILING MOUNTED
	DUCT SMOKE DETECTOR - HVAC DUCT MOUNTED

AS-BUILT FIRE ALARM

Anthony Mancini, Inc.
179 SHERIDAN ST.
PORTLAND, ME 04101
P: (207)774-5829 F: (207)772-1686
E: info@mancinielectric.com
"We appreciate Your Business."

NO.	DATE	DESCRIPTION



PROJECT NAME & ADDRESS:
Maine College of Art
Congress Street
Portland, Maine

SHEET NAME:
Third Floor - Fire Alarm

Checked By: G. MANCINI
Drawn By: A. AMES

Date: 06.12.2015
Scale:

SHEET:
E3

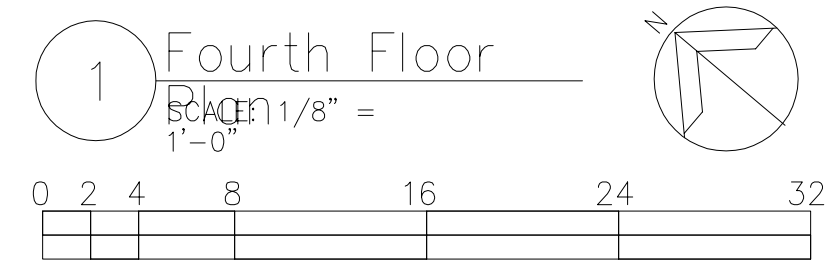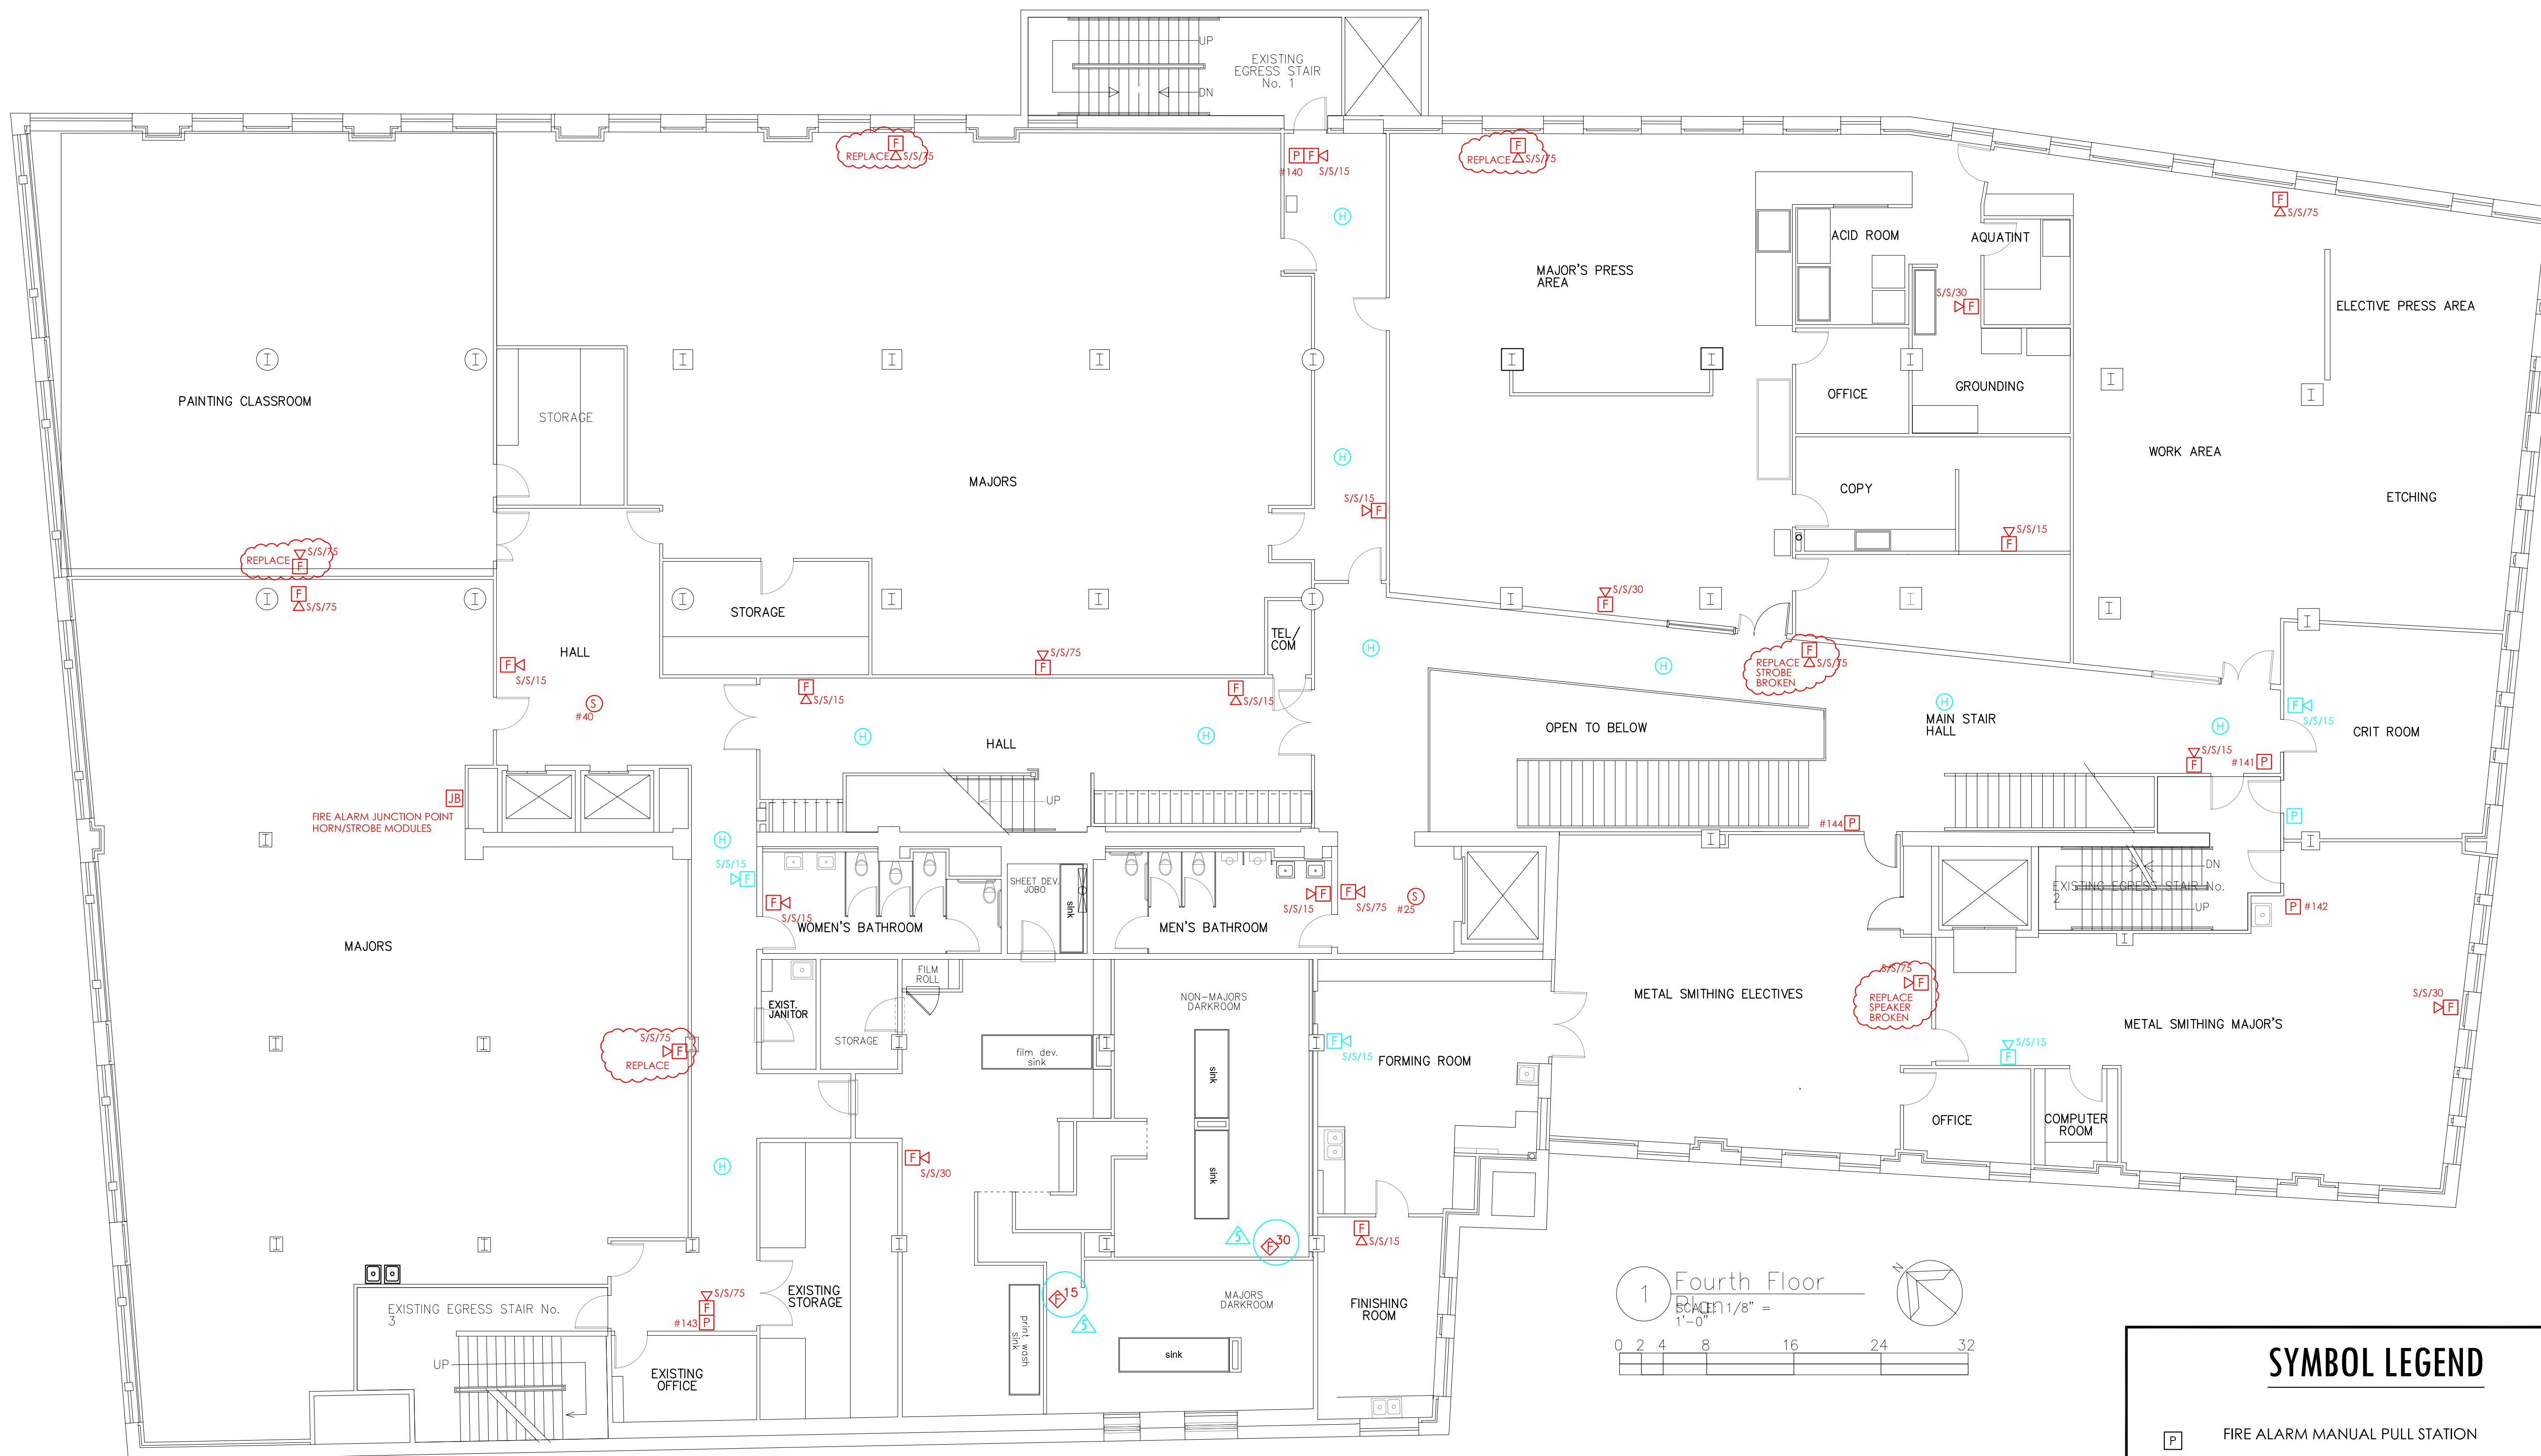

- GENERAL NOTES:**
- ▲ REPLACE ALL EXISTING SPEAKER/STROBE & STROBE DEVICES.
 - ▲ BLUE COLOR = INDICATES NEW DEVICE.
 - ▲ REPLACE EXISTING HORN/STROBE WITH SPEAKER/STROBE DEVICE.
 - ▲ REMOVE EXISTING DEVICE.
 - ▲ REPLACE EXISTING STROBE DEVICE WITH SPEAKER/STROBE DEVICE.
 - ▲ REPLACE EXISTING HEAT DETECTOR WITH SMOKE DETECTOR.

SYMBOL LEGEND	
	FIRE ALARM MANUAL PULL STATION
	FIRE ALARM HORN AND STROBE UNIT
	FIRE ALARM SPEAKER AND STROBE UNIT
	FIRE ALARM STROBE UNIT
	SMOKE DETECTOR - CEILING MOUNTED
	HEAT DETECTOR - CEILING MOUNTED
	DUCT SMOKE DETECTOR - HVAC DUCT MOUNTED

AS-BUILT FIRE ALARM

Anthony Mancini, Inc.
 179 SHERIDAN ST.
 PORTLAND, ME 04101
 P: (207)774-5829 F: (207)772-1686
 E: info@mancinielectric.com
 "We appreciate Your Business."

NO.	DATE	DESCRIPTION


PROJECT NAME & ADDRESS:
 Maine College of Art
 Congress Street
 Portland, Maine

SHEET NAME:
 Fourth Floor - Fire Alarm

Checked By: G. MANCINI
 Drawn By: A. AMES

Date: 06.12.2015
 Scale:

SHEET:
E4

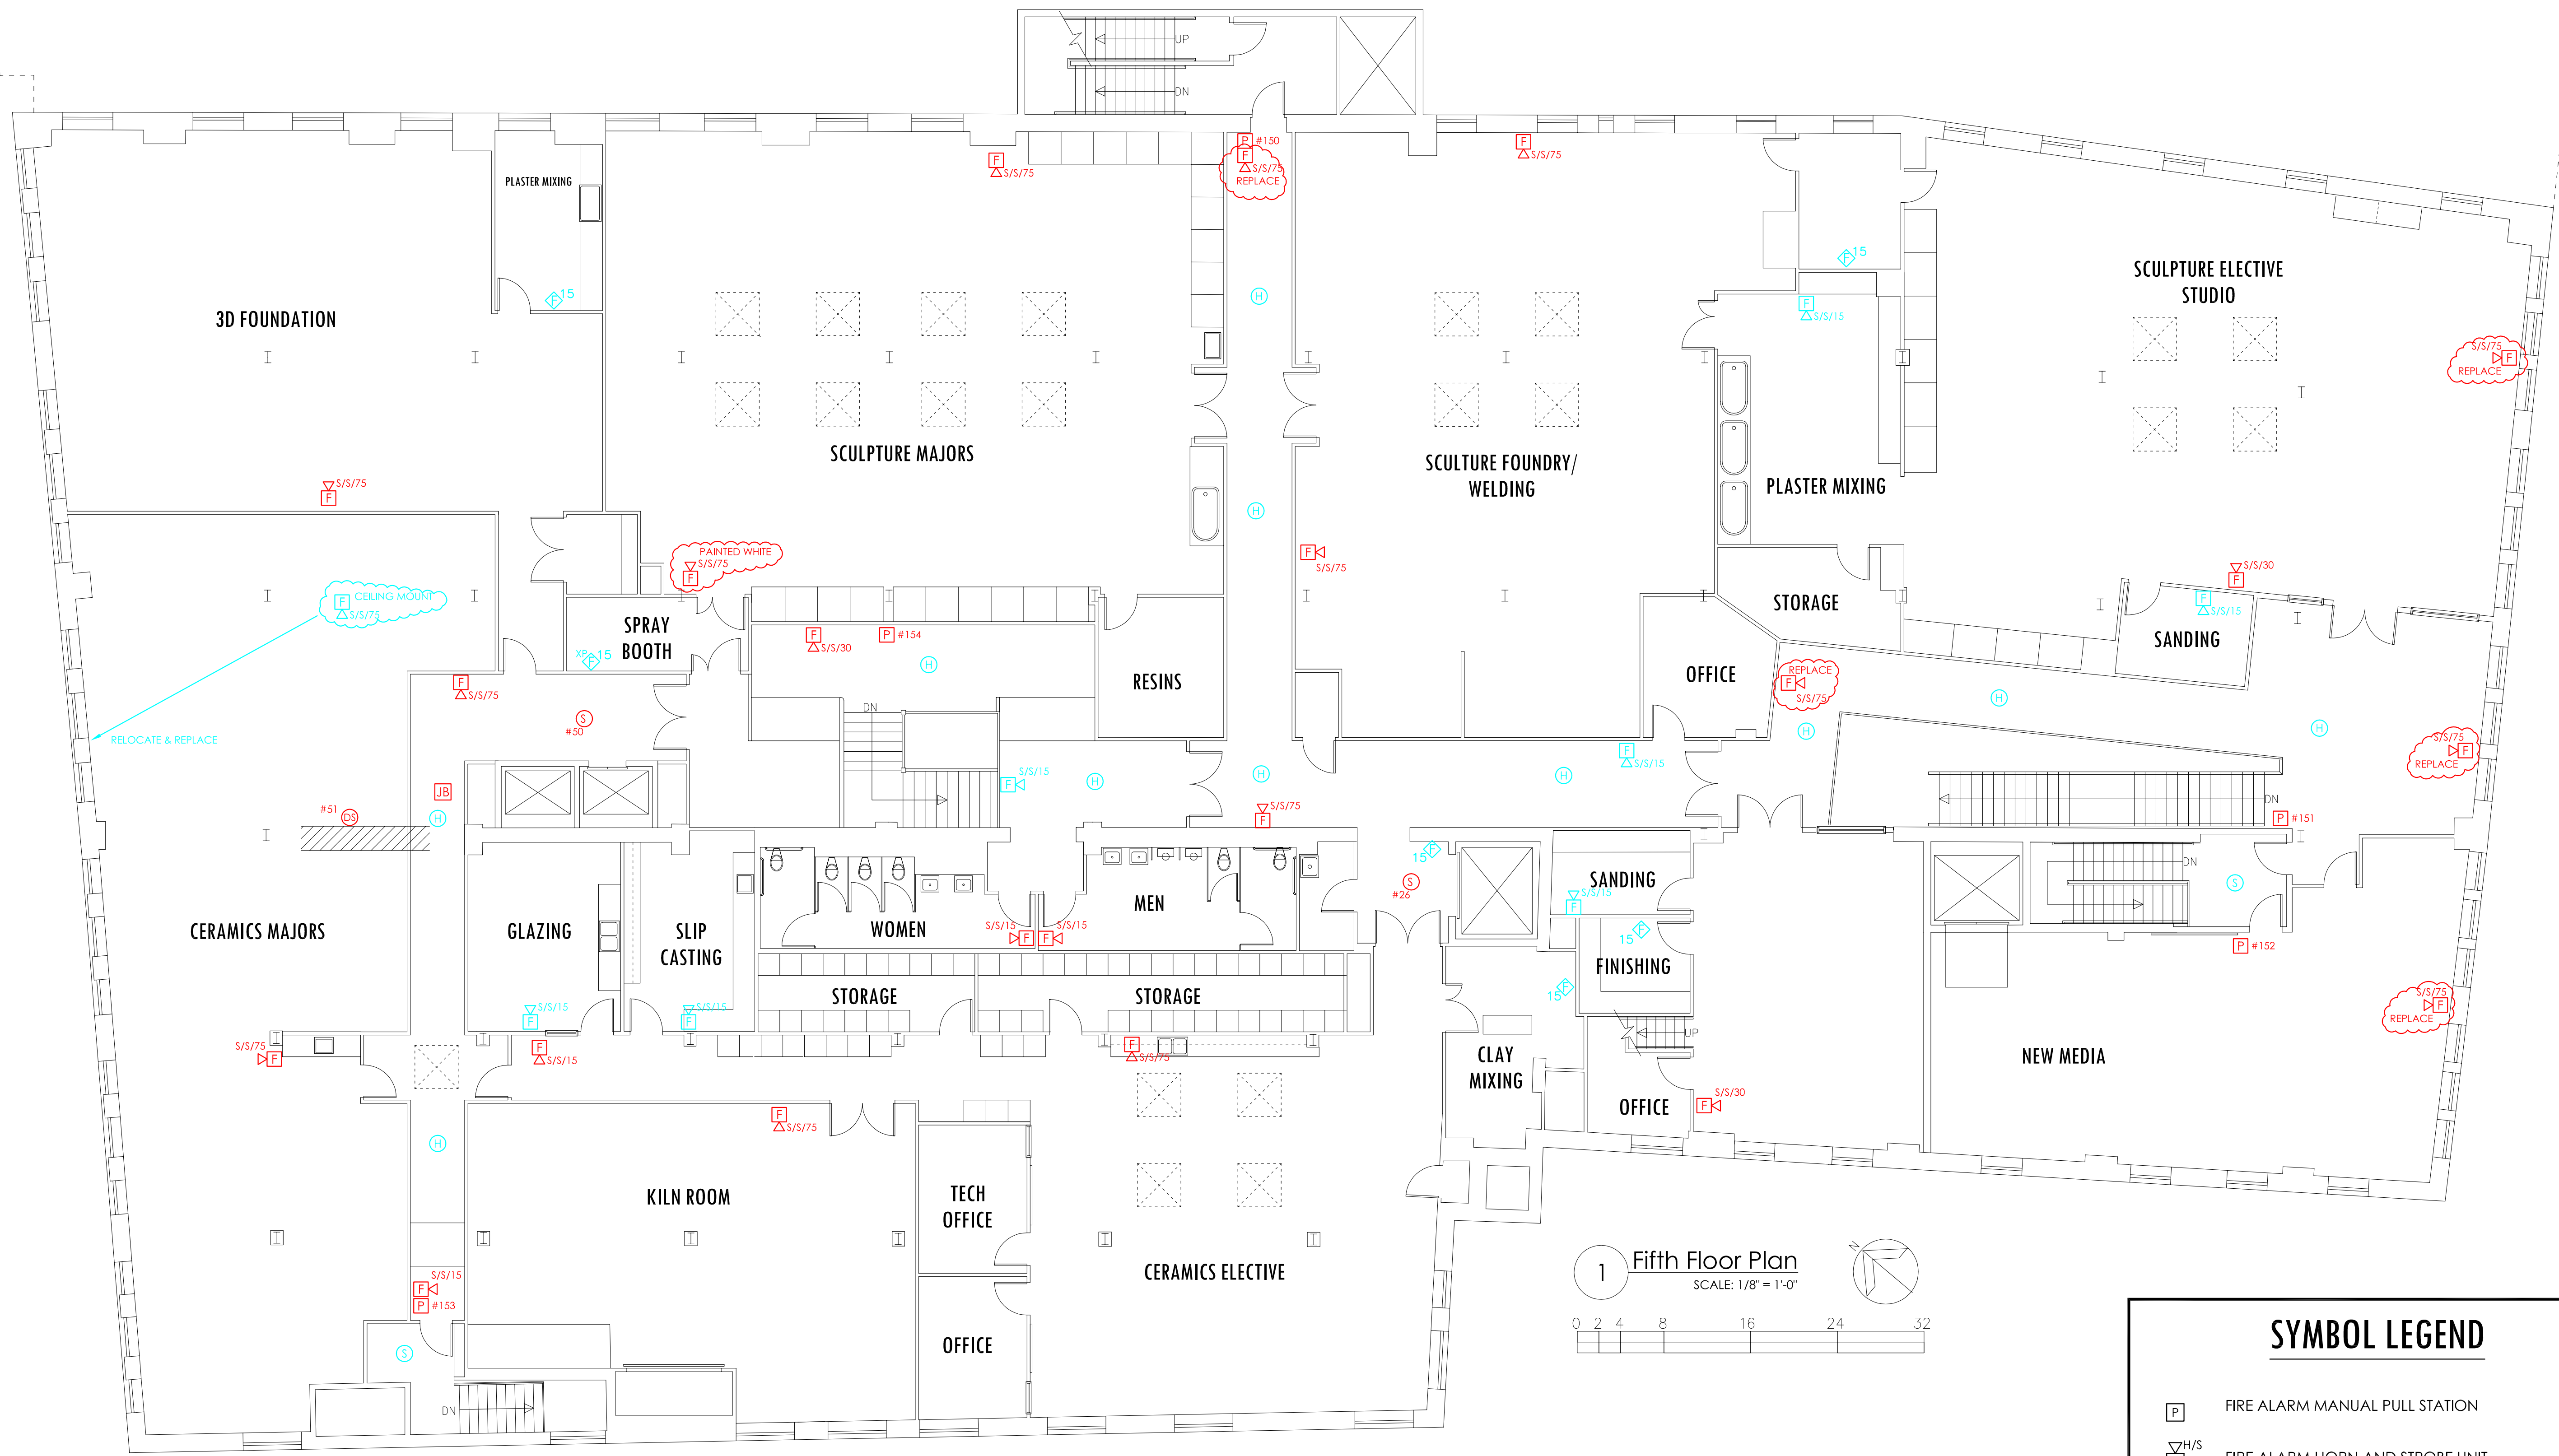

1 Fifth Floor Plan
 SCALE: 1/8" = 1'-0"
 0 2 4 8 16 24 32

- GENERAL NOTES:
- ▲ REPLACE ALL EXISTING SPEAKER/STROBE & STROBE DEVICES.
 - ▲ BLUE COLOR = INDICATES NEW DEVICE.
 - ▲ REPLACE EXISTING HORN/STROBE WITH SPEAKER/STROBE DEVICE.
 - ▲ REMOVE EXISTING DEVICE.
 - ▲ REPLACE EXISTING STROBE DEVICE WITH SPEAKER/STROBE DEVICE.
 - ▲ REPLACE EXISTING HEAT DETECTOR WITH SMOKE DETECTOR.

SYMBOL LEGEND	
	FIRE ALARM MANUAL PULL STATION
	FIRE ALARM HORN AND STROBE UNIT
	FIRE ALARM SPEAKER AND STROBE UNIT
	FIRE ALARM STROBE UNIT
	SMOKE DETECTOR - CEILING MOUNTED
	HEAT DETECTOR - CEILING MOUNTED
	DUCT SMOKE DETECTOR - HVAC DUCT MOUNTED

AS-BUILT FIRE ALARM

Anthony Mancini, Inc.
 179 SHERIDAN ST.
 PORTLAND, ME 04101
 P: (207)774-5829 F: (207)772-1686
 E: info@mancinielectric.com
 "We appreciate Your Business."

NO.	DATE	DESCRIPTION


PROJECT NAME & ADDRESS:
 Maine College of Art
 Congress Street
 Portland, Maine

SHEET NAME:
 Fifth Floor - Fire Alarm

Checked By: G. MANCINI
 Drawn By: A. AMES

Date: 06.12.2015
 Scale:

SHEET:
E5

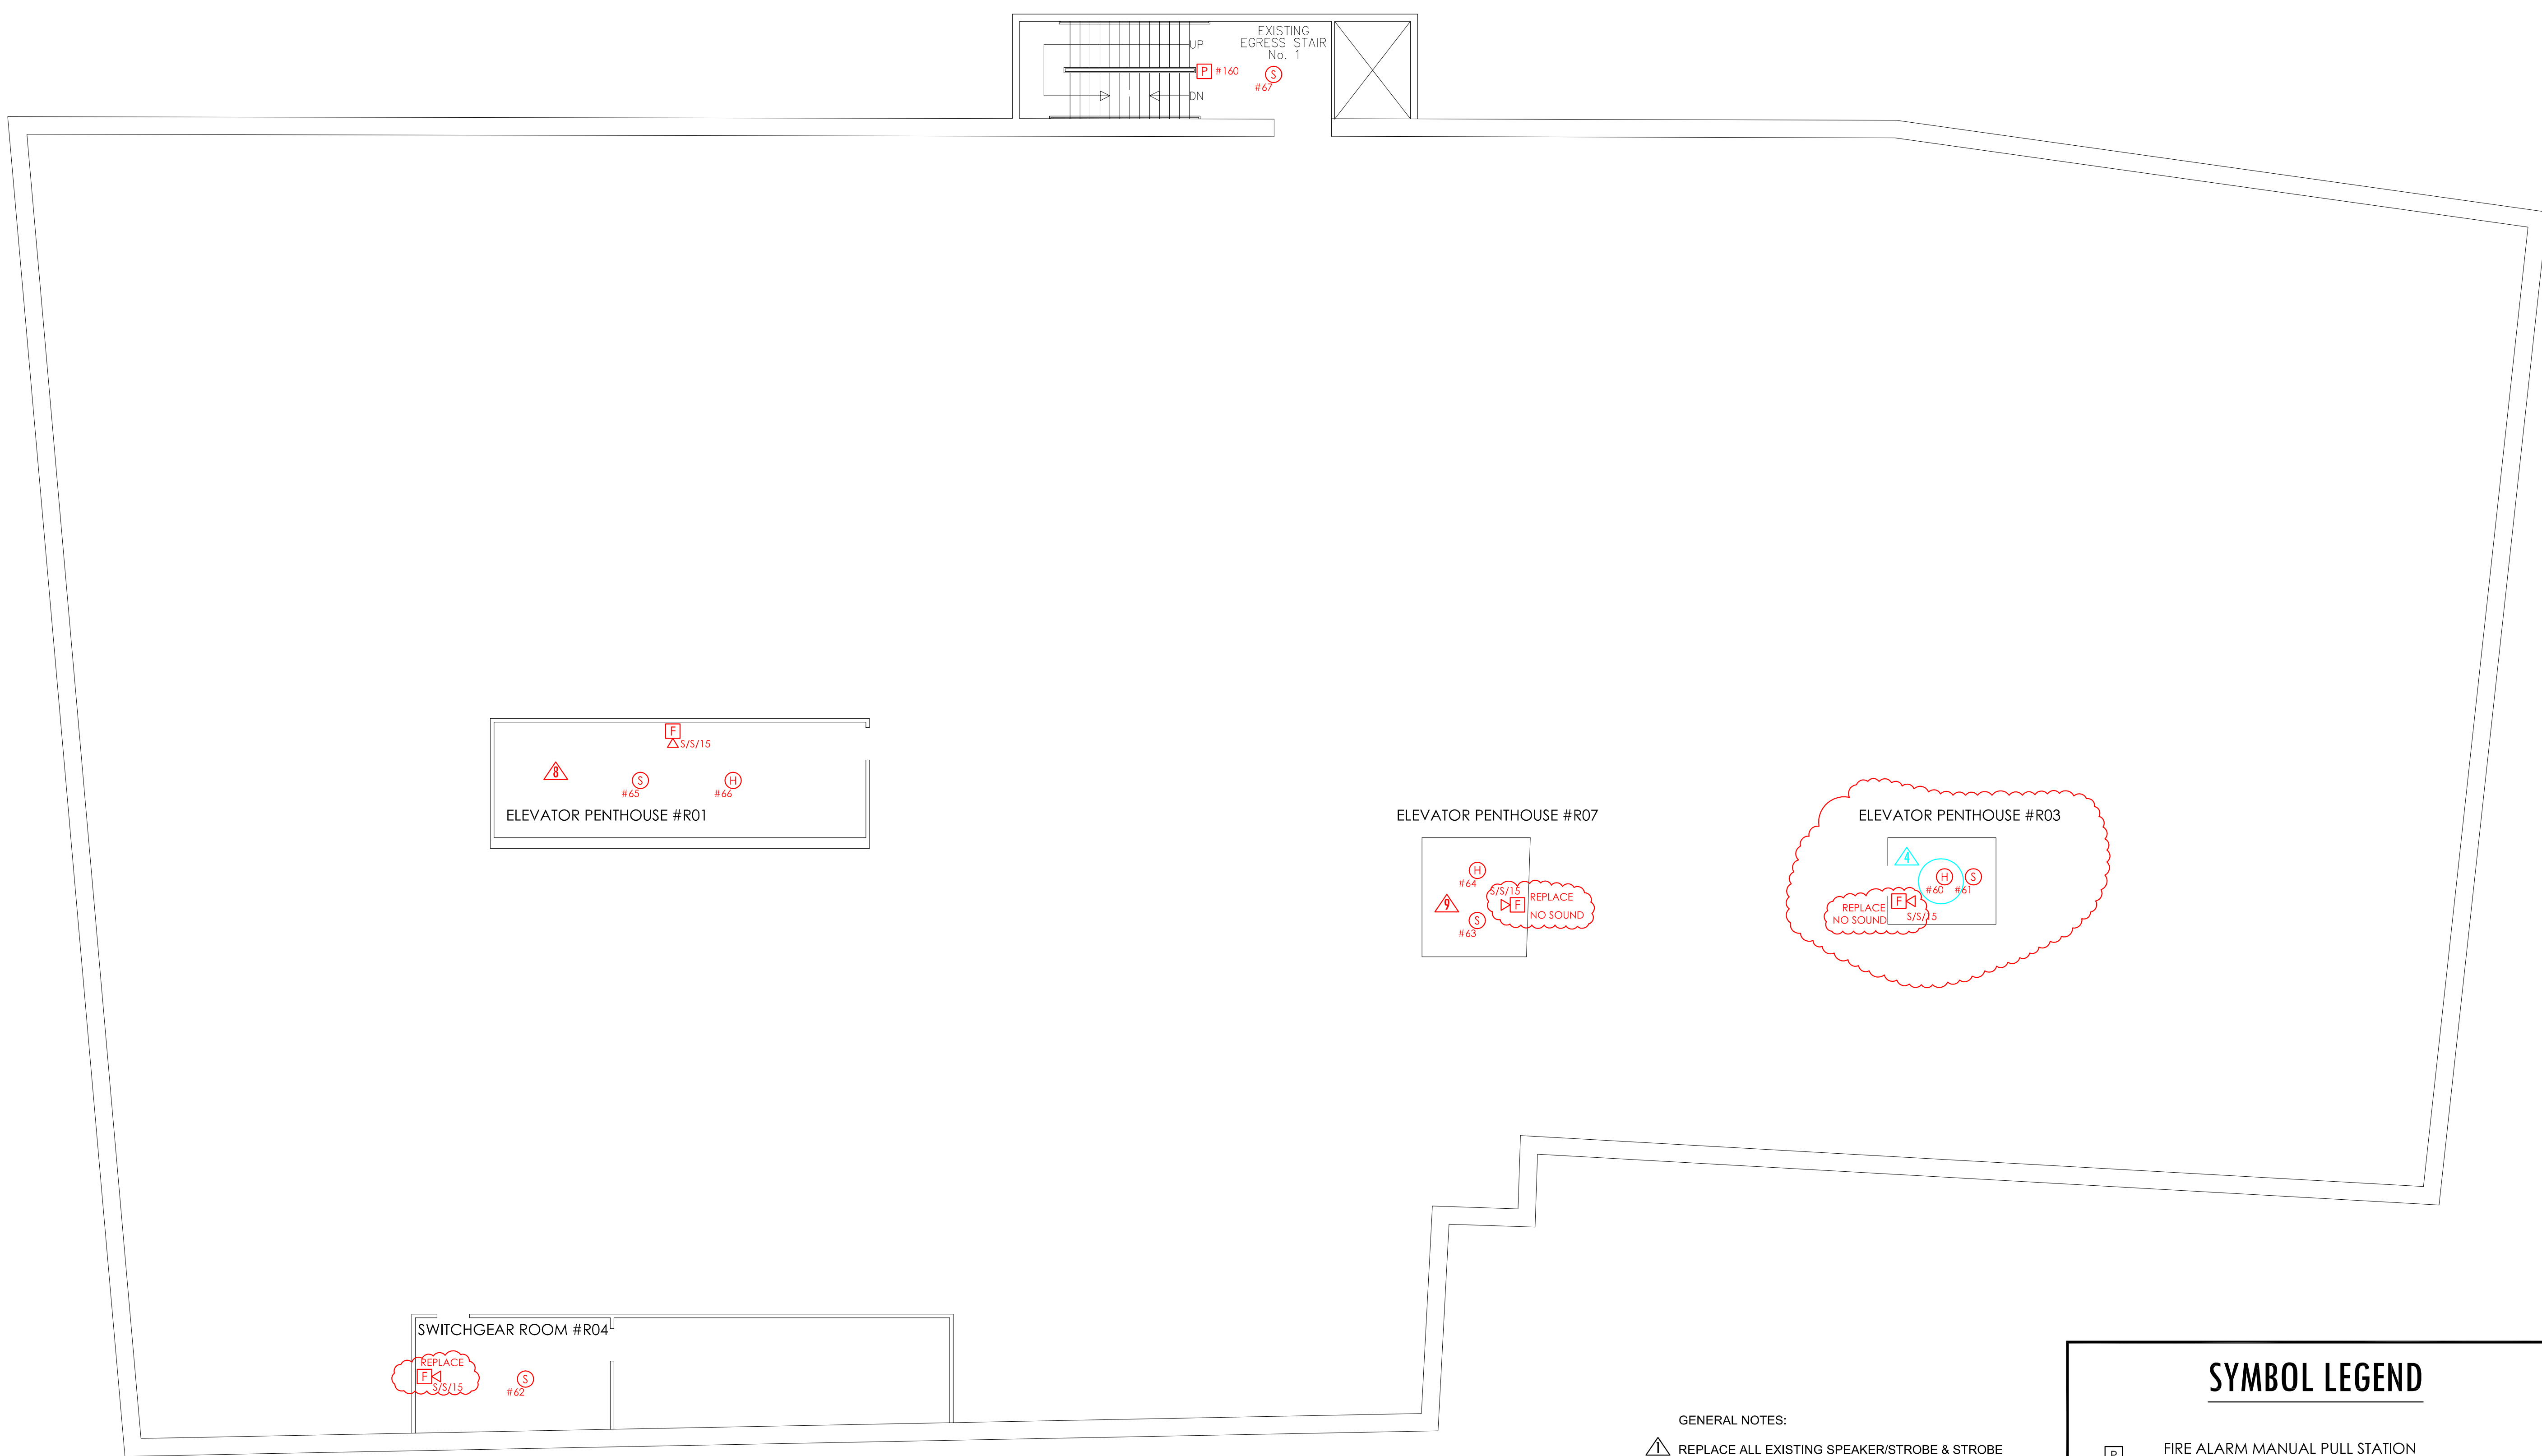

- GENERAL NOTES:**
- ▲ REPLACE ALL EXISTING SPEAKER/STROBE & STROBE DEVICES.
 - ▲ BLUE COLOR = INDICATES NEW DEVICE.
 - ▲ REPLACE EXISTING HORN/STROBE WITH SPEAKER/STROBE DEVICE.
 - ▲ REMOVE EXISTING DEVICE.
 - ▲ REPLACE EXISTING STROBE DEVICE WITH SPEAKER/STROBE DEVICE.
 - ▲ REPLACE EXISTING HEAT DETECTOR WITH SMOKE DETECTOR.
 - ▲ ADD SMOKE & HEAT DETECTORS IN ELEVATOR SHAFT.
 - ▲ ADD THREE (3) HEAT DETECTORS.
 - ▲ RE-LOCATE HEAT DETECTOR.

SYMBOL LEGEND	
	FIRE ALARM MANUAL PULL STATION
	FIRE ALARM HORN AND STROBE UNIT
	FIRE ALARM SPEAKER AND STROBE UNIT
	FIRE ALARM STROBE UNIT
	SMOKE DETECTOR - CEILING MOUNTED
	HEAT DETECTOR - CEILING MOUNTED
	DUCT SMOKE DETECTOR - HVAC DUCT MOUNTED

AS-BUILT FIRE ALARM

Anthony Mancini, Inc.
 179 SHERIDAN ST.
 PORTLAND, ME 04101
 P: (207)774-5829 F: (207)772-1686
 E: info@mancinielectric.com
 "We appreciate Your Business."



NO.	DATE	DESCRIPTION

PROJECT NAME & ADDRESS:
 Maine College of Art
 Congress Street
 Portland, Maine

SHEET NAME:
 Roof - Fire Alarm

Checked By: G. MANCINI
 Drawn By: A. AMES

Date: 06.12.2015
 Scale:

SHEET:
 E6