

© 2014 RYAN SENATORE ARCHITECTURE

MEPS  
510 CONGRESS STREET  
PORTLAND, MAINE



RYAN SENATORE  
ARCHITECTURE  
565 CONGRESS STREET  
SUITE 304  
PORTLAND, MAINE 04101  
207-650-6414  
senatorearchitecture.com

CONSULTANTS:

REVISIONS:

DATE: OCTOBER 30, 2014

PROJECT No.

DRAWN BY: RRT / RJS

CHECKED BY: RJS

SCALE: AS NOTED


SHEET TITLE:  
FINISH AND  
SIGNAGE  
SCHEDULE

A7-1

# FINISH SCHEDULE

## FLOORING NOTES

- AT LOCATIONS OF EXISTING VCT INDICATED TO BE REMOVED ON CONCRETE SUBSTRATE, MECHANICALLY REMOVE TILE AND ALL ADHESIVE MATERIALS DOWN TO CONCRETE BASE UTILIZE DUSTLESS MACHINE.
- GRIND CONCRETE HIGH POINTS AND RIDGES AS REQUIRED TO MINIMIZE FLOOR UNDULATIONS
- APPLY SELF LEVELING MATERIAL TO CLEAN CONCRETE SURFACE (MAPEI ULTRAPAN M20 PLUS) TO ENTIRE FLOOR SURFACE TO PROVIDE SMOOTH SURFACE. INSTALL PER MANUFACTURERS INSTRUCTIONS
- AT DOOR THRESHOLDS TO ROOMS WITH CARPET TILE ADJACENT TO NEW SELF LEVELED FLOORS, REMOVE FIRST COURSE OF CARPET TILE FEATHER (ARDEX FEATHERING MATERIAL) FROM SELF LEVELING INTO ROOM AND REINSTALL CARPET TILE. INSTALL NEW VINYL THRESHOLDS
- AL LOCATIONS OF EXISTING VCT INDICATED TO BE REMOVED ON WOOD SUBSTRATE, REMOVE TILE AND ADHESIVES, REPLACE AND REPAIR ANY DAMAGED SUBFLOOR, SKIM UNEVEN SURFACES WITH SELF LEVELING COMPOUND, INSTALL NEW 1/4" LAYER OF PLYWOOD, PREP FOR NEW VCT FLOOR TILE
- PROVIDE NEW TRANSITIONS AT ALL DOORWAY LOCATIONS OF NEW FLOORING AND EXISTING FLOORING.

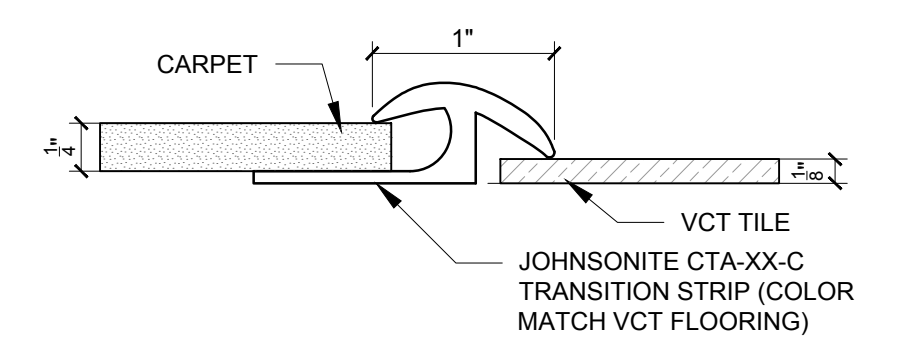

1 FLOORING TRANSITION BETWEEN CARPET AND VCT TILE  
10"x1'-0"

## ROOM FINISH SCHEDULE

ROOM #	ROOM NAME	WALLS					FLOOR	CEILING			REMARKS	PAINT COLOR
		NORTH	EAST	SOUTH	WEST	BASE		MAT.	HEIGHT	RATING		
400	MEDICAL WAITING AREA	1	1	1	1	10	20	31	-	-		
401	MEDICAL NCO	1	1	1	1	10	22	31	-	-		
402	CHIEF MEDICAL OFFICER	1	1	1	1	10	20	31	-	-		
403	FEE BASED DOCTOR	1	1	1	1	10	20	31	-	-		
404	MALE ORTHO	1	1	1	1	10	20	31	-	-		
405	UTILITY CLOSET	3	3	1	3	10	20	33	-	-		
406	MEDICAL NCOIC	1	1	1	1	10	20	31	-	-		
407	VISION TESTING 1	1	1	1	1	10	20	31	-	-		
408	AUDIO TESTING	1	1	1	1	10	20	31	-	-		
409	VISION TESTING 2	1	1	1	1	10	20	31	-	-		
410	MEDICAL STORAGE	3	3	3	3	10	20	31	-	-		
411	EKG ROOM	1	1	1	1	10	20	31	-	-		
412	MALE URINALYSIS	2	2	2	2	11	21	30	-	-		
413	LAB / SEROLOGY	1	1	1	1	10	20	31	-	-		
414	FEMALE ORTHO	1	1	1	1	10	20	31	-	-		
415	FEMALE URINALYSIS	2	2	2	2	11	21	30	-	-		
416	FEMALE EXAM ROOM 1	1	1	1	1	10	20	31	-	-		
417	FEMALE EXAM ROOM 2	1	1	1	1	10	20	31	-	-		
302	WOMENS LOCKER ROOM	3	3	3	3	11	21	34	-	-		
303	MENS LOCKER ROOM	3	3	3	3	11	21	34	-	-		
310	WOMENS LAV.	2	2	2	2	11	21	34	-	-		
312	MENS LAV.	2	2	2	2	11	21	34	-	-		
602	LAVATORY	2	2	2	2	11	21	31	-	-		

## FINISH SCHEDULE KEY

WALLS	
1	VINYL WALL COVERING - FLOOR TO CEILING
2	6"x6" CERAMIC TILE 6' UP WALL - PAINT GWB FROM TILE TO CEILING
3	PAINTED GWB
BASE	
10	4" VINYL COVE BASE
11	CERAMIC TILE BASE
FLOORS	
20	12"x12" VCT FLOOR TILE
21	12"x12" CERAMIC TILE
22	24"x24" CARPET TILE
CEILING	
30	GWB WITH PLASTER TOP COAT - PAINTED
31	24" X 48" LAY-IN ACOUSTICAL TILE WITH GRID SYSTEM
32	24"x24" LAY-IN ACOUSTICAL TILE WITH GRID SYSTEM - BEVELED REGULAR EDGE
33	NEW CEILING TILE IN EXISTING GRID
34	PATCH AND PAINT EXISTING CEILING

## ROOM FINISH GENERAL NOTES


- ALSO SEE INTERIOR ELEVATIONS FOR GRAPHIC DEPICTIONS OF EXTENT OF FINISHES
- INSTALL MOISTURE RESISTANT (MOLD AND MILDEW RESISTANT) GWB IN ALL AREAS WHERE PLUMBING FIXTURES EXIST (CEILING AND WALLS IN BATHROOMS)
- CLOSETS SHALL BE FINISHED AS THE ROOMS THEY SERVICE
- ALL SPACES DESIGNATED AS CLOSET OR CL. ARE TO RECEIVE ONE CLOTHING ROD 5/2" AFF AND ONE 12" WIRE SHELF ABOVE THE ROD ALONG THE WALL OPPOSITE THE DOOR UNLESS NOTED OTHERWISE.
- ALL SPACES DESIGNATED AS LINEN CLOSETS (LIN) OR PANTRY (PAN) ARE TO RECEIVE FOUR 12" WIRE SHELVES SPACED AT 1'-0" OC STARTING AT FINISH FLOOR, UNLESS NOTED OTHERWISE.
- ALL LAUNDRY CLOSETS ARE TO RECEIVE ONE 12" SHELF AT 4'-6" A.F.F. UNLESS NOTED OTHERWISE.
- PROVIDE APPROPRIATE BLOCKING IN WALLS OF ALL BATHROOMS BEHIND FIXTURES, PARTITIONS AND ACCESSORIES. PROVIDE BLOCKING FOR GRAB BARS IN WALLS OF BATHROOMS
- PROVIDE APPROPRIATE BLOCKING IN WALLS FOR DOOR STOPS
- BOTTOM EDGE OF GWB ON WALL SURFACES TO BE HELD UP 1/2" FROM CONCRETE FLOOR SURFACES
- PROVIDE VINYL TRANSITIONS STRIPS AT ALL FLOOR TRANSITIONS UNLESS OTHERWISE NOTED
- UNLESS OTHERWISE NOTED IN DRAWINGS THE TYPICAL WALL TYPE IS 'W'. ALL OTHER PARTITION TYPES WILL BE INDICATED.
- VERIFY UNDERLAYMENT MEETS MANUFACTURERS SPECIFICATION AT RESILIENT FLOORING

# SIGNAGE SCHEDULE

## ROOM NAMES AND NUMBERS

100	HEADQUARTERS ADMINISTRATION	410	MEDICAL STORAGE
101	COMMANDER	411	MEDICAL BREAK AREA
102	EXECUTIVE OFFICER	412	MALE URINALYSIS
103	SENIOR ENLISTED ADVISOR	413	LAB / SEROLOGY
104	HQ CONFERENCE ROOM	414	FEMALE ORTHO
105	STAFF LOUNGE	415	FEMALE URINALYSIS
106	MEN'S LAVATORY	416	FEMALE EXAMINATION
107	WOMEN'S LAVATORY	417	EKG / COT ROOM
200	TESTING SECTION	500	PROCESSING SECTION
201	TEST ROOM 2	501	FILE ROOM
202	TEST ROOM 1	502	HUMAN RESOURCES SUPERVISOR
203	SCORING ROOM	503	OPERATIONS BREAK AREA
204	EDUCATION SERVICES SPECIALIST	504	OPERATIONS OFFICER
205	TEST COORDINATOR	505	LEAD HUMAN RESOURCES ASSISTANT
206	TEST CONTROL OFFICER	506	TRAVEL OFFICE
207	SECURE STORAGE	507	PRE ENLISTMENT INVESTIGATION 1
		508	PRE ENLISTMENT INVESTIGATION 2
		509	ASVAB TESTING
300	COMMUNICATIONS / MIRS / SERVER		
301	SYSTEM ADMINISTRATOR	601	MAIN ENTRANCE SECURITY ROOM
302	WOMEN'S LOCKER ROOM	602	BAGGAGE ROOM
303	MEN'S LOCKER ROOM	603	VISITOR LOUNGE
304	EXERCISE ROOM	604	APPLICANT LOUNGE
305	UTILITY CLOSET	605	STORAGE CLOSET
306	BRIEFING ROOM	606	GAME ROOM
307	CEREMONY ROOM		
308	CONFERENCE ROOM	700	LIAISON WAITING AREA
309	STUDENT TESTING STORAGE	701	MARINE CORPS LIAISON
310	WOMEN'S LAVATORY	702	COAST GUARD LIAISON
311	VIP ROOM	703	NATIONAL GUARD LIAISON
312	MEN'S LAVATORY	704	NAVY LIAISON
313	CONFERENCE ROOM	705	NAVY CLASSIFIER
314	HOUSE KEEPING SUPPLIES	706	EPDS
		707	ARMY LIAISON
		708	ARMY SENIOR LIAISON
		709	AIR FORCE LIAISON
		710	ELECTRICAL CLOSET
400	MEDICAL SECTION	800	LOGISTICS / SUPPLY
401	MEDICAL NCOIC	801	RECYCLING / STORAGE
402	CHIEF MEDICAL OFFICER	802	LAVATORY
403	ASSISTANT MEDICAL OFFICER		
404	MALE ORTHO		
405	UTILITY CLOSET		
406	MEDICAL NCOIC		
407	VISION TESTING 1		
408	AUDIO TESTING		
409	VISION TESTING 2		

- NOTES
- PROVIDE 6 FIRE EXIT PLAN SIGNS TO BE FIELD LOCATED WITH OWNER (BASED ON FULL MEPS FLOOR PLAN)

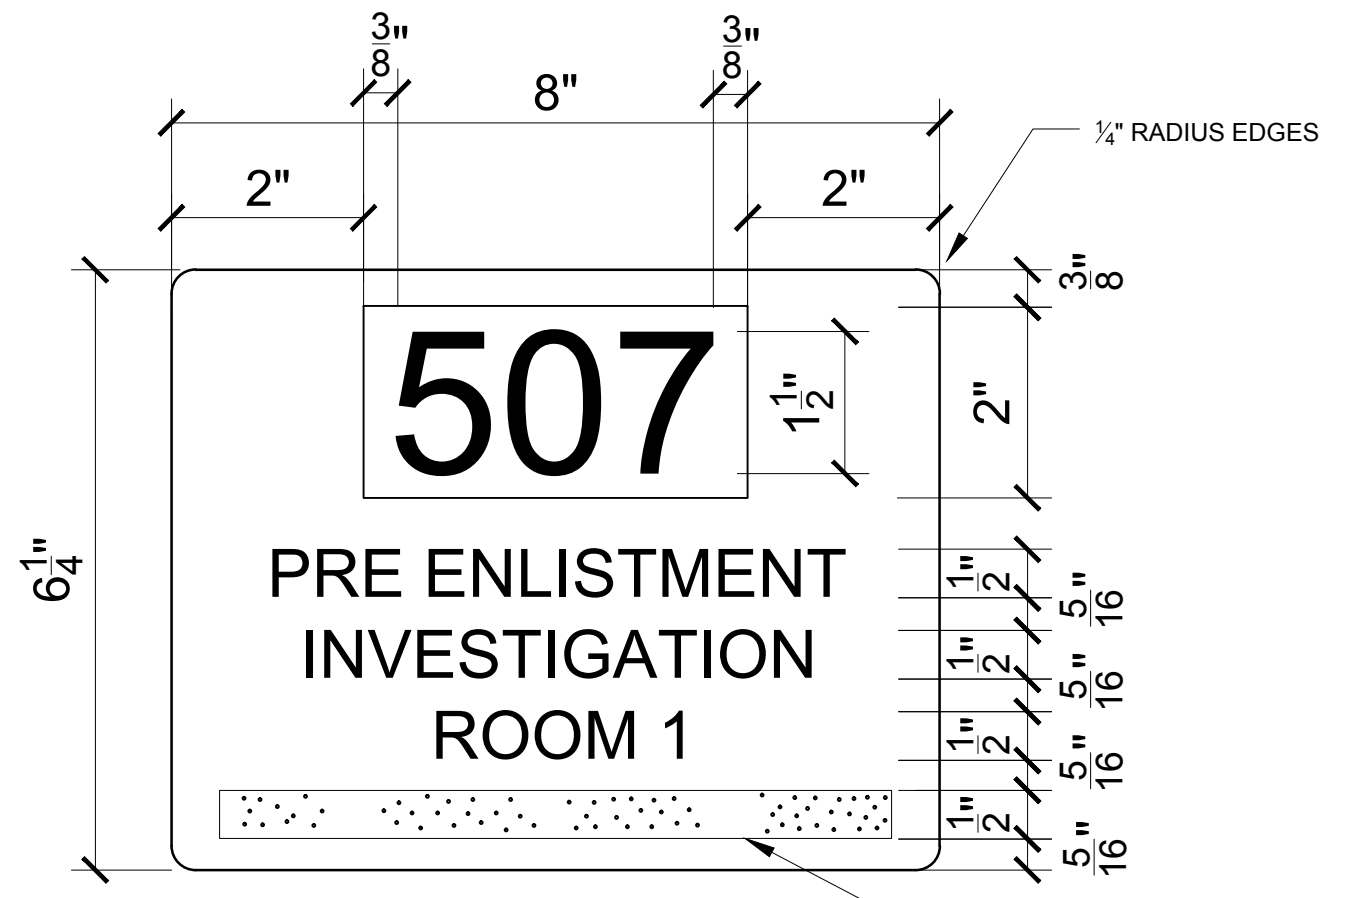

2 TYPICAL SIGNAGE PLATE  
6'1"x1'-0"

## DIVISION 9 - SIGNAGE

- 0.1 Interior Signage - All rooms throughout the facility shall be provided with a sign. Use the building standards for guidance if appropriate. Coordinate the signage color with the interior color scheme. Specify a sign that allows for room name change. Signage must be on GSA schedule.
- A. Individual signs should be no larger than 8" x 8" and attached to the adjacent wall, not on the door, unless noted otherwise on the Design Intent Drawings.
- A. Signage must be firmly anchored to the walls or on sidelights with blank back panels. Include fire exit plans in the facility signage package. Placement of the signs must be consistent throughout the facility.
- A. Systems Furniture workstations do not require a sign. Each MEPS Section also requires signage at entry and exit doors.
- A. Provide and install the following sign in a conspicuous location near the primary entrance:
- ATTENTION ALL PERSONNEL AND VISITORS**  
IT IS A FEDERAL CRIME TO KNOWINGLY POSSESS OR CAUSE TO BE PRESENT, A FIREARM OR OTHER DANGEROUS WEAPON IN THIS FACILITY. THE LAWFUL PERFORMANCE OF OFFICIAL DUTIES AUTHORIZED BY LAW IS EXEMPT. VIOLATORS WILL BE PROSECUTED TO THE FULLEST EXTENT OF THE LAW.
- 0.1 Exterior Signage - Locate one exterior sign on the address side of the building. The sign shall be on a monument, lit to 15 foot-candles with photocell control. If the building has more than one tenant and an exterior sign is not allowed, provide a sign at the main entrance door of the MEPS space. The exterior sign is to read "MILITARY ENTRANCE PROCESSING STATION" with the USMEPCOM Logo.