


REVISIONS




Binga's Wingas at the Stadium
Free and Brown Street
Portland, Maine

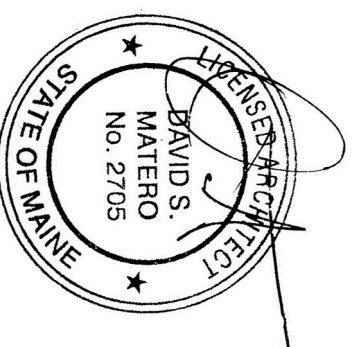


Job Number: 09.0111
Date: 11 Jun.09
Scale: 1/8" = 1'-0"
Drawing Title:
Lighting and Reflected CIG Plan

A7.1
Issue for Permit

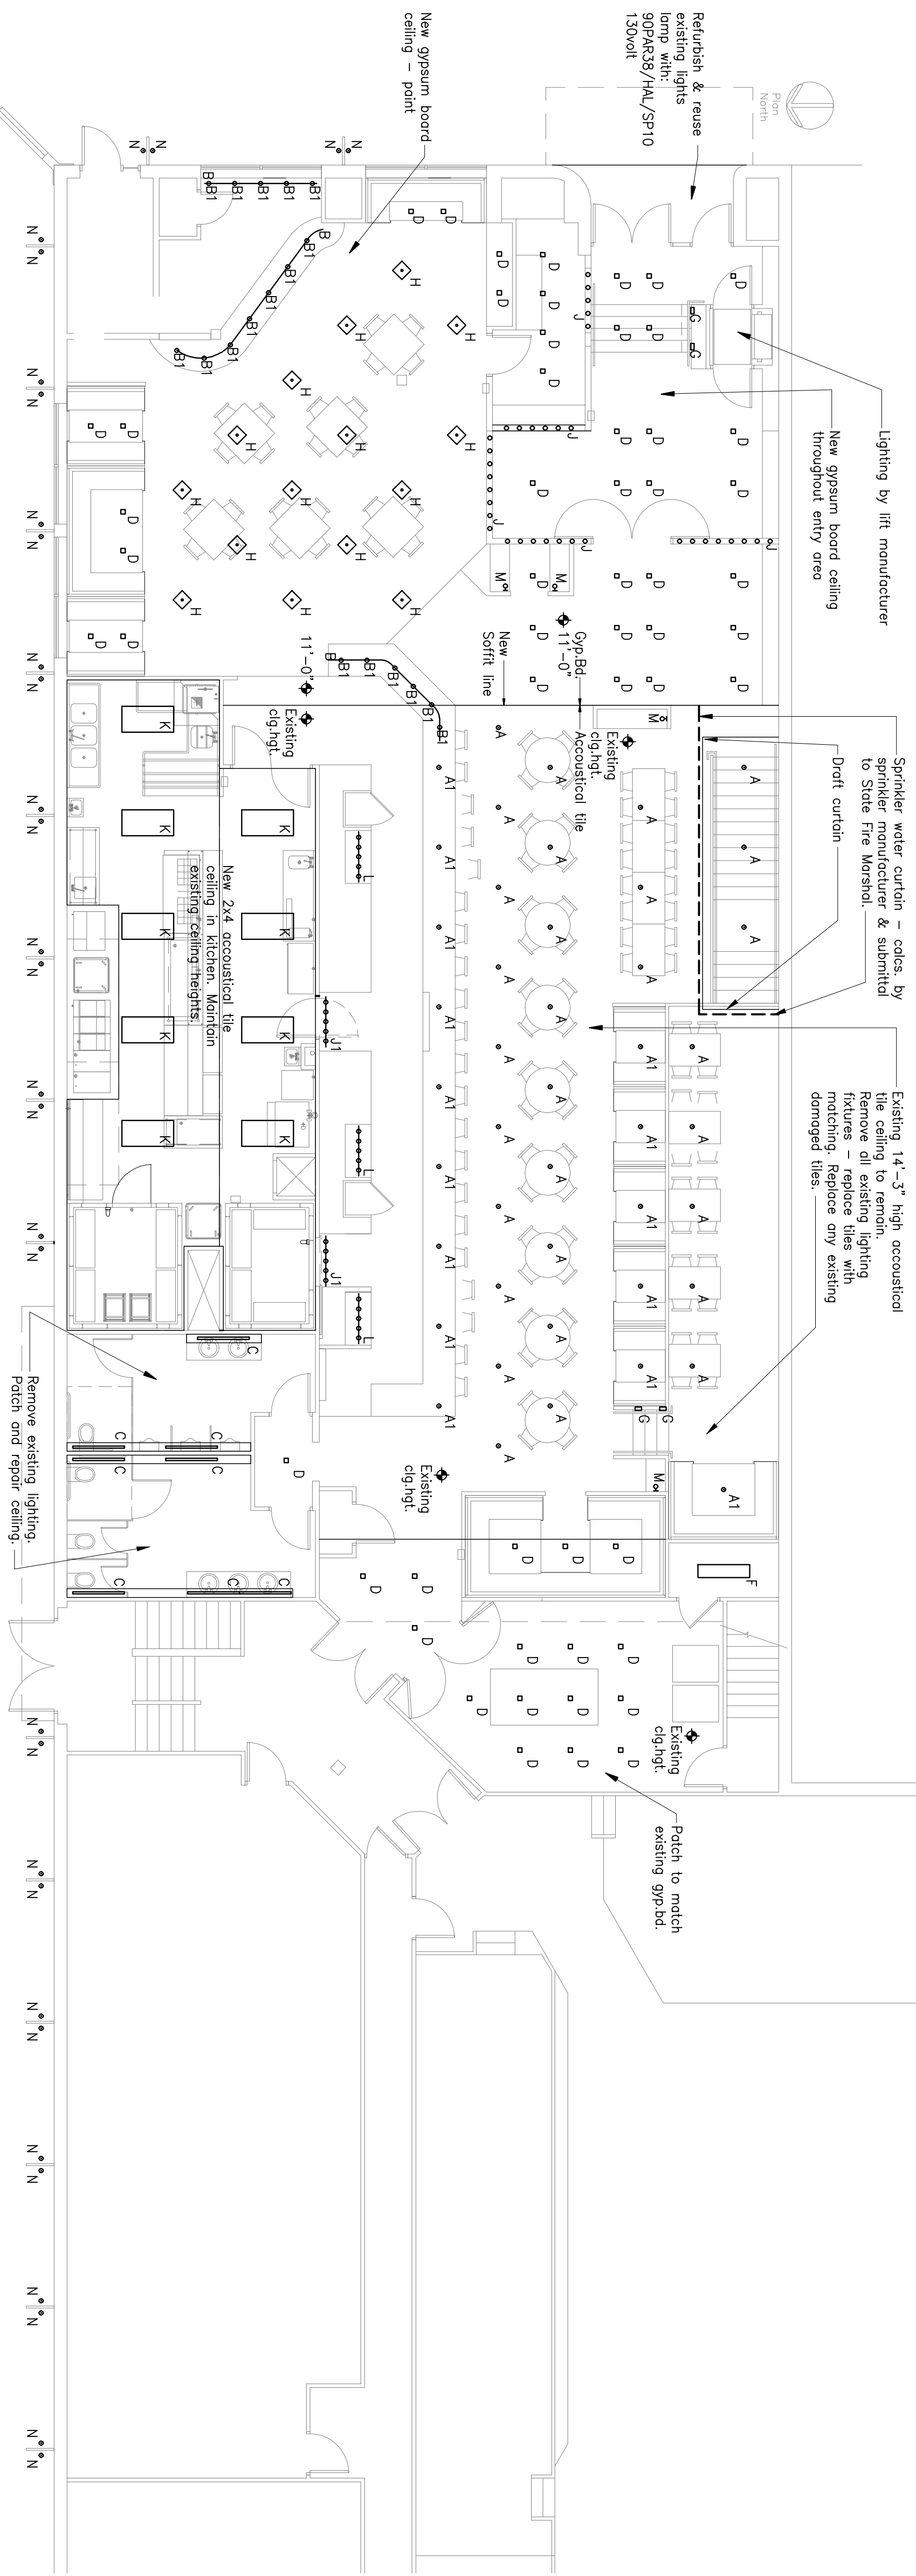

1 First Floor Lighting & Reflected Ceiling Plan
Scale: 1/8" = 1'-0"

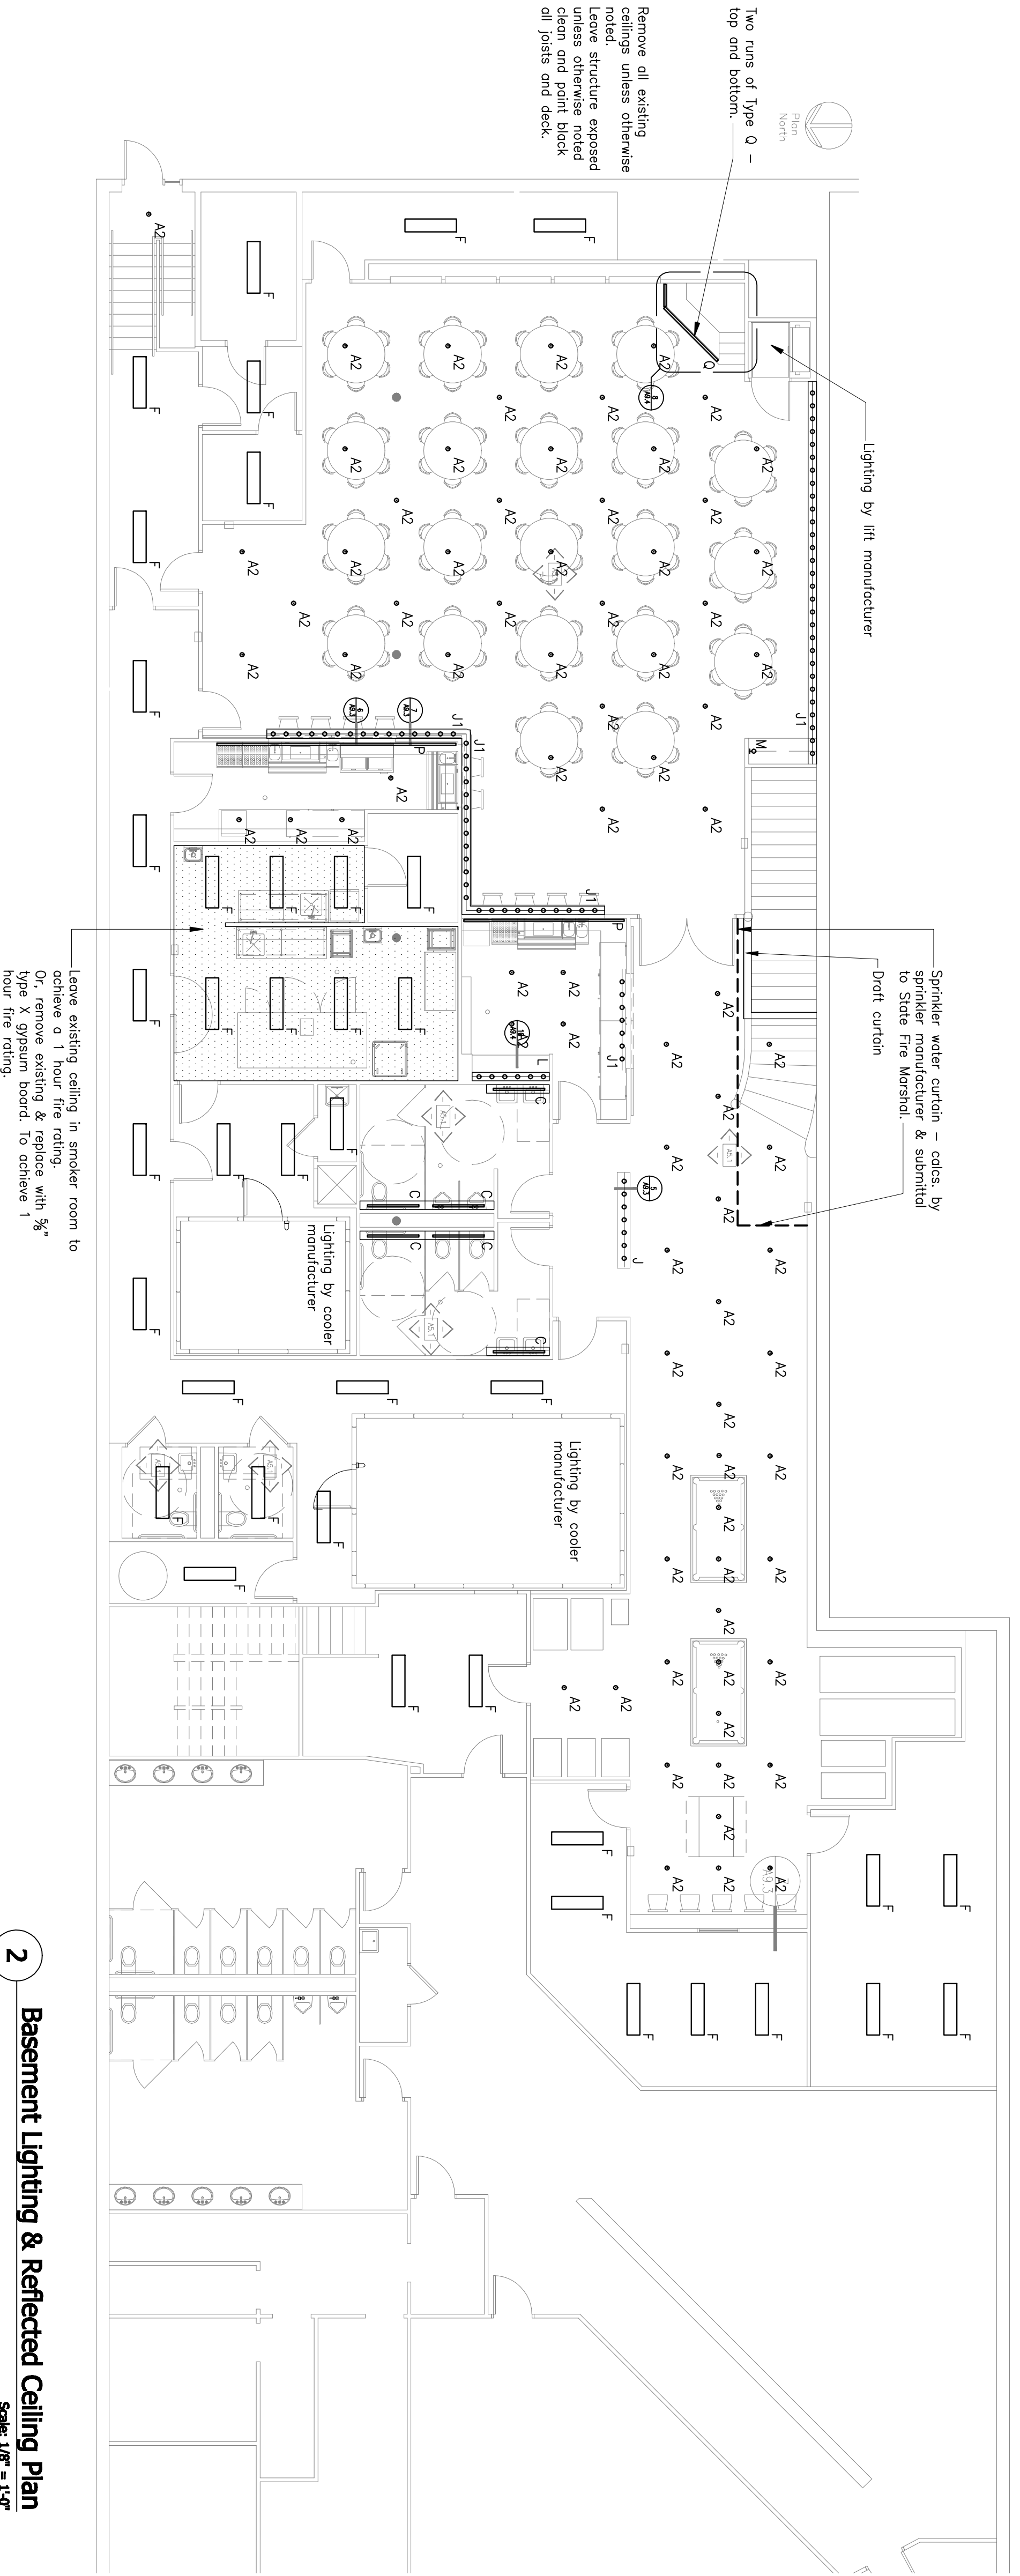

2 Basement Lighting & Reflected Ceiling Plan
Scale: 1/8" = 1'-0"