


congress street

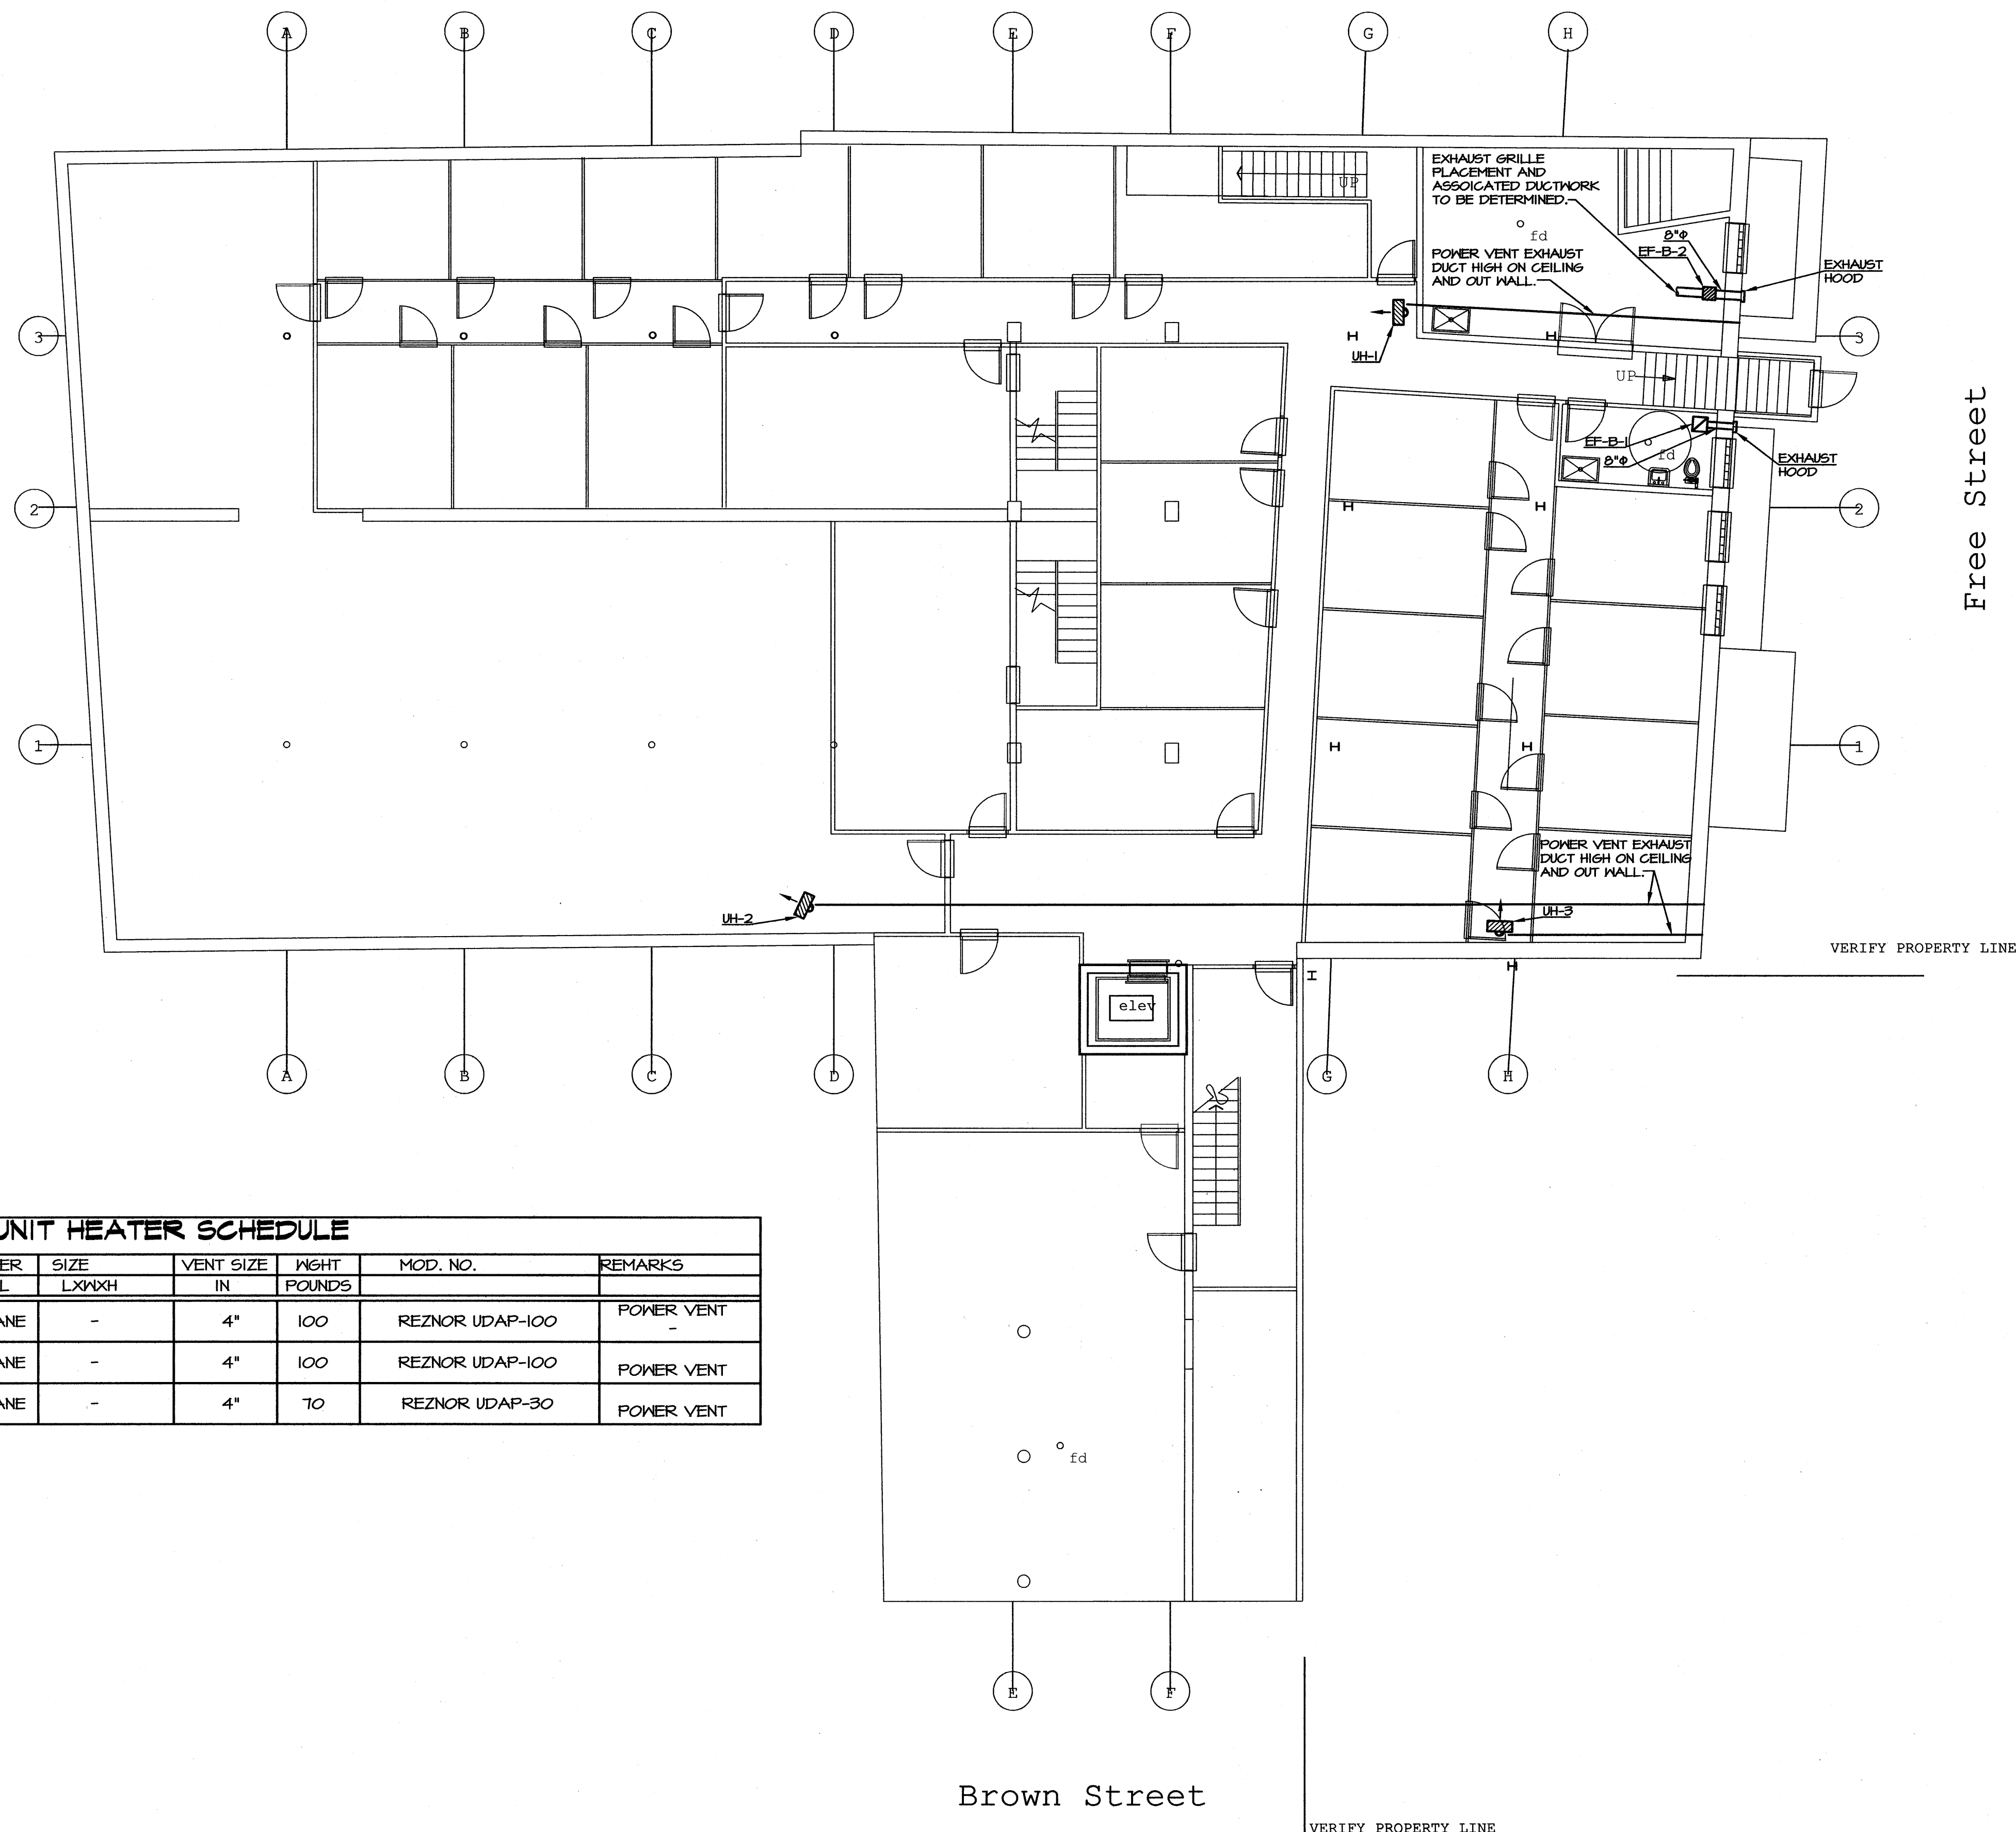

Free Street

Brown Street

VERIFY PROPERTY LINE


GAS UNIT HEATER SCHEDULE

TAG	SERVES	INPUT MBH	OUTPUT MBH	EFF. %	BURNER FUEL	SIZE LxWxH	VENT SIZE IN	WGT POUNDS	MOD. NO.	REMARKS
UH-1	BSMNT OPEN SPACE	100	80	80%	PROPANE	-	4"	100	REZNOR UDAP-100	POWER VENT
UH-2	BSMNT HALL	100	80	80%	PROPANE	-	4"	100	REZNOR UDAP-100	POWER VENT
UH-3	BSMNT FREE ST HALL	60	48	80%	PROPANE	-	4"	70	REZNOR UDAP-30	POWER VENT

This document is owned by, and the information contained herein is proprietary to Titan Mechanical Inc. By receipt hereof the holder agrees not to use the information, disclose it to any third party, nor reproduce this document without the prior written consent of Titan Mechanical Inc. and agrees to return the document for their request.

DATE	REVISIONS

Titan Mechanical, Inc.
 Design Build Engineering - Mechanical Contracting
 P.O. Box 3927 / 41 Evergreen Drive
 Portland, Maine 04104
 Ph. (207) 878-5223 Fax. (207) 878-5235

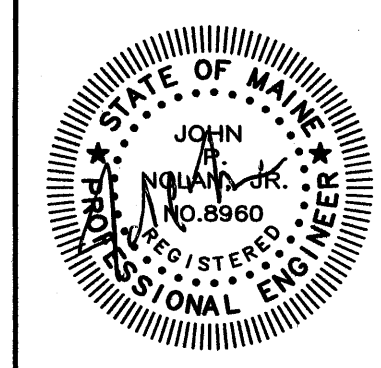

KIMBALL BLOCK LLC
 CLIENT
490 CONGRESS ST. MECH. SYSTEMS
 PROJECT
BASEMENT HVAC LAYOUT PLAN
 DRAWING TITLE

DATE: 05/17/05
 SCALE: 1/8" = 1'-0"
 DRAWN BY: RNC
 CHECKED BY: JPN
 JOB NUMBER: XXXX
 CAD FILE: 490 CONGRESS.MXD
 SHEET NUMBER

M1.1
 SHEET 1 OF 21