


Congress Street

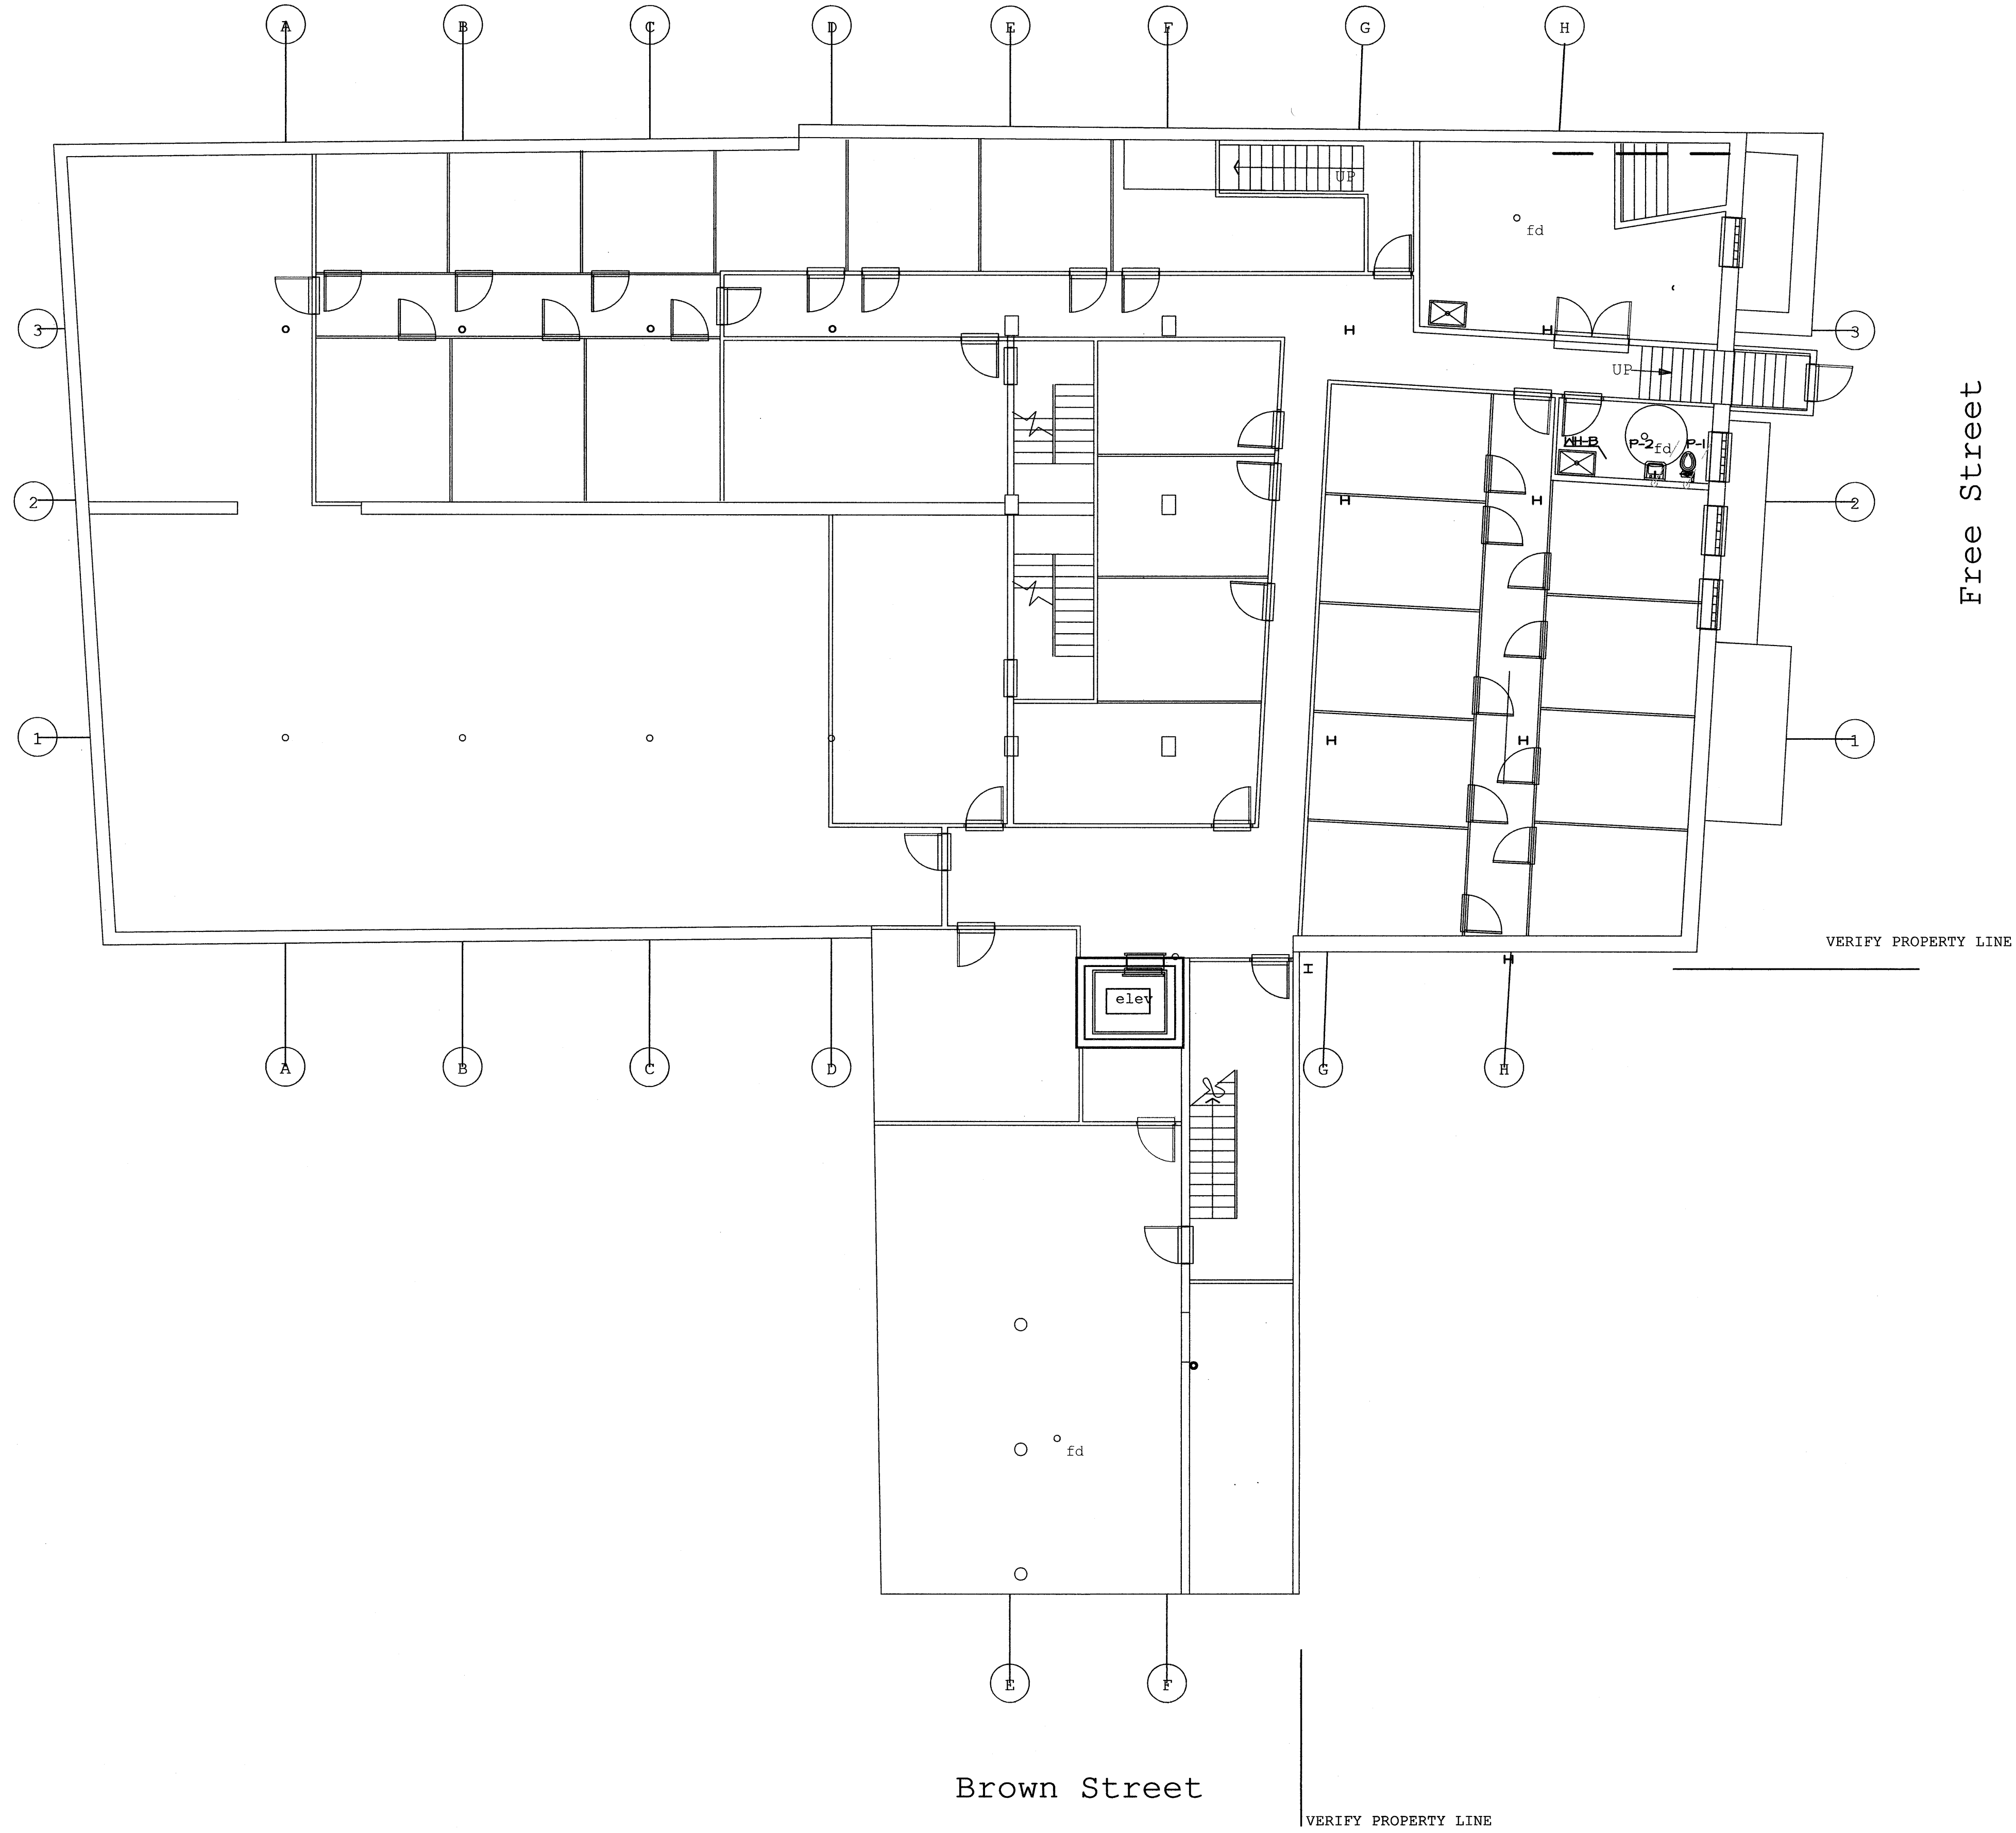

Brown Street

Free Street

KIMBALL BLOCK LLC
CLIENT

490 CONGRESS ST. MECH. SYSTEMS
PROJECT

BASEMENT SANITARY PLUMBING PLAN
DRAWING TITLE

DATE: 05/17/05

SCALE: 1/8" = 1'-0"

DRAWN BY: RNC

CHECKED BY: JPN

JOB NUMBER: XXXX

CAD FILE: 490 CONGRESS.MXD

SHEET NUMBER

P1.1

SHEET 8 OF 21

REVISIONS	DATE

Titan Mechanical, Inc.
 Design Build Engineering - Mechanical Contracting
 P.O. Box 3927 / 41 Evergreen Drive
 Portland, Maine 04104
 Ph. (207) 878-5223 Fax. (207) 878-5235

The document is owned by and the information contained in it is proprietary to Titan Mechanical Inc. By receipt hereof the recipient agrees not to use, copy, reproduce, or disseminate the information contained herein without the prior written consent of Titan Mechanical Inc. and agrees to return the document forthwith upon request.