


congress street

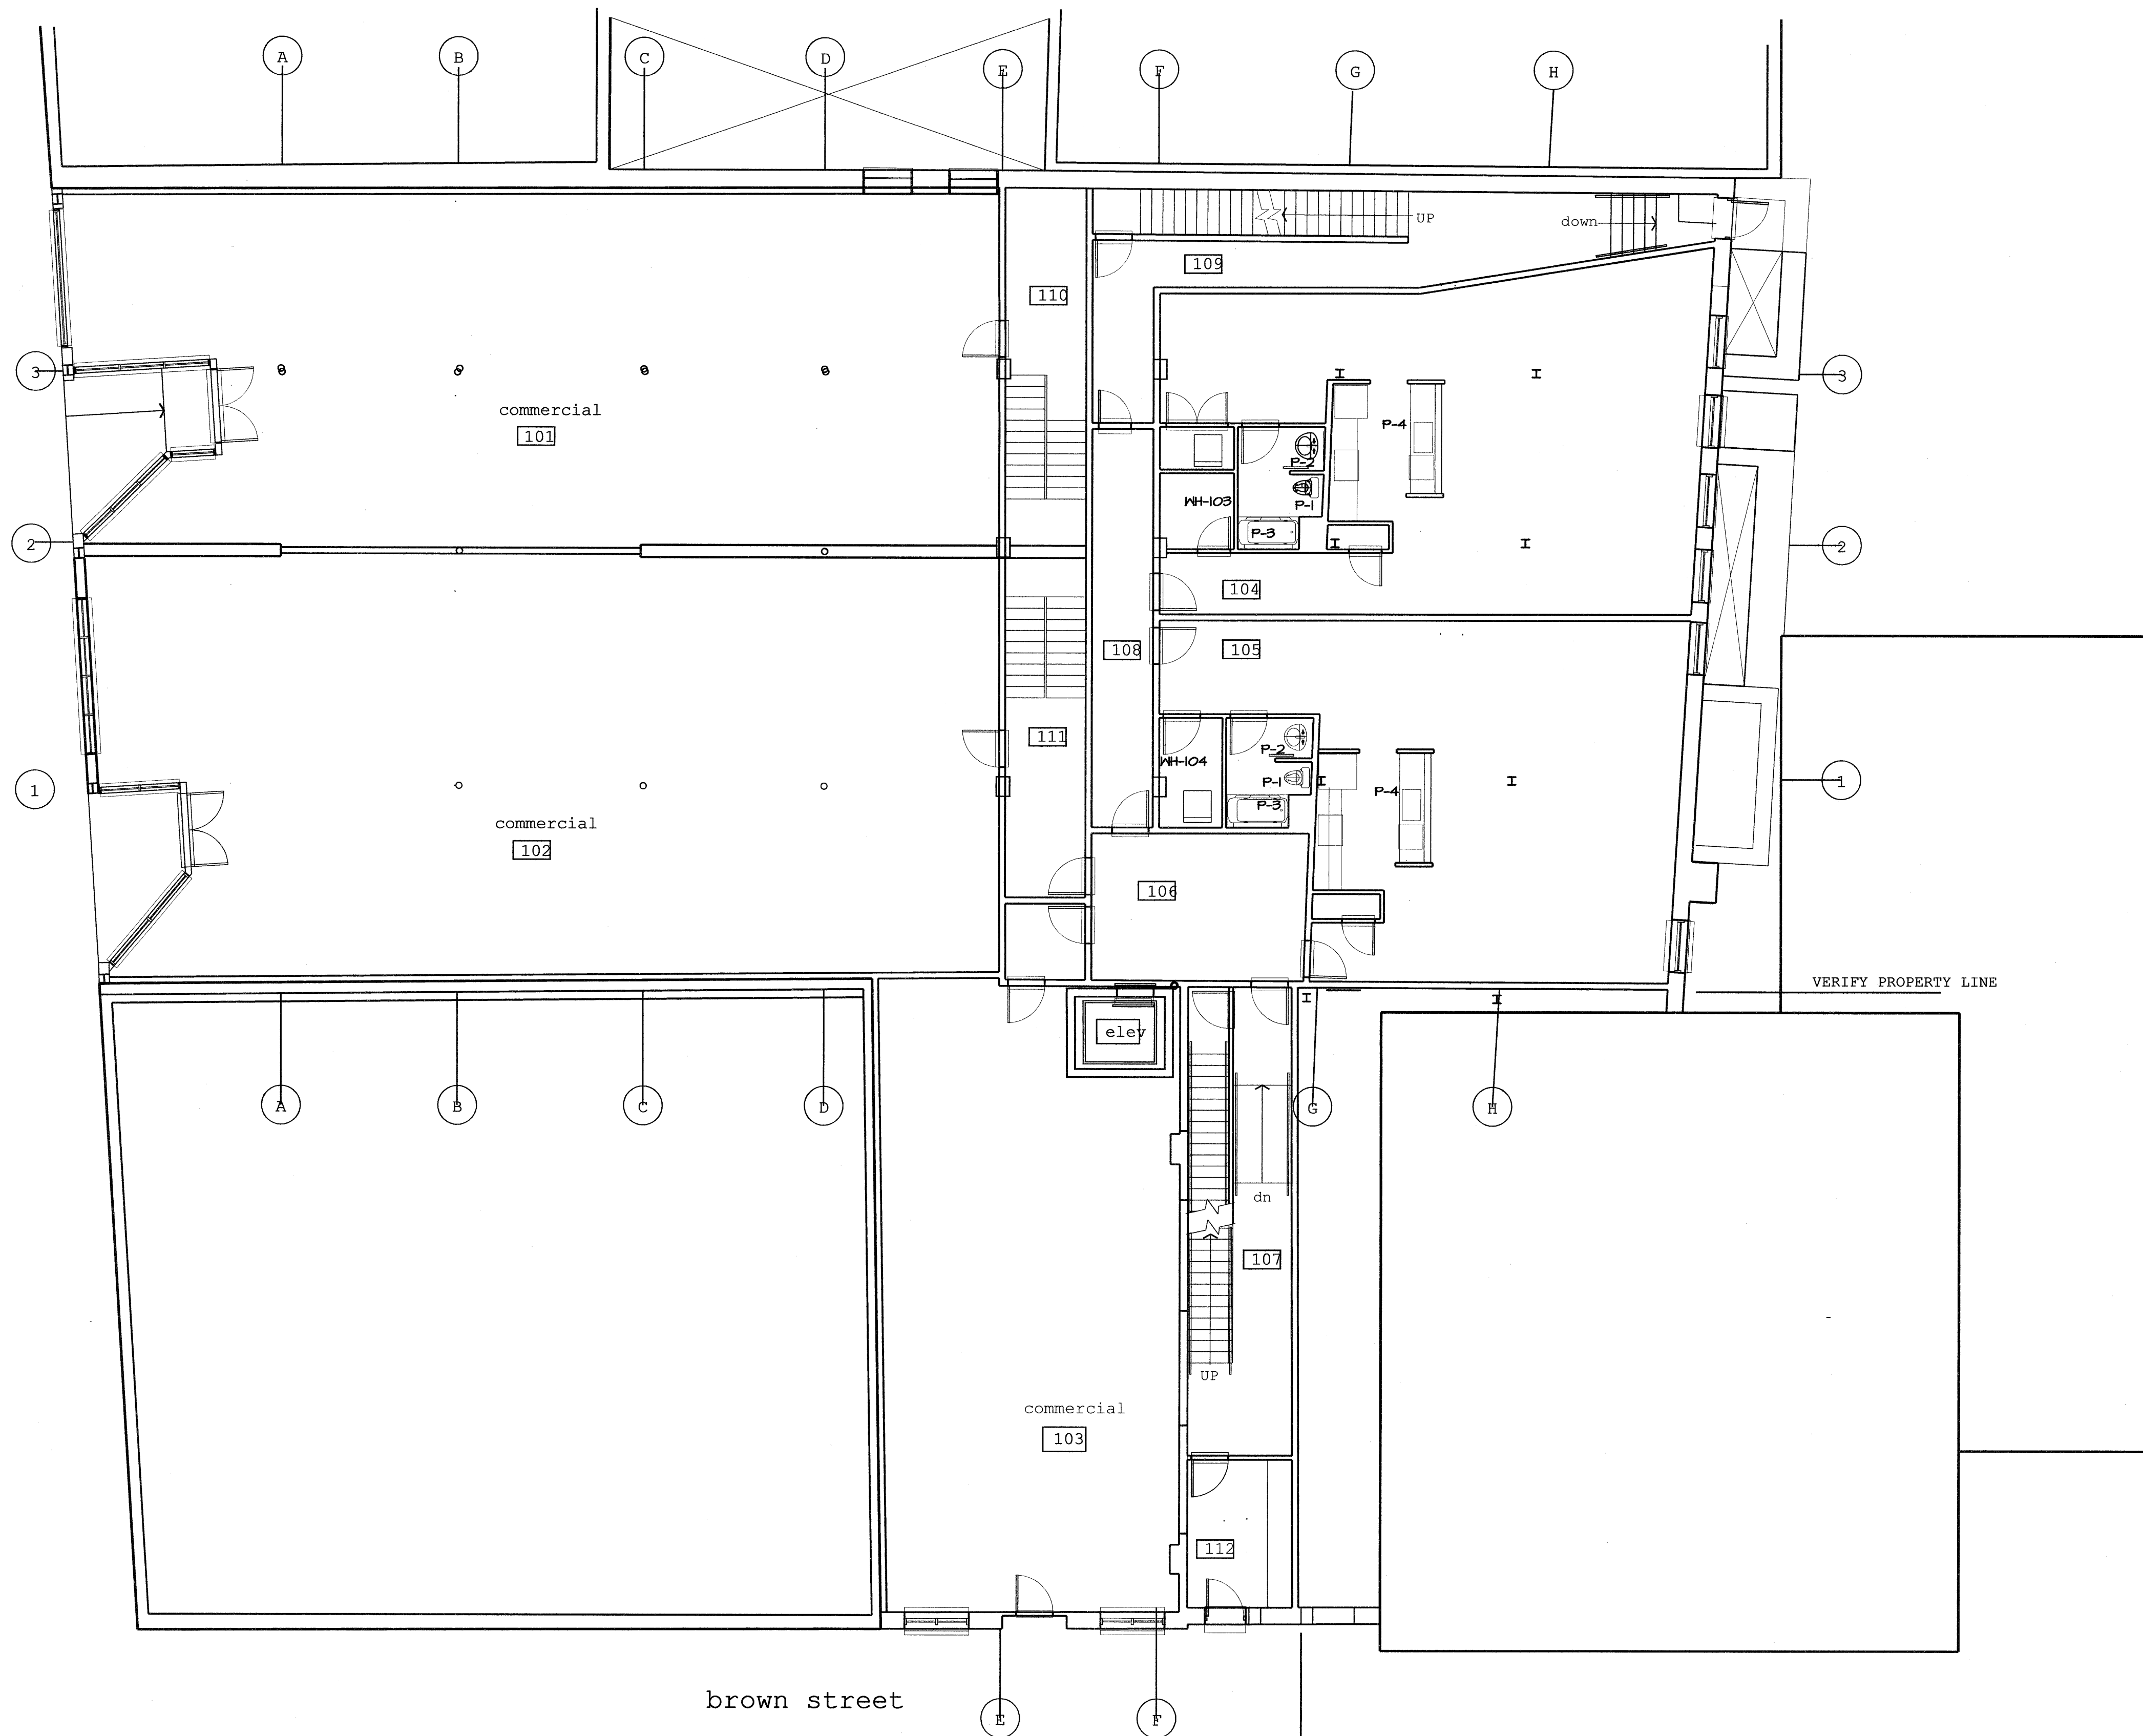

free street

brown street

- general notes:
- 7'-6" ce
 - 9'-0" ce

The document is owned by, and the information contained in it is proprietary to Titan Mechanical, Inc. By receipt hereof the holder agrees not to use the information disclosed in it for any third party, nor reproduce the document without the prior written consent of Titan Mechanical, Inc. and agrees to return the document forthwith upon request.

REVISIONS	DATE

Titan Mechanical, Inc.
 Design Build Engineering - Mechanical Contracting
 P.O. Box 3927 / 41 Evergreen Drive
 Portland, Maine 04104
 Ph. (207) 878-5223 Fax. (207) 878-5235

KIMBALL BLOCK LLC
 CLIENT

490 CONGRESS ST. MECH. SYSTEMS
 PROJECT

1ST FLOOR SANITARY PLUMBING PLAN
 DRAWING TITLE

DATE: 05/17/05
 SCALE: 1/8" = 1'-0"
 DRAWN BY: RNC
 CHECKED BY: JFN
 JOB NUMBER: XXXX
 CAD FILE: 490 CONGRESS.MP2

SHEET NUMBER

P1.2

SHEET 4 OF 21