


congress street

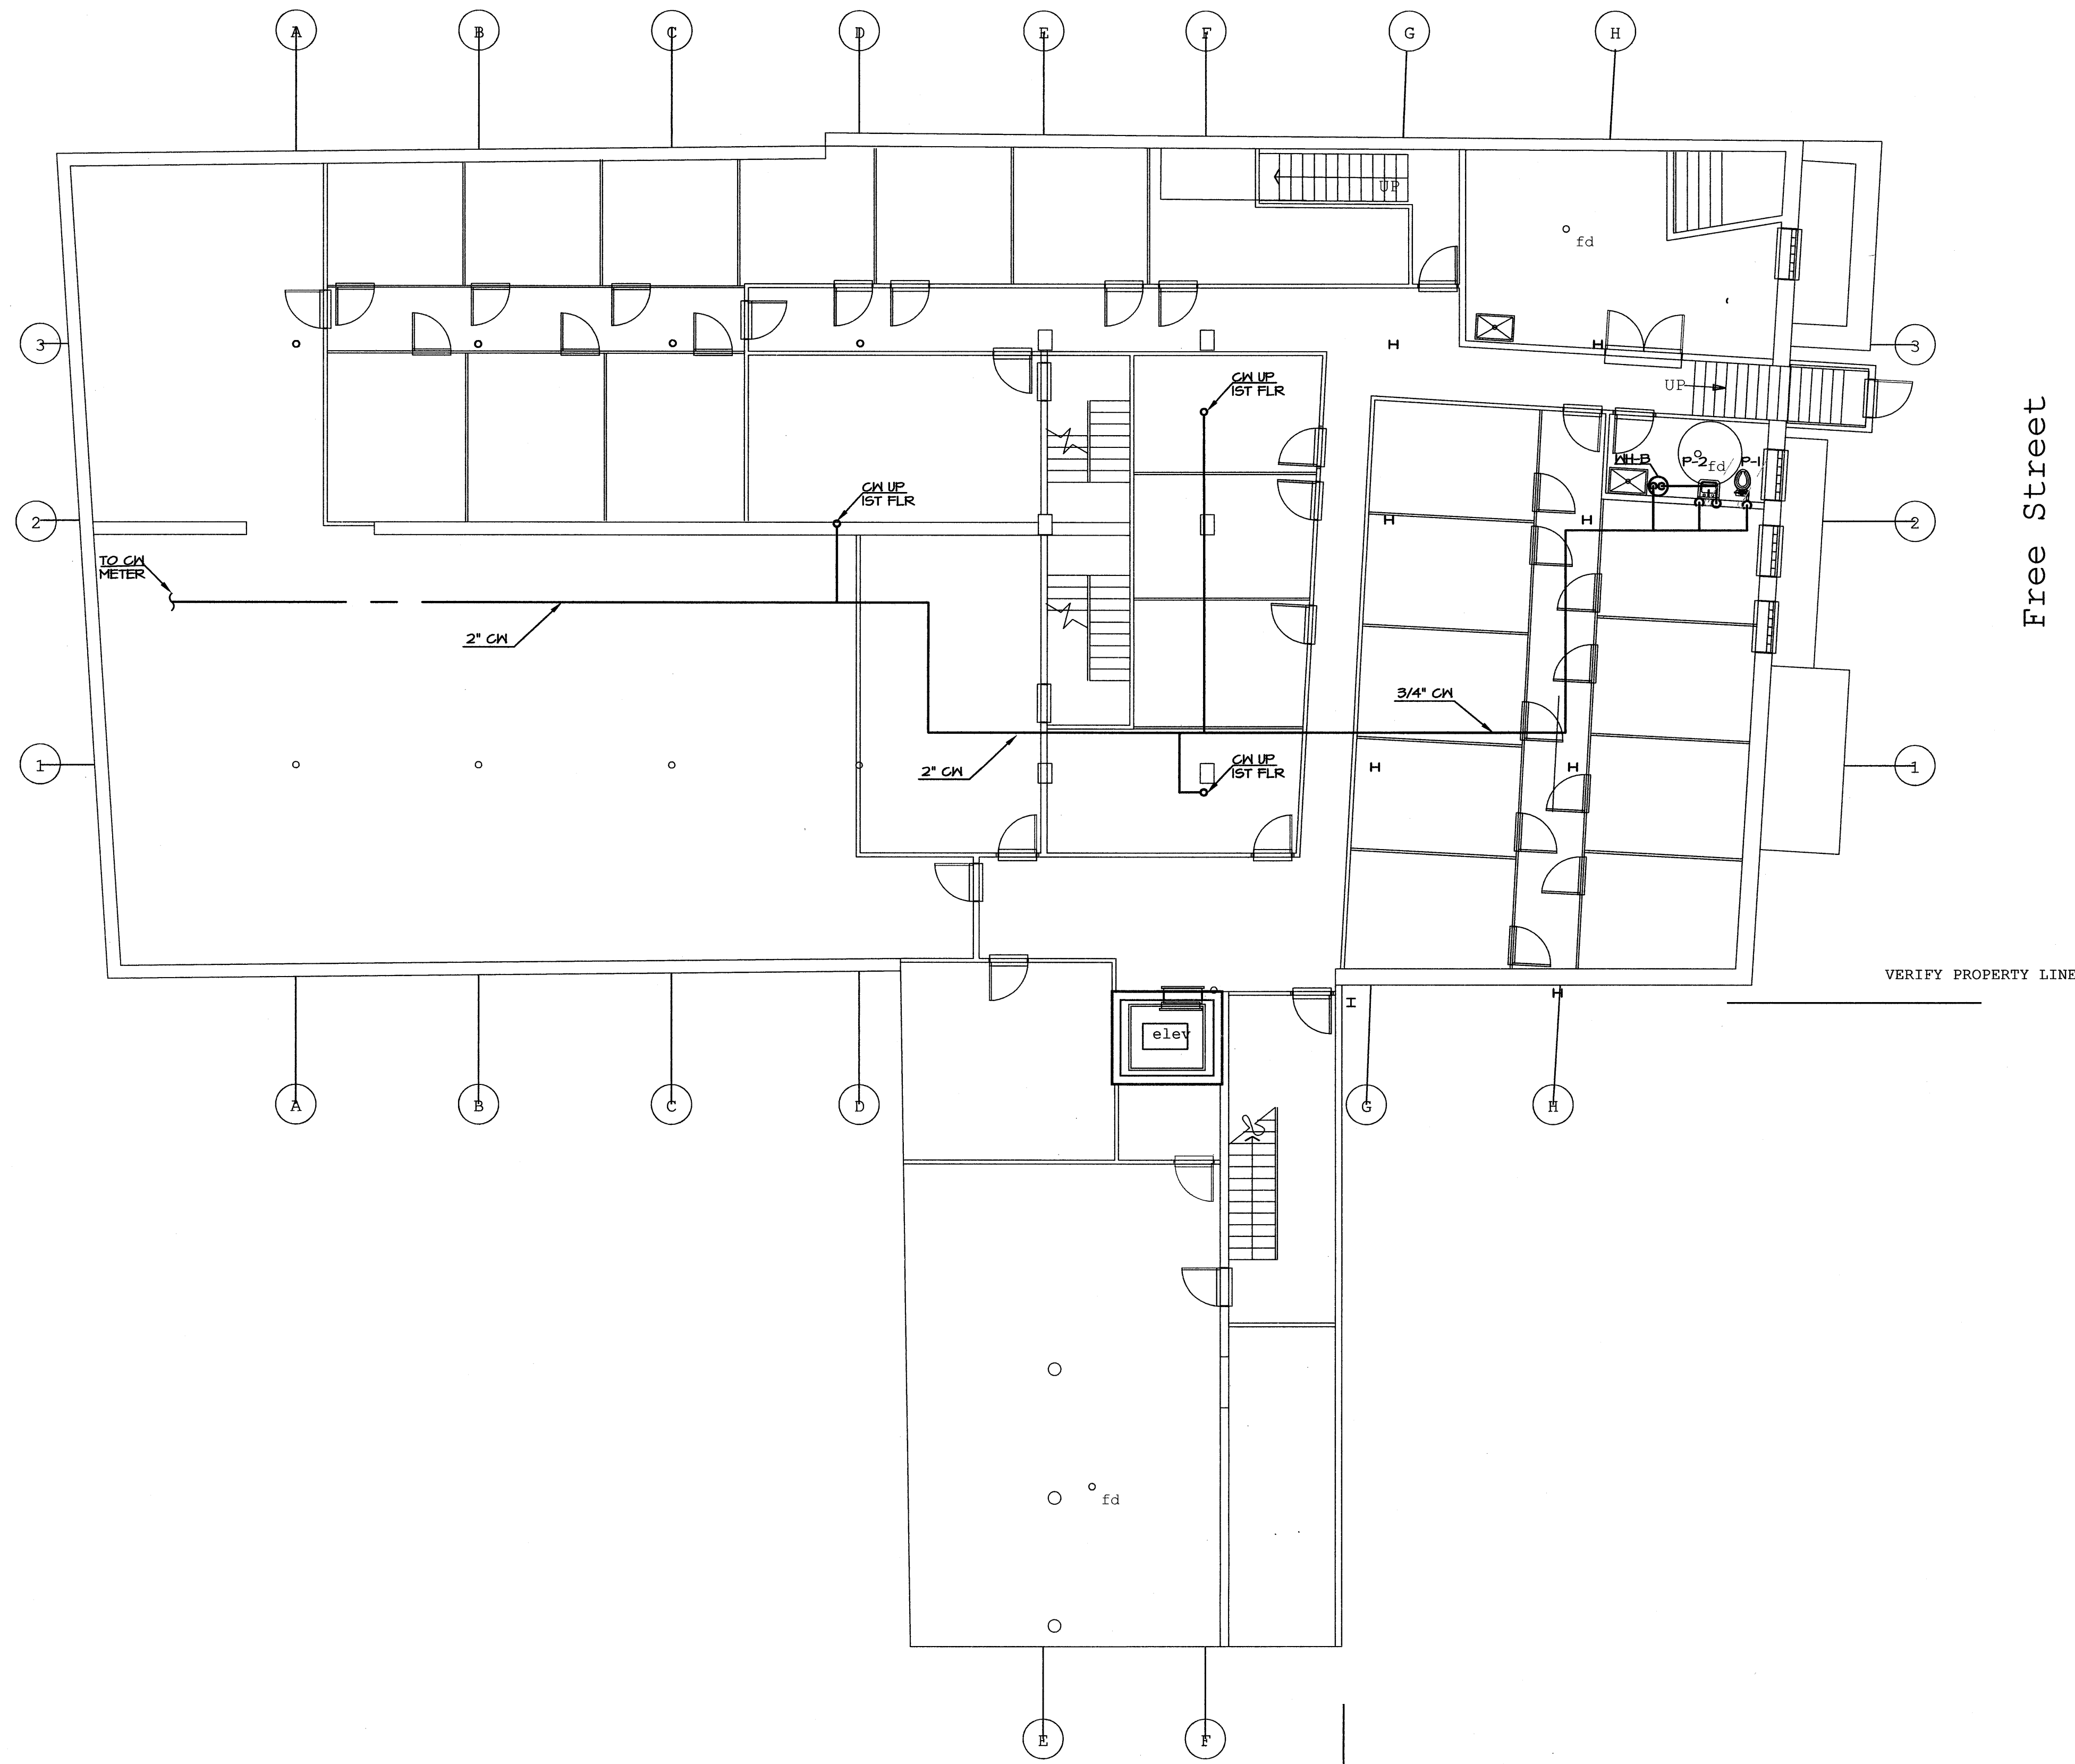

VERIFY PROPERTY LINE

Free Street

Brown Street

VERIFY PROPERTY LINE

This document is owned by and the information contained herein is proprietary to Titan Mechanical, Inc. By receipt of this document, the recipient agrees not to reproduce this document without the prior written consent of Titan Mechanical, Inc. and agrees to return the document forthwith upon request.

REVISIONS	DATE

**Titan Mechanical, Inc.**  
 Design Build Engineering - Mechanical Contracting  
 P.O. Box 3927 / 41 Evergreen Drive  
 Portland, Maine 04104  
 Ph. (207) 878-5223 Fax. (207) 878-5235



**KIMBALL BLOCK LLC**  
 CLIENT  
**490 CONGRESS ST. MECH. SYSTEMS**  
 PROJECT  
**BASEMENT DOMESTIC PLUMBING PLAN**  
 DRAWING TITLE

DATE: 05/17/05  
 SCALE: 1/8" = 1'-0"  
 DRAWN BY: RNC  
 CHECKED BY: JPN  
 JOB NUMBER: XXXX  
 CAD FILE: 490 CONGRESS.MVP  
 SHEET NUMBER

**P1.8**  
 SHEET 15 OF 21