



congress street

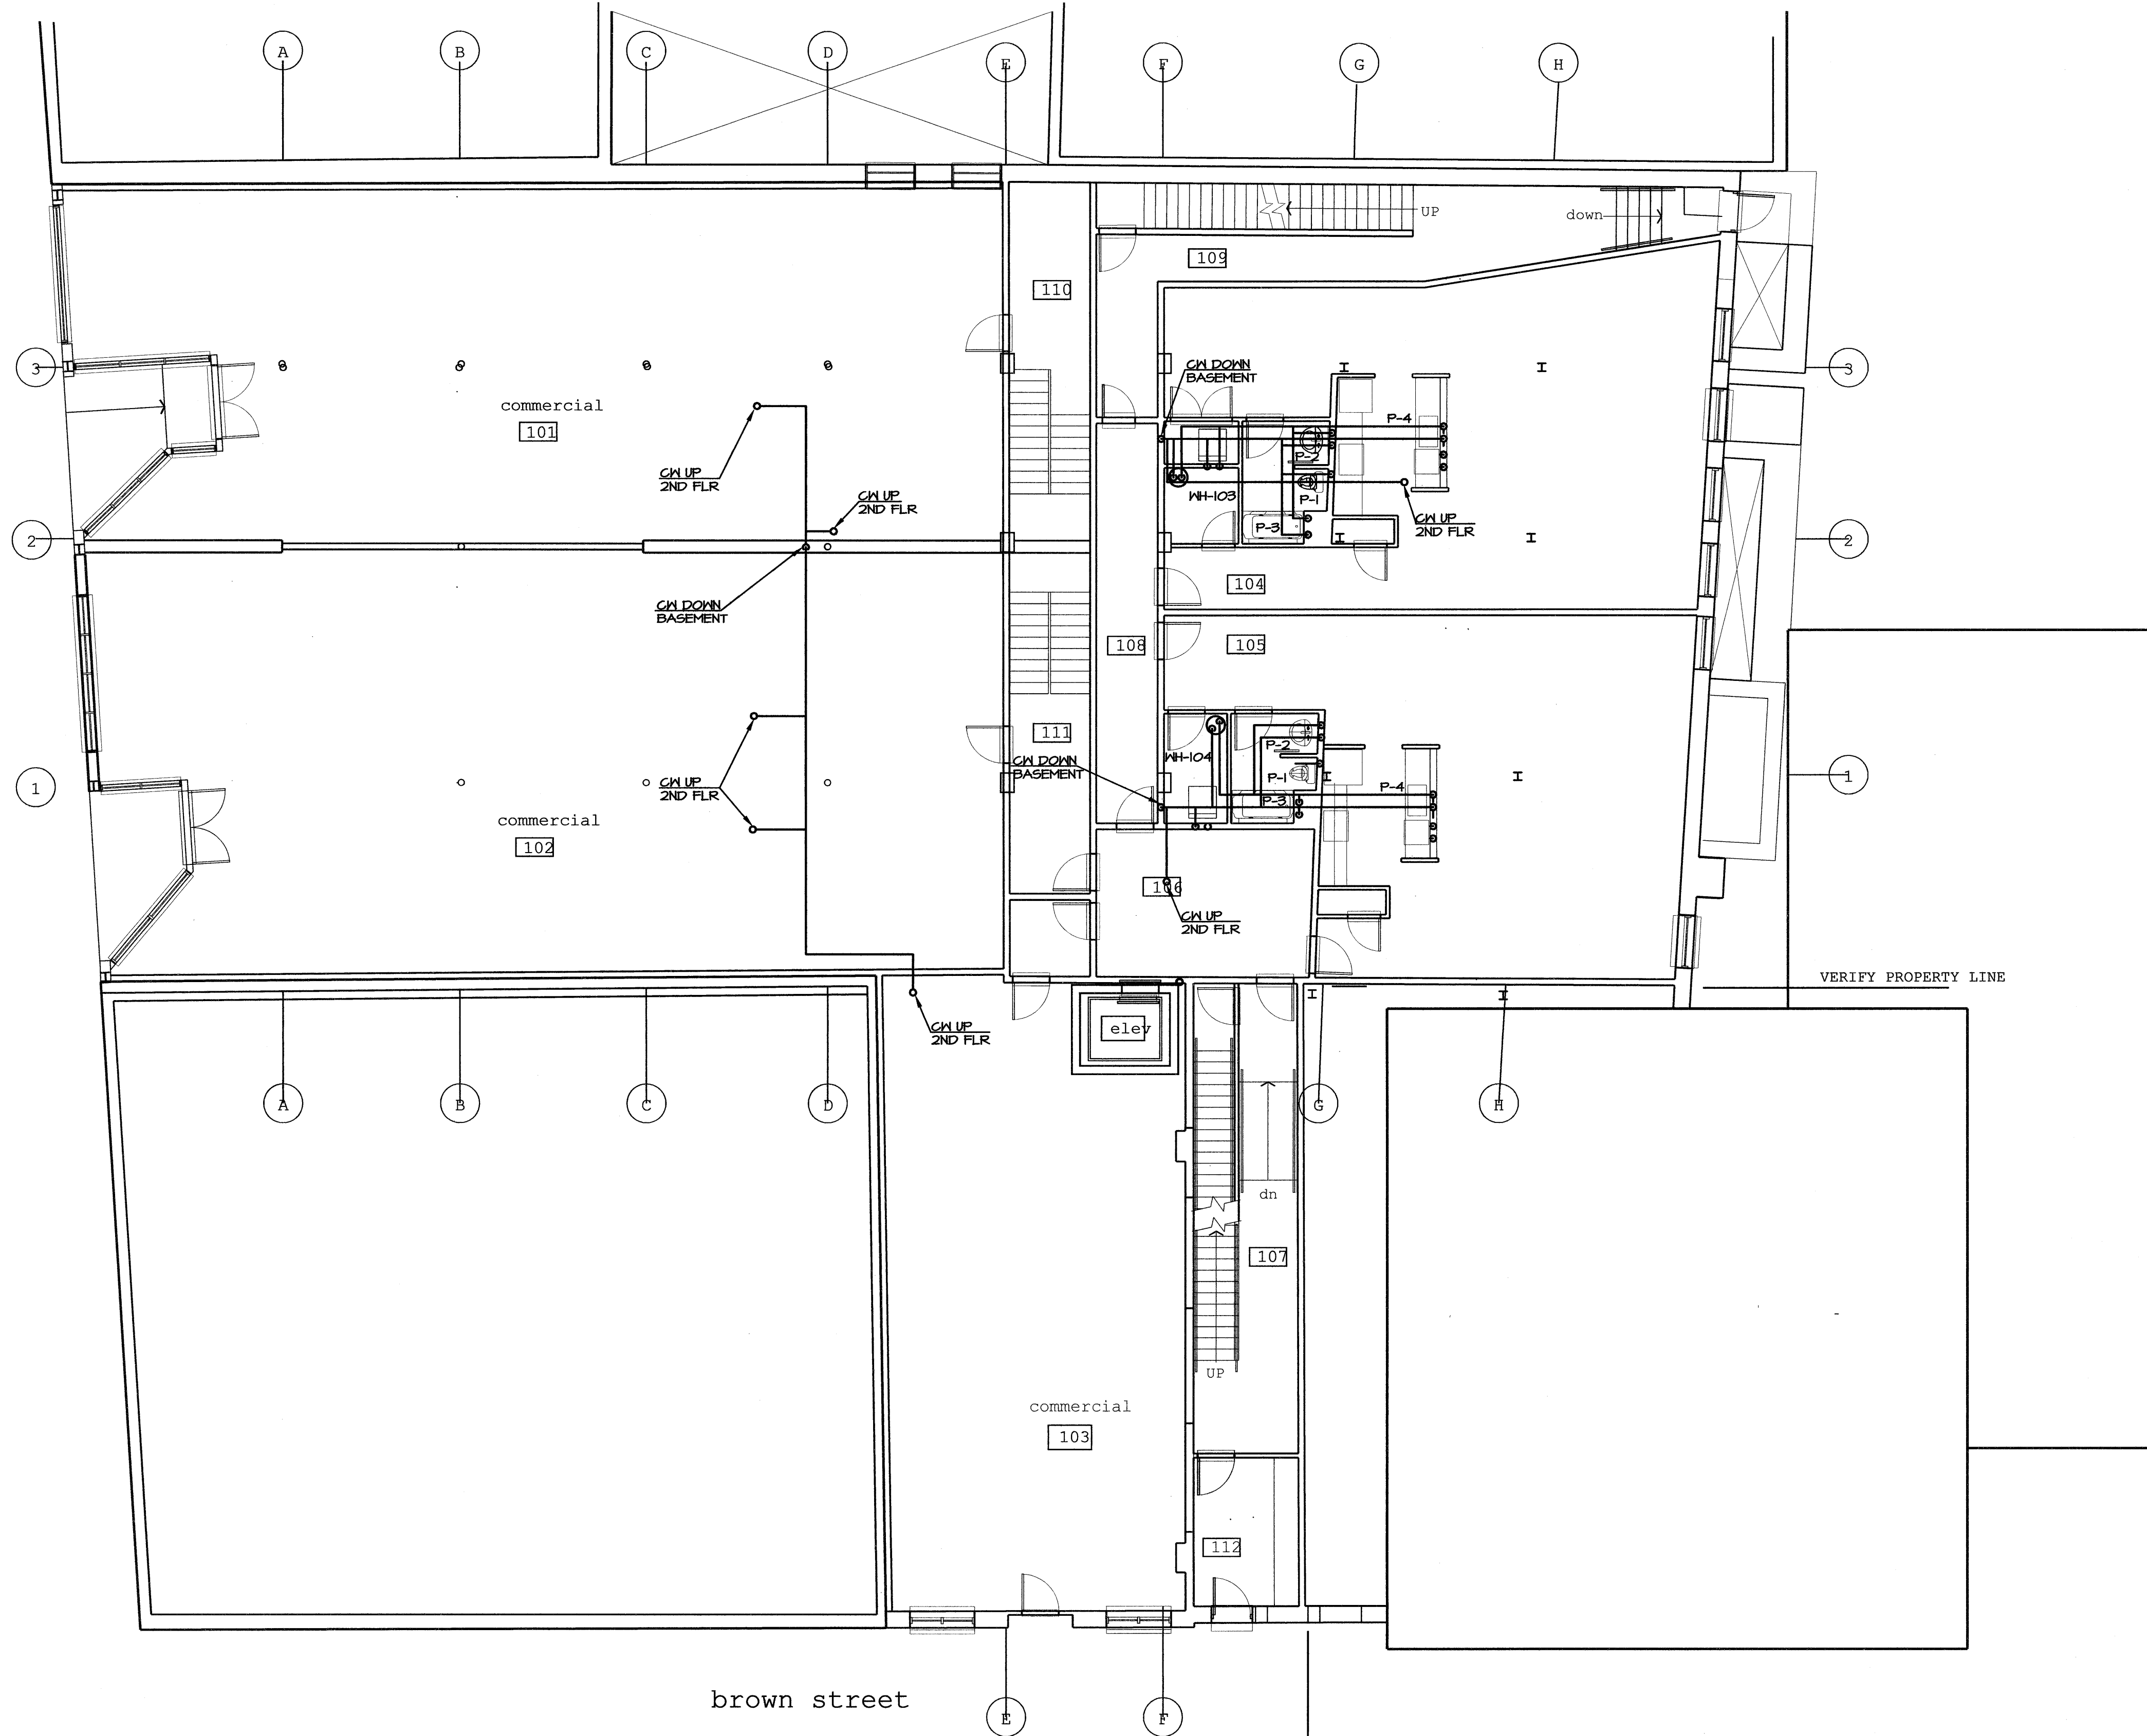

free street

brown street


general notes:

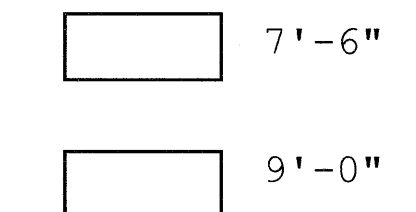

This document is owned by and the information contained herein is proprietary to Titan Mechanical Inc. By receipt hereof the holder agrees not to use the information, disclose it to any third party, nor reproduce the document without the prior written consent of Titan Mechanical Inc. and agrees to return the document forthwith upon request.

DATE	REVISIONS

Titan Mechanical, Inc.
 Design Build Engineering - Mechanical Contracting
 P.O. Box 3927 / 41 Evergreen Drive
 Portland, Maine 04104
 Ph. (207) 878-5223 Fax. (207) 878-5235

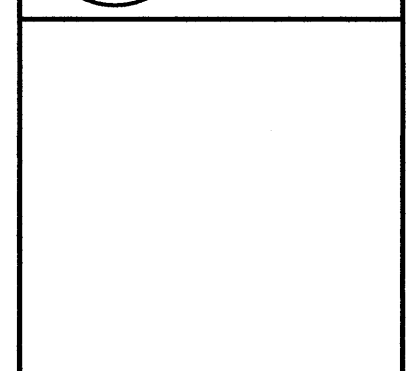

KIMBALL BLOCK LLC
 CLIENT
490 CONGRESS ST. MECH. SYSTEMS
 PROJECT
1ST FLOOR DOMESTIC PLUMBING PLAN
 DRAWING TITLE

DATE: 05/17/05
 SCALE: 1/8" = 1'-0"
 DRAWN BY: RNC
 CHECKED BY: JFN
 JOB NUMBER: XXXX
 CAD FILE: 40 CONGRESS.MP2
 SHEET NUMBER

P1.9
 SHEET 16 OF 21