



MUSEUM of AFRICAN CULTURE - ELECTRICAL PLAN
 SCALE = 1/4" = 1'-0"

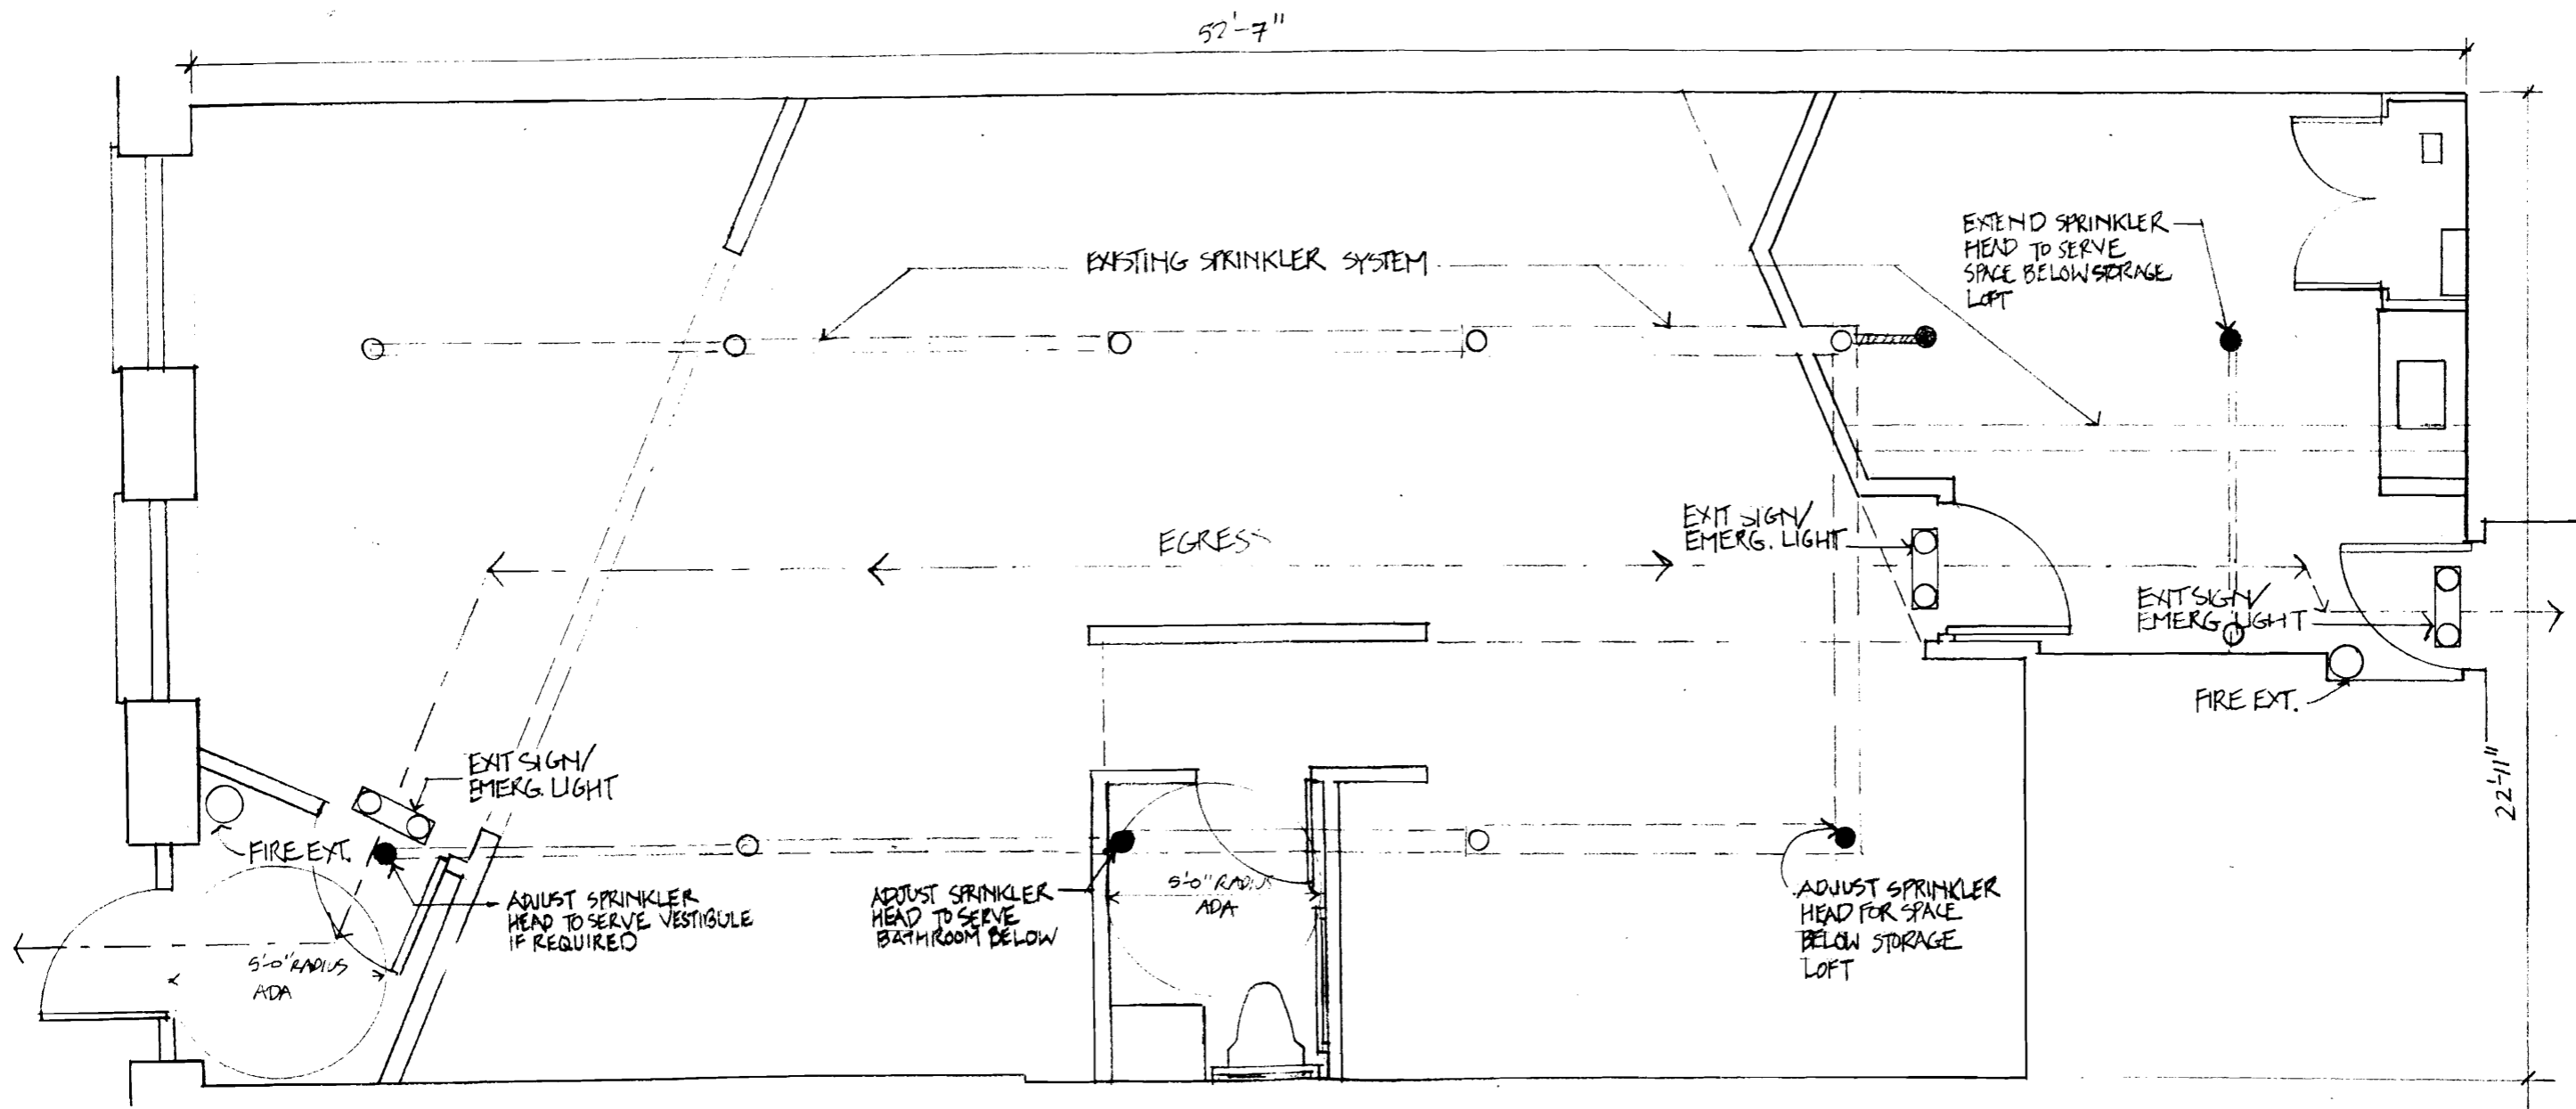


MUSEUM of AFRICAN CULTURE - LIFE SAFETY PLAN
 SCALE = 1/4" = 1'-0"


NOTE: UNIT HAS EXISTING SPRINKLER SYSTEM
 MODIFICATIONS MUST BE VERIFIED BY
 SPRINKLER CONTRACTOR

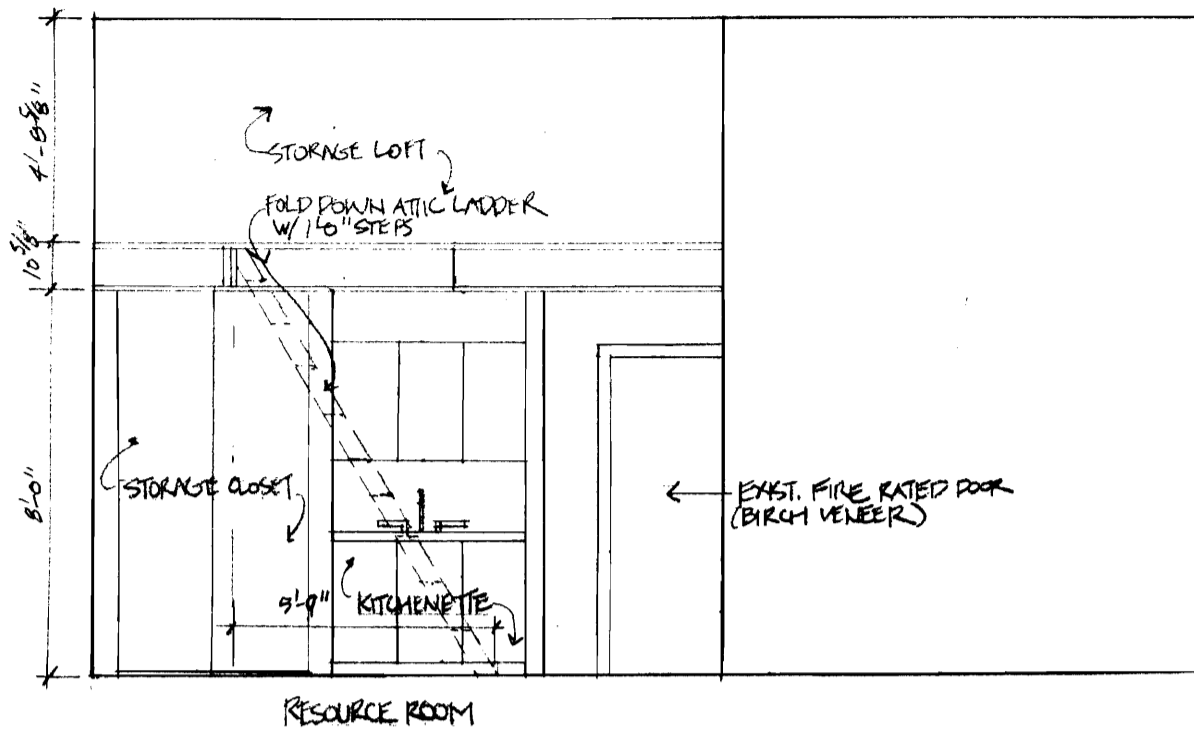


ELEVATION C
 SCALE = 1/4" = 1'-0"

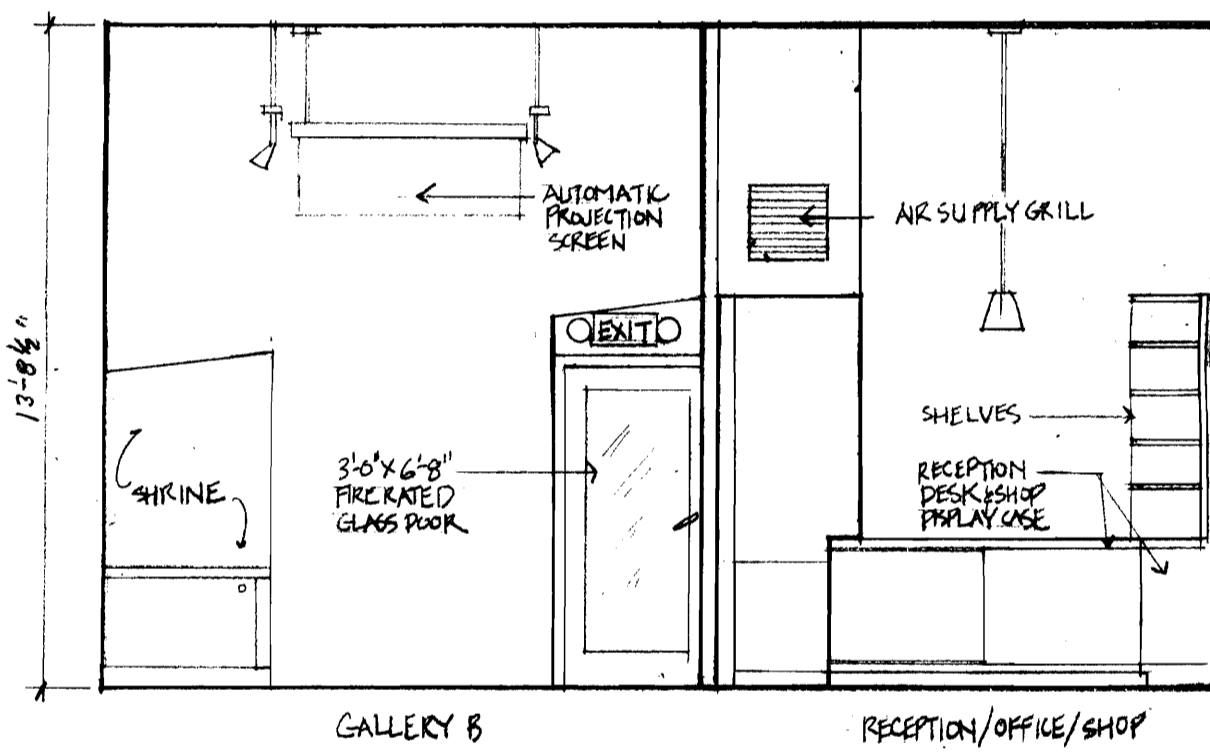


ELEVATION B
 SCALE = 1/4" = 1'-0"

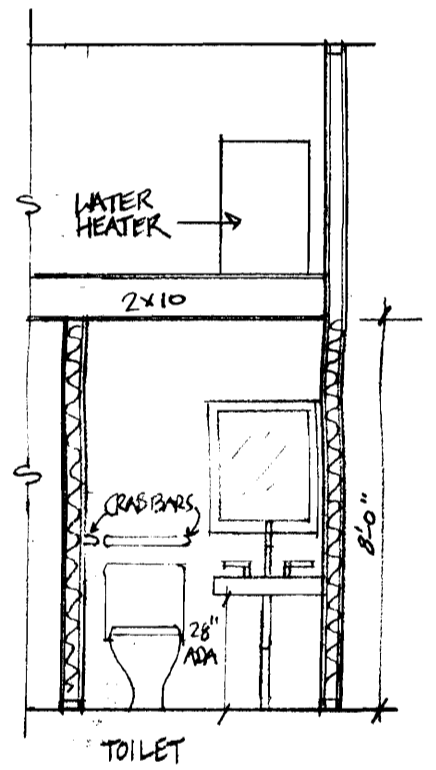

ELEVATION D
 SCALE = 1/4" = 1'-0"

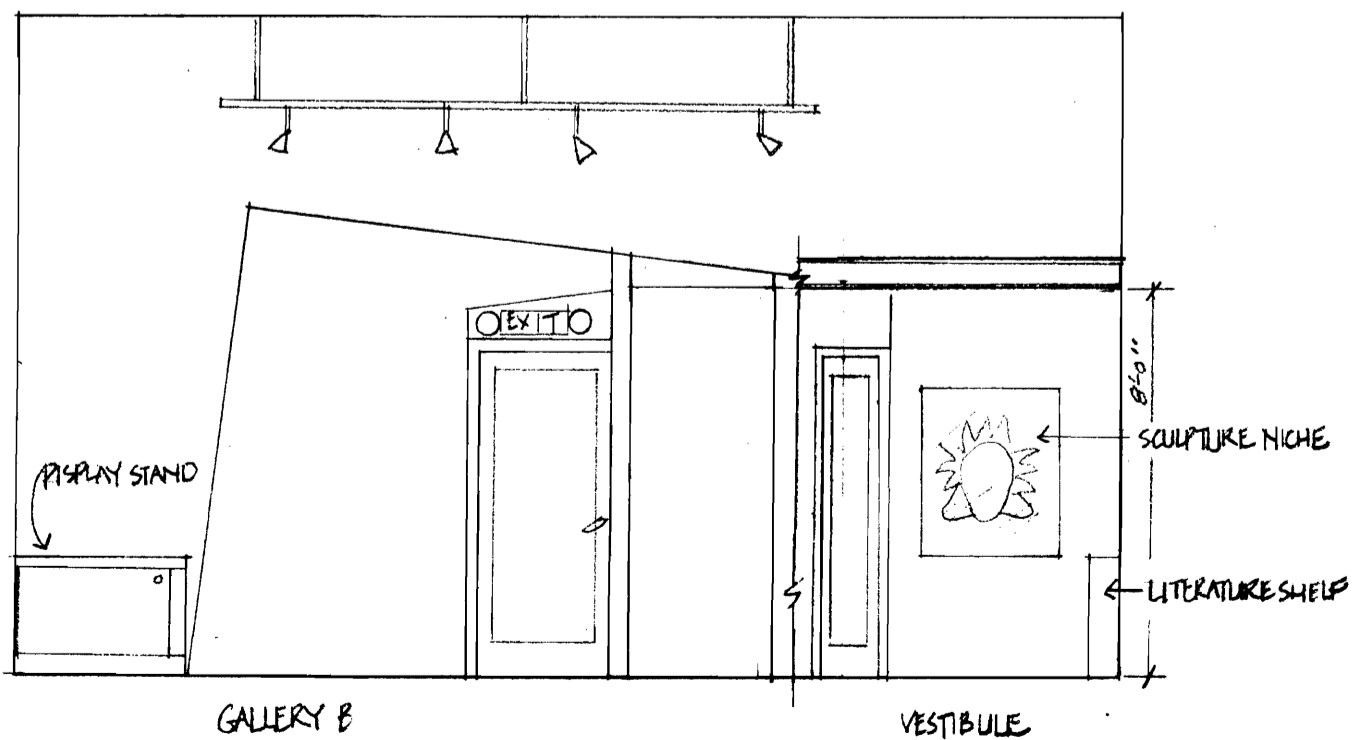


ELEVATION A
 SCALE = 1/4" = 1'-0"

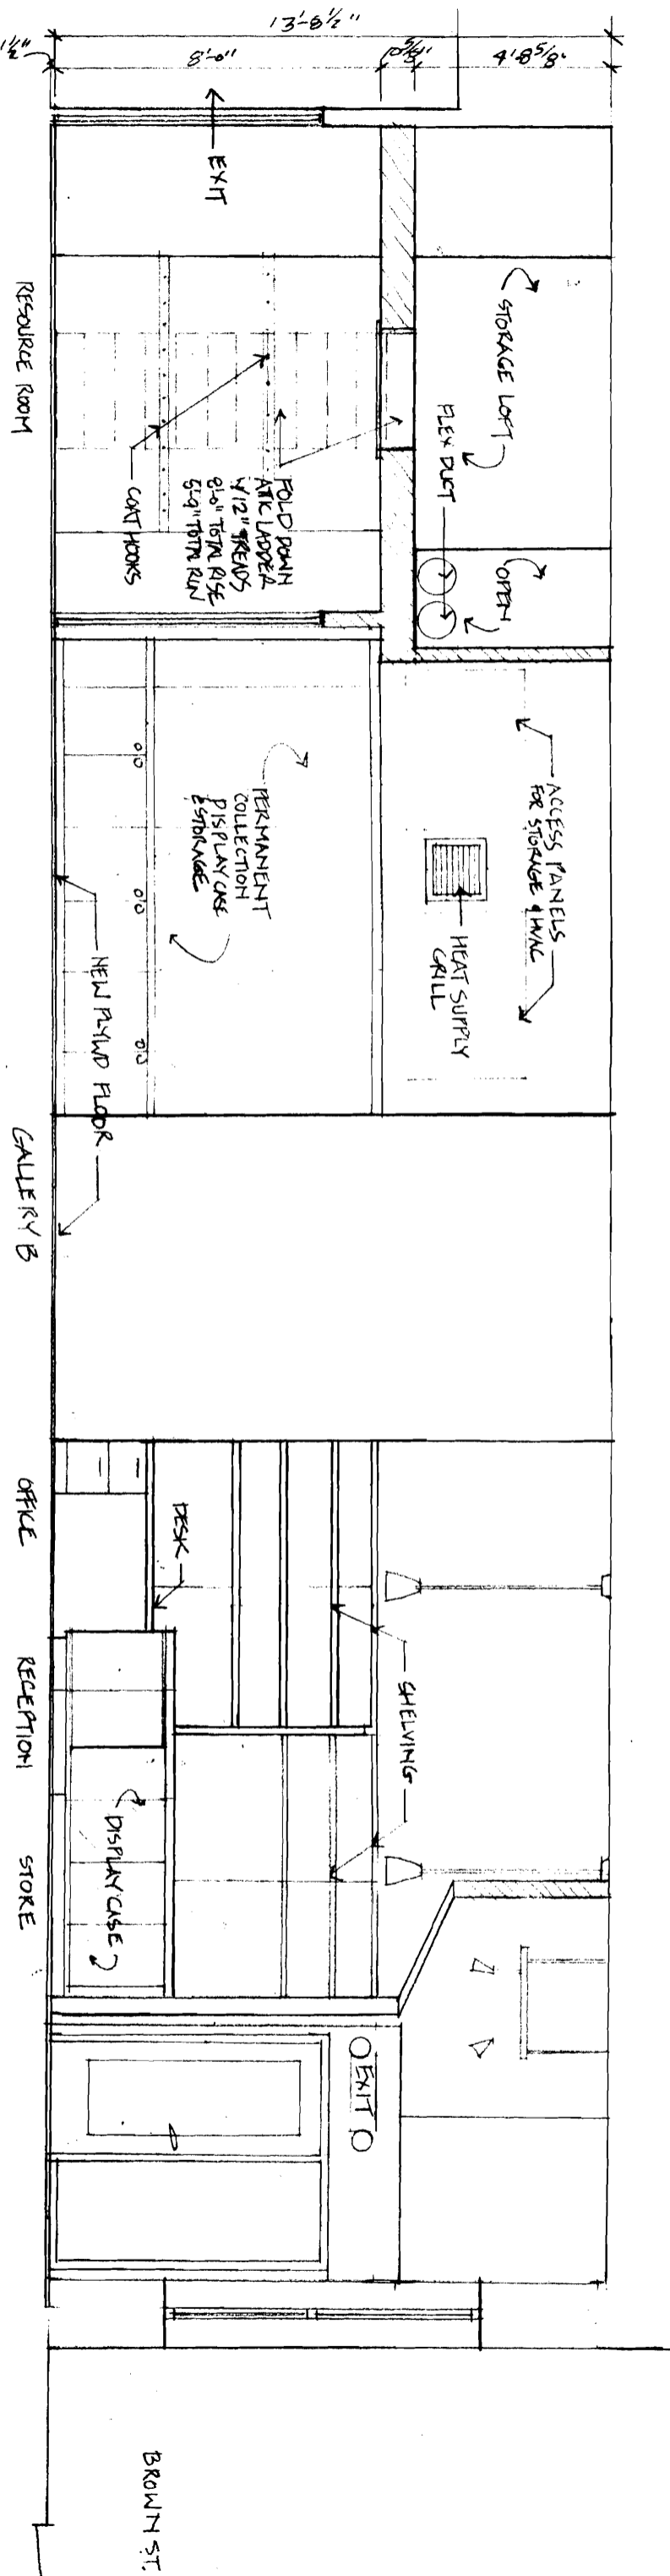

ELEVATION E


SCALE = 1/4" = 1'-0"

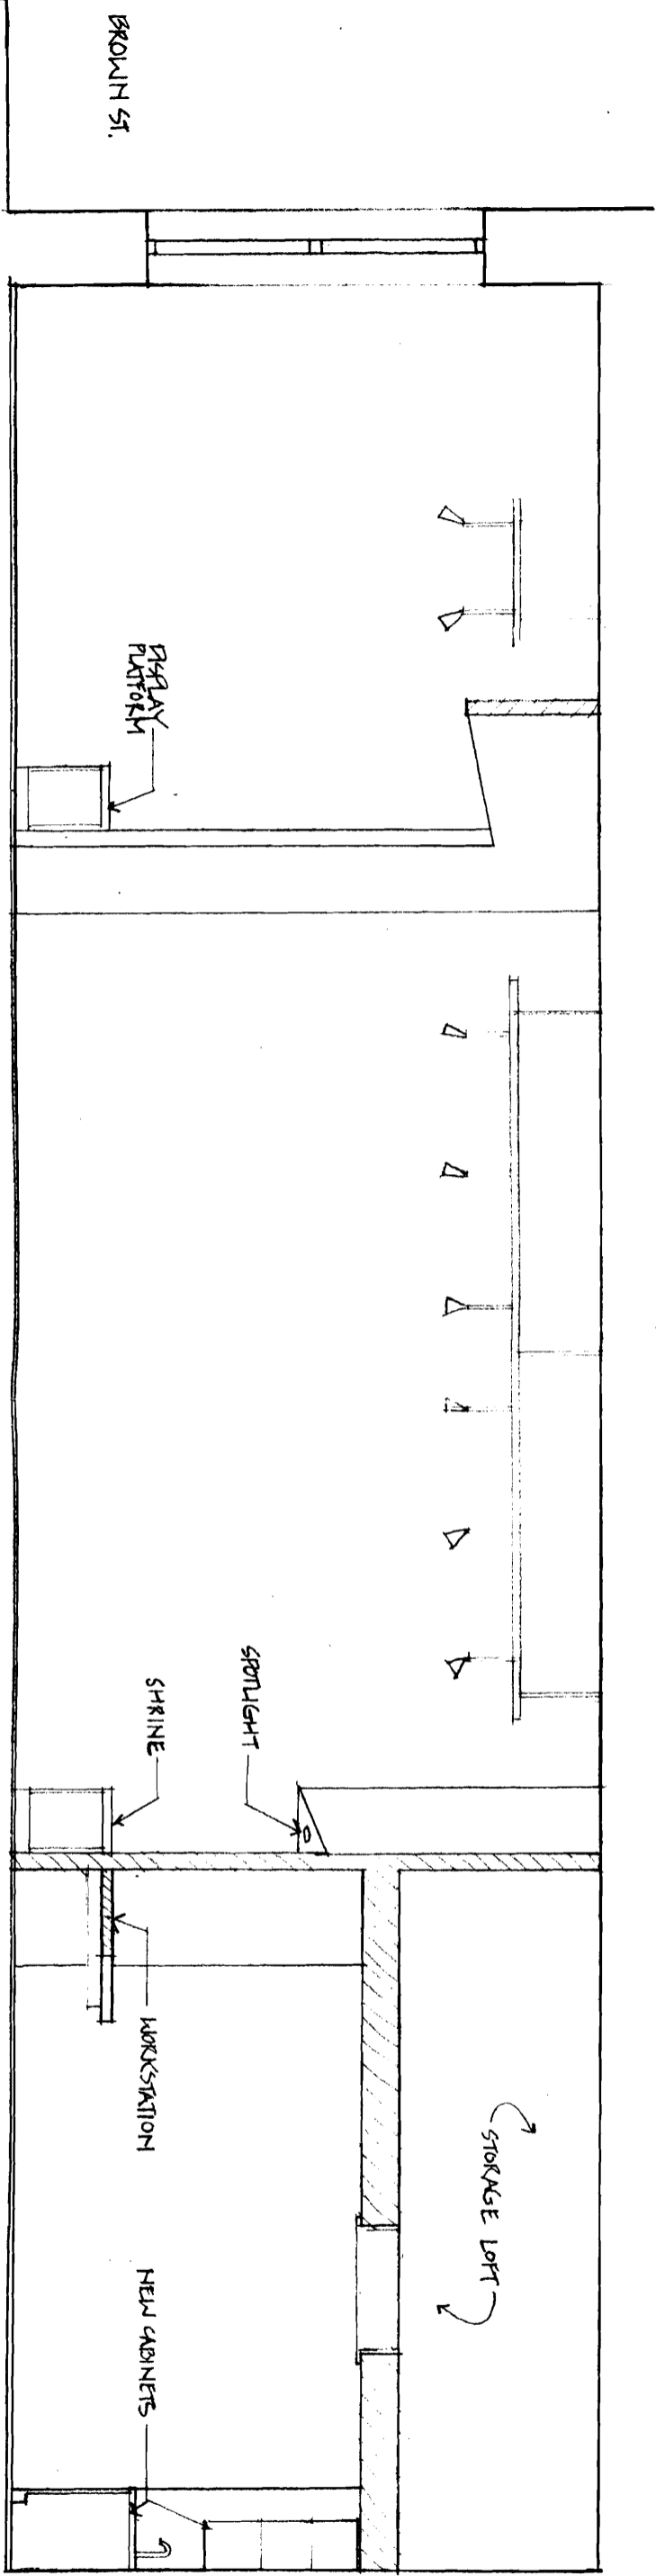

ELEVATION F


SCALE = 1/4" = 1'-0"

MUSEUM of AFRICAN CULTURE

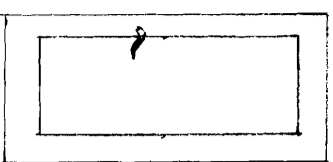


① VESTIBULE DOOR

3"x6" MATHG. WIR.
 FULL GLASS - RIGHT HAND REVERSE
 BB HINGERS
 KEYPED LOCK
 ELECTRIC STRIKE
 ADA LEVERS

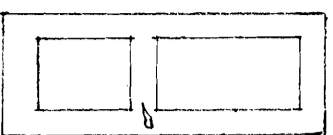


② BATHROOM DOOR

2"x6" MATHG. WIR.
 RANSFD 2 PANEL - LEFT HAND
 BB HINGERS
 PRIVACY SET HDW.
 ADA LEVERS

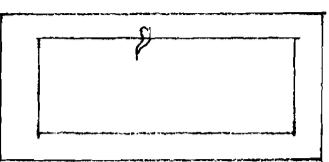

③ RESOURCE ROOM DOOR

3"x6" MATHG. WIR.
 FULL GLASS - RIGHT HAND
 BB HINGERS
 PASSAGE SET
 ADA LEVERS

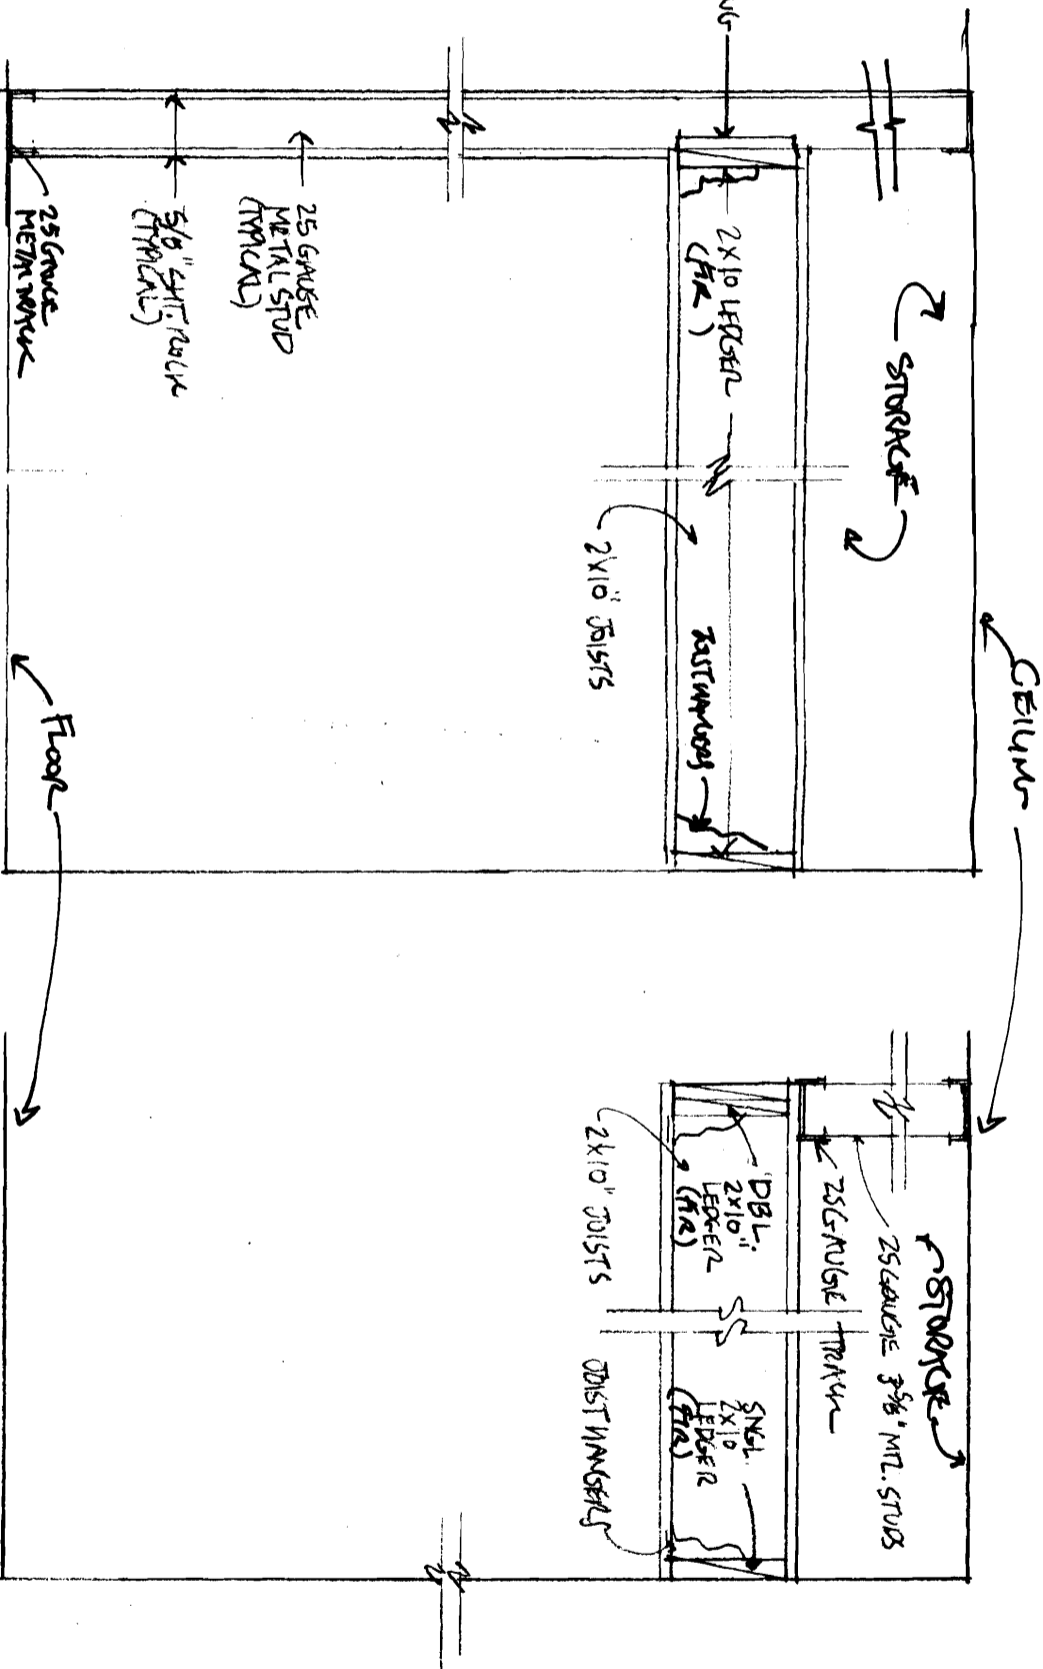

RESOURCE ROOM WALL LOFT FRAMING

PERM. COLLEMAN LOFT & WWR-ESTERON


NOTE: ALL DOOR HAVE HOLLOW METAL FIRE CODE FRAMES

MUSEUM of AFRICAN CULTURE - DOOR SCHEDULE & FRAMING DETAILS




① VESTIBULE DOOR

3"x6" MAHOG. UNR.
 FULL GLASS - RIGHT HAND REVERSE
 BR. HINGERS
 KEYED LOCK
 ELECTRIC STRIKE
 ADA LEVERS

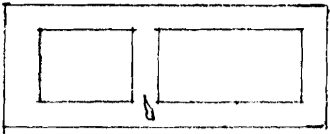


② BATHROOM DOOR

2"x6" MAHOG. UNR.
 RAISED 2 PANELED - LEFT HAND
 BR. HINGERS
 PRIVACY SET HDW.
 ADA LEVERS

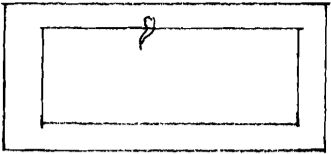


③ RESOURCE ROOM DOOR

3"x6" MAHOG. UNR.
 FULL GLASS - RIGHT HAND
 BR. HINGERS
 PASSAGE SET
 ADA LEVERS

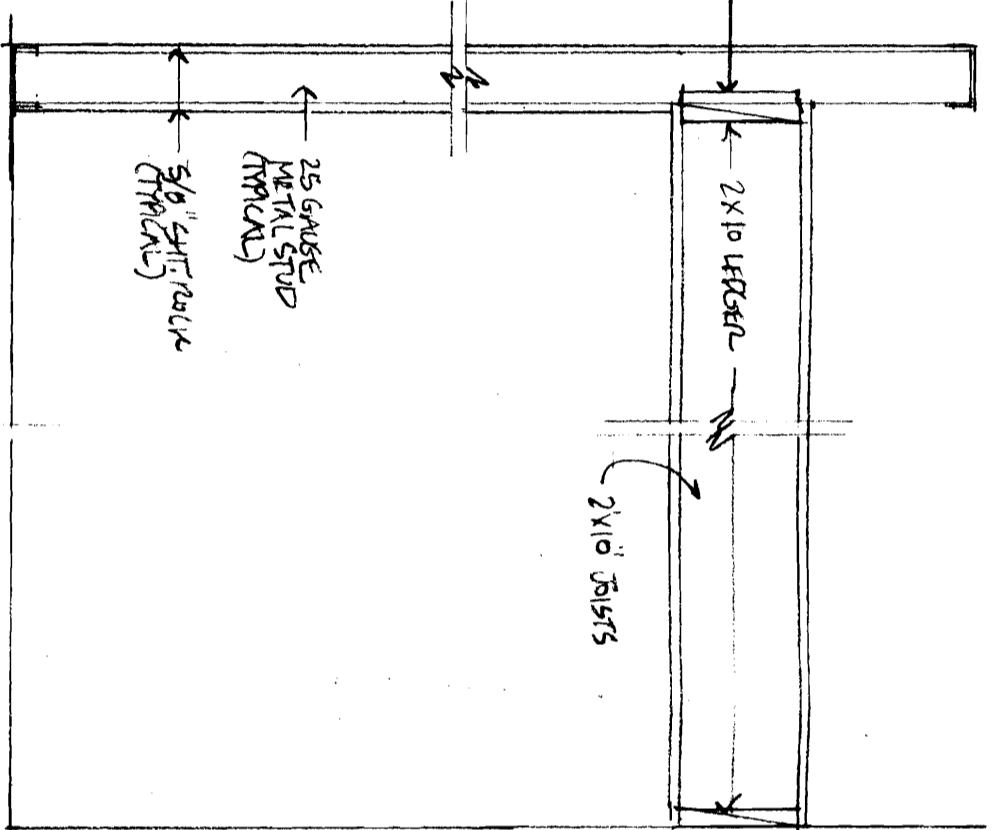

RESOURCE ROOM WALL & LEFT FRAMING

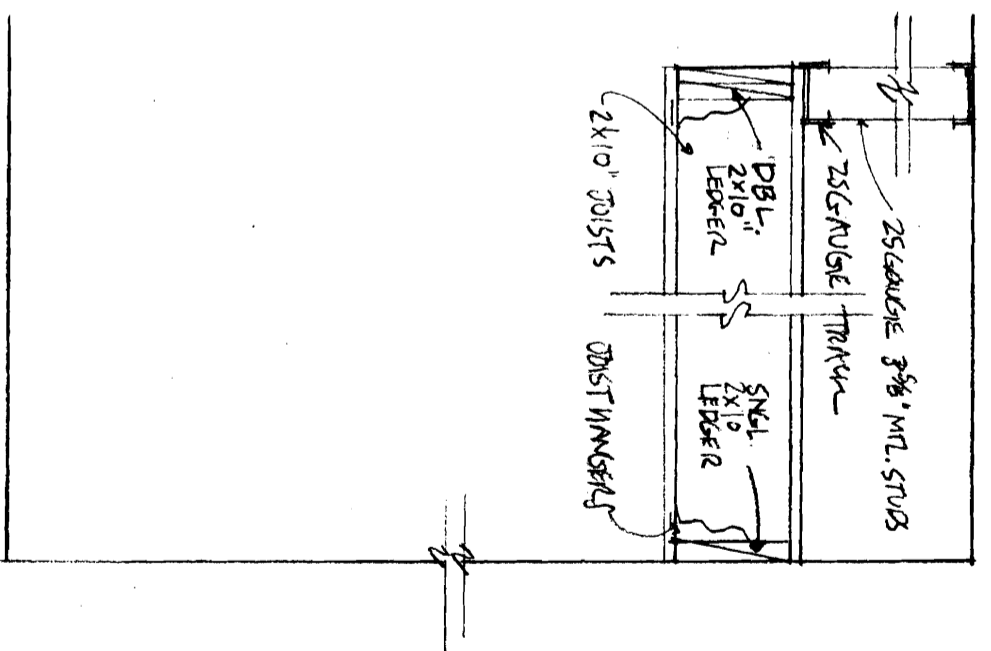

MUSEUM of AFRICAN CULTURE - DOOR SCHEDULE & FRAMING DETAILS