
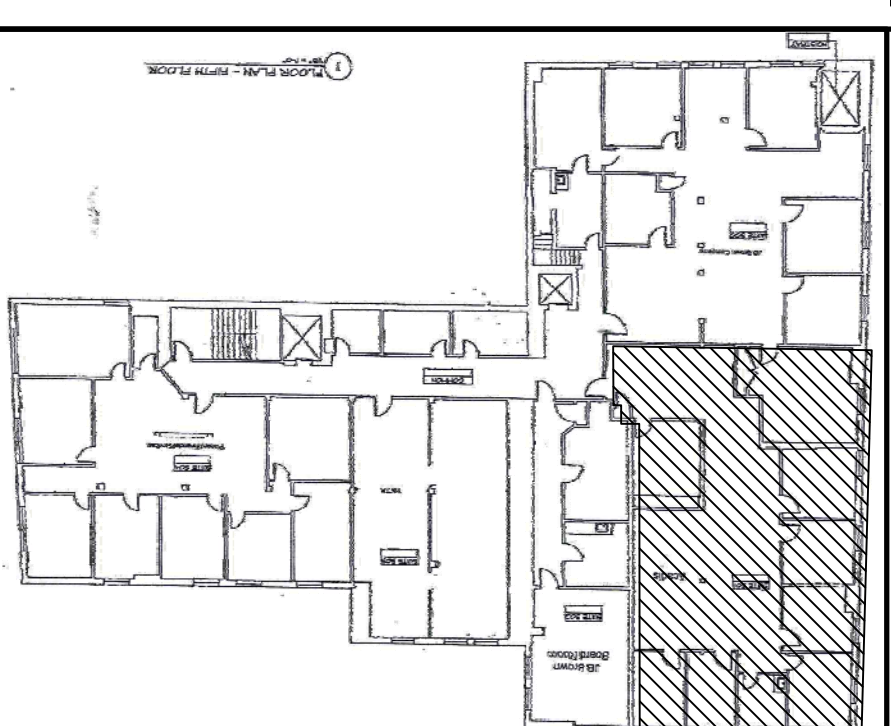


ELECTRICAL NOTES

- FURNITURE BY OTHERS. INFORMATION PROVIDED FOR INFORMATION ONLY.
- SPECIALTY POWER AND DATA NETWORK OUTLETS TO BE PROVIDED FOR ALL EQUIPMENT/ INCLUDING COPIERS, PLOTTERS, ETC.
- ELECTRICAL SHOWN AT RECOMMENDED LOCATIONS. REUSE EXISTING ELECTRICAL WHERE APPROPRIATE. REASSESS CONVENIENCE OUTLETS AS NEEDED. CONTRACTOR TO ASSESS EXISTING ELECTRICAL FOR USABILITY.
- DATA/COMMUNICATIONS SHALL BE FURNISHED AND INSTALLED BY TENANT'S CONTRACTOR. PROVIDE RING & STRING AT NEW LOCATIONS SHOWN ON PLAN.
- COORDINATE ALL ELECTRICAL DEVICE LOCATIONS AND REQUIREMENTS WITH FURNITURE VENDOR. NOTE SHALL BE PLACED ON ELECTRICAL POWER PLAN.
- ADD OR MODIFY EXISTING DETECTION AND ALARM SYSTEM. LOCAL BELLWORKS AND FIRE SAFETY. AS WELL AS ADA ACCESSIBILITY GUIDELINES. G.C. TO REVIEW STROBE LOCATIONS WITH ARCHITECT PRIOR TO INSTALLATION. G.C. TO MARK AND VERIFY LOCATIONS OF ANY OF THE ABOVE EQUIPMENT BEFORE INSTALLING IN OPS/ISSUE BOARD DESIGN AGREEMENT, AND TO BE DESIGN-BUILD.
- MODULAR FURNITURE TO BE A WIRE SYSTEM FED FROM A SYSTEMS FURNITURE CORE DRILL OR WALL FEED. ASSUME A 4 CIRCUIT / 8 WIRE SYSTEM. ASSUME 1 CIRCUIT PER 2 WORKSTATIONS.
- ELECTRICAL CONTRACTOR SHALL SUPPLY 90 DEGREE ELBOW CONNECTORS TO THE FURNITURE WHIPS SUPPLIED BY VENDOR.
- ELECTRICAL DESIGN AND PERMITTING TO BE DESIGN-BUILD.

ELECTRICAL LEGEND

ELECTRICAL	FLOOR	WALL	
⊙	⊗	⊕	JUNCTION BOX
⊖	⊕	⊖	DUPLEX RECEPTACLE
⊖	⊕	⊖	AC = ABOVE COUNTER
⊖	⊕	⊖	QUADREPLEX RECEPTACLE
⊖	⊕	⊖	TELEPHONE OUTLET MTD
⊖	⊕	⊖	TELECOMMUNICATION OUTLET MTD, UON
⊖	⊕	⊖	COMBINATION TELEPHONE/DATA OUTLET
⊖	⊕	⊖	COMB POWER/TELEPHONE/DATA OUTLET, FLUSH MOUNTED.
⊖	⊕	⊖	POWER POLE
⊖	⊕	⊖	FURNITURE FEED - COMMUNICATION, FLUSH MOUNT
⊖	⊕	⊖	FURNITURE FEED - POWER, FLUSH MOUNT

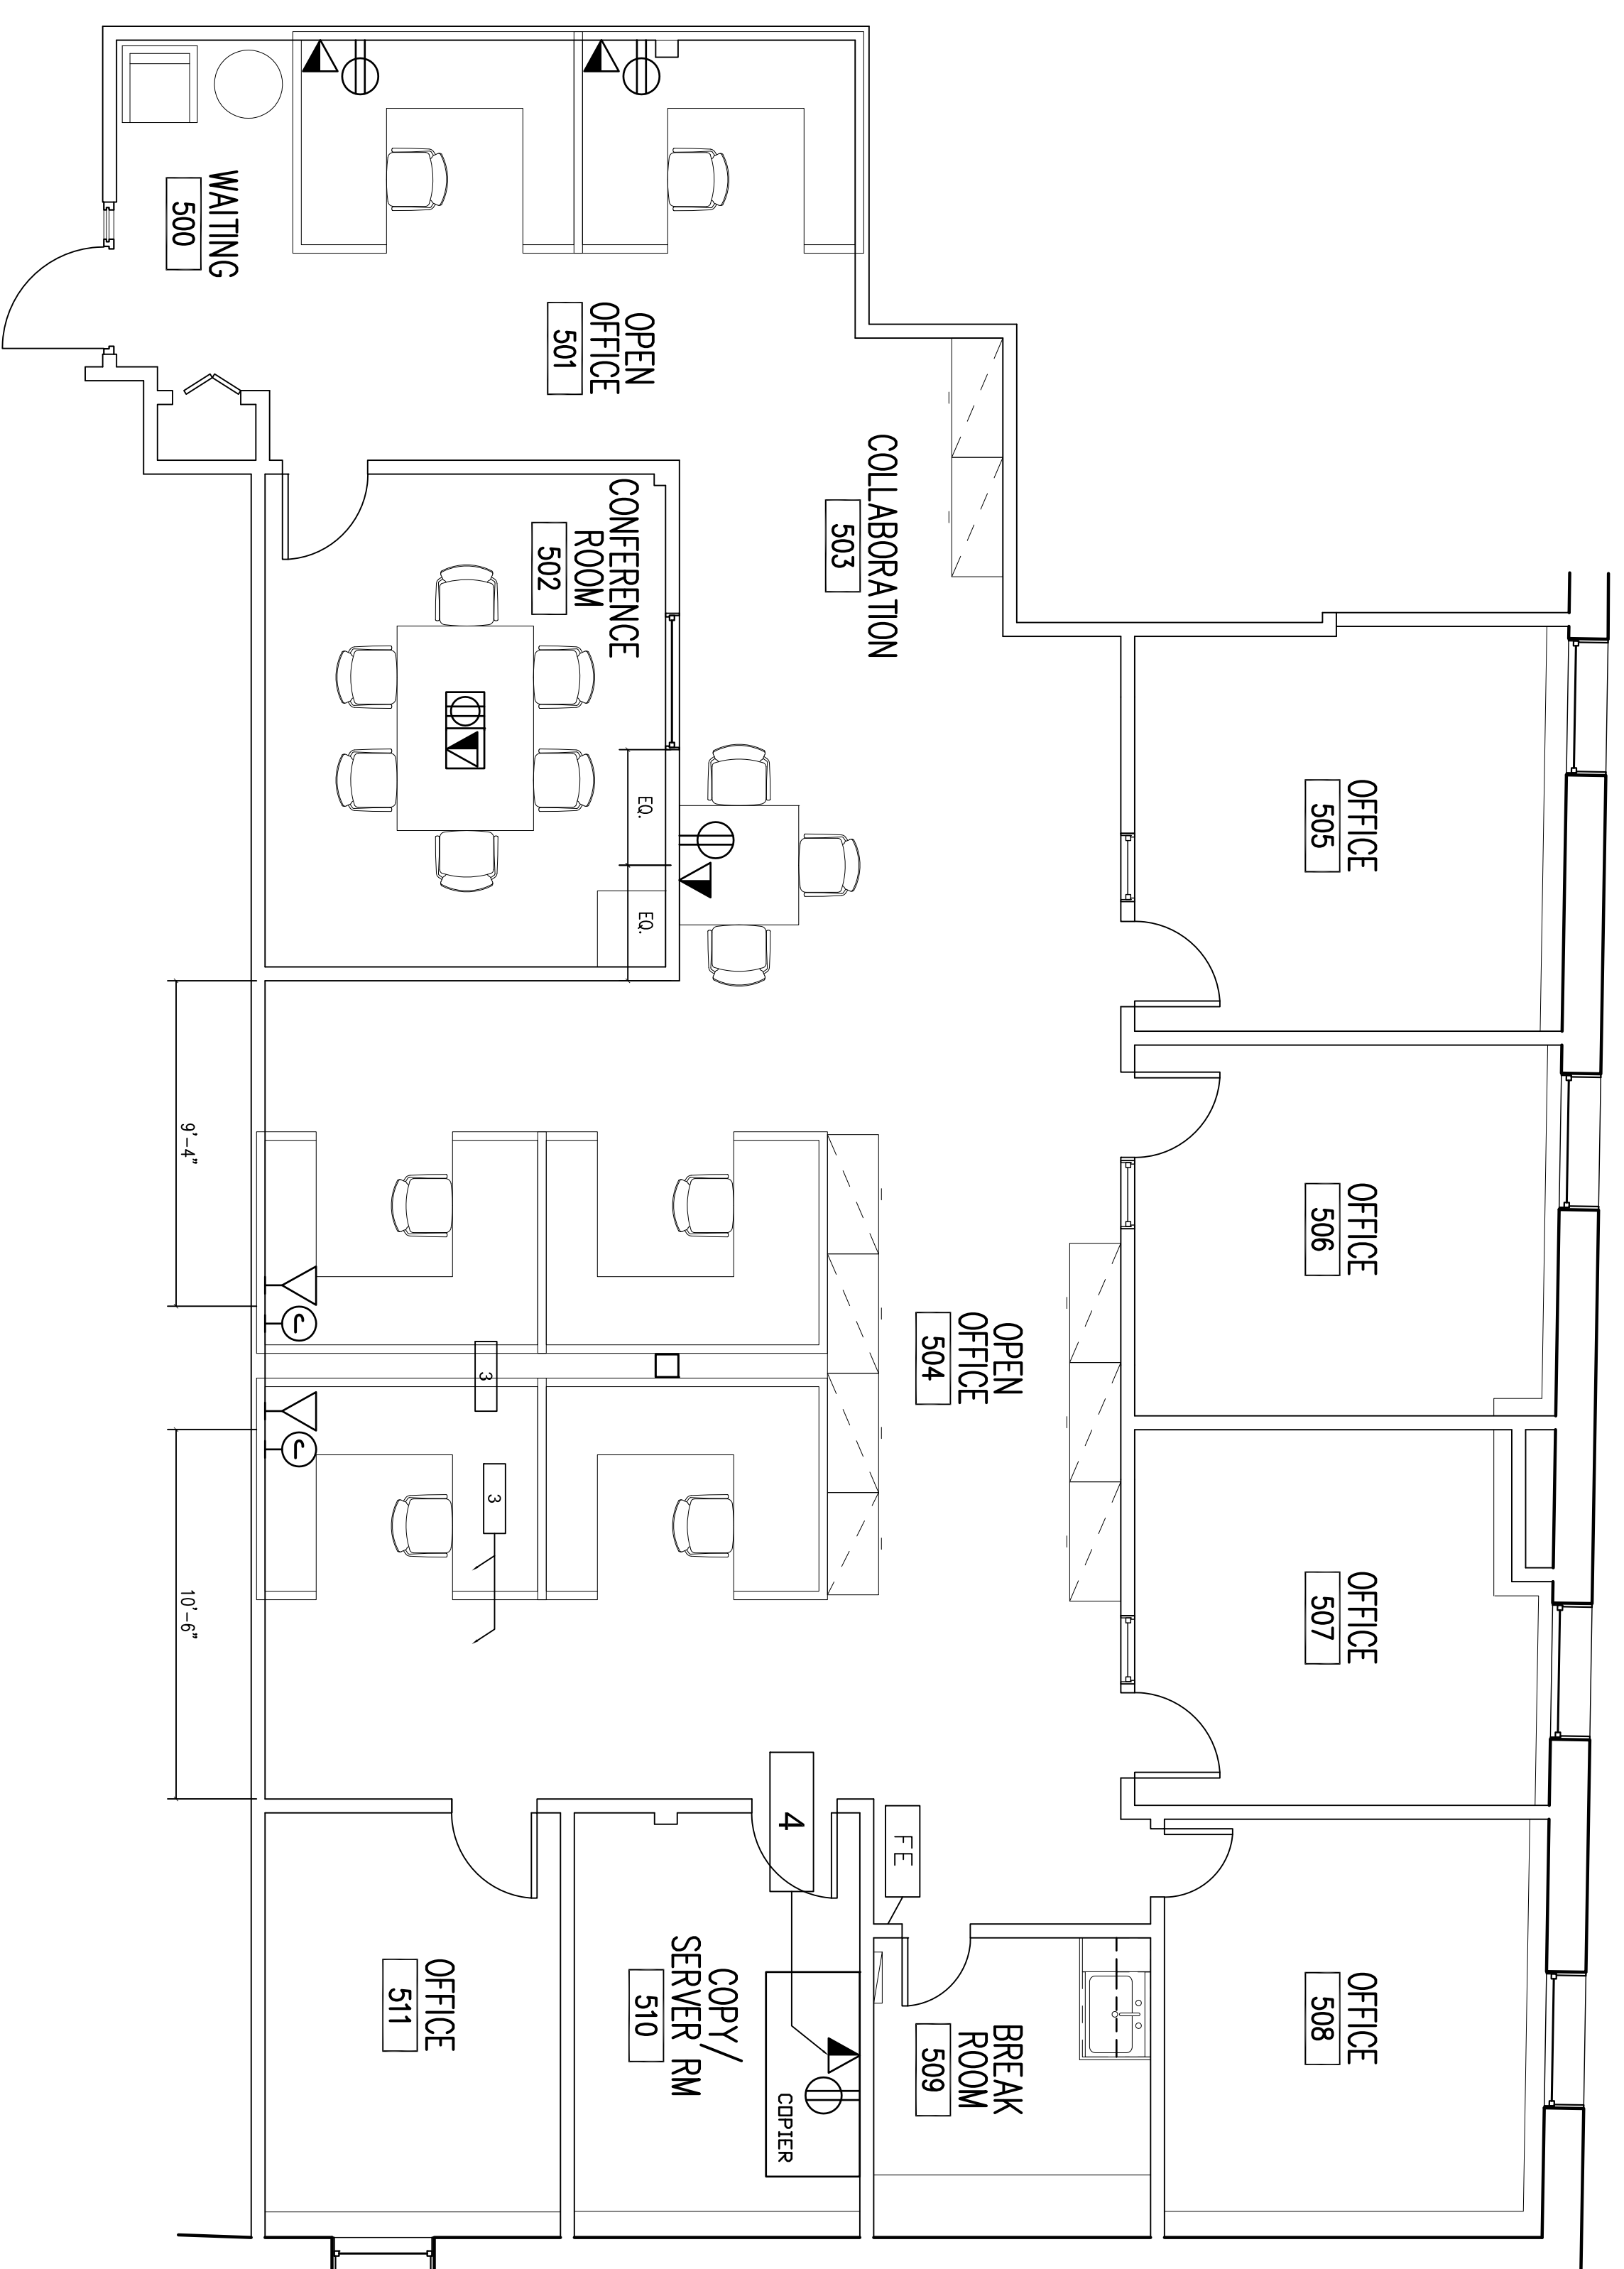

PROJECT NORTH

REV.	DESCRIPTION	DATE
1	FINISH SELECTIONS	01/23/15
0	NOTE REVISIONS	01/15/15

CURRENT ISSUE STATUS:

DESIGN GROUP
COLLABORATIVE
ARCHITECTURE
ARCHITECTURE
DESIGN + PLANNING
 22 FREE STREET
 PORTLAND, MAINE 04101
 (207) 699-3300

ARCADIS
 cty, stg

FURNITURE PLAN

SHEET TITLE:	DATE:	DRAWING SCALE:
SHIRLEY E. HOLT No. 3413 LICENSED ARCHITECT STATE OF MAINE	12/19/2014	0" = 1"
PROJECT NO.:	SCALE:	SHEET NO.:
124012	AS NOTED	0
DRAWN BY:	DATE:	DATE OF RECORD:
SH	01/15/15	
CW		

A6 FURNITURE PLAN
 1/8" = 1'-0"