


REVISION	DESCRIPTION	DATE
0	ISSUED FOR REVIEW & APPROVAL	5/10/2016

RESERVED FOR CITY STAMP

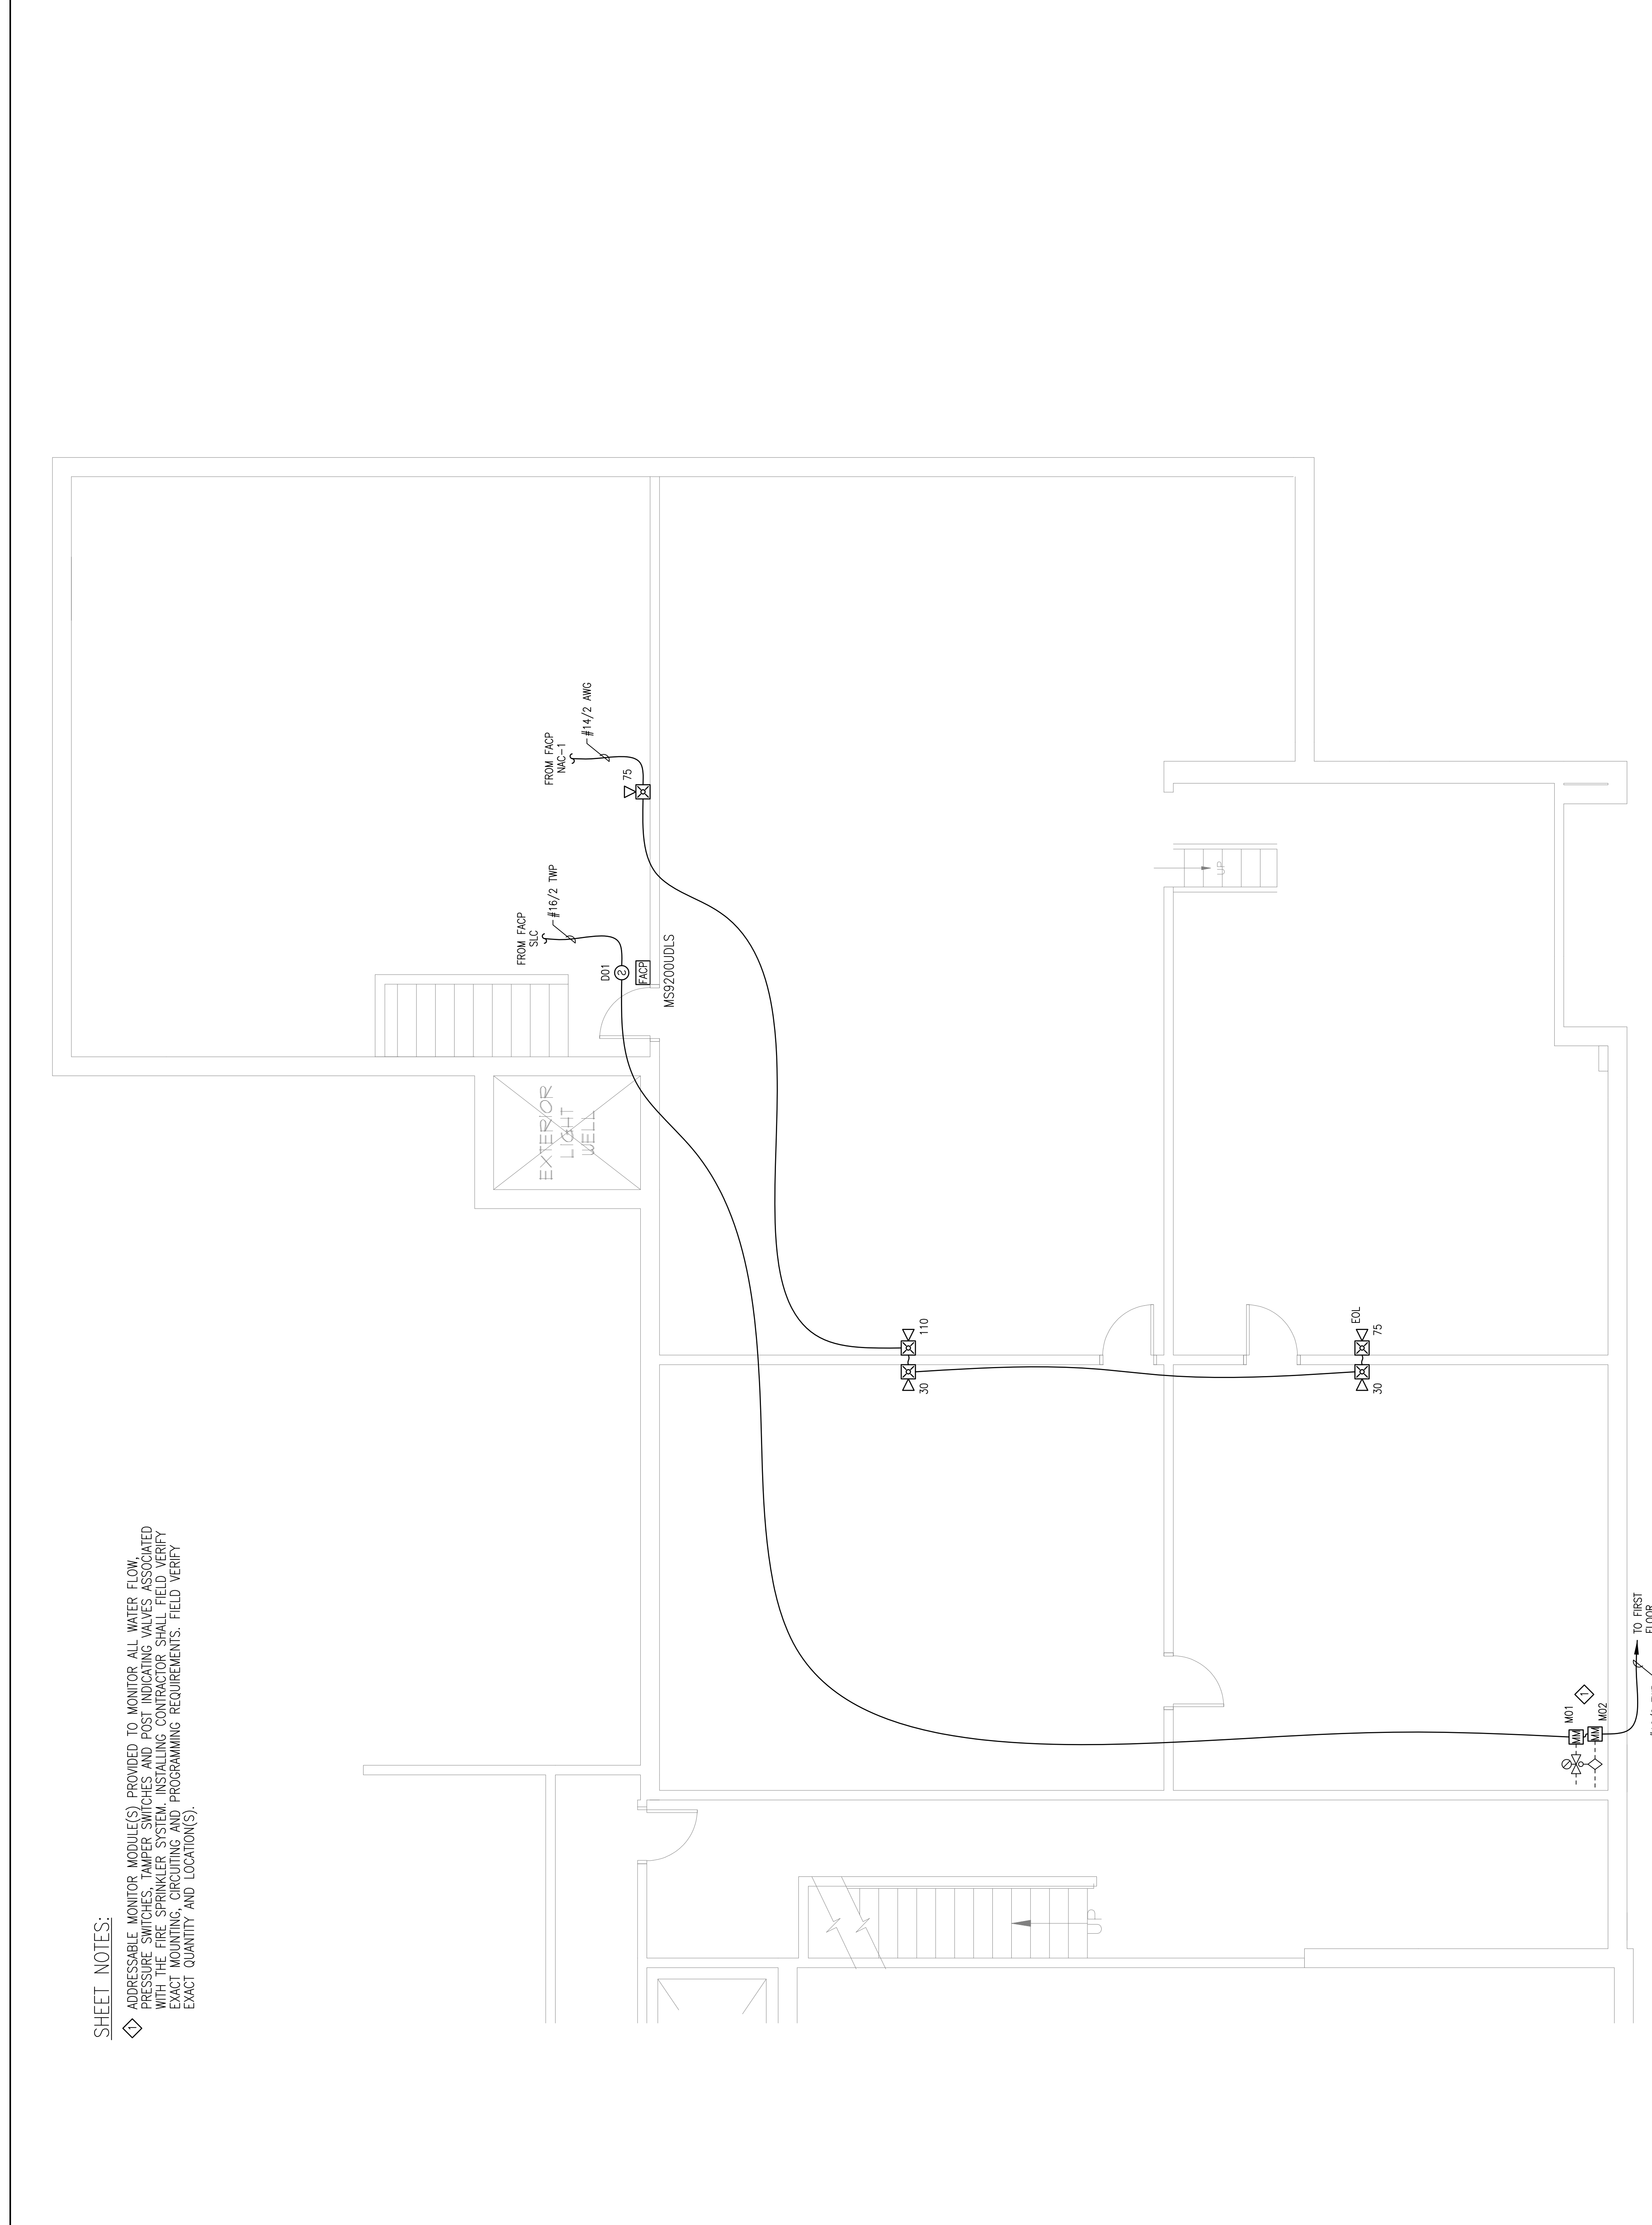

SHEET NOTES:

- ◇ ADDRESSABLE MONITOR MODULE(S) PROVIDED TO MONITOR ALL WATER FLOW PRESSURE SWITCHES, TAMPER SWITCHES AND POST INDICATING VALVES. ASSOCIATED WITH THE FIRE SPRINKLER SYSTEM. INSTALLING CONTRACTOR SHALL FIELD VERIFY EXACT MOUNTING, CIRCUITING AND PROGRAMMING REQUIREMENTS. FIELD VERIFY EXACT QUANTITY AND LOCATION(S).


CUNNINGHAM

Security Systems


10 Princes Point Road, Yarmouth, Maine 04096
Office: 207.846.3350 • Fax: 207.846.6080

EASTMAN BLOCK CONDOS
11 BROWN STREET
PORTLAND, MAINE 04101
BASEMENT FIRE ALARM PLAN

DRAWN	JPB UNICAD JOB #16319
CHECKED	WAYNE B. HAWES INSET N 90496
DATE	5/10/2016
REVISION	0
SCALE	1/4"=1'-0"

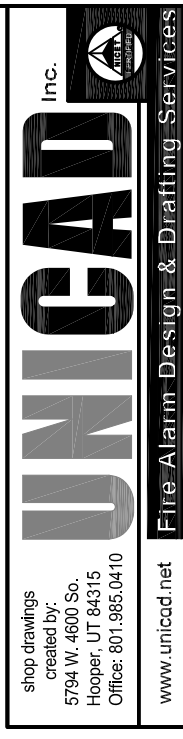

FA-2

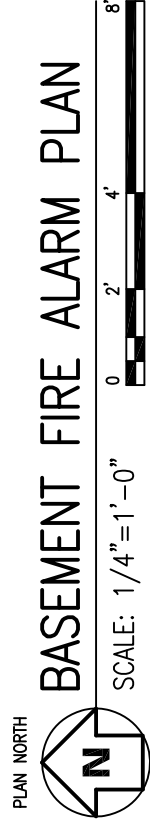

BASEMENT FIRE ALARM PLAN