


REVISION	DESCRIPTION	DATE
0	ISSUED FOR REVIEW & APPROVAL	5/10/2016

RESERVED FOR CITY STAMP

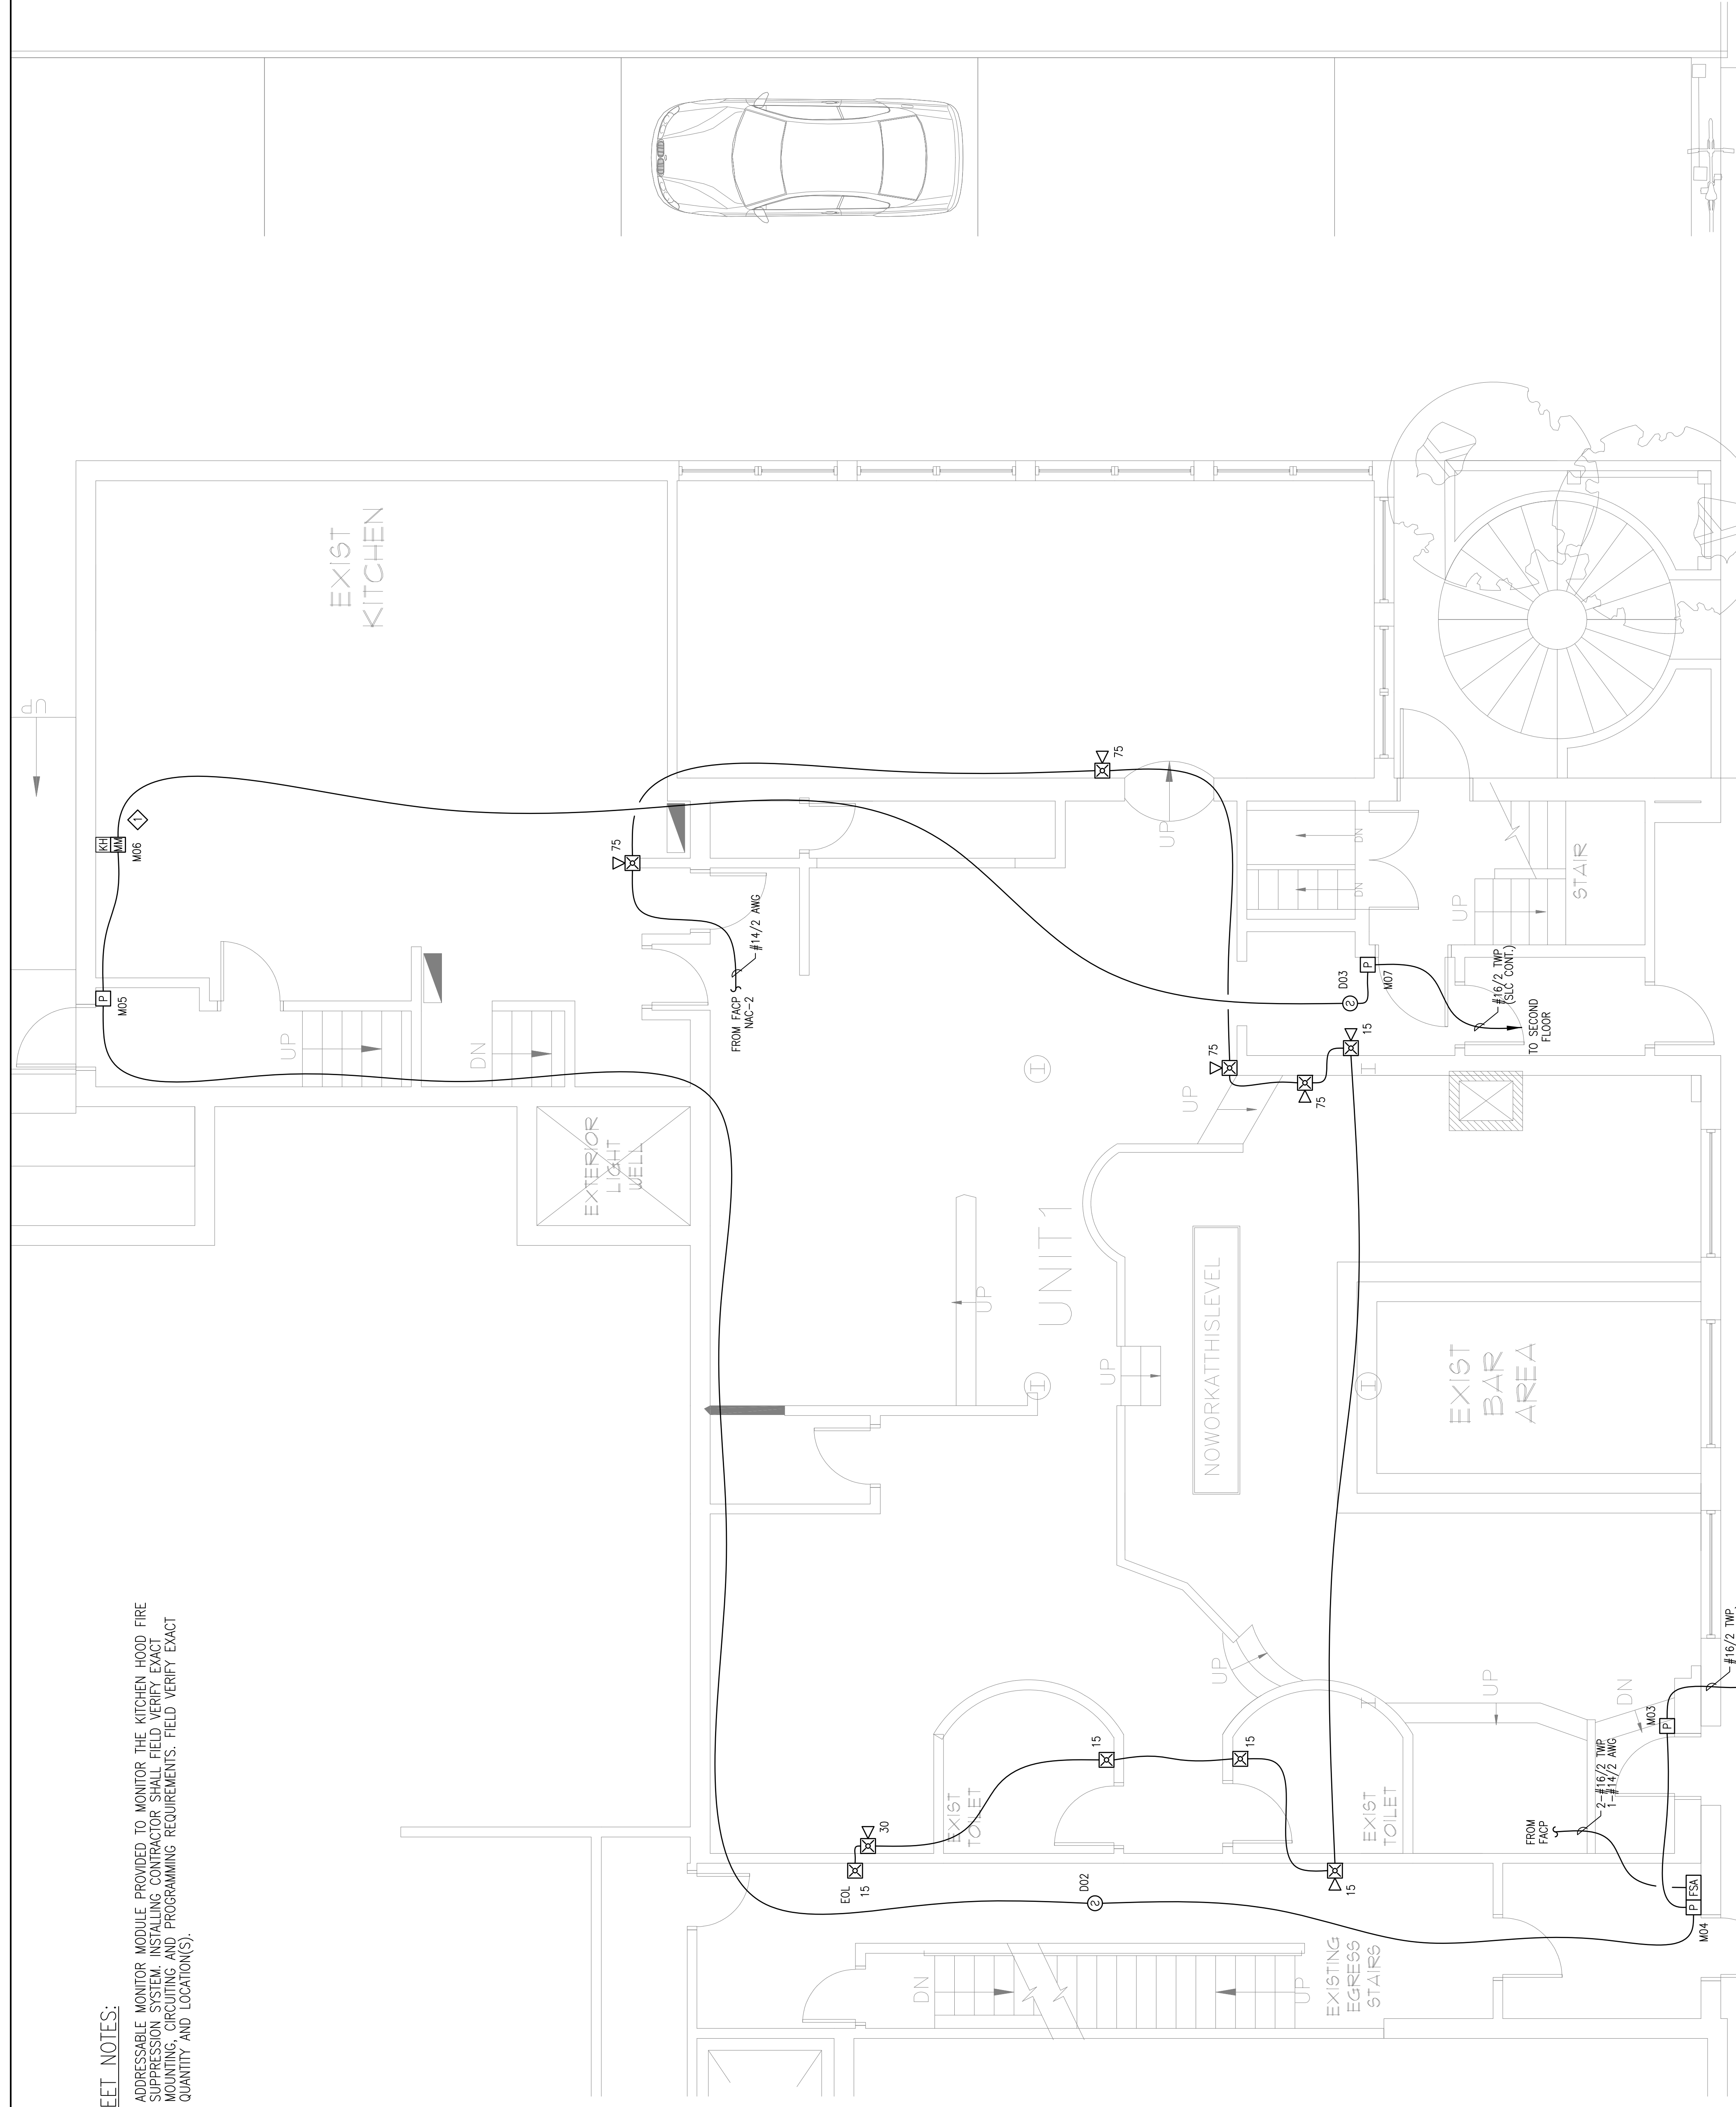

SHEET NOTES:
 ◆ ADDRESSABLE MONITOR MODULE PROVIDED TO MONITOR THE KITCHEN HOOD FIRE SUPPRESSION SYSTEM. INSTALLING CONTRACTOR SHALL FIELD VERIFY EXACT MOUNTING, CIRCUITING AND PROGRAMMING REQUIREMENTS. FIELD VERIFY EXACT QUANTITY AND LOCATION(S).

CUNNINGHAM
 Security Systems
 10 Princes Point Road, Yarmouth, Maine 04096
 Office: 207.846.3350 • Fax: 207.846.6080

EASTMAN BLOCK CONDOS
11 BROWN STREET
PORTLAND, MAINE 04101
FIRST FLOOR FIRE ALARM PLAN

DRAWN	JPB UNICAD JOB #16319
CHECKED	WAYNE B. HAWES NCET # 90496
DATE	5/10/2016
REVISION	0
SCALE	1/4"=1'-0"

UNICAD Inc.
 Fire Alarm Design & Drafting Services
 578 W. 400 St.
 Portland, ME 04102
 Office: 603.865.6410
 www.unicad.net

PLAN NORTH
FIRST FLOOR FIRE ALARM PLAN
 SCALE: 1/4"=1'-0"

FA-3