

REVISION	DESCRIPTION	DATE
0	ISSUED FOR REVIEW & APPROVAL	5/10/2016


RESERVED FOR CITY STAMP

**CUNNINGHAM**  
 Security Systems  
 10 Princes Point Road, Yarmouth, Maine 04096  
 Office: 207.846.3350 • Fax: 207.846.6080

**EASTMAN BLOCK CONDOS**  
**11 BROWN STREET**  
**PORTLAND, MAINE 04101**  
**SECOND FLOOR FIRE ALARM PLAN**

DRAWN	JPB UNICAD JOB #16319
CHECKED	WAYNE B. HAWES NCET # 90496
DATE	5/10/2016
REVISION	0
SCALE	1/4"=1'-0"

**FA-4**

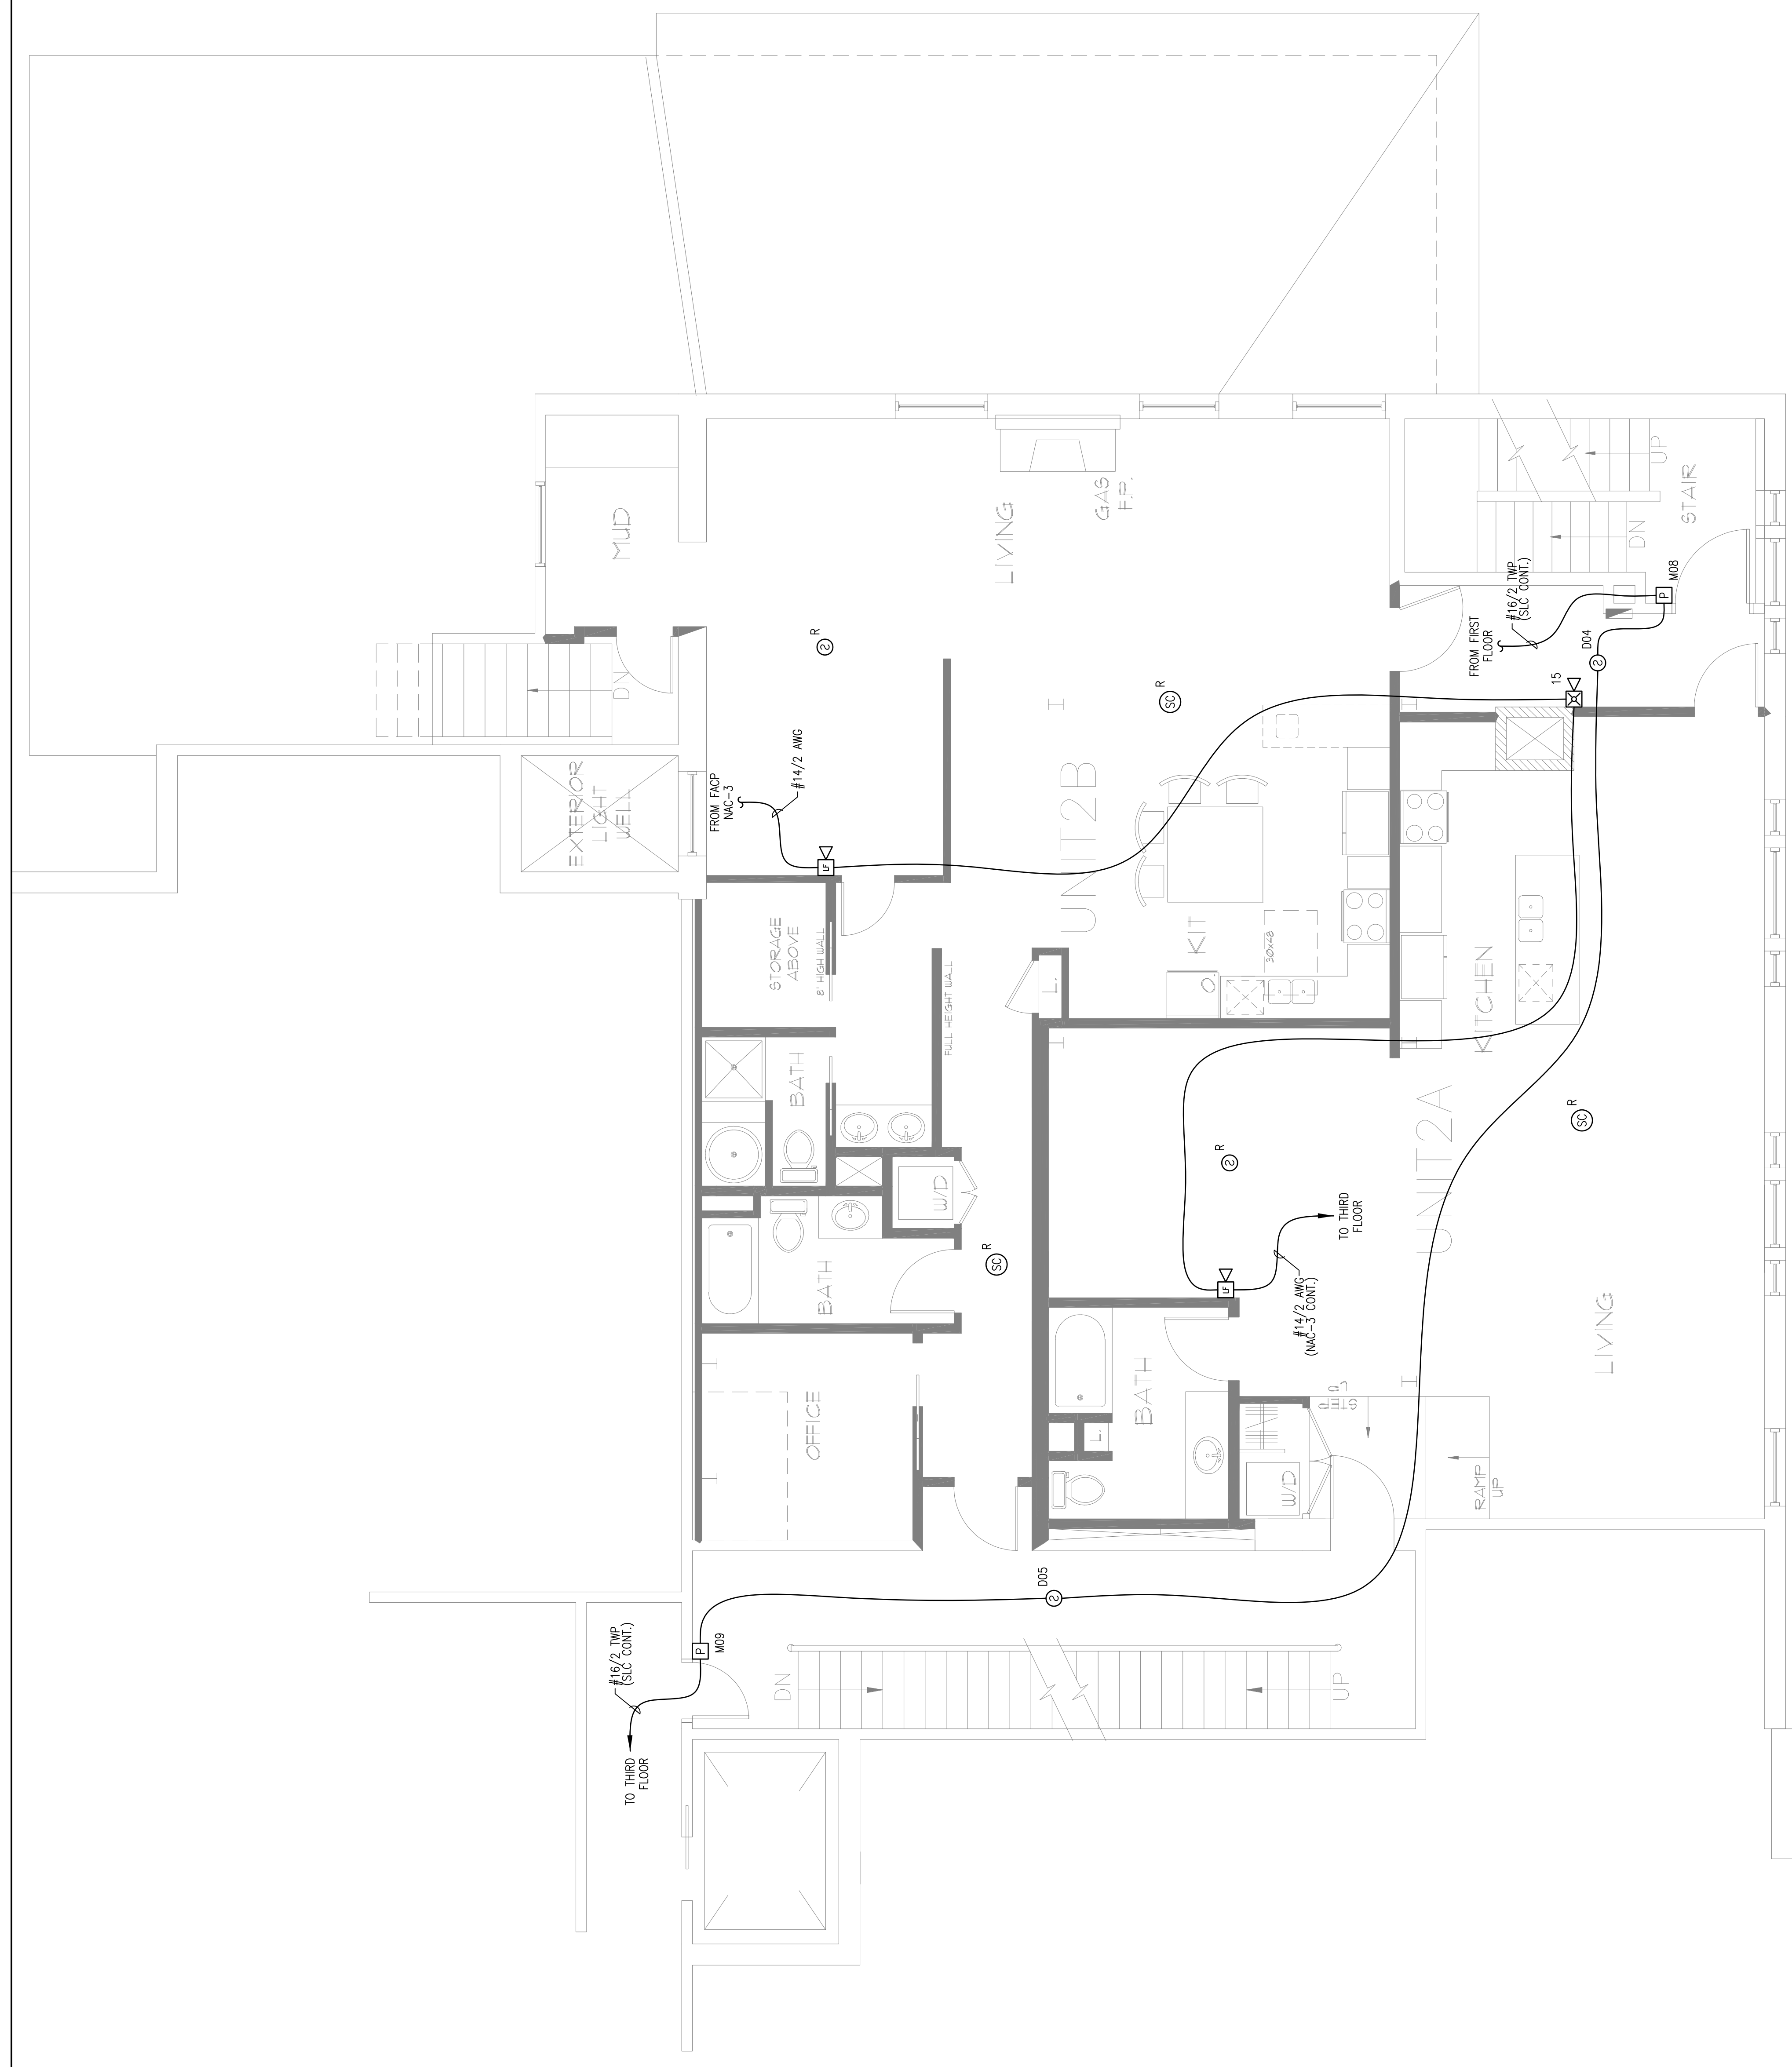

PLAN NORTH  
**SECOND FLOOR FIRE ALARM PLAN**  
 SCALE: 1/4"=1'-0"



**UNICAD** Inc.  
 578 W. 40th St.  
 Portland, ME 04102  
 Office: 603.865.6410  
 www.unicad.net  
 Fire Alarm Design & Drafting Services