

REVISION	0	ISSUED FOR REVIEW & APPROVAL	5/10/2016
DESCRIPTION			
DATE			

RESERVED FOR CITY STAMP


**CUNNINGHAM**  
Security Systems  
10 Princes Point Road, Yarmouth, Maine 04096  
Office: 207.846.3350 • Fax: 207.846.6080

**EASTMAN BLOCK CONDOS**  
**11 BROWN STREET**  
**PORTLAND, MAINE 04101**  
**THIRD FLOOR FIRE ALARM PLAN**

DRAWN	JPB	UNICAD JOB #16319
CHECKED	WAYNE B. HAWES	NCET # 90496
DATE	5/10/2016	
REVISION	0	
SCALE	1/4"=1'-0"	

**FA-5**

**UNICAD** Inc.  
www.unicad.net  
579A W. 400th St.  
Portland, ME 04106  
Office: 603.865.6410

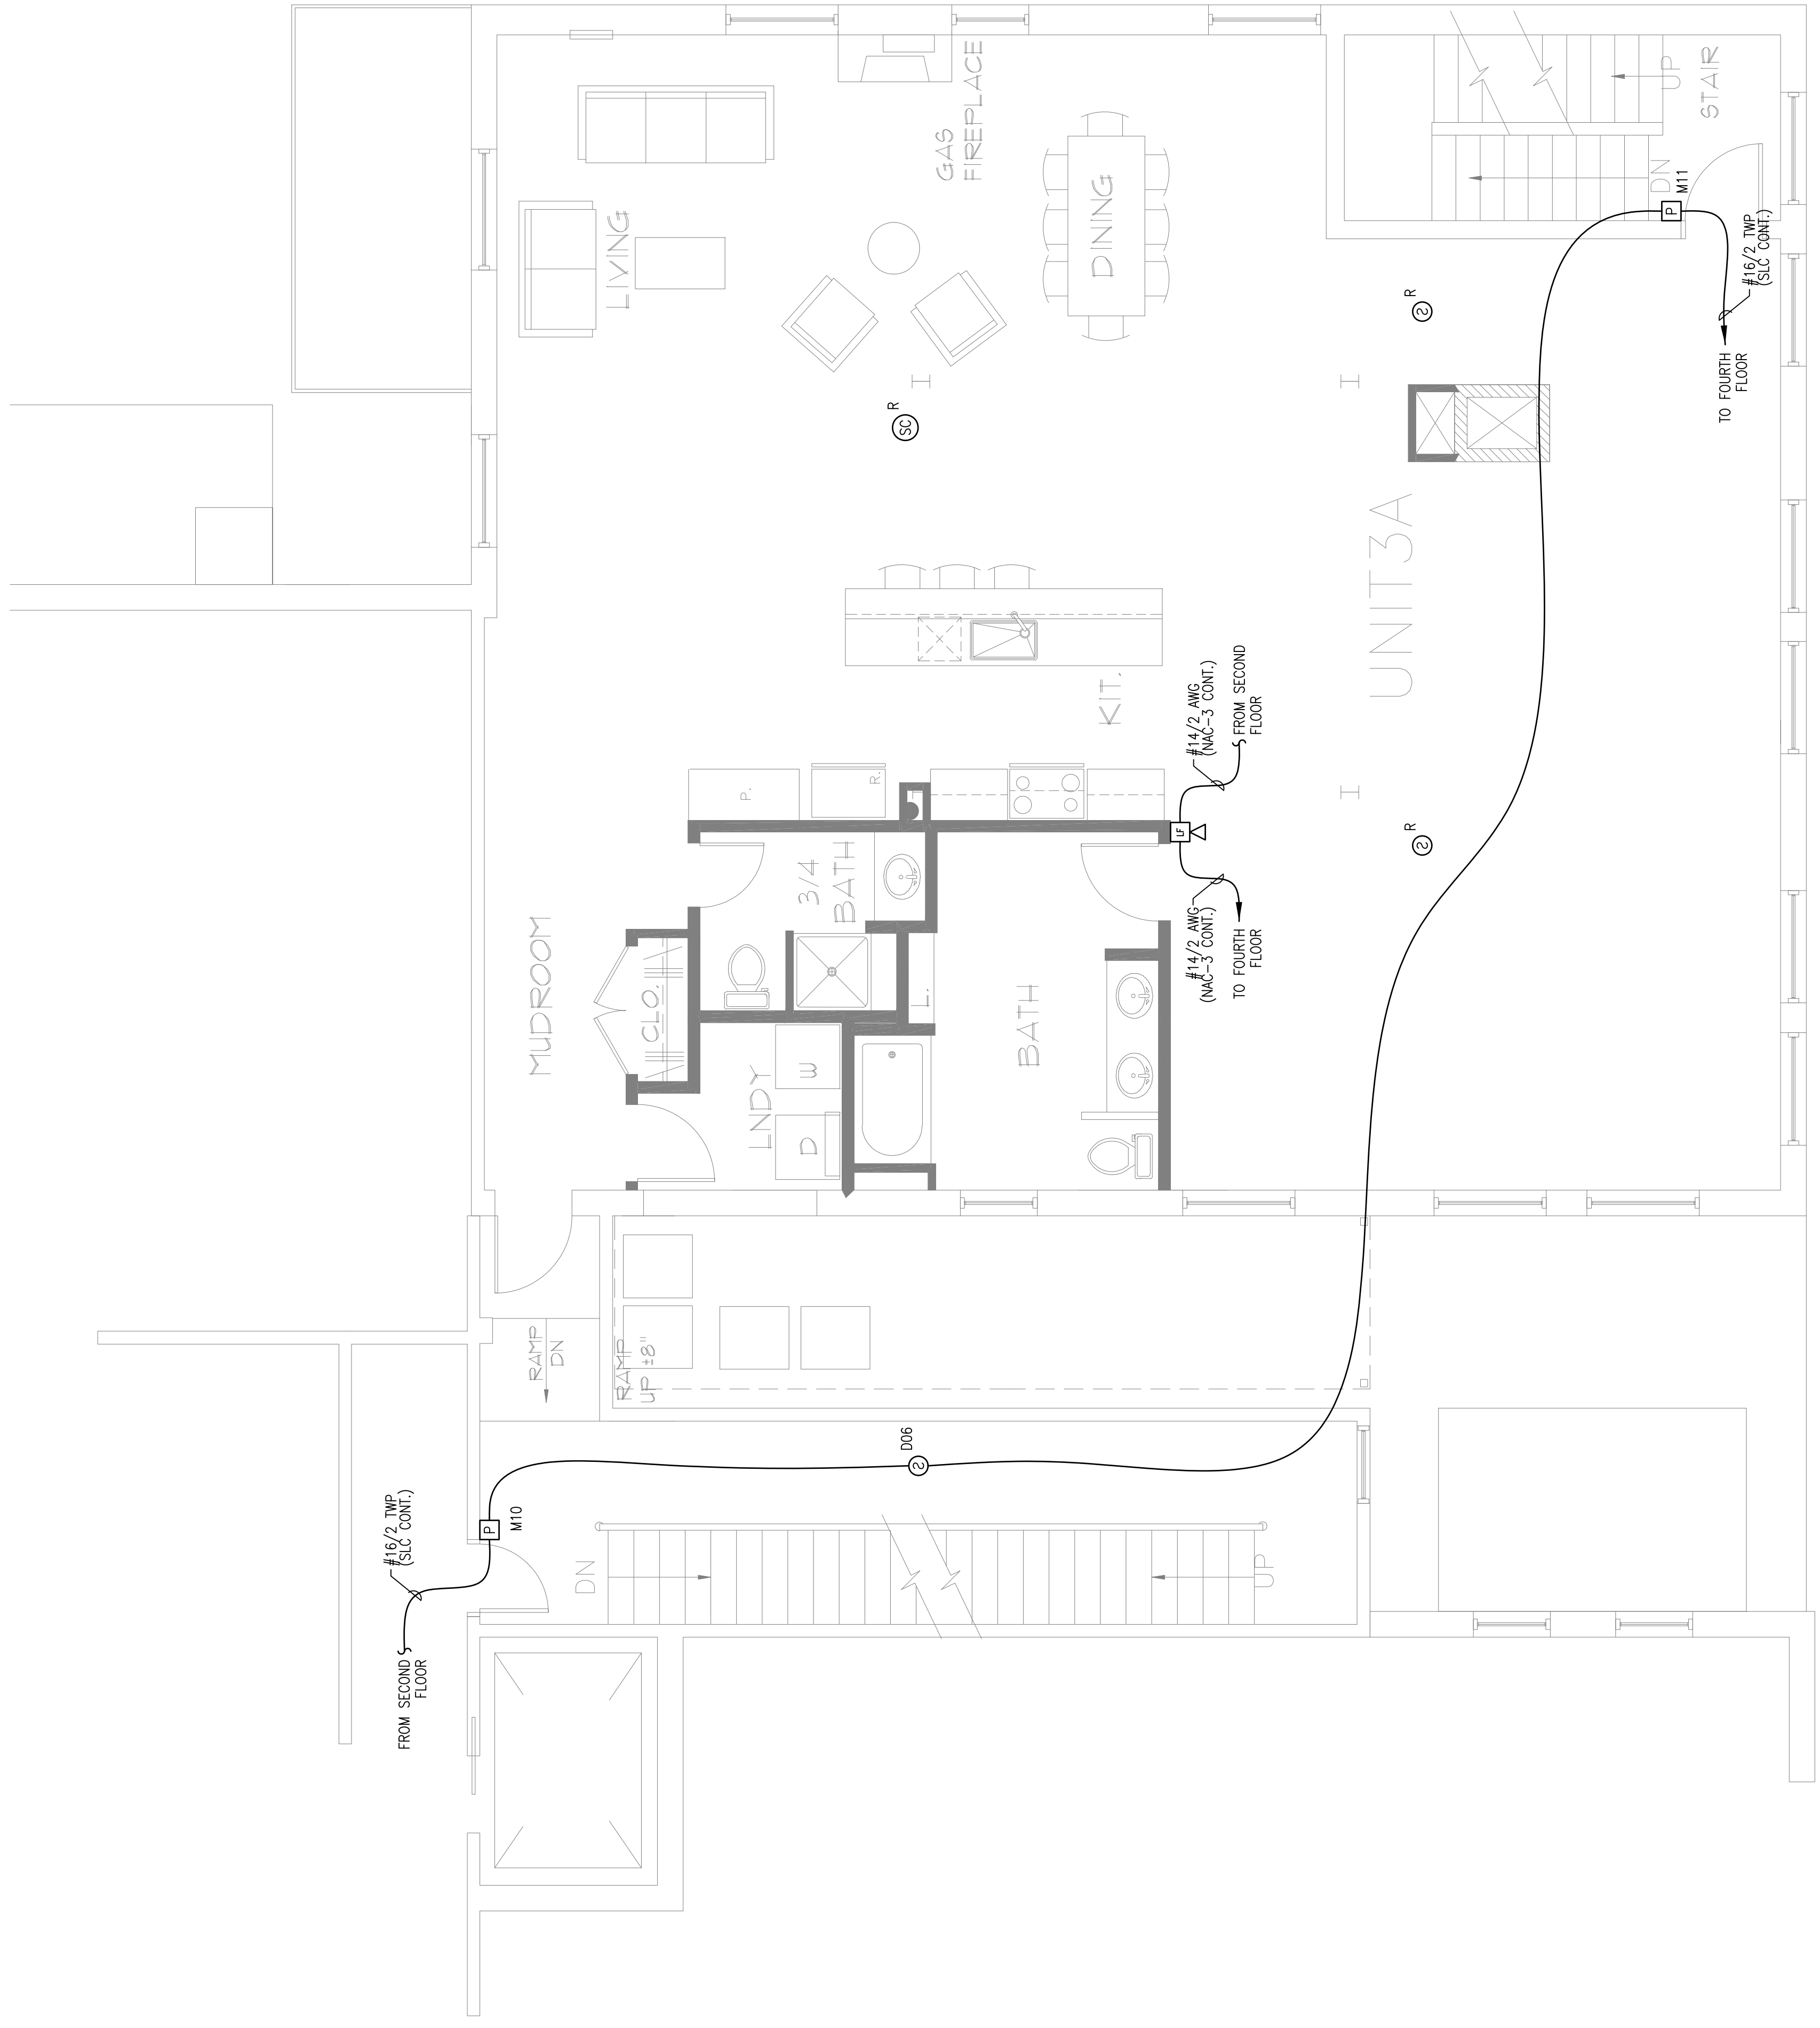

PLAN WITH  
**THIRD FLOOR FIRE ALARM PLAN**  
SCALE: 1/4"=1'-0"

