

REVISION	DESCRIPTION	DATE
0	ISSUED FOR REVIEW & APPROVAL	5/10/2016


RESERVED FOR CITY STAMP

CUNNINGHAM
Security Systems
10 Princes Point Road, Yarmouth, Maine 04096
Office: 207.846.3350 • Fax: 207.846.6080

**EASTMAN BLOCK CONDOS
11 BROWN STREET
PORTLAND, MAINE 04101
FOURTH FLOOR FIRE ALARM PLAN**

DRAWN	JPB UNICAD JOB #16319
CHECKED	WAYNE B. HAWES NCET # 90496
DATE	5/10/2016
REVISION	0
SCALE	1/4"=1'-0"

FA-6

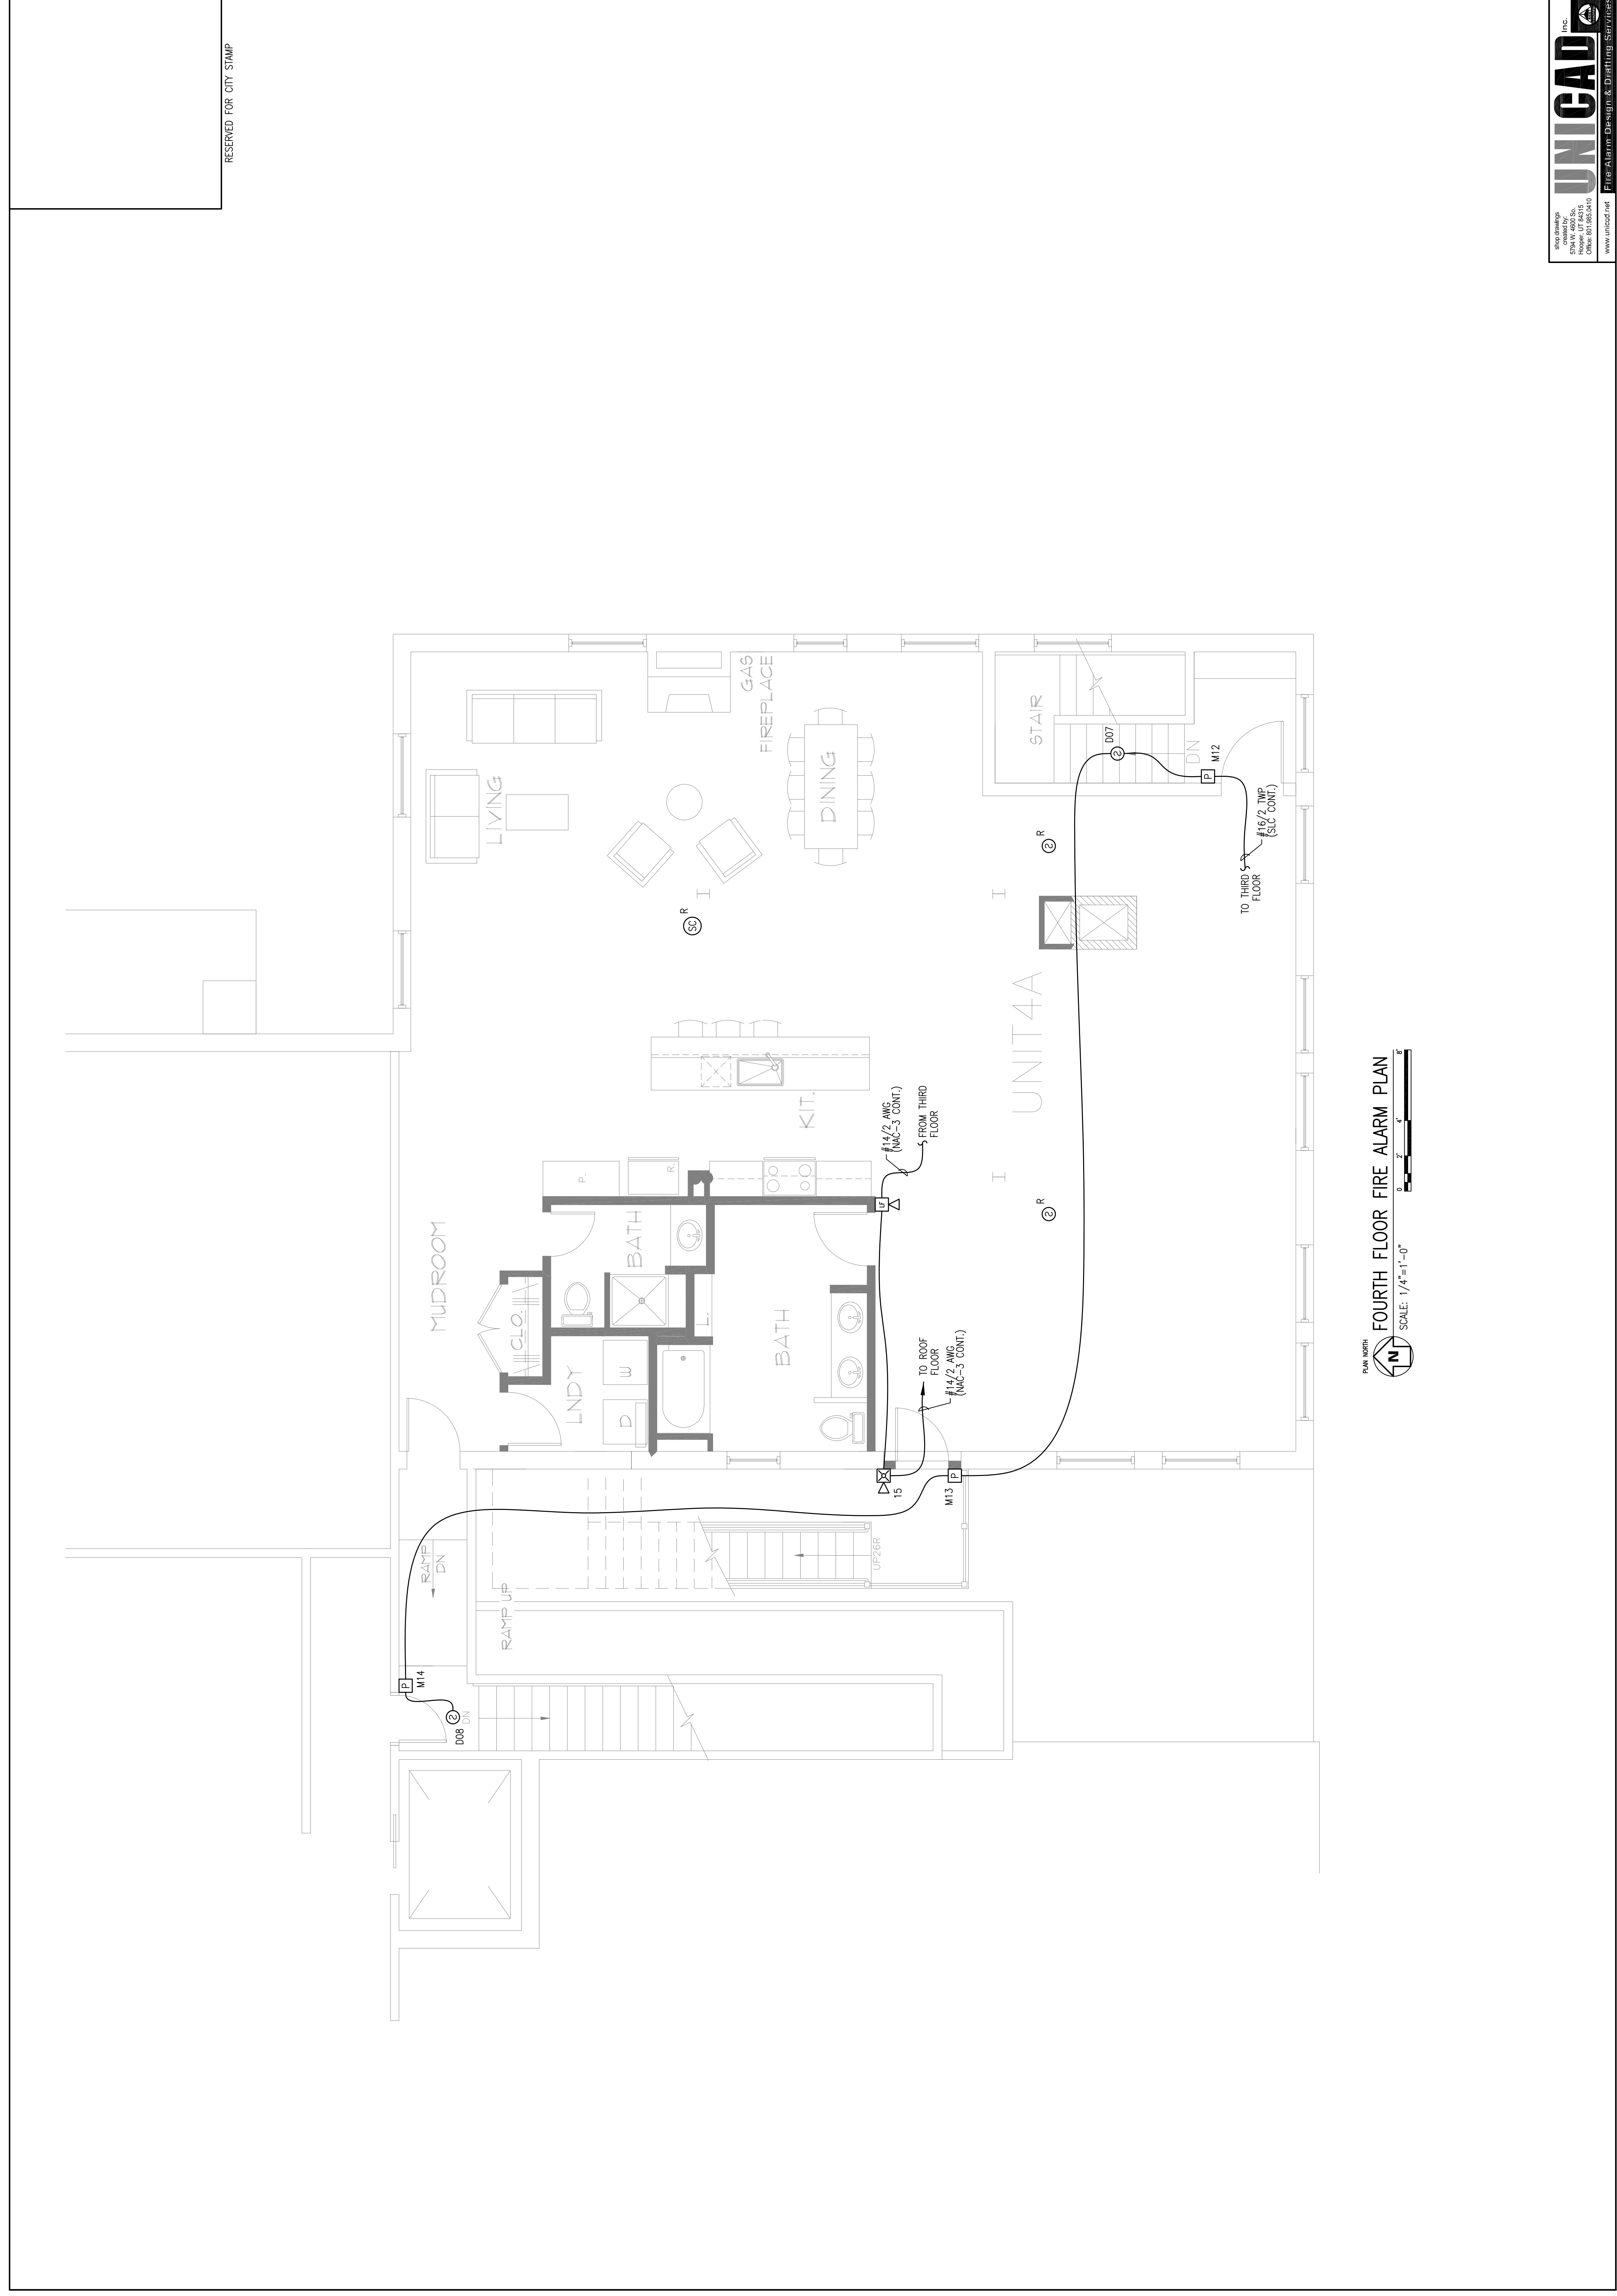

UNICAD Inc.
www.unicad.net
579A W. 40th St.
Portland, ME 04101
Office: 601.865.6410