


REVISION	DESCRIPTION	DATE
0	ISSUED FOR REVIEW & APPROVAL	5/10/2016

RESERVED FOR CITY STAMP

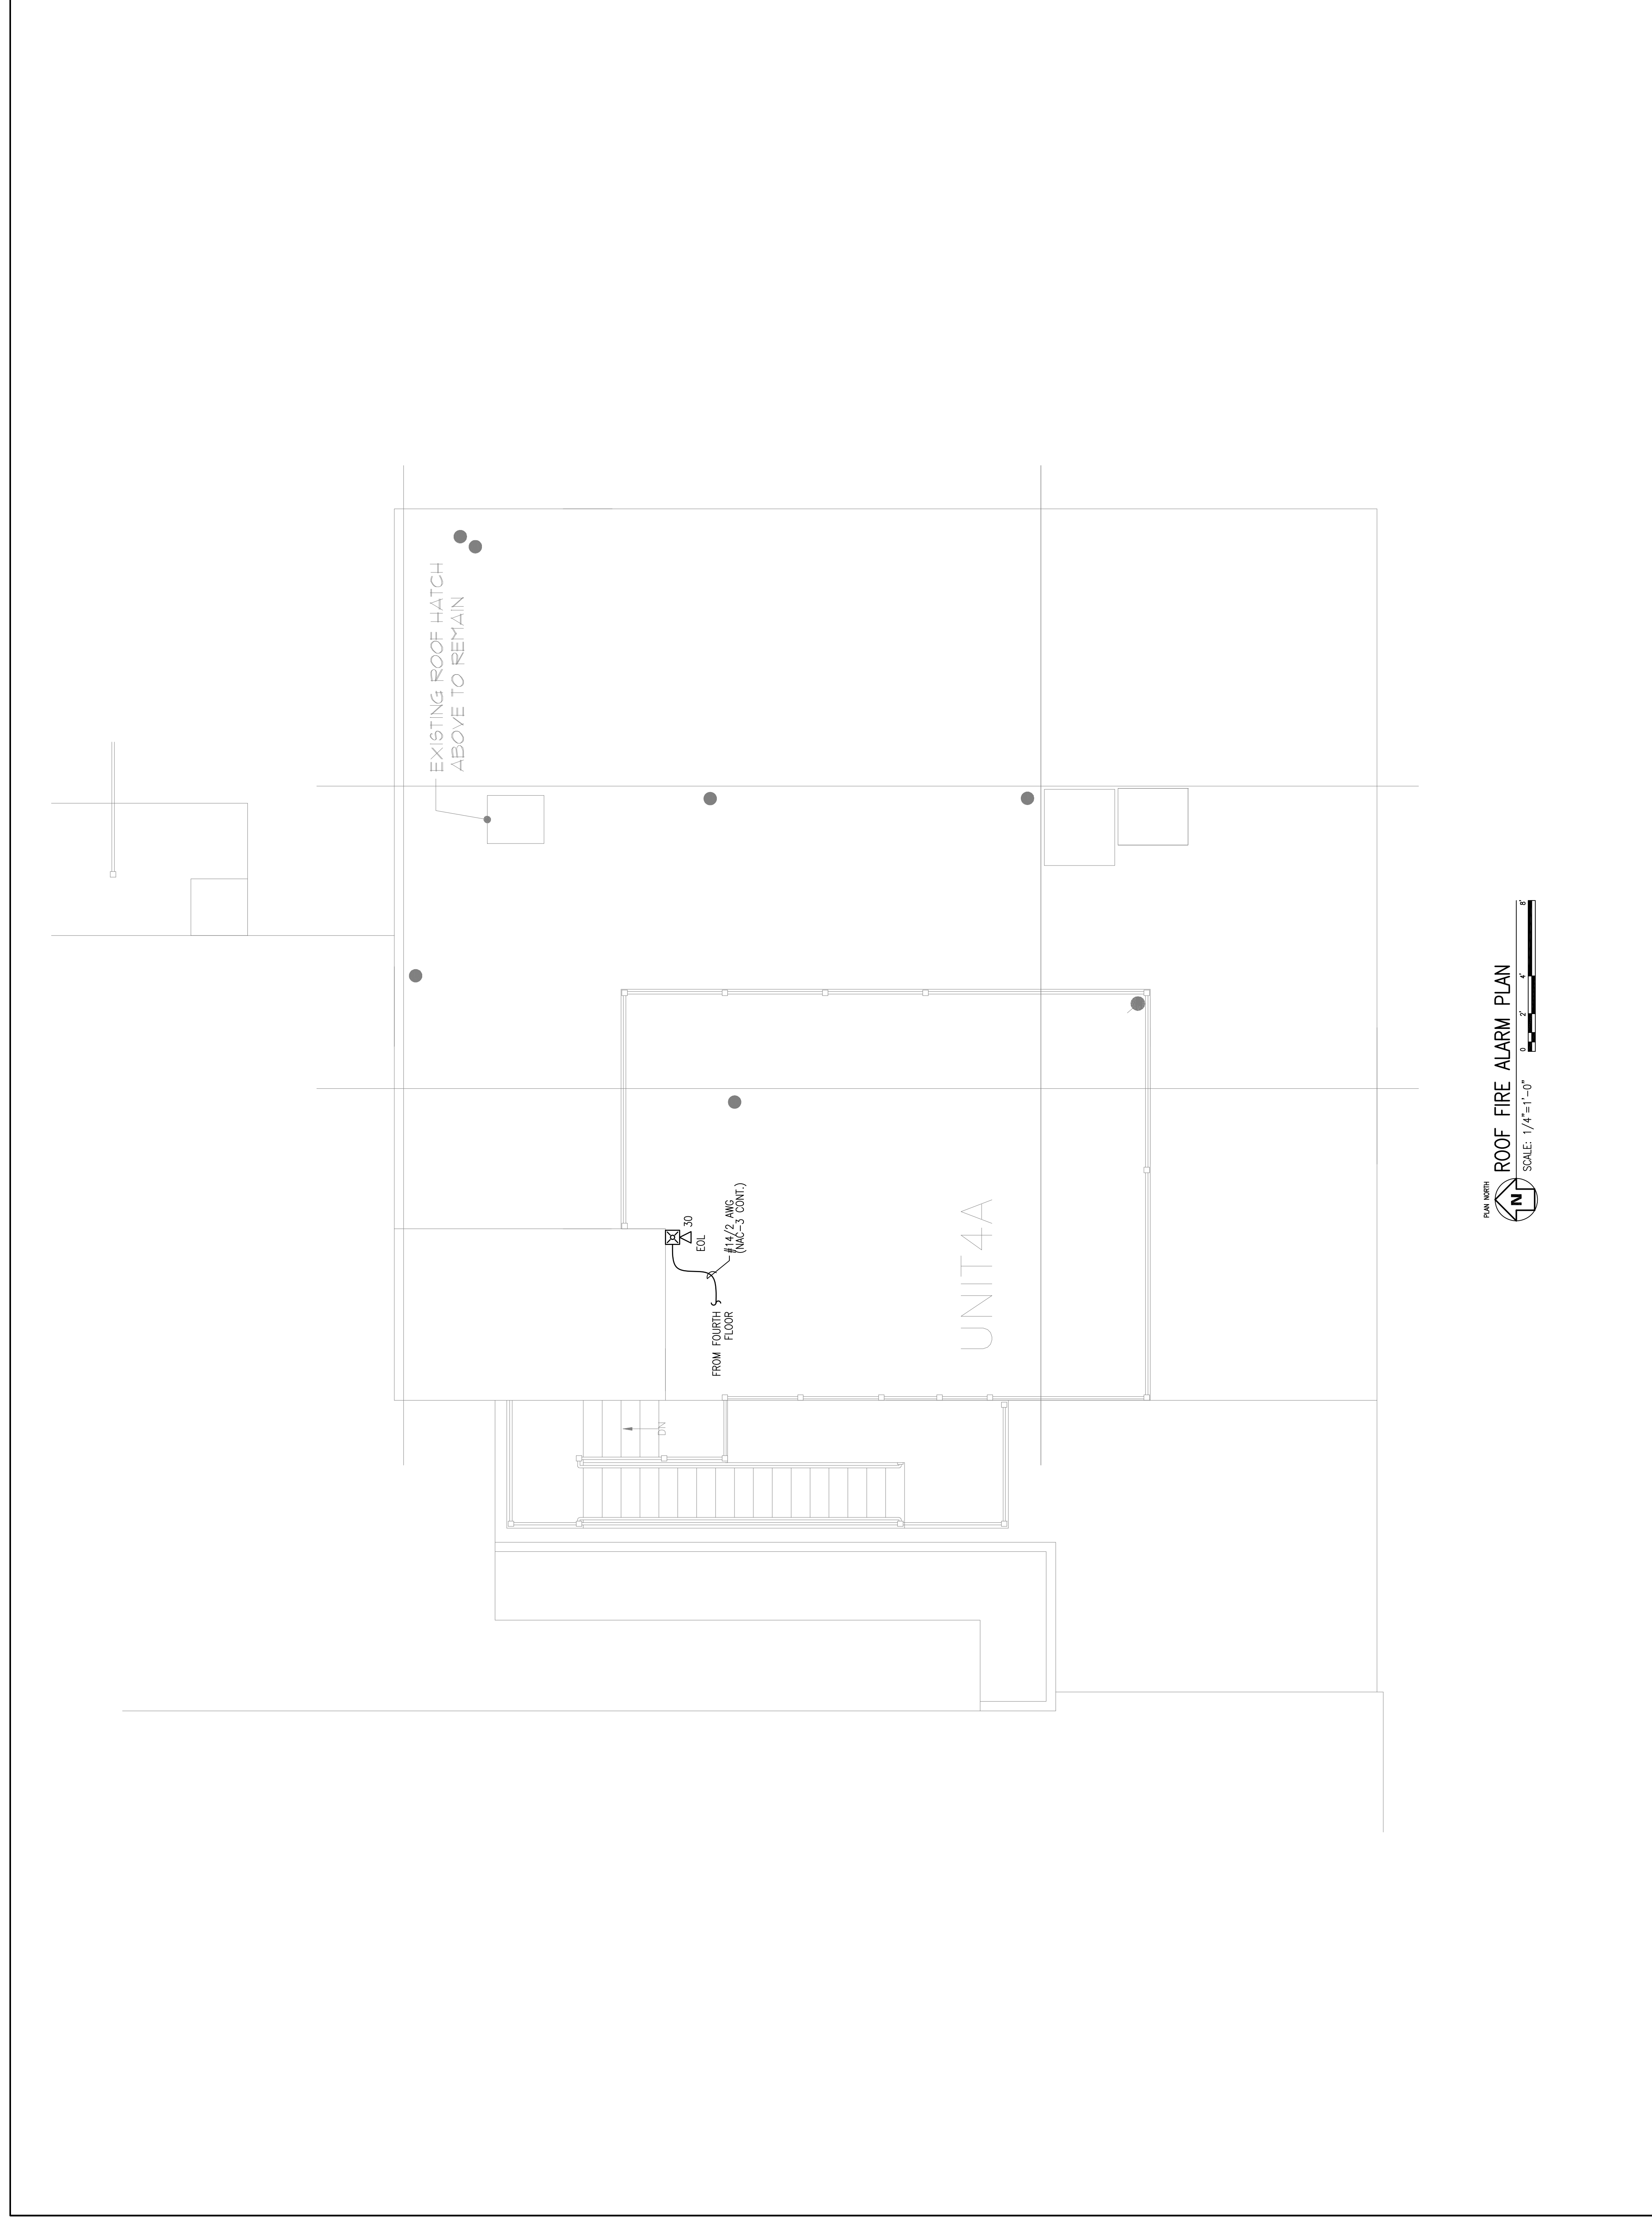

CUNNINGHAM
Security Systems

10 Princes Point Road, Yarmouth, Maine 04096
Office: 207.846.3350 • Fax: 207.846.6080

EASTMAN BLOCK CONDOS
11 BROWN STREET
PORTLAND, MAINE 04101
ROOF FIRE ALARM PLAN

DRAWN	JPB UNICAD JOB #16319
CHECKED	WAYNE B. HAWES NGEET # 90496
DATE	5/10/2016
REVISION	0
SCALE	1/4"=1'-0"

FA-7

UNICAD Inc.
Fire Alarm Design & Drafting Services
www.unicad.net
579A W. 40th St.
Portland, ME 04102
Office: 603.865.6410