


1 2 3 4 5 6 7

A
B
C
D
E

 
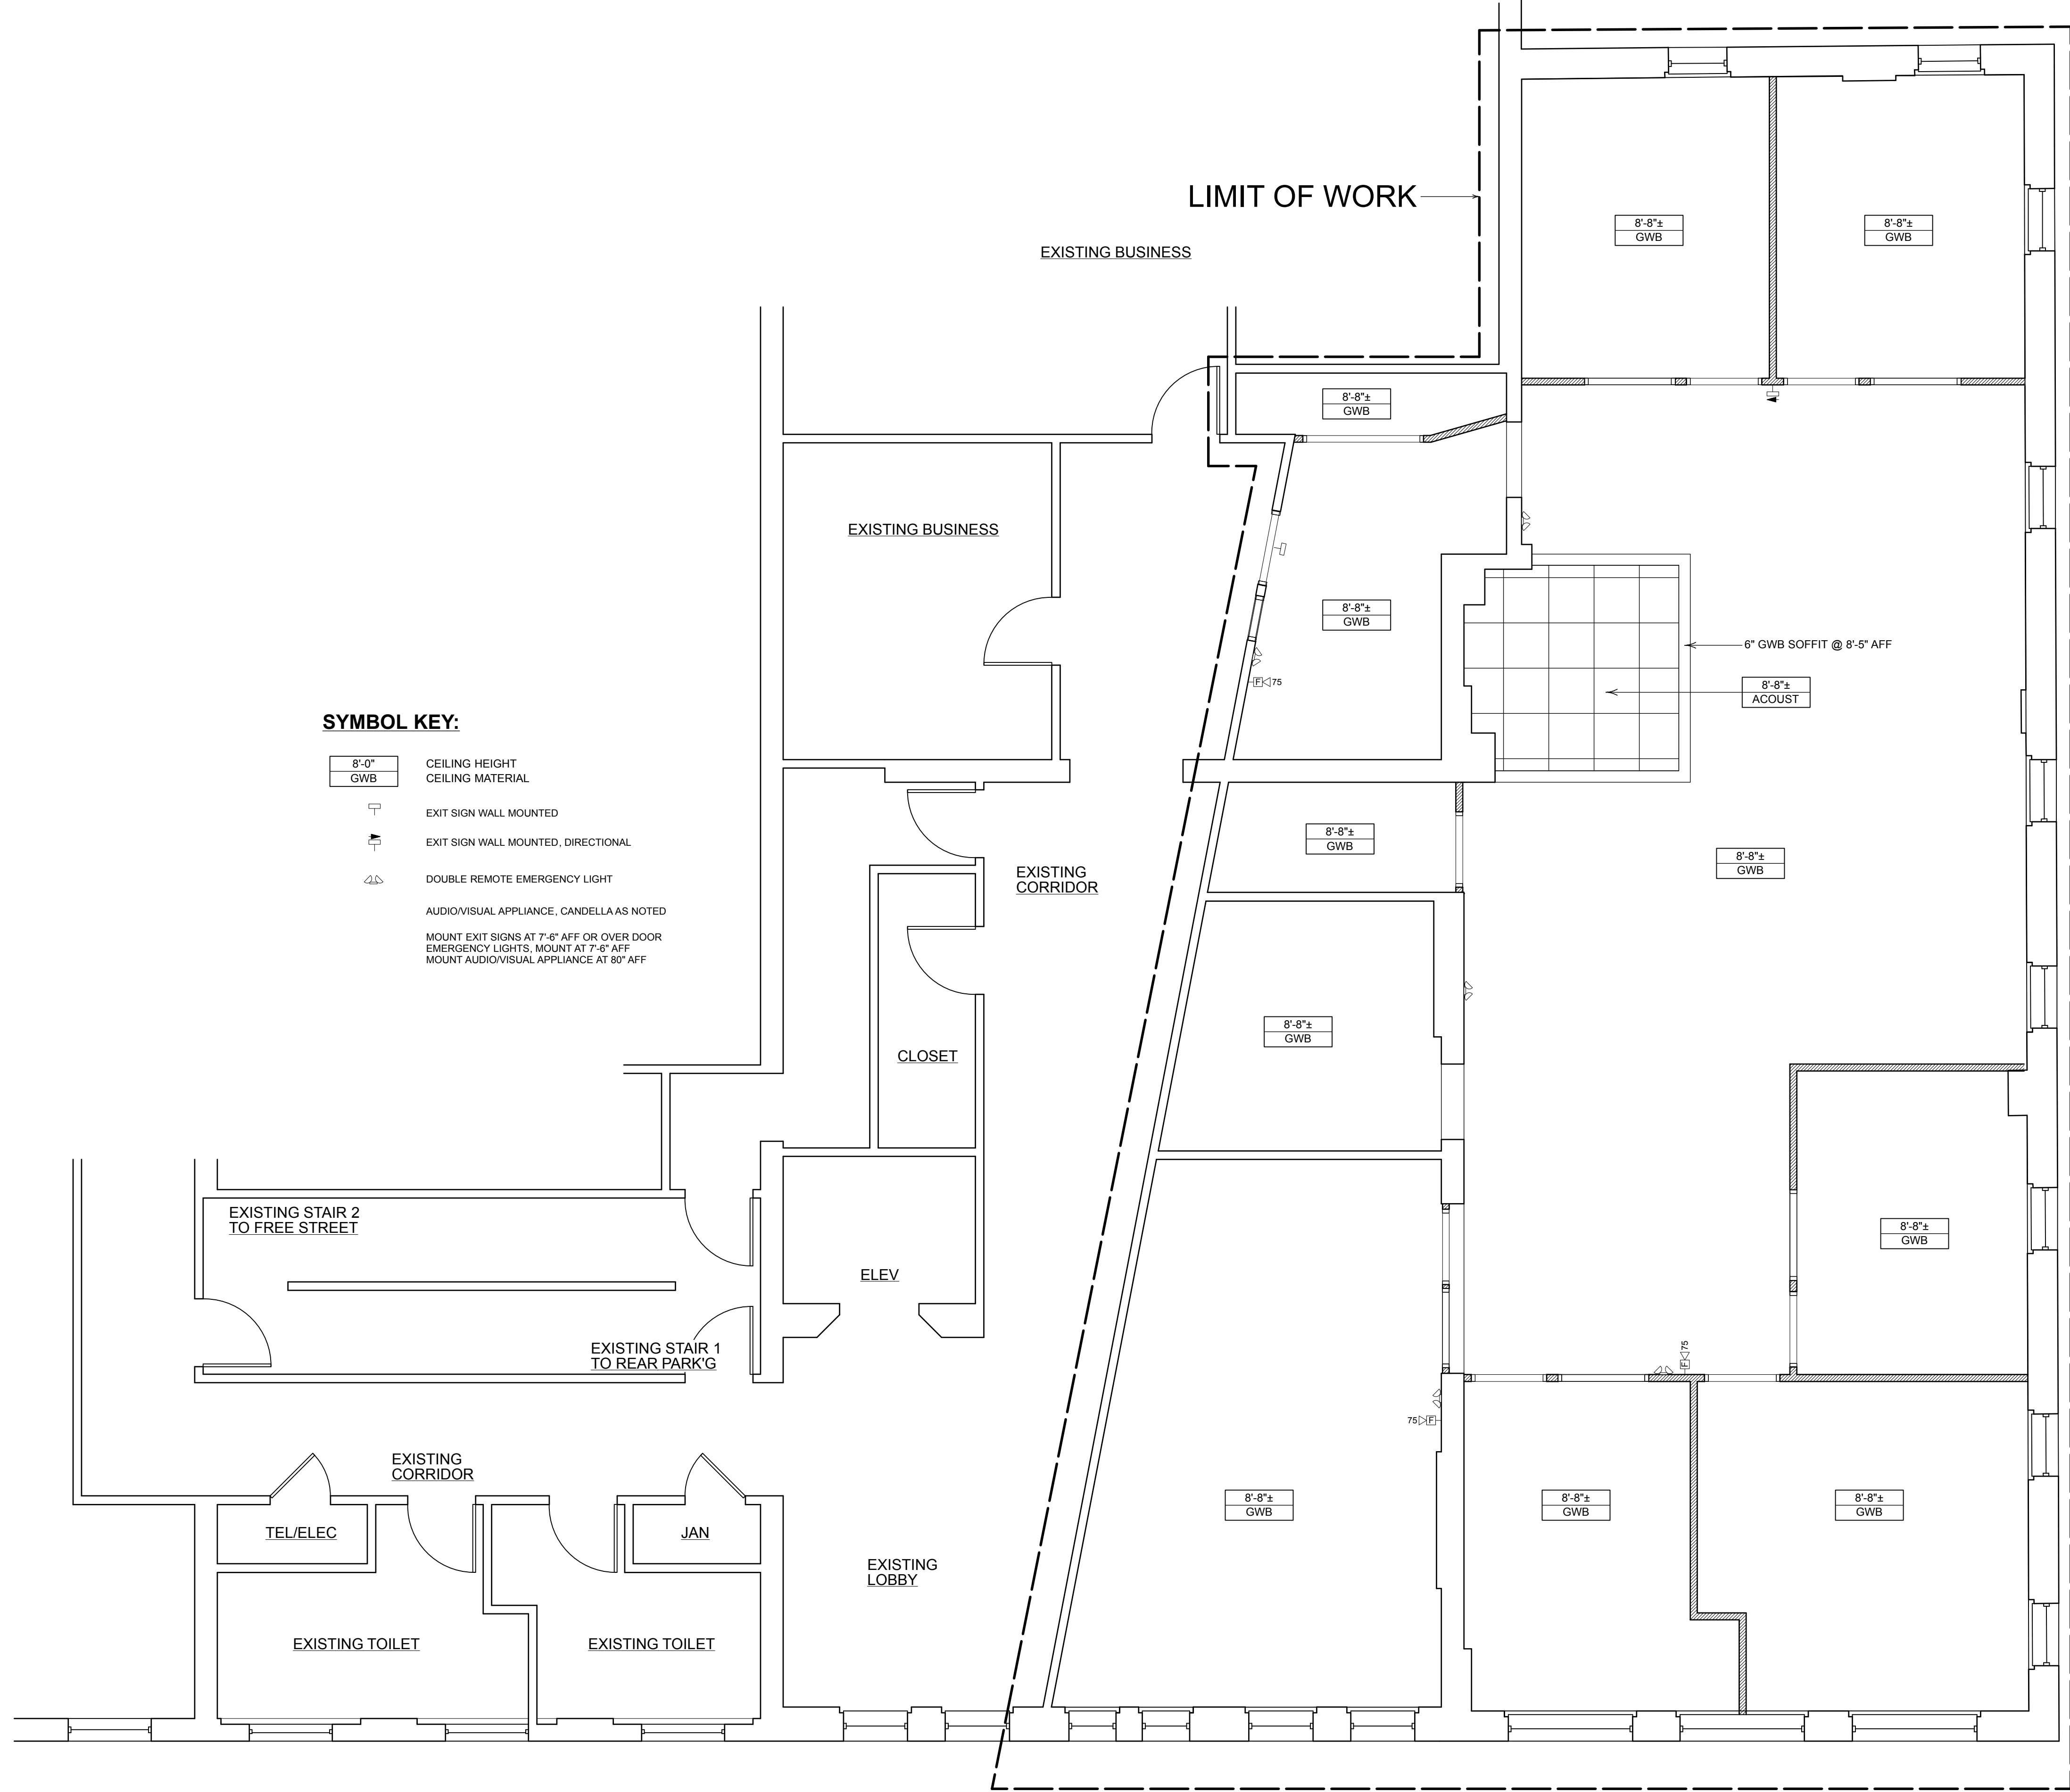


SYMBOL KEY:

- 8'-0"
GWB CEILING HEIGHT
CEILING MATERIAL
- EXIT SIGN WALL MOUNTED
- EXIT SIGN WALL MOUNTED, DIRECTIONAL
- DOUBLE REMOTE EMERGENCY LIGHT
- AUDIOVISUAL APPLIANCE, CANELLA AS NOTED
- MOUNT EXIT SIGNS AT 7'-6" AFF OR OVER DOOR
- EMERGENCY LIGHTS, MOUNT AT 7'-6" AFF
- MOUNT AUDIOVISUAL APPLIANCE AT 8' AFF

Appr									
Zone									
Revision Notes									
Date									
No.									
For Construction Permit Issue Notes									
Date	8/25/15								
No.	1								
Designed By	8/25/15								
Drawn By									
Checked By									
Reviewed By									
Submitted By									
Project Manager									
Design Firm	HKTA/architects 30 Danforth Street Portland, Maine 04101								
Project Name	22 Free St Renovations J.B. Brown & Sons Portland, Maine								
Drawing Title	REFLECTED CLG PLAN EMERGENCY LIGHT & FIRE ALARM PLAN								
Scale	Sheet Scale								
Sheet No.	A-102								
Total Sheets	8 Total Sheets								

1 REFLECTED CEILING PLAN, EMERGENCY LIGHT & FIRE ALARM PLAN
 Scale: 1/4" = 1'-0"

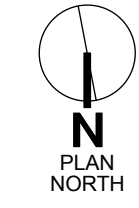

HKTA / architects
 30 Danforth Street Suite 209
 Portland, Maine 04101
 phone: 207. 774. 6016
 fax: 207. 774. 9128
 email: hkta@maine.rr.com

1 2 3 4 5 6 7