



EL RAYO - FREE STREET
 PORTLAND, MAINE
 RENOVATION


BRIBURN
 architecture for life
25 State St. Portland, ME 04101-2800

CONSULTANTS:

REVISIONS:


ISSUED: 01/15/16
 PROJECT No: 1523
 DRAWN BY: RIF
 CHECKED BY: RIF
 SHEET TITLE:
 ENLARGED BATHROOM PLAN
 & DETAILS

A401

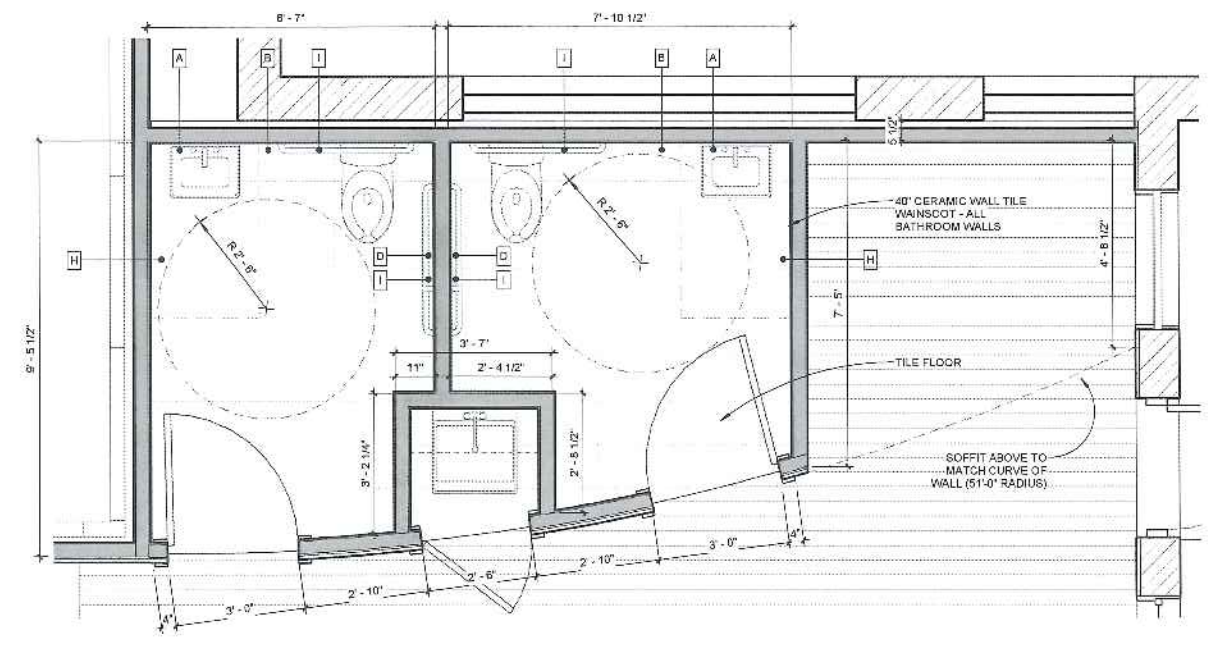


- BATHROOM ACCESSORY LEGEND**
- A MIRROR
 - B SOAP DISPENSER
 - C PAPER TOWEL DISPENSER
 - D TOILET PAPER DISPENSER
 - E TOILET PAPER HOLDER
 - F SANITARY NAPKIN DISPOSAL
 - G SANITARY NAPKIN DISPENSER
 - H HAND DRYER
 - I GRAB BARS

1 ENLARGED BATHROOM PLAN
 1/2" = 1'-0"

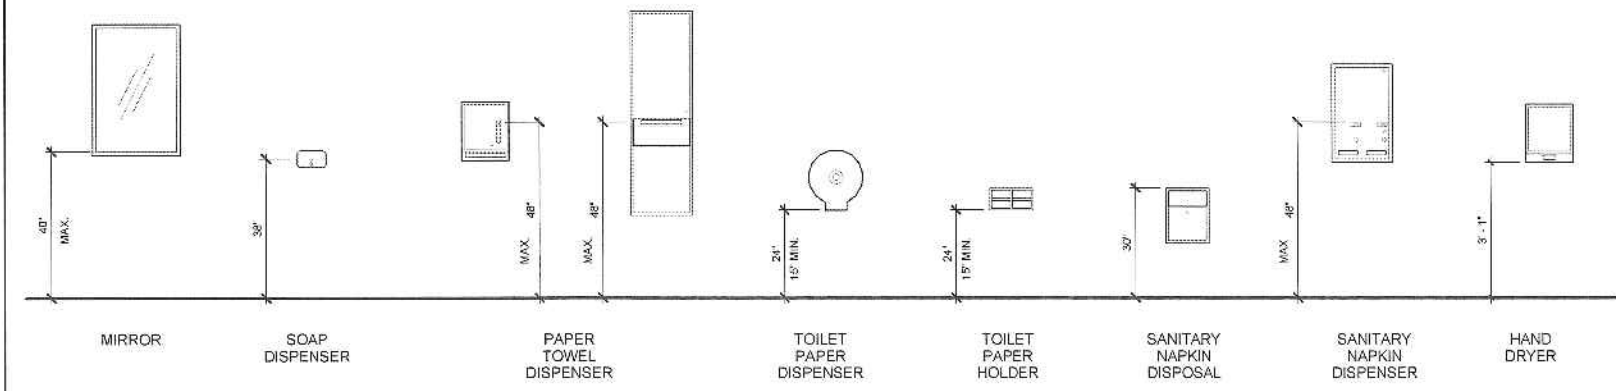

TYPICAL TOILET ACCESSORIES MOUNTING HEIGHTS

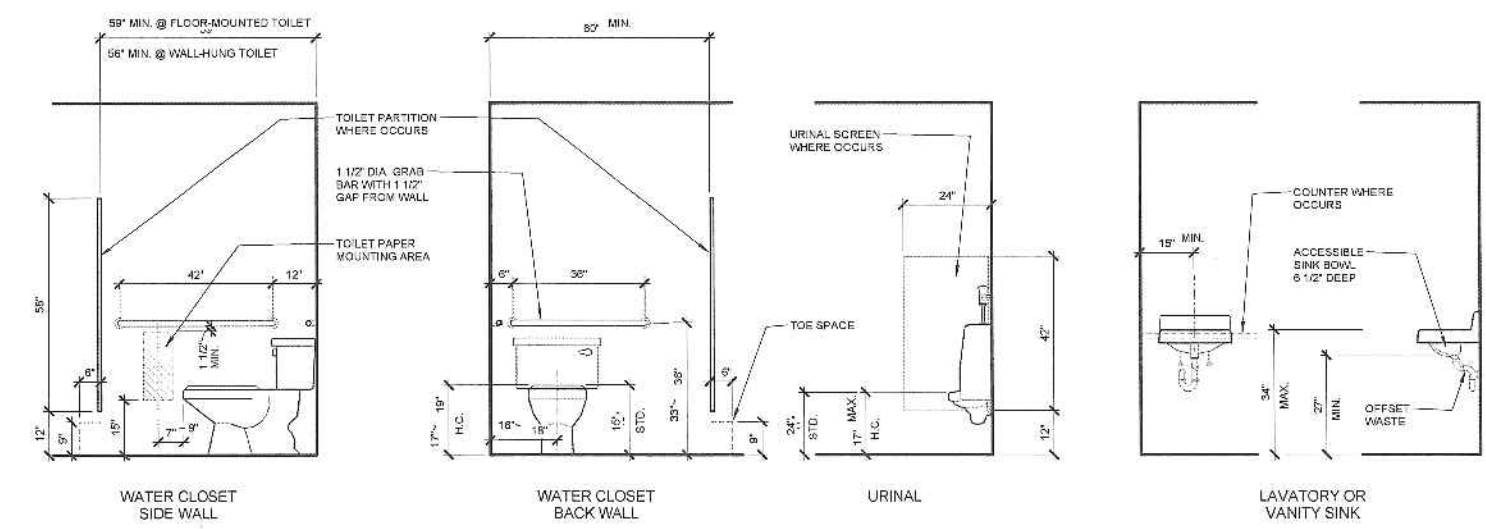

TYPICAL PLUMBING FIXTURES AND ACCESSORIES MOUNTING HEIGHTS