



**EL RAYO - FREE STREET**  
 PORTLAND, MAINE  
 RENOVATION



**BRIBURN**  
 architecture for life  
 3 Maple St. Suite 202 Portland, ME 04101 (207) 775-8492

CONSULTANTS:



REVISIONS:

ISSUED: 01/15/16  
 PROJECT No: 1523  
 DRAWN BY: RIP  
 CHECKED BY: RIP  
 SHEET TITLE:  
**FLOOR PLANS &  
 REFLECTED CEILING PLAN**

**A101**

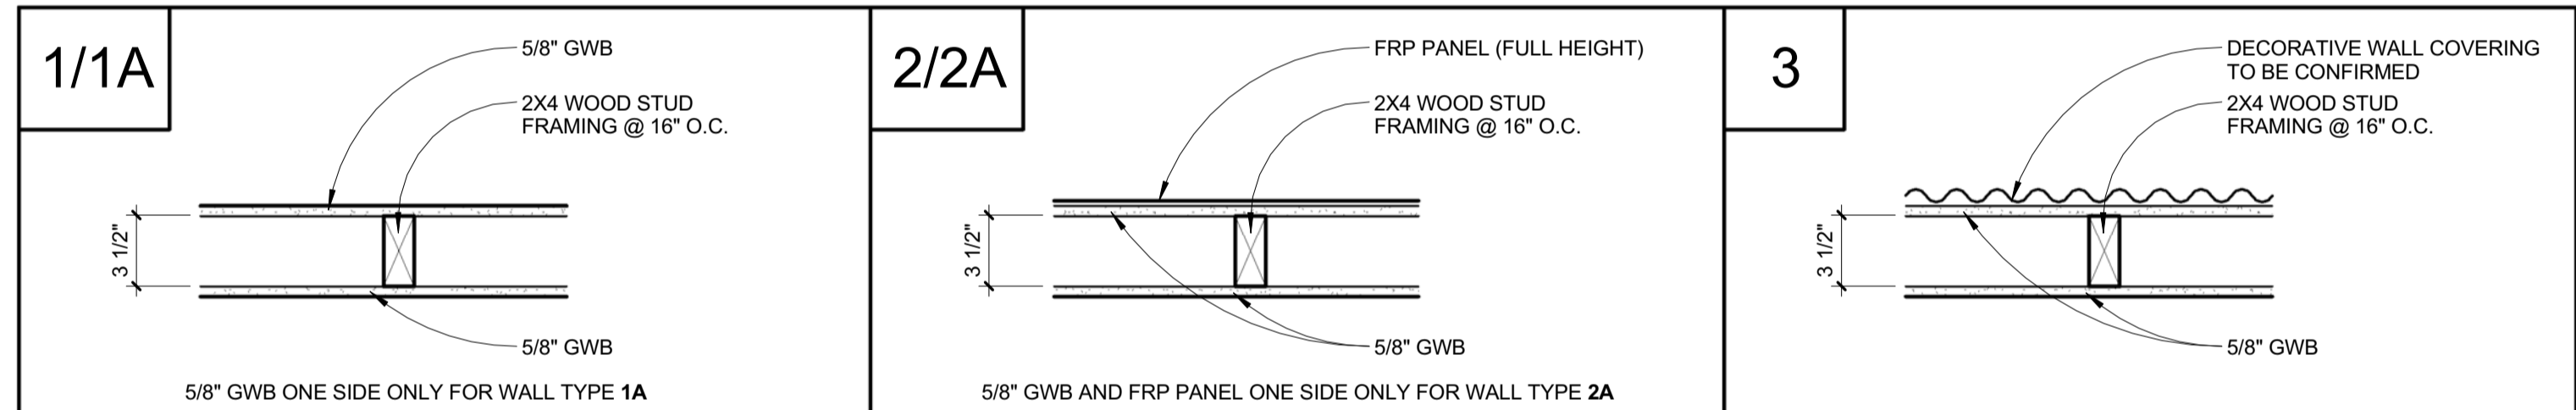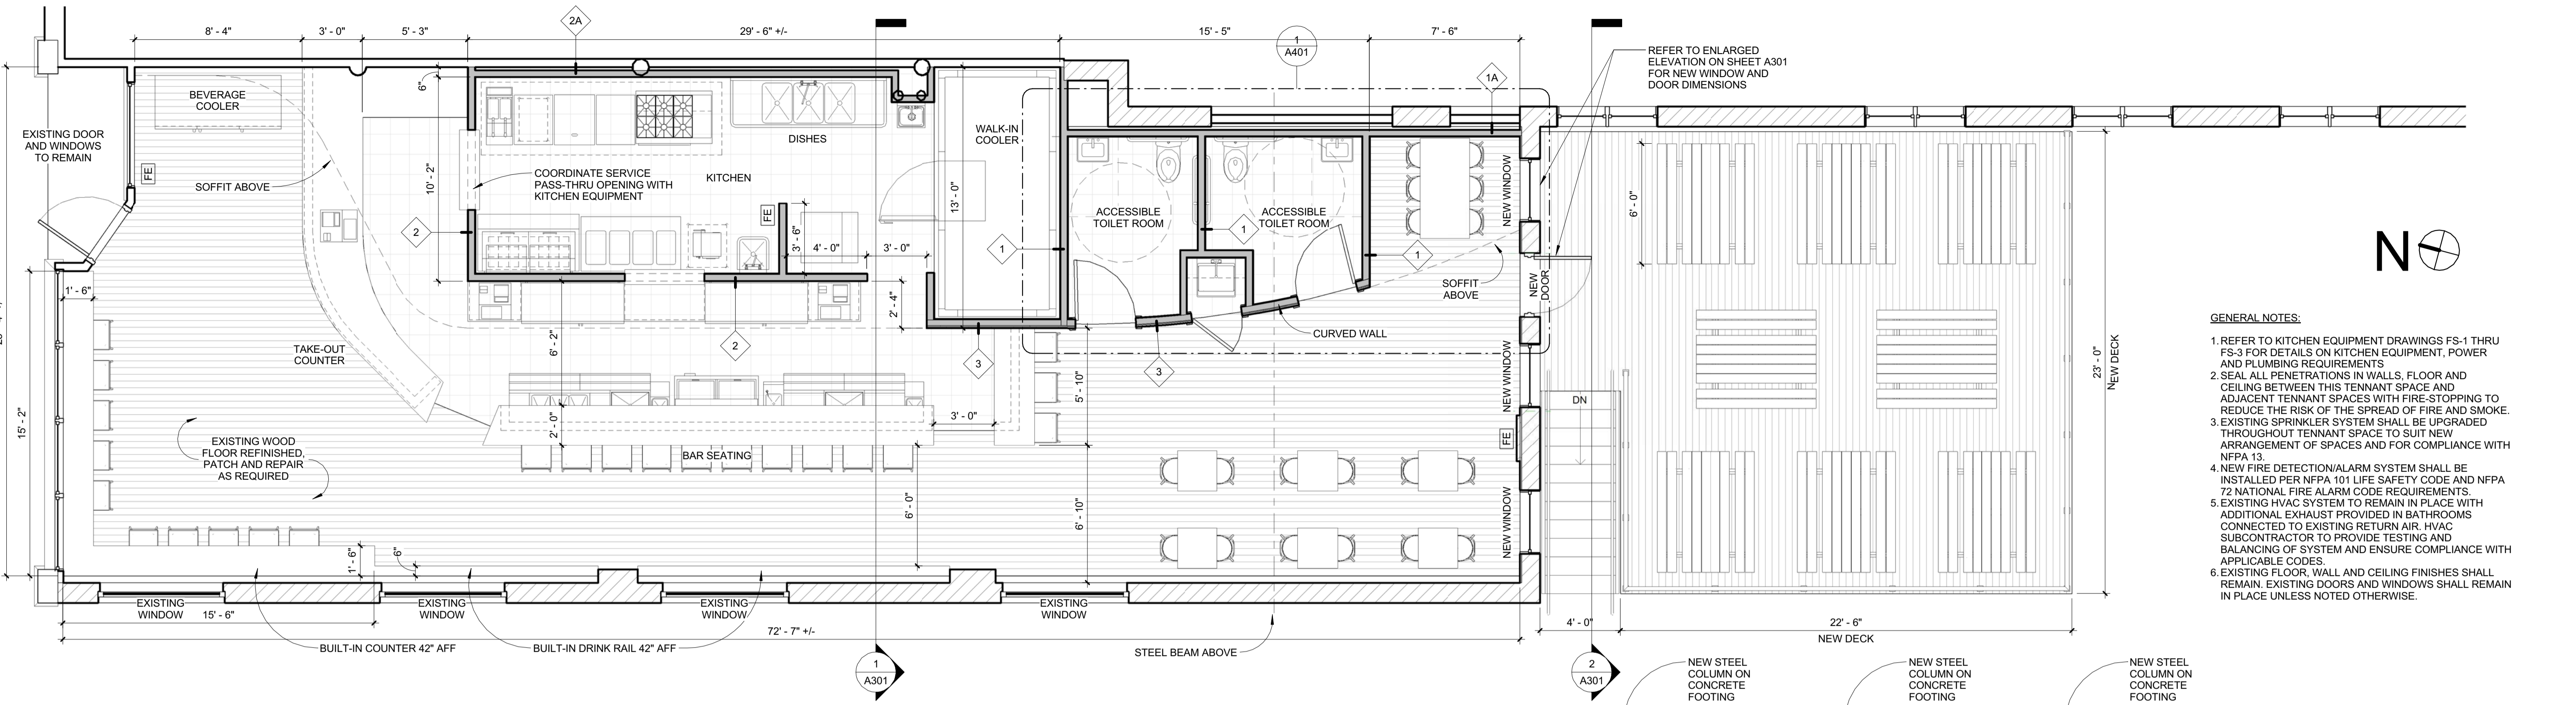

WALL TYPES  
 1 1/2" = 1'-0"

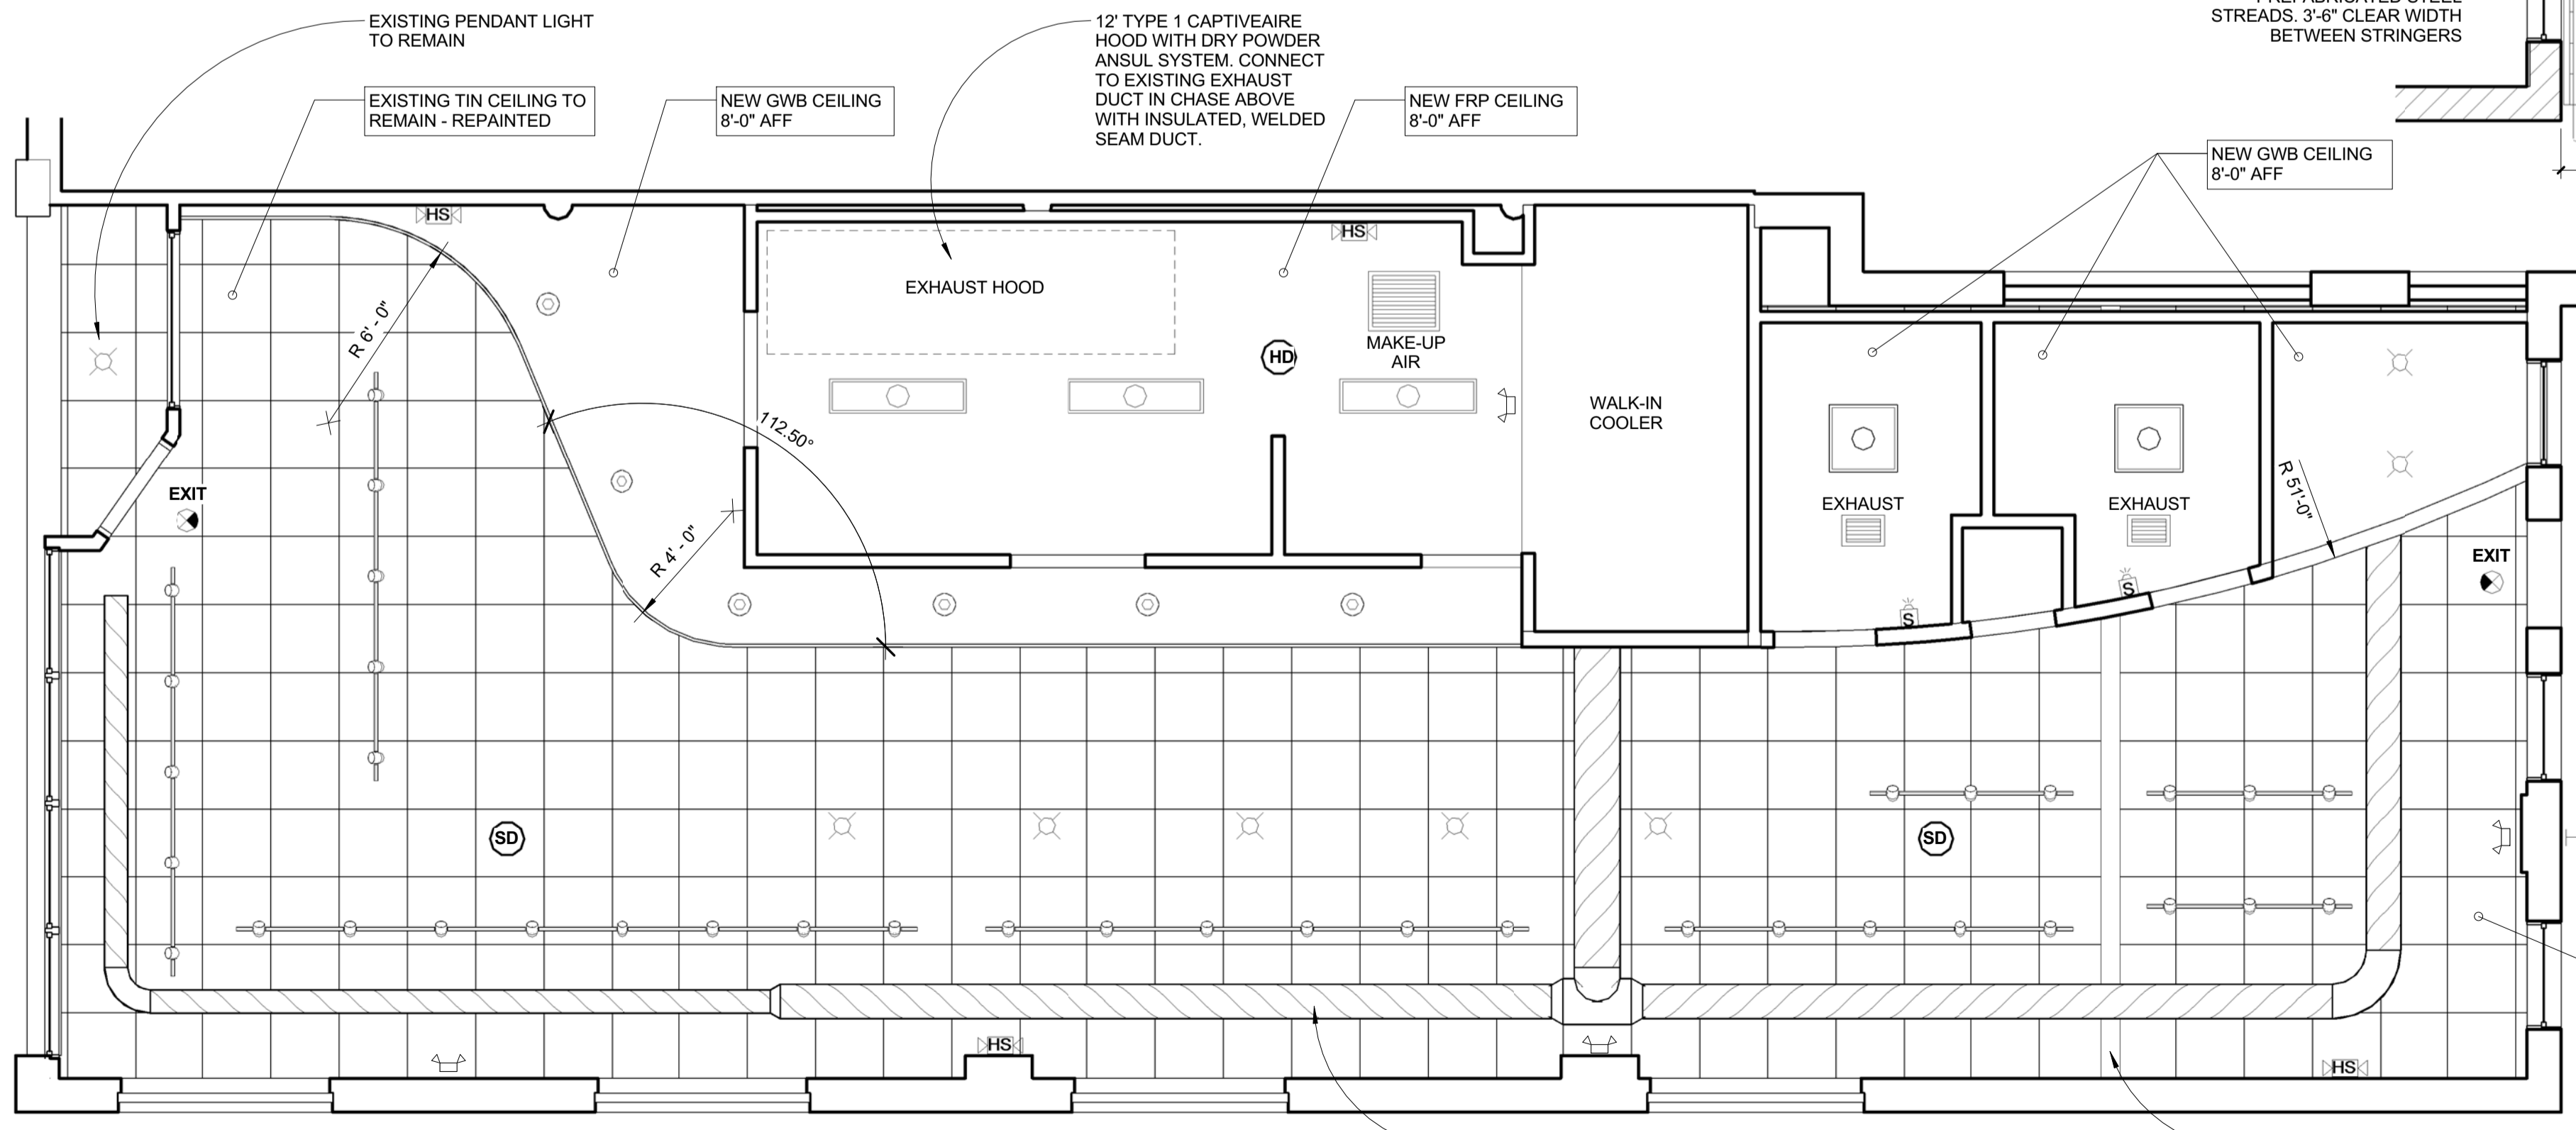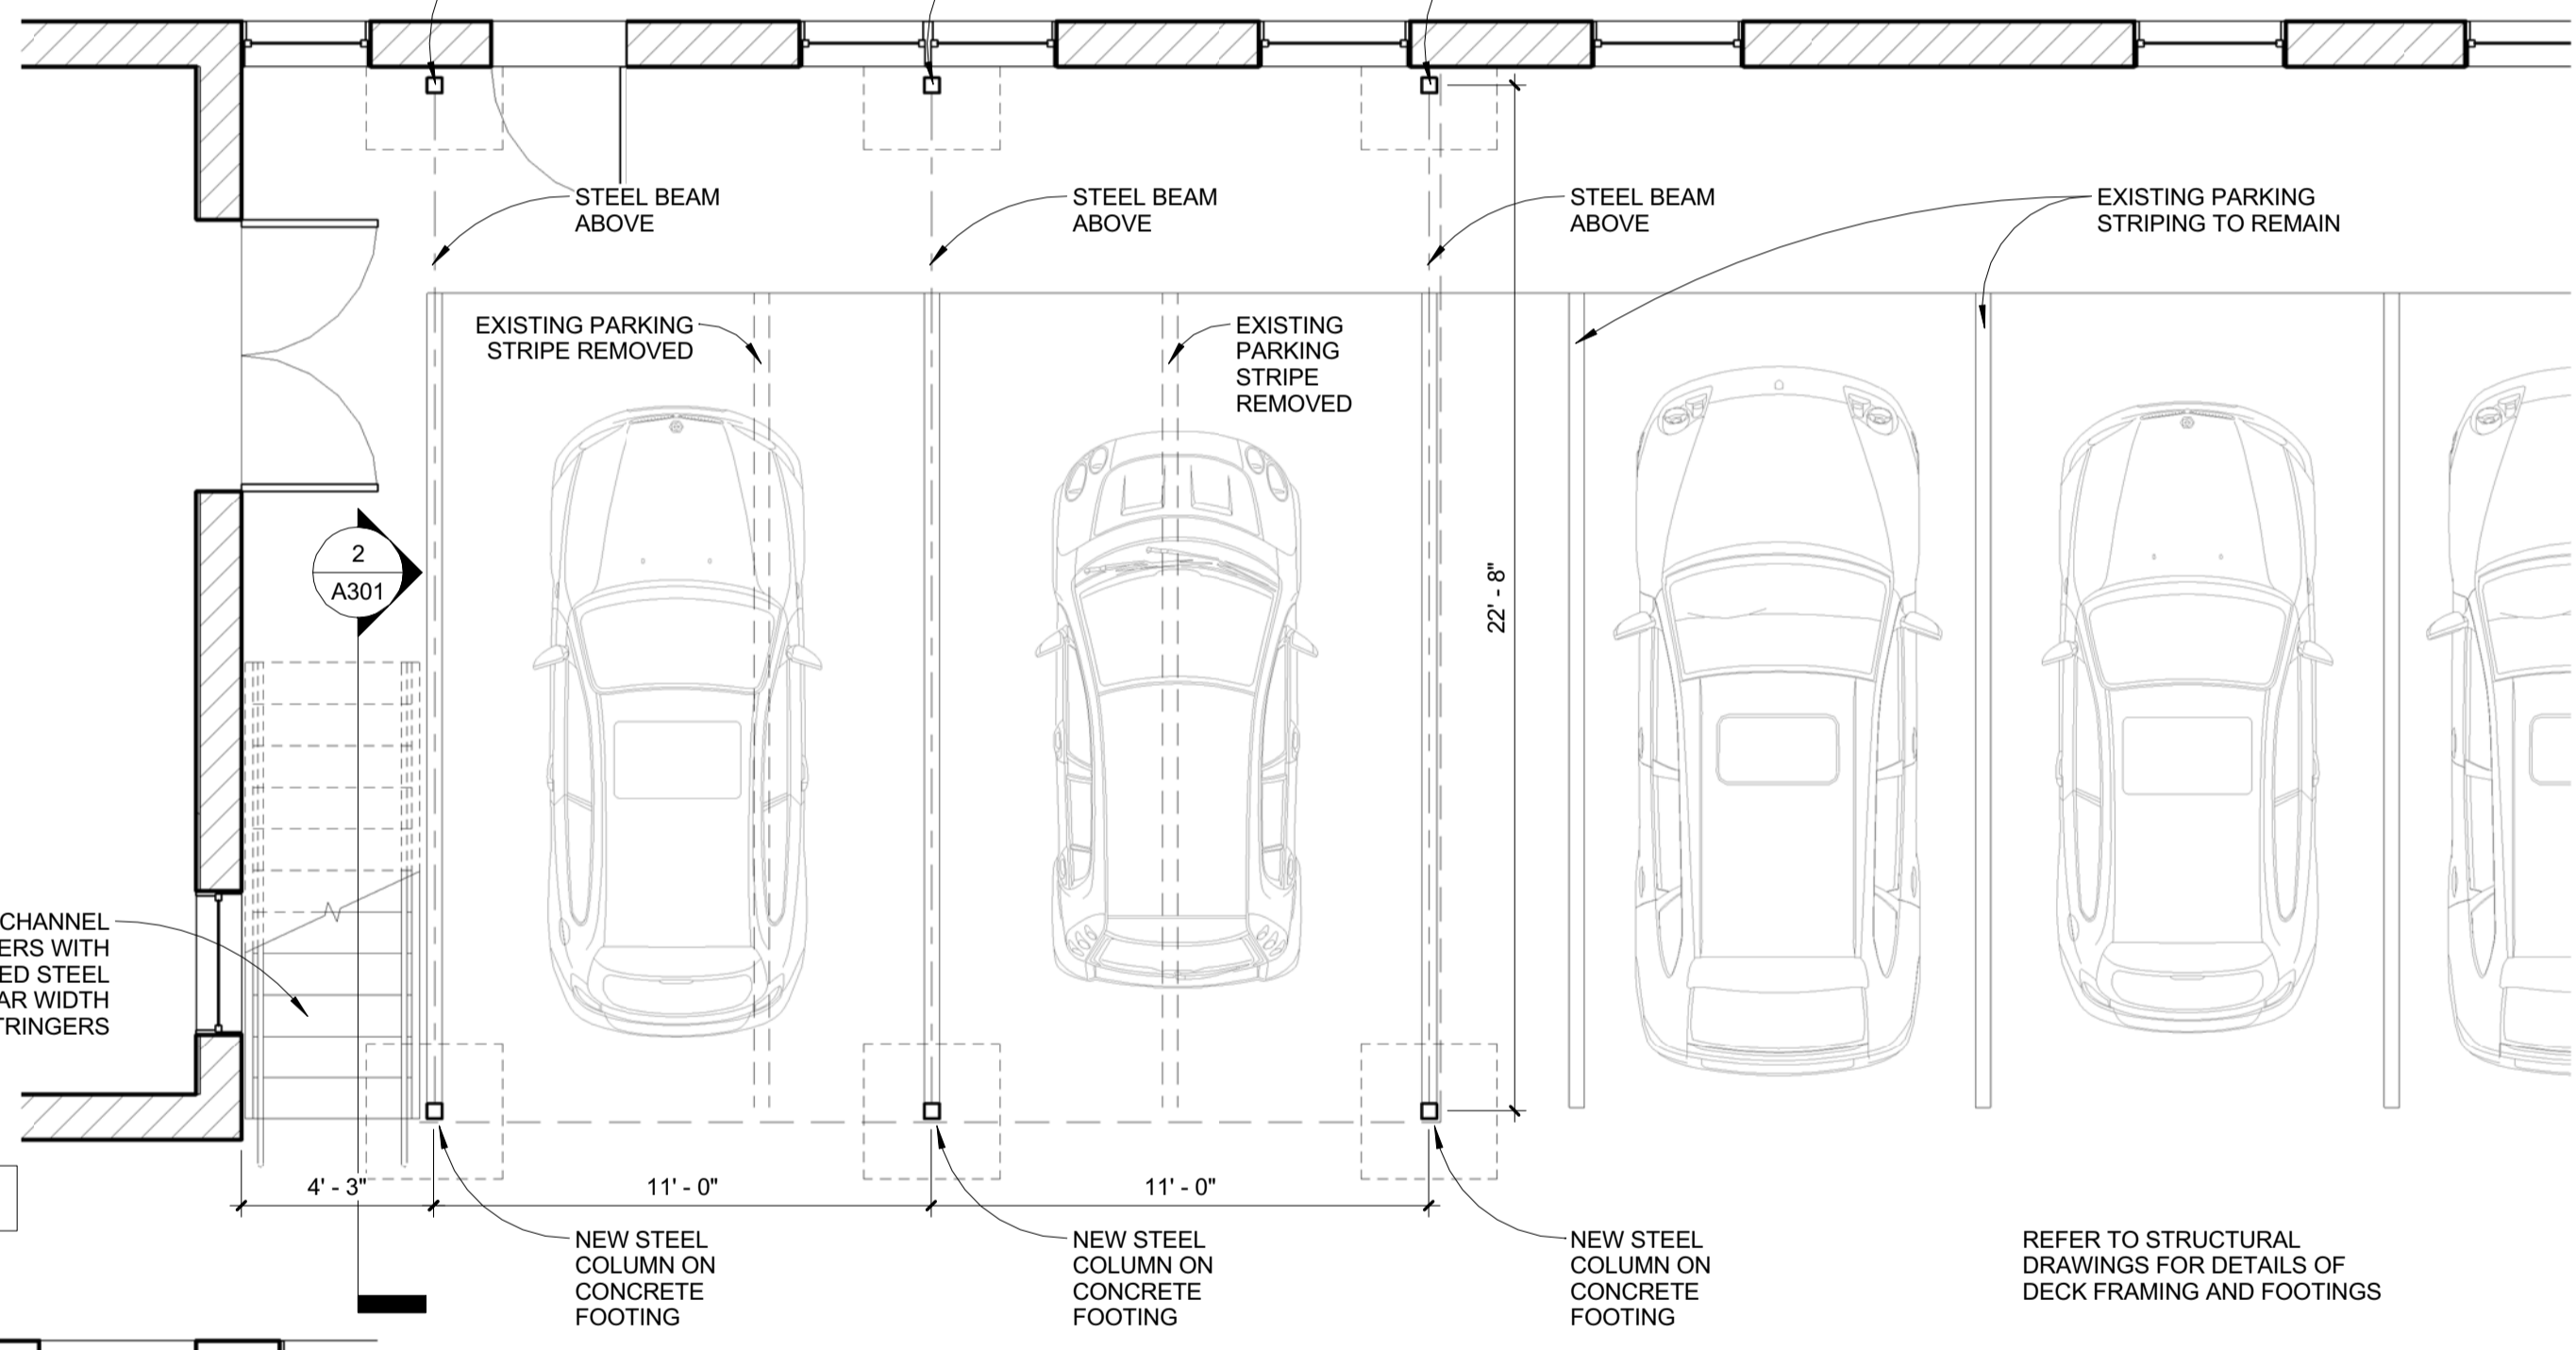

LIGHTING SYMBOL LEGEND			
	SURFACE MOUNTED LIGHT FIXTURE		4' SURFACE MOUNTED FLUORESCENT LIGHT FIXTURE
	RECESSED LIGHT FIXTURE		UNDER-CABINET LIGHT FIXTURE
	WALL MOUNTED LIGHT FIXTURE		PENDANT LIGHT FIXTURE
	EXHAUST FAN/LIGHT		WALL MOUNTED STRIP LIGHT
	GARAGE DOOR OPENER		CEILING FAN/LIGHT
	TRACK LIGHT SYSTEM		COMBINATION HORN/STROBE NOTIFICATION DEVICE
	ILLUMINATED EXIT SIGN		STROBE ONLY NOTIFICATION DEVICE
	EMERGENCY LIGHT PACK		SMOKE / HEAT DETECTOR

LIGHT FIXTURES TO BE SELECTED BY OWNER